
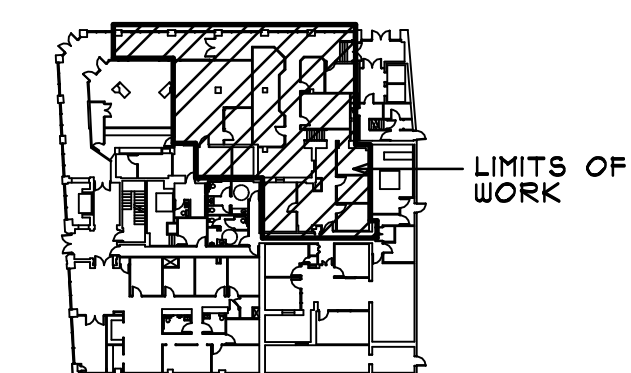


RENOVATIONS
FOR
**COULTER OFFICE
BUILDING**
601 S. JEFFERSON ST
ROANOKE, VA.

△	_____	_____
△	- _____	- _____
△	- _____	- _____
△	- _____	- _____
△	- _____	- _____

REVISIONS DATE

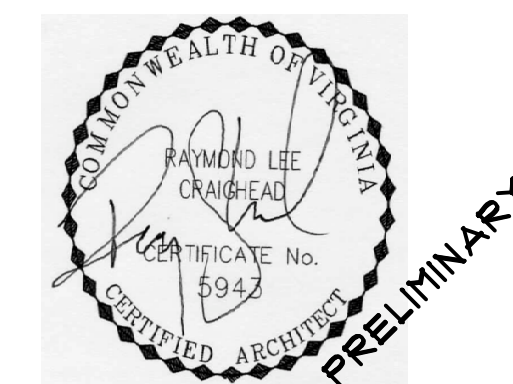

KEY PLAN


INTERIOR ALTERATIONS FOR
**WESTERN VIRGINIA
WATER AUTHORITY**

PROJECT NO: 2017043
DATE: 06/15/2017
DRAWN BY: RLC
CHECKED BY: RLC

APPROVED FOR THE CONTRACTOR DATE

APPROVED FOR THE OWNER DATE

P-1
PLUMBING FLOOR PLAN
SCALE: 1/4"= 1'-0"
GRAPHIC:

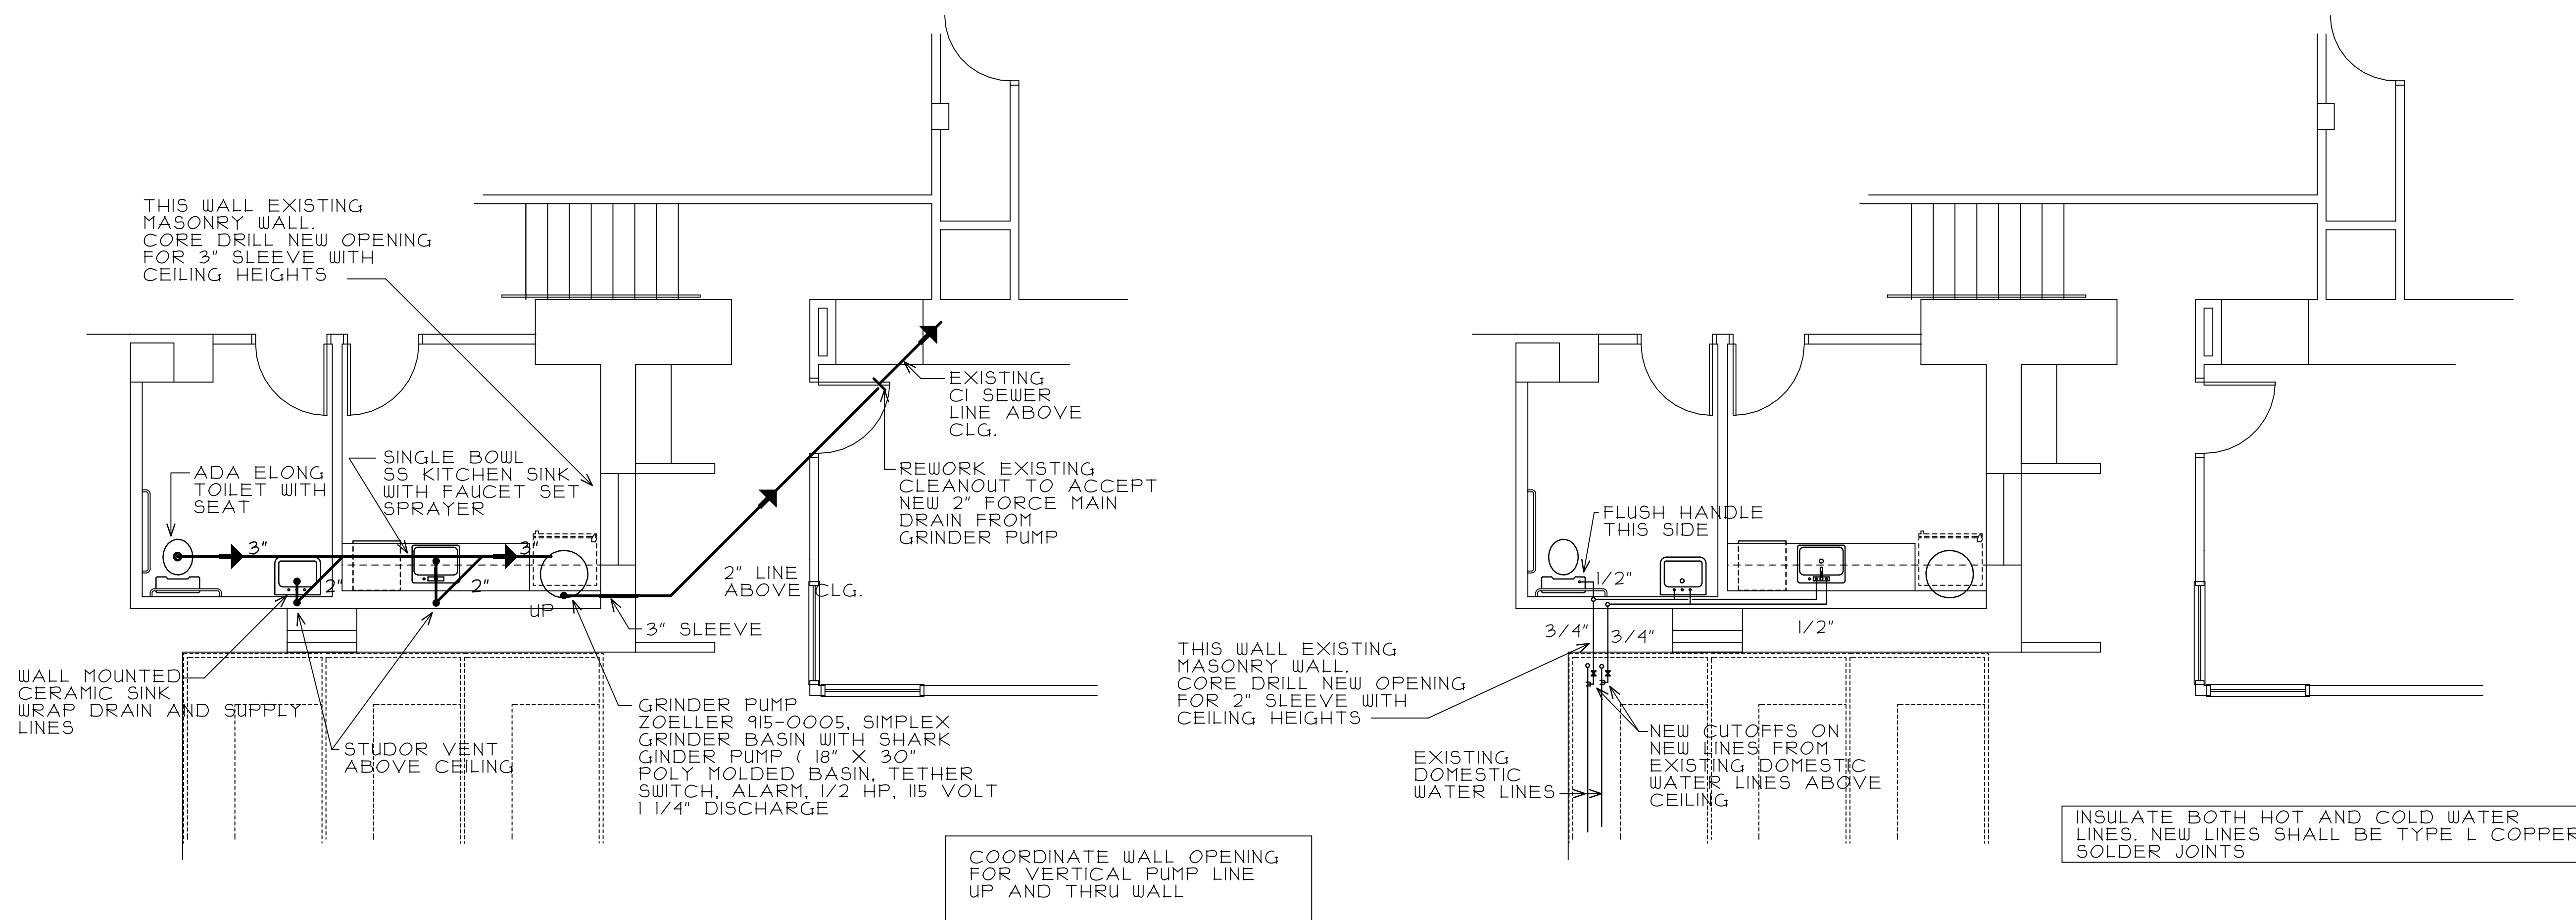

SANITARY SEWER PLAN

SCALE: 1/4" = 1'-0"

GROUND LEVEL ENTRY, LOWER LEVEL PLAN

COORDINATE WITH OWNER FOR INTERRUPTION TAP FOR NEW FORCE
MAIN CONNECTION TO LIMIT IMPACT ON OWNER AND EMPLOYEES.

DOMESTIC WATER PLAN

SCALE: 1/4" = 1'-0"

GROUND LEVEL ENTRY, LOWER LEVEL PLAN

COORDINATE WITH OWNER FOR INTERRUPTION TAP FOR NEW WATER
LINE CONNECTION TO LIMIT IMPACT ON OWNER AND EMPLOYEES.