


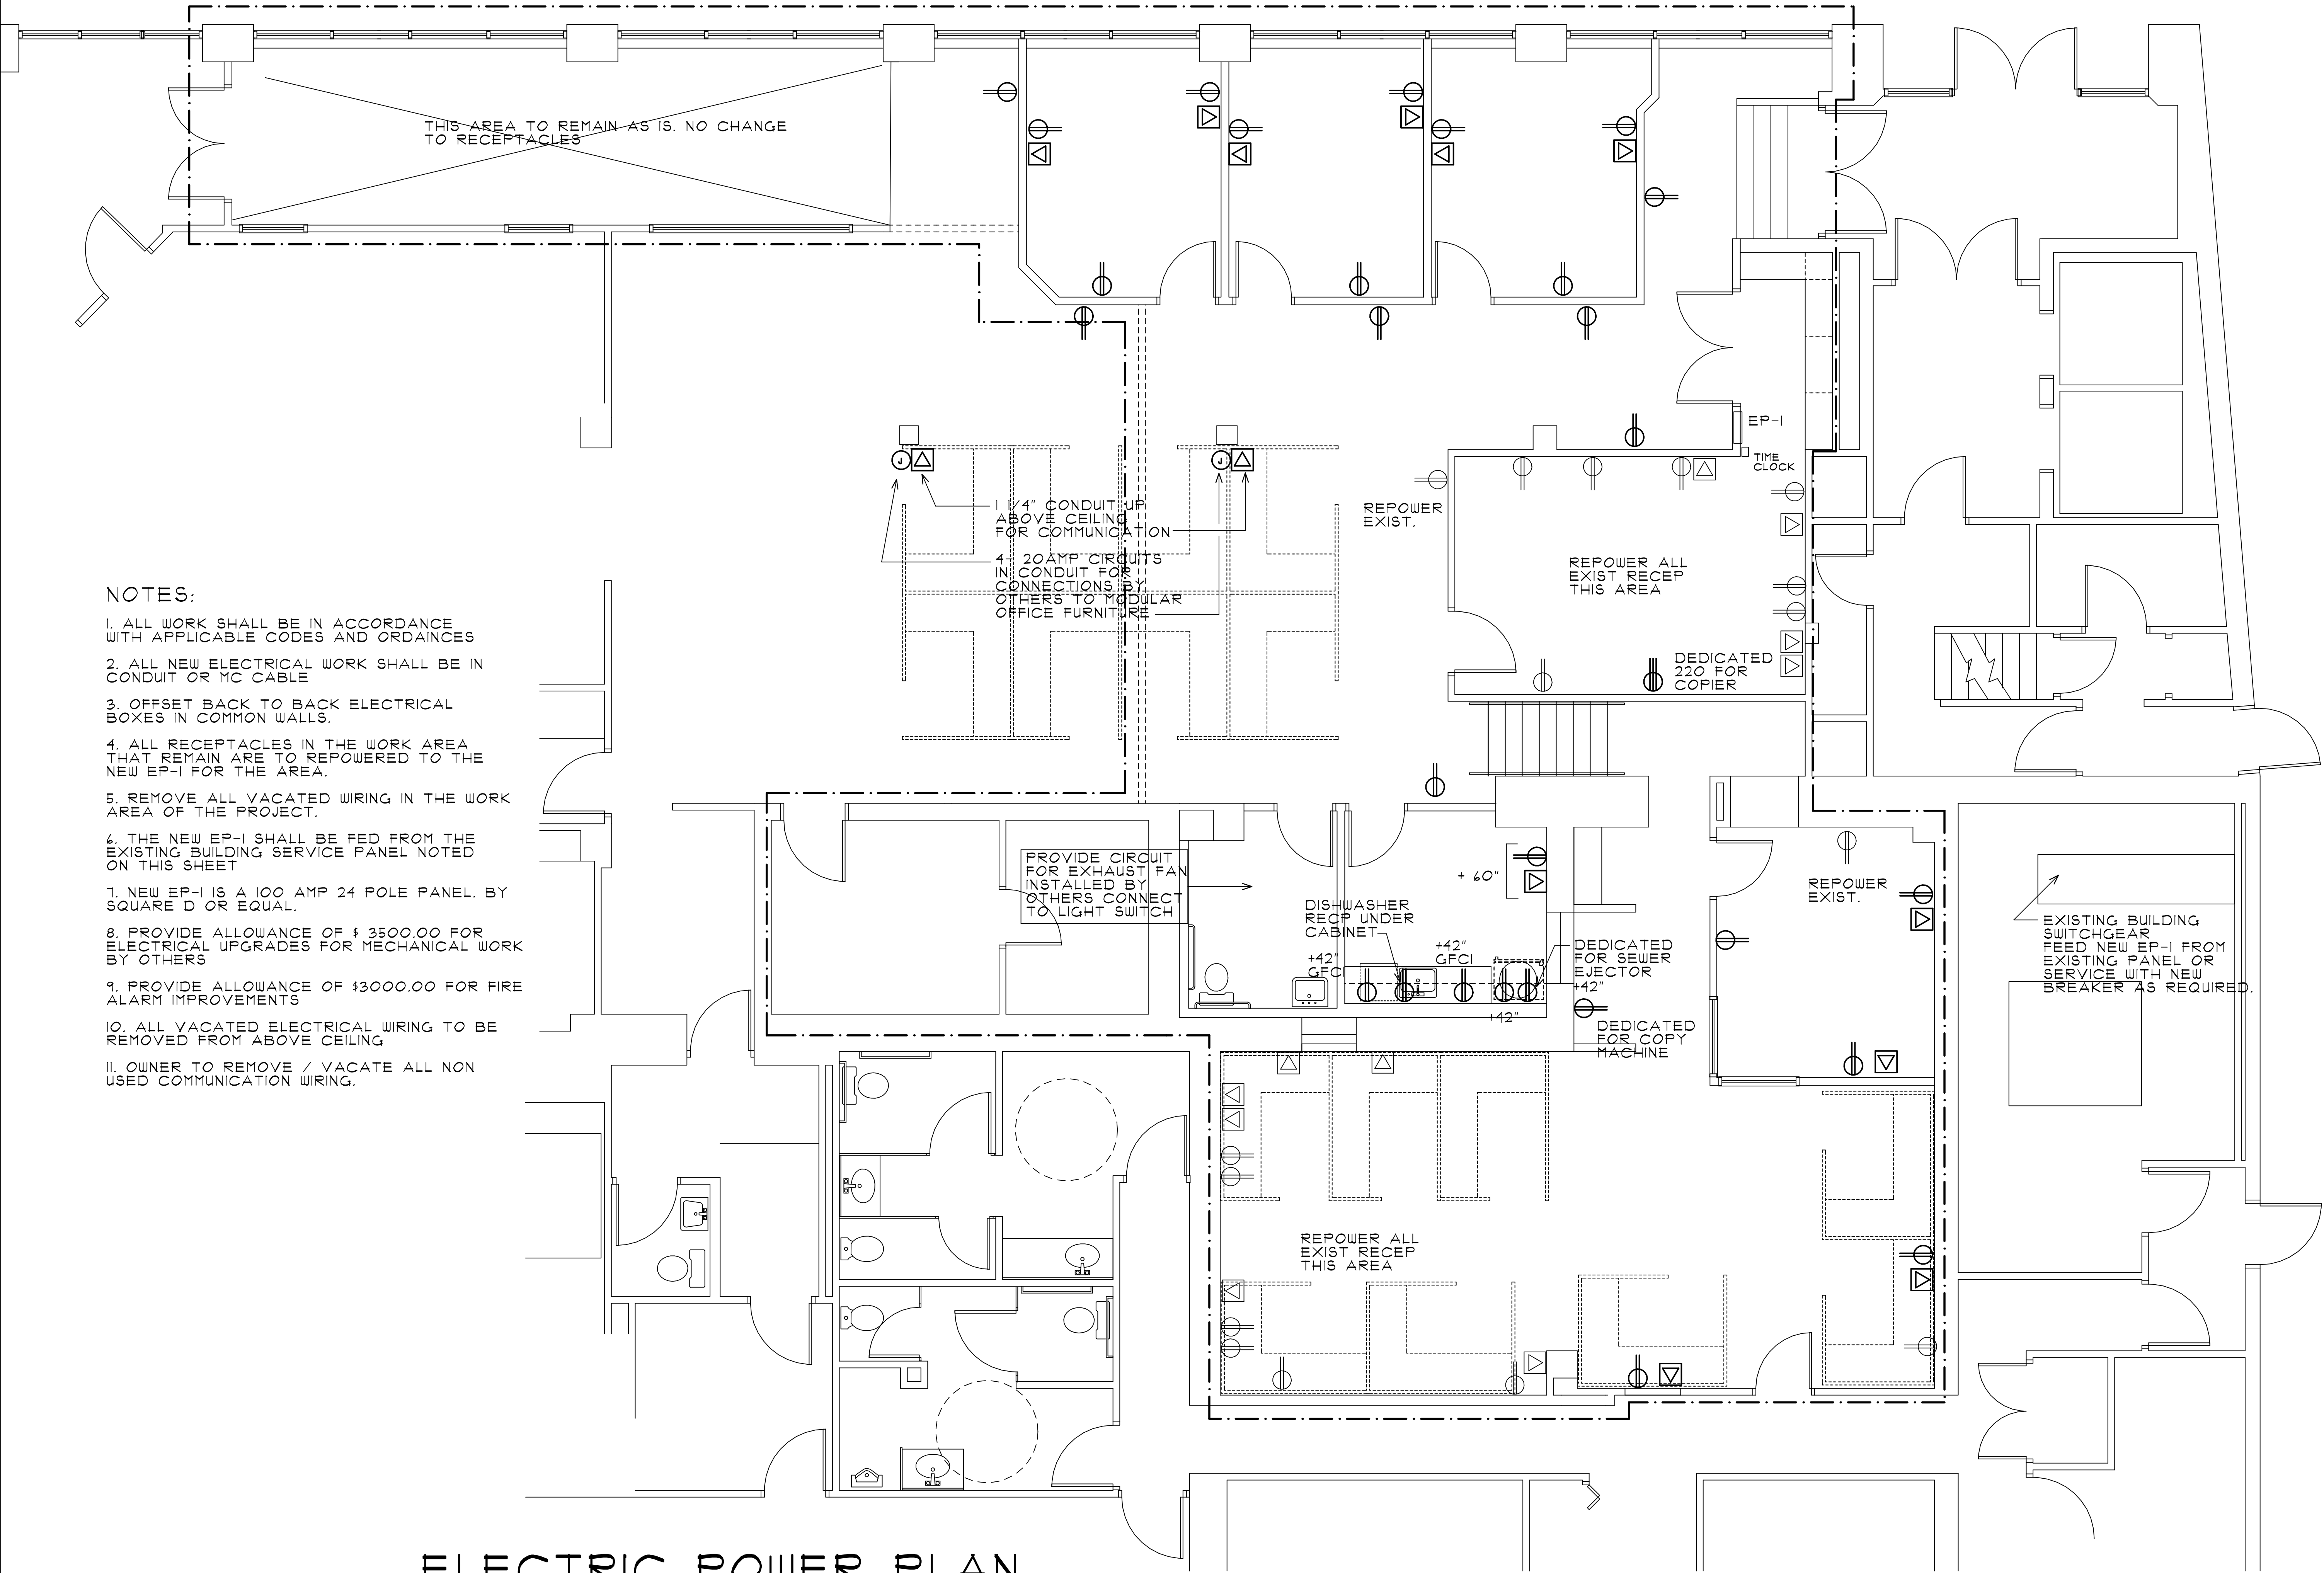

NOTES:

- 1. ALL WORK SHALL BE IN ACCORDANCE WITH APPLICABLE CODES AND ORDINANCES
- 2. ALL NEW ELECTRICAL WORK SHALL BE IN CONDUIT OR MC CABLE
- 3. OFFSET BACK TO BACK ELECTRICAL BOXES IN COMMON WALLS.
- 4. ALL RECEPTACLES IN THE WORK AREA THAT REMAIN ARE TO REPOWERED TO THE NEW EP-1 FOR THE AREA.
- 5. REMOVE ALL VACATED WIRING IN THE WORK AREA OF THE PROJECT.
- 6. THE NEW EP-1 SHALL BE FED FROM THE EXISTING BUILDING SERVICE PANEL NOTED ON THIS SHEET
- 7. NEW EP-1 IS A 100 AMP 24 POLE PANEL. BY SQUARE D OR EQUAL.
- 8. PROVIDE ALLOWANCE OF \$ 3500.00 FOR ELECTRICAL UPGRADES FOR MECHANICAL WORK BY OTHERS
- 9. PROVIDE ALLOWANCE OF \$3000.00 FOR FIRE ALARM IMPROVEMENTS
- 10. ALL VACATED ELECTRICAL WIRING TO BE REMOVED FROM ABOVE CEILING
- 11. OWNER TO REMOVE / VACATE ALL NON USED COMMUNICATION WIRING.

ELECTRIC POWER PLAN

SCALE: 1/16" = 1'-0"


4,211 SF

GROUND LEVEL ENTRY, LOWER LEVEL PLAN

RENOVATIONS
FOR
COULTER OFFICE
BUILDING
401 S. JEFFERSON ST
ROANOKE, VA.

△	_____	_____
△	_____	_____
△	_____	_____
△	_____	_____
△	_____	_____

REVISIONS DATE

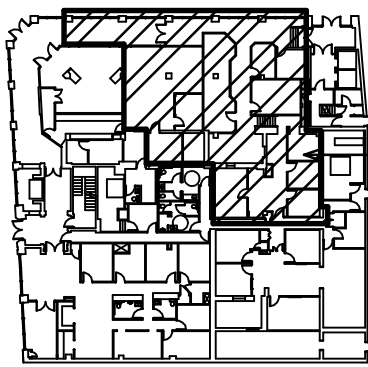

KEY PLAN

INTERIOR ALTERATIONS FOR
WESTERN VIRGINIA
WATER AUTHORITY

PROJECT NO: 2017043
DATE: 04/15/2017
DRAWN BY: RLC
CHECKED BY: RLC

APPROVED FOR THE CONTRACTOR DATE

APPROVED FOR THE OWNER DATE

E-2
ELECTRICAL POWER PLAN
SCALE: 1/4"= 1'-0"
GRAPHIC: