


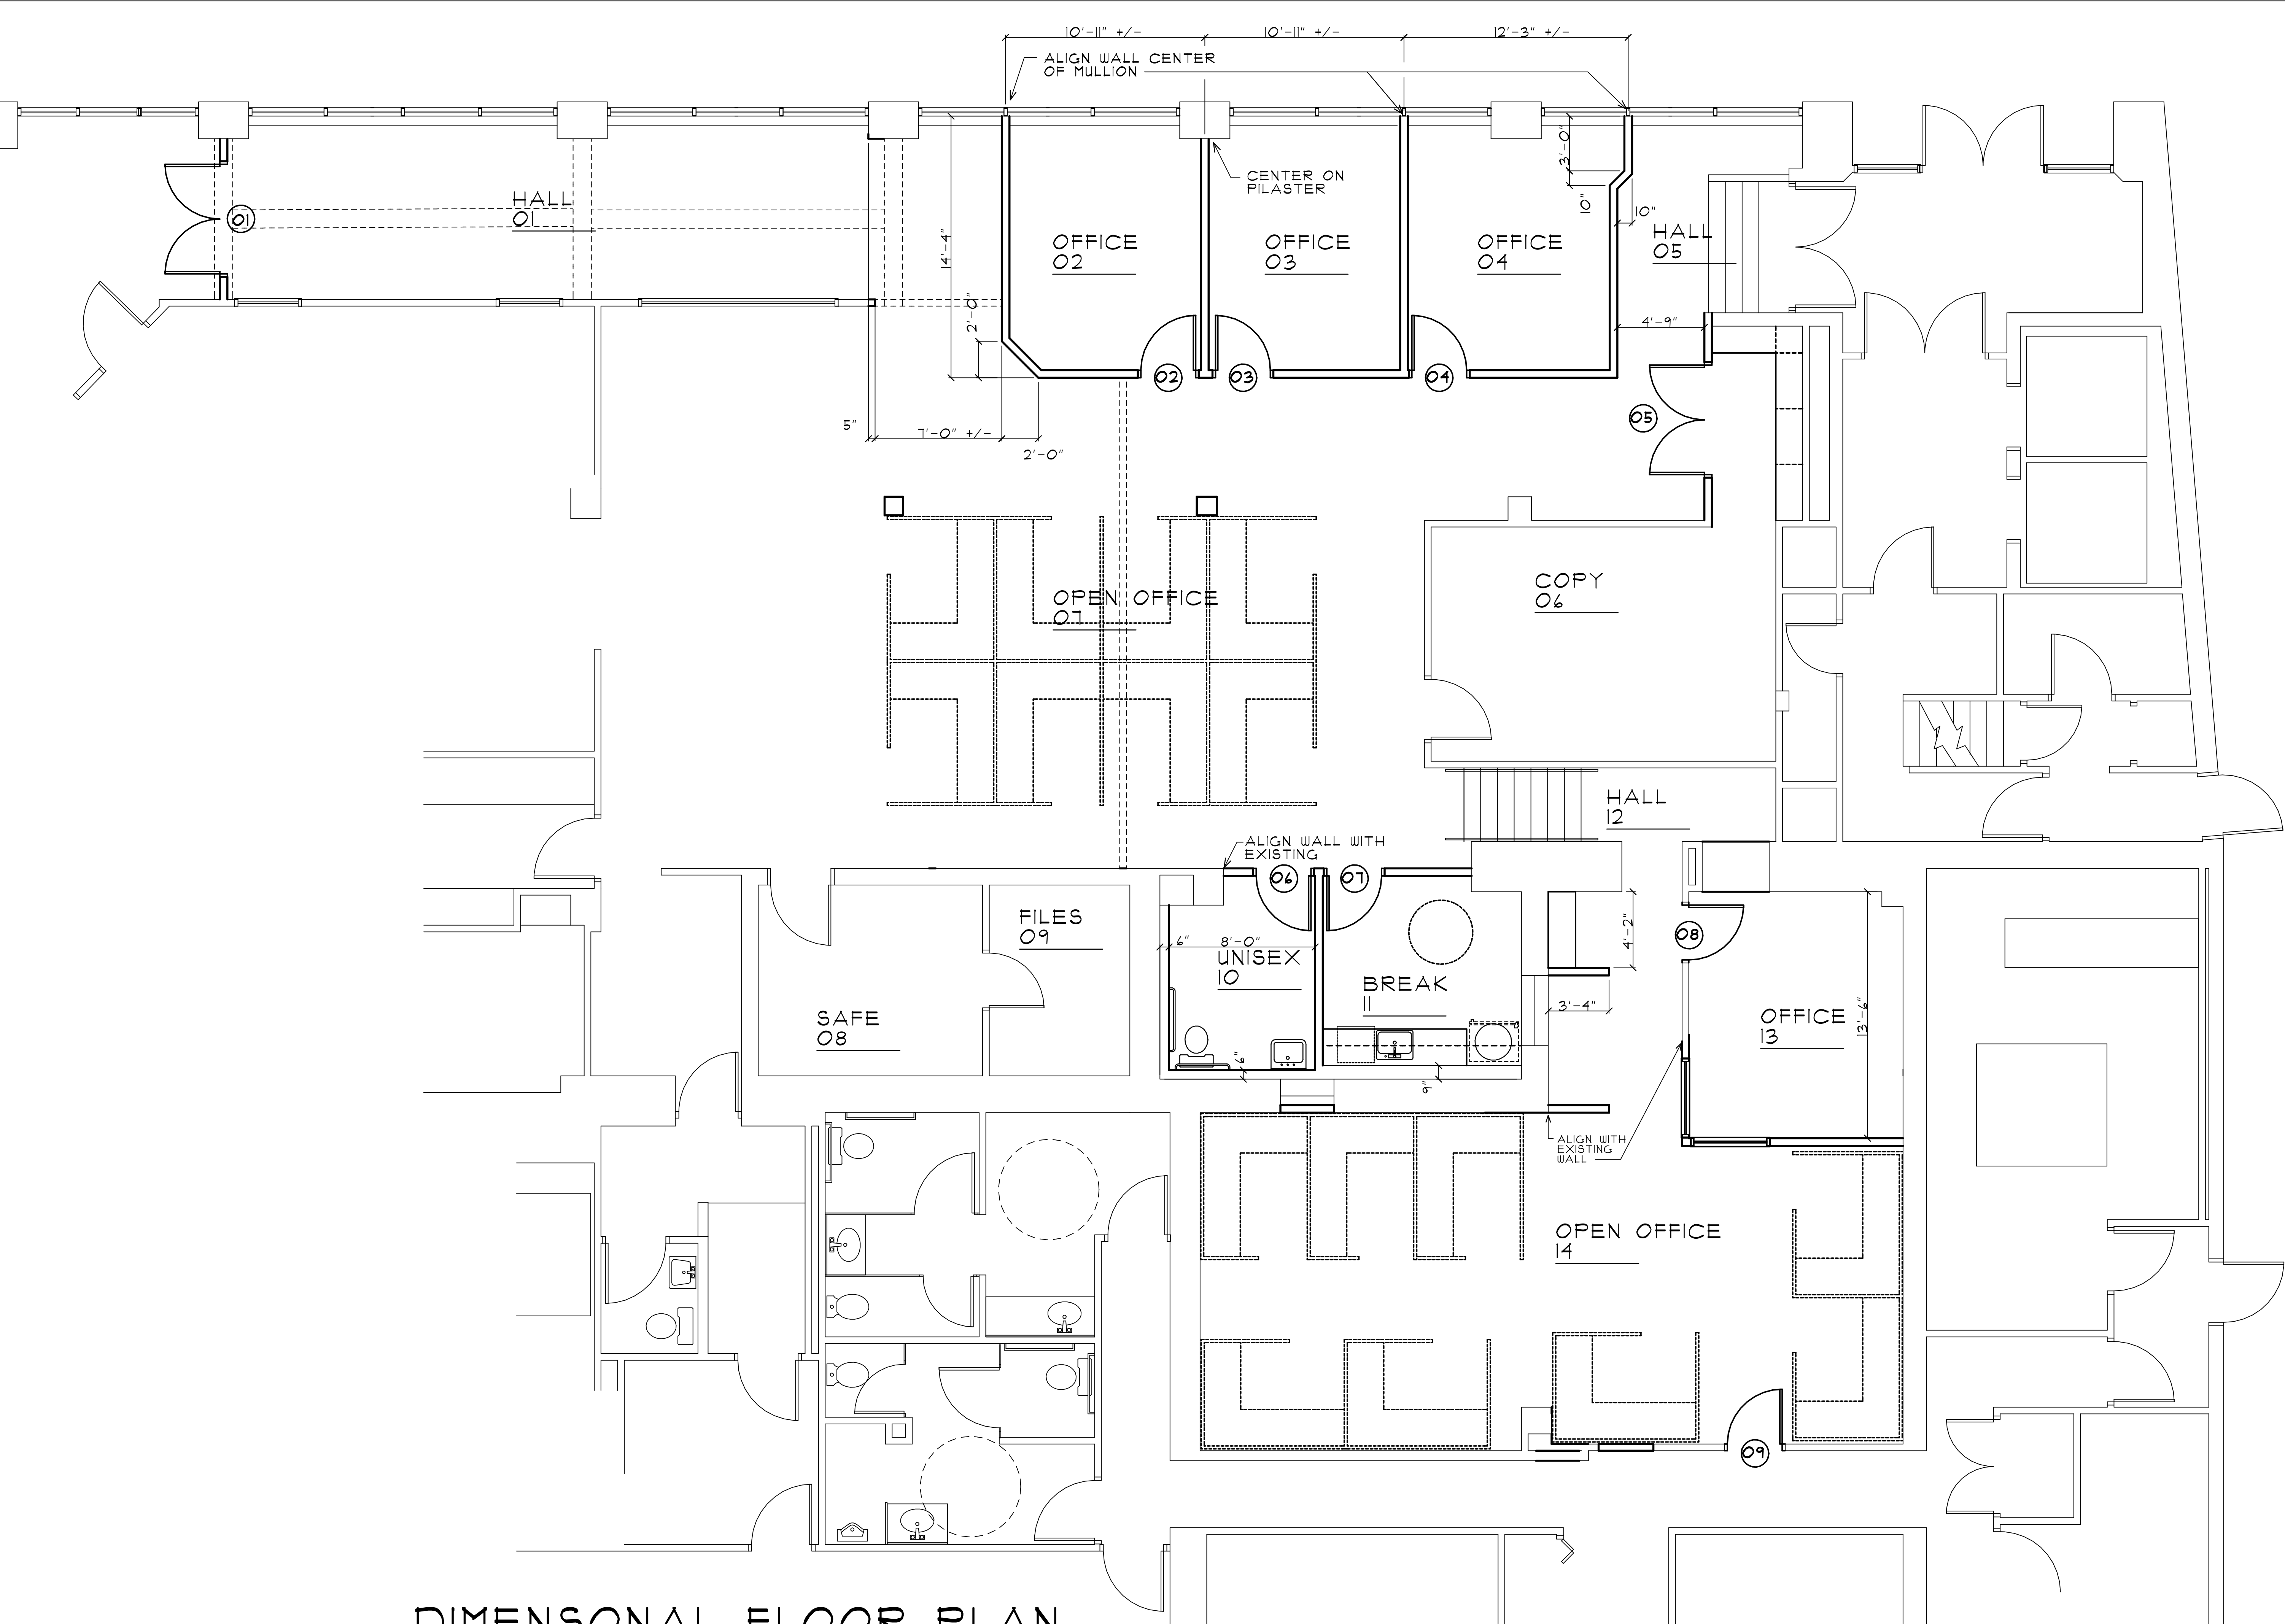

DIMENSIONAL FLOOR PLAN

SCALE: 1/16" = 1'-0"



4,211 SF

GROUND LEVEL ENTRY, LOWER LEVEL PLAN
TAX ID # 1013301, WESTERN VIRGINIA WATER AUTHORITY, OWNER

RENOVATIONS
FOR
**COULTER OFFICE
BUILDING**
401 S. JEFFERSON ST
ROANOKE, VA.

△	_____	_____
△	- _____	- _____
△	- _____	- _____
△	- _____	- _____
△	- _____	- _____

REVISIONS DATE

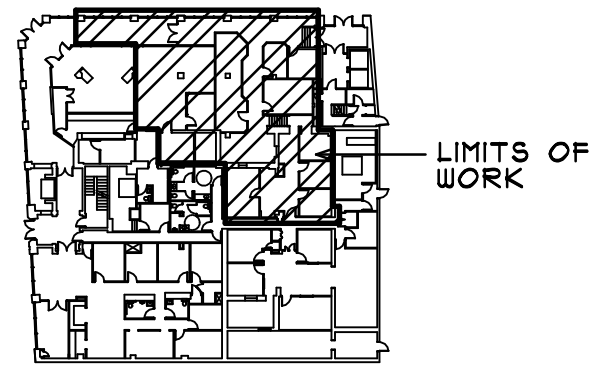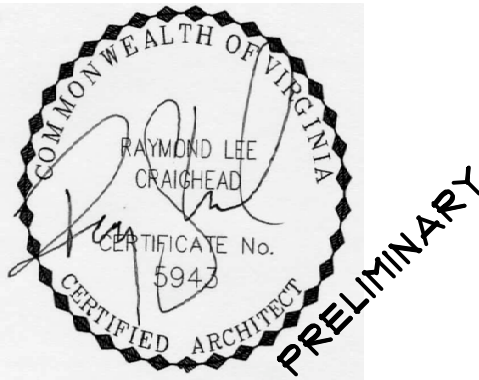

KEY PLAN

INTERIOR ALTERATIONS FOR
**WESTERN VIRGINIA
WATER AUTHORITY**

PROJECT NO: 2011043
DATE: 04/15/2011
DRAWN BY: RLC
CHECKED BY: RLC

APPROVED FOR THE CONTRACTOR DATE

APPROVED FOR THE OWNER DATE

A-2
DIMENSIONAL FLOOR PLAN
SCALE: 1/4"= 1'-0"
GRAPHIC: