


△ _____

△ - _____ - _____

△ - _____ - _____

△ - _____ - _____

△ - _____ - _____

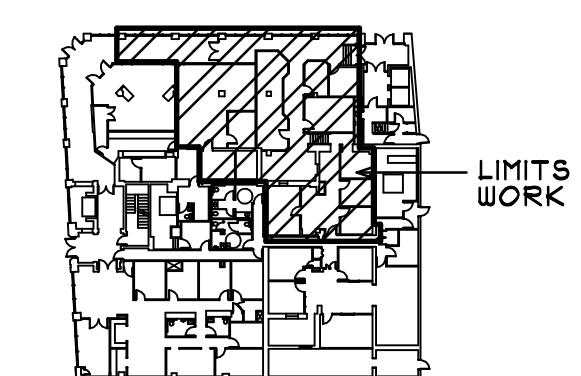[illegible]

KEY PLAN

INTERIOR ALTERATIONS FOR
WESTERN VIRGINIA
WATER AUTHORITY


PROJECT NO: 2017043
DATE: 06/15/2017
DRAWN BY: RLC
CHECKED BY: RLC

APPROVED FOR THE CONTRACTOR DATE

APPROVED FOR THE OWNER _____ DATE _____

A-3
NEW FLOOR PLAN
SCALE: 1/4" = 1'-0"

GRAPHIC:

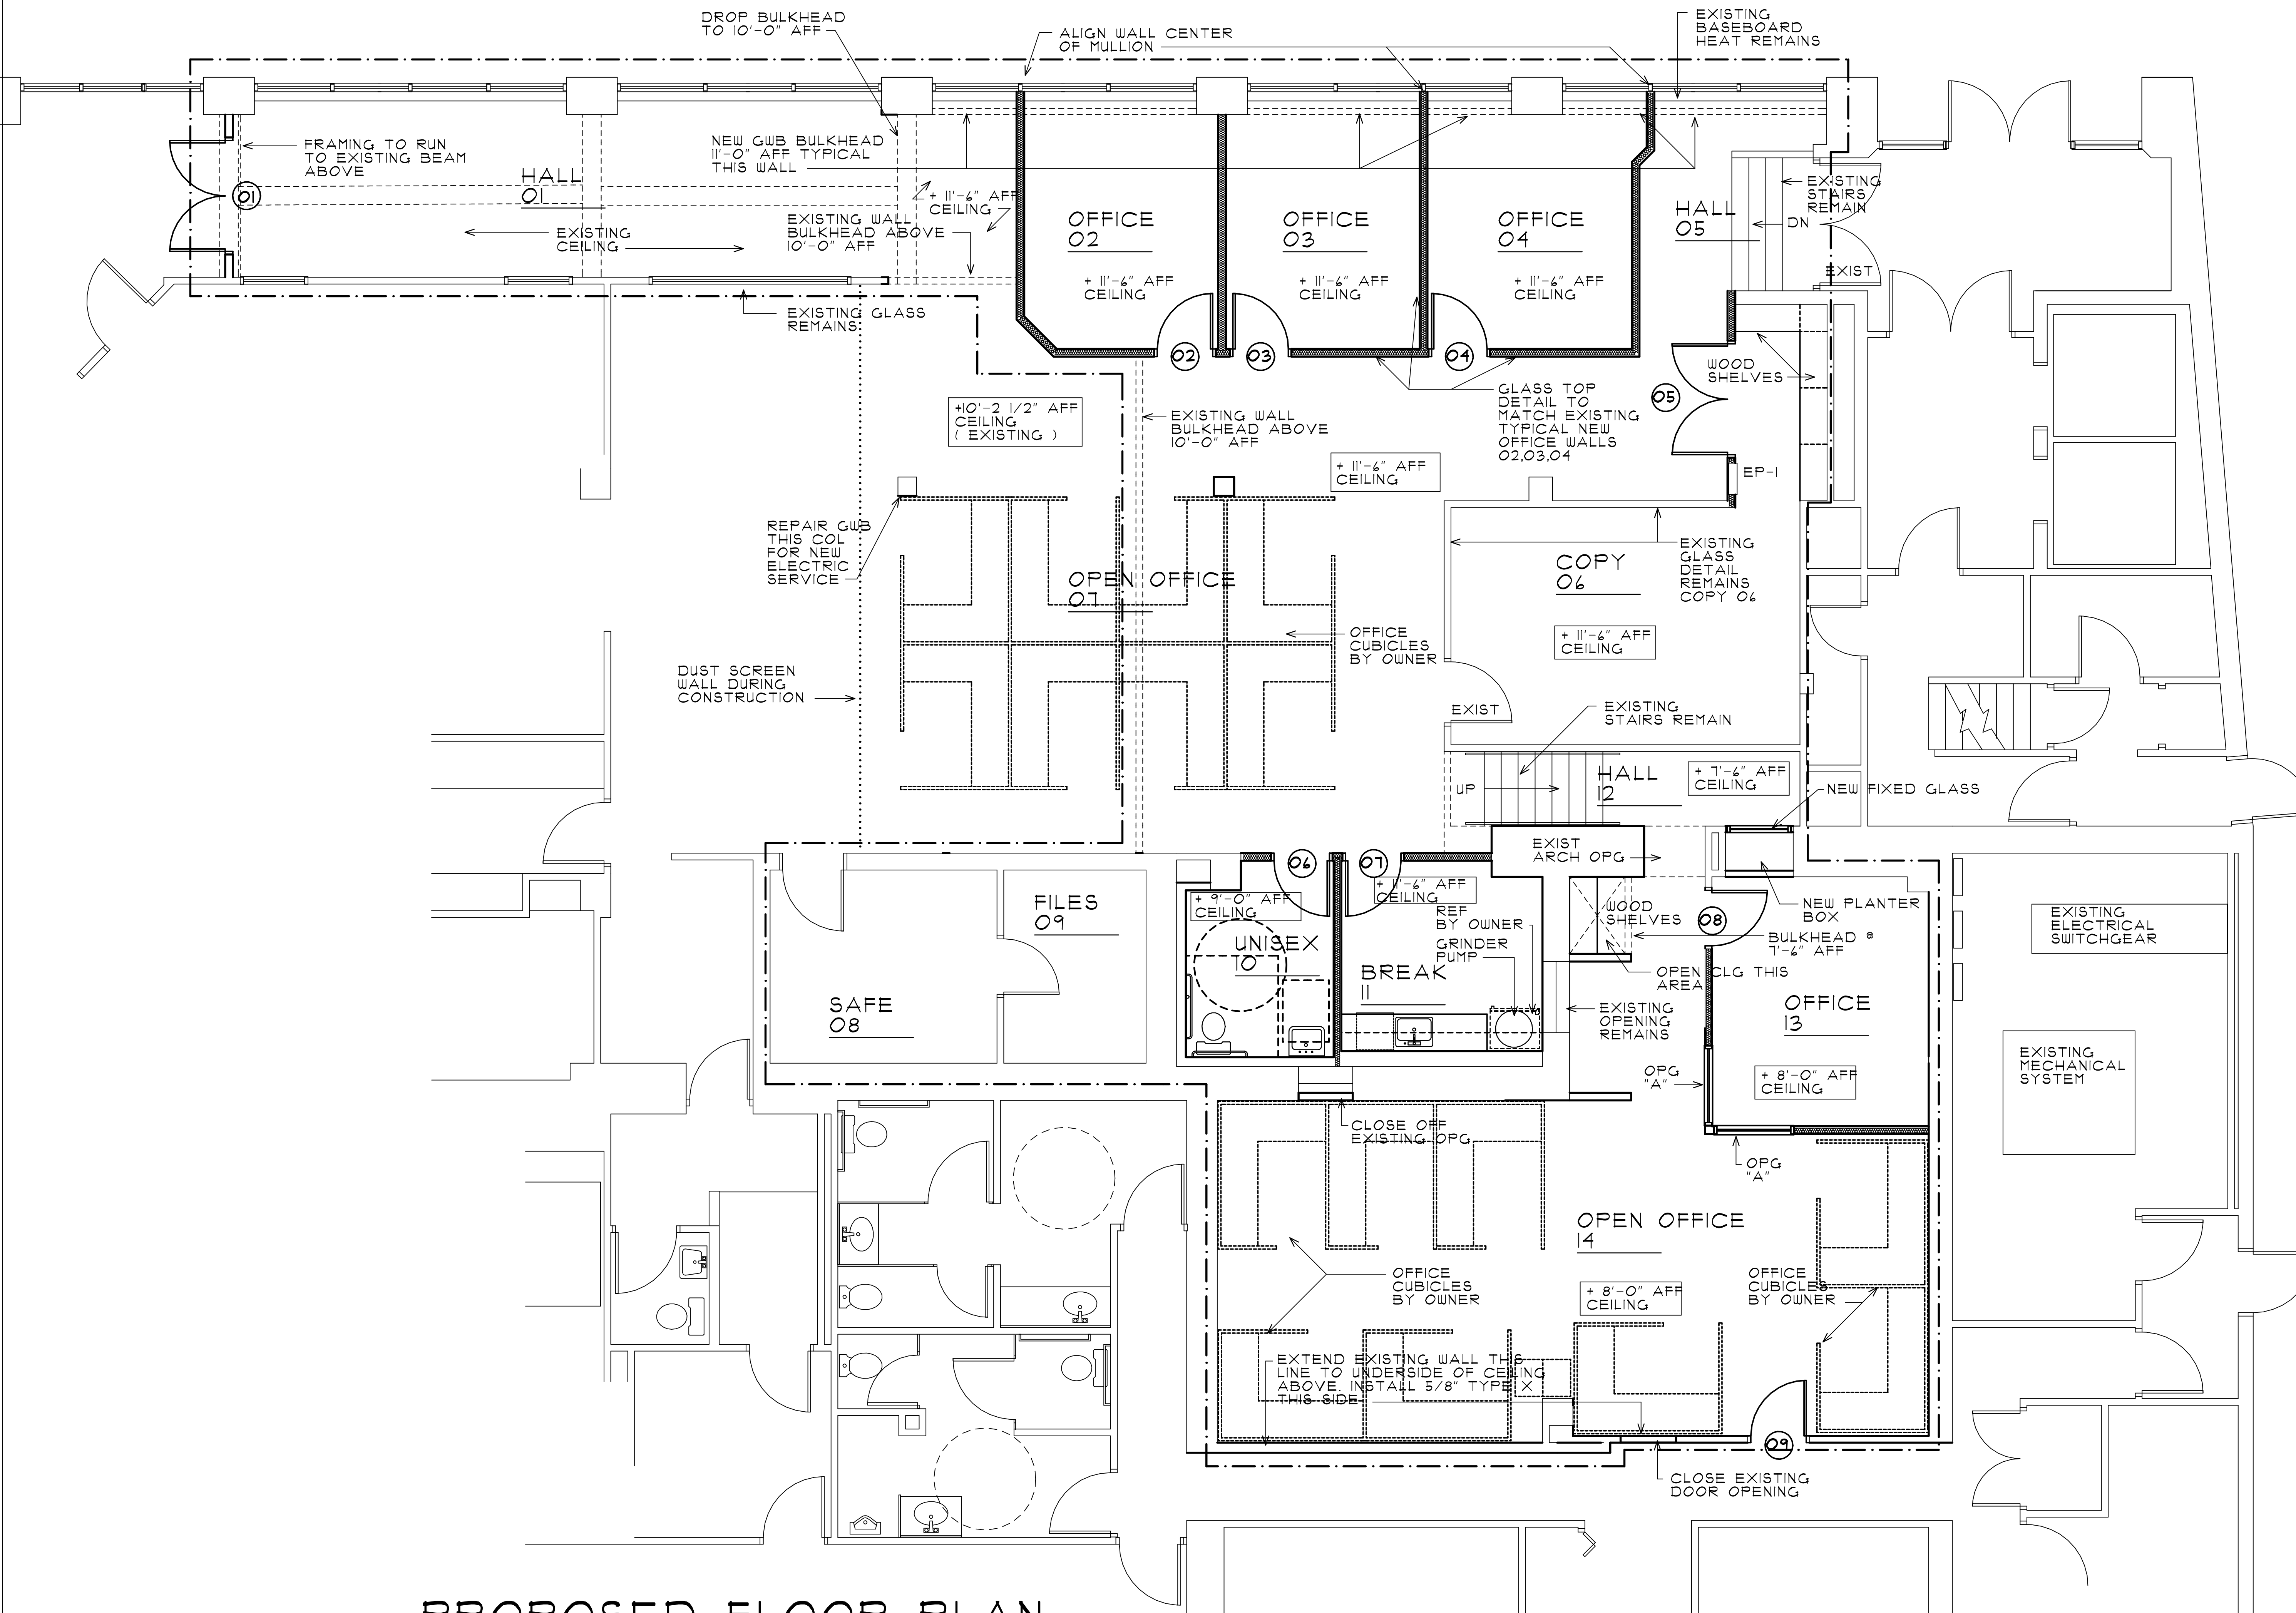

PROPOSED FLOOR PLAN

SCALE: 1/16" = 1'-0"

4,211 SF

GROUND LEVEL ENTRY, LOWER LEVEL PLAN