


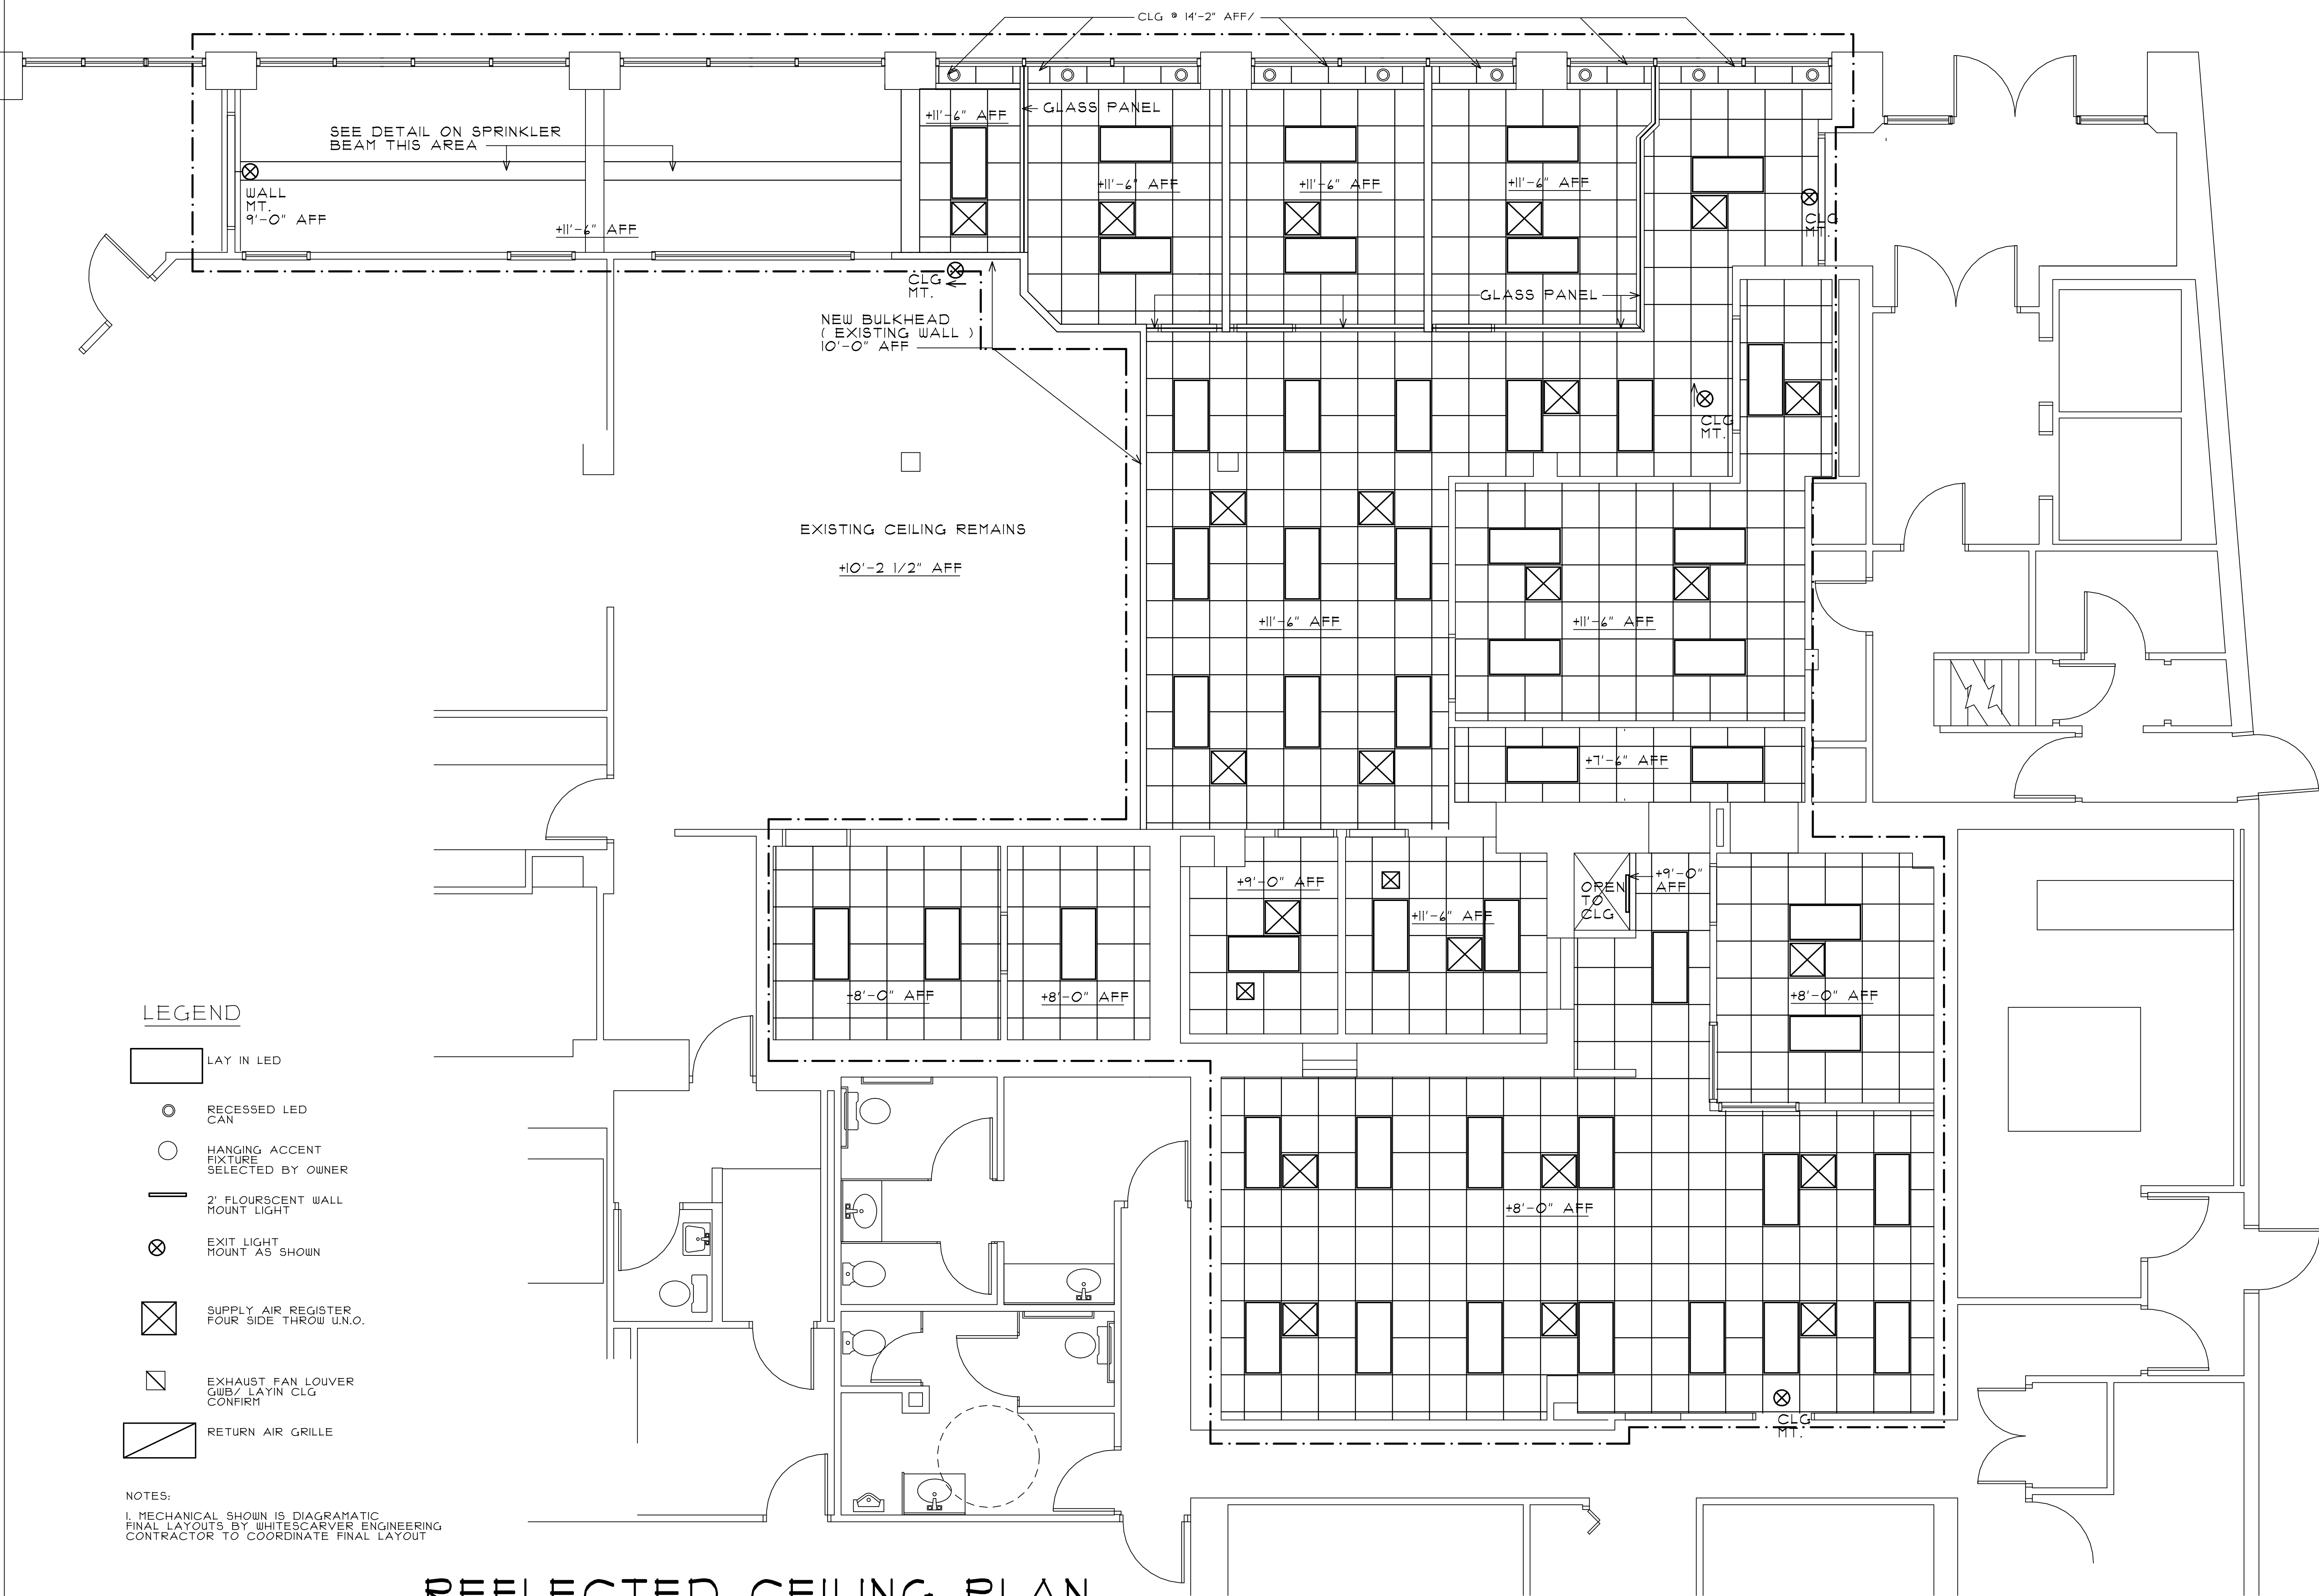

LEGEND

- LAY IN LED
- RECESSED LED CAN
- HANGING ACCENT FIXTURE SELECTED BY OWNER
- 2' FLUORESCENT WALL MOUNT LIGHT
- EXIT LIGHT MOUNT AS SHOWN
- SUPPLY AIR REGISTER FOUR SIDE THROW U.N.O.
- EXHAUST FAN LOUVER CLG LAYIN CLG CONFIRM
- RETURN AIR GRILLE

NOTES:  
1. MECHANICAL SHOWN IS DIAGRAMATIC  
FINAL LAYOUTS BY WHITESCARVER ENGINEERING  
CONTRACTOR TO COORDINATE FINAL LAYOUT


# REFLECTED CEILING PLAN

SCALE: 1/4" = 1'-0"  
4,211 SF  
GROUND LEVEL ENTRY, LOWER LEVEL PLAN

**CRAIGHEAD ASSOCIATES**  
Architects, Designers, Construction Managers  
3534 BRAMBLETON AVENUE SW  
SUITE 8  
ROANOKE, VIRGINIA 24018  
(540) 714-5326  
rcraigheadarchitect@yahoo.com

## RENOVATIONS FOR COULTER OFFICE BUILDING 601 S. JEFFERSON ST ROANOKE, VA.

|           |            |           |
|-----------|------------|-----------|
|           | GLASS PNLS | 8/29/2017 |
|           | -          | -         |
|           | -          | -         |
|           | -          | -         |
|           | -          | -         |
| REVISIONS |            | DATE      |

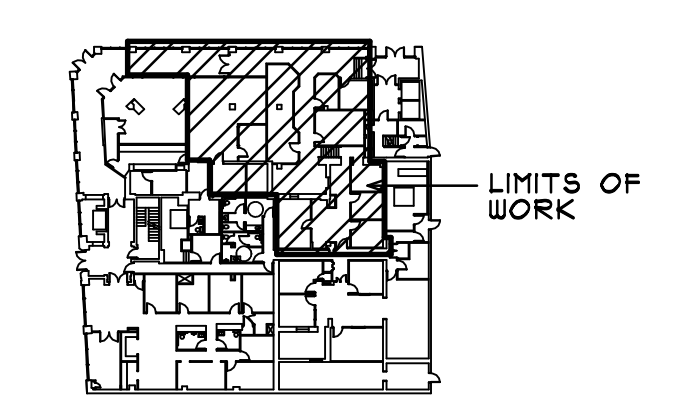

KEY PLAN

### INTERIOR ALTERATIONS FOR WESTERN VIRGINIA WATER AUTHORITY

PROJECT NO: 2017043  
DATE: 04/15/2017  
DRAWN BY: RLC  
CHECKED BY: RLC

APPROVED FOR THE CONTRACTOR \_\_\_\_\_ DATE \_\_\_\_\_  
APPROVED FOR THE OWNER \_\_\_\_\_ DATE \_\_\_\_\_

**A-4**  
REFLECTED CEILING PLAN  
SCALE: 1/4"= 1'-0"  
GRAPHIC: