
 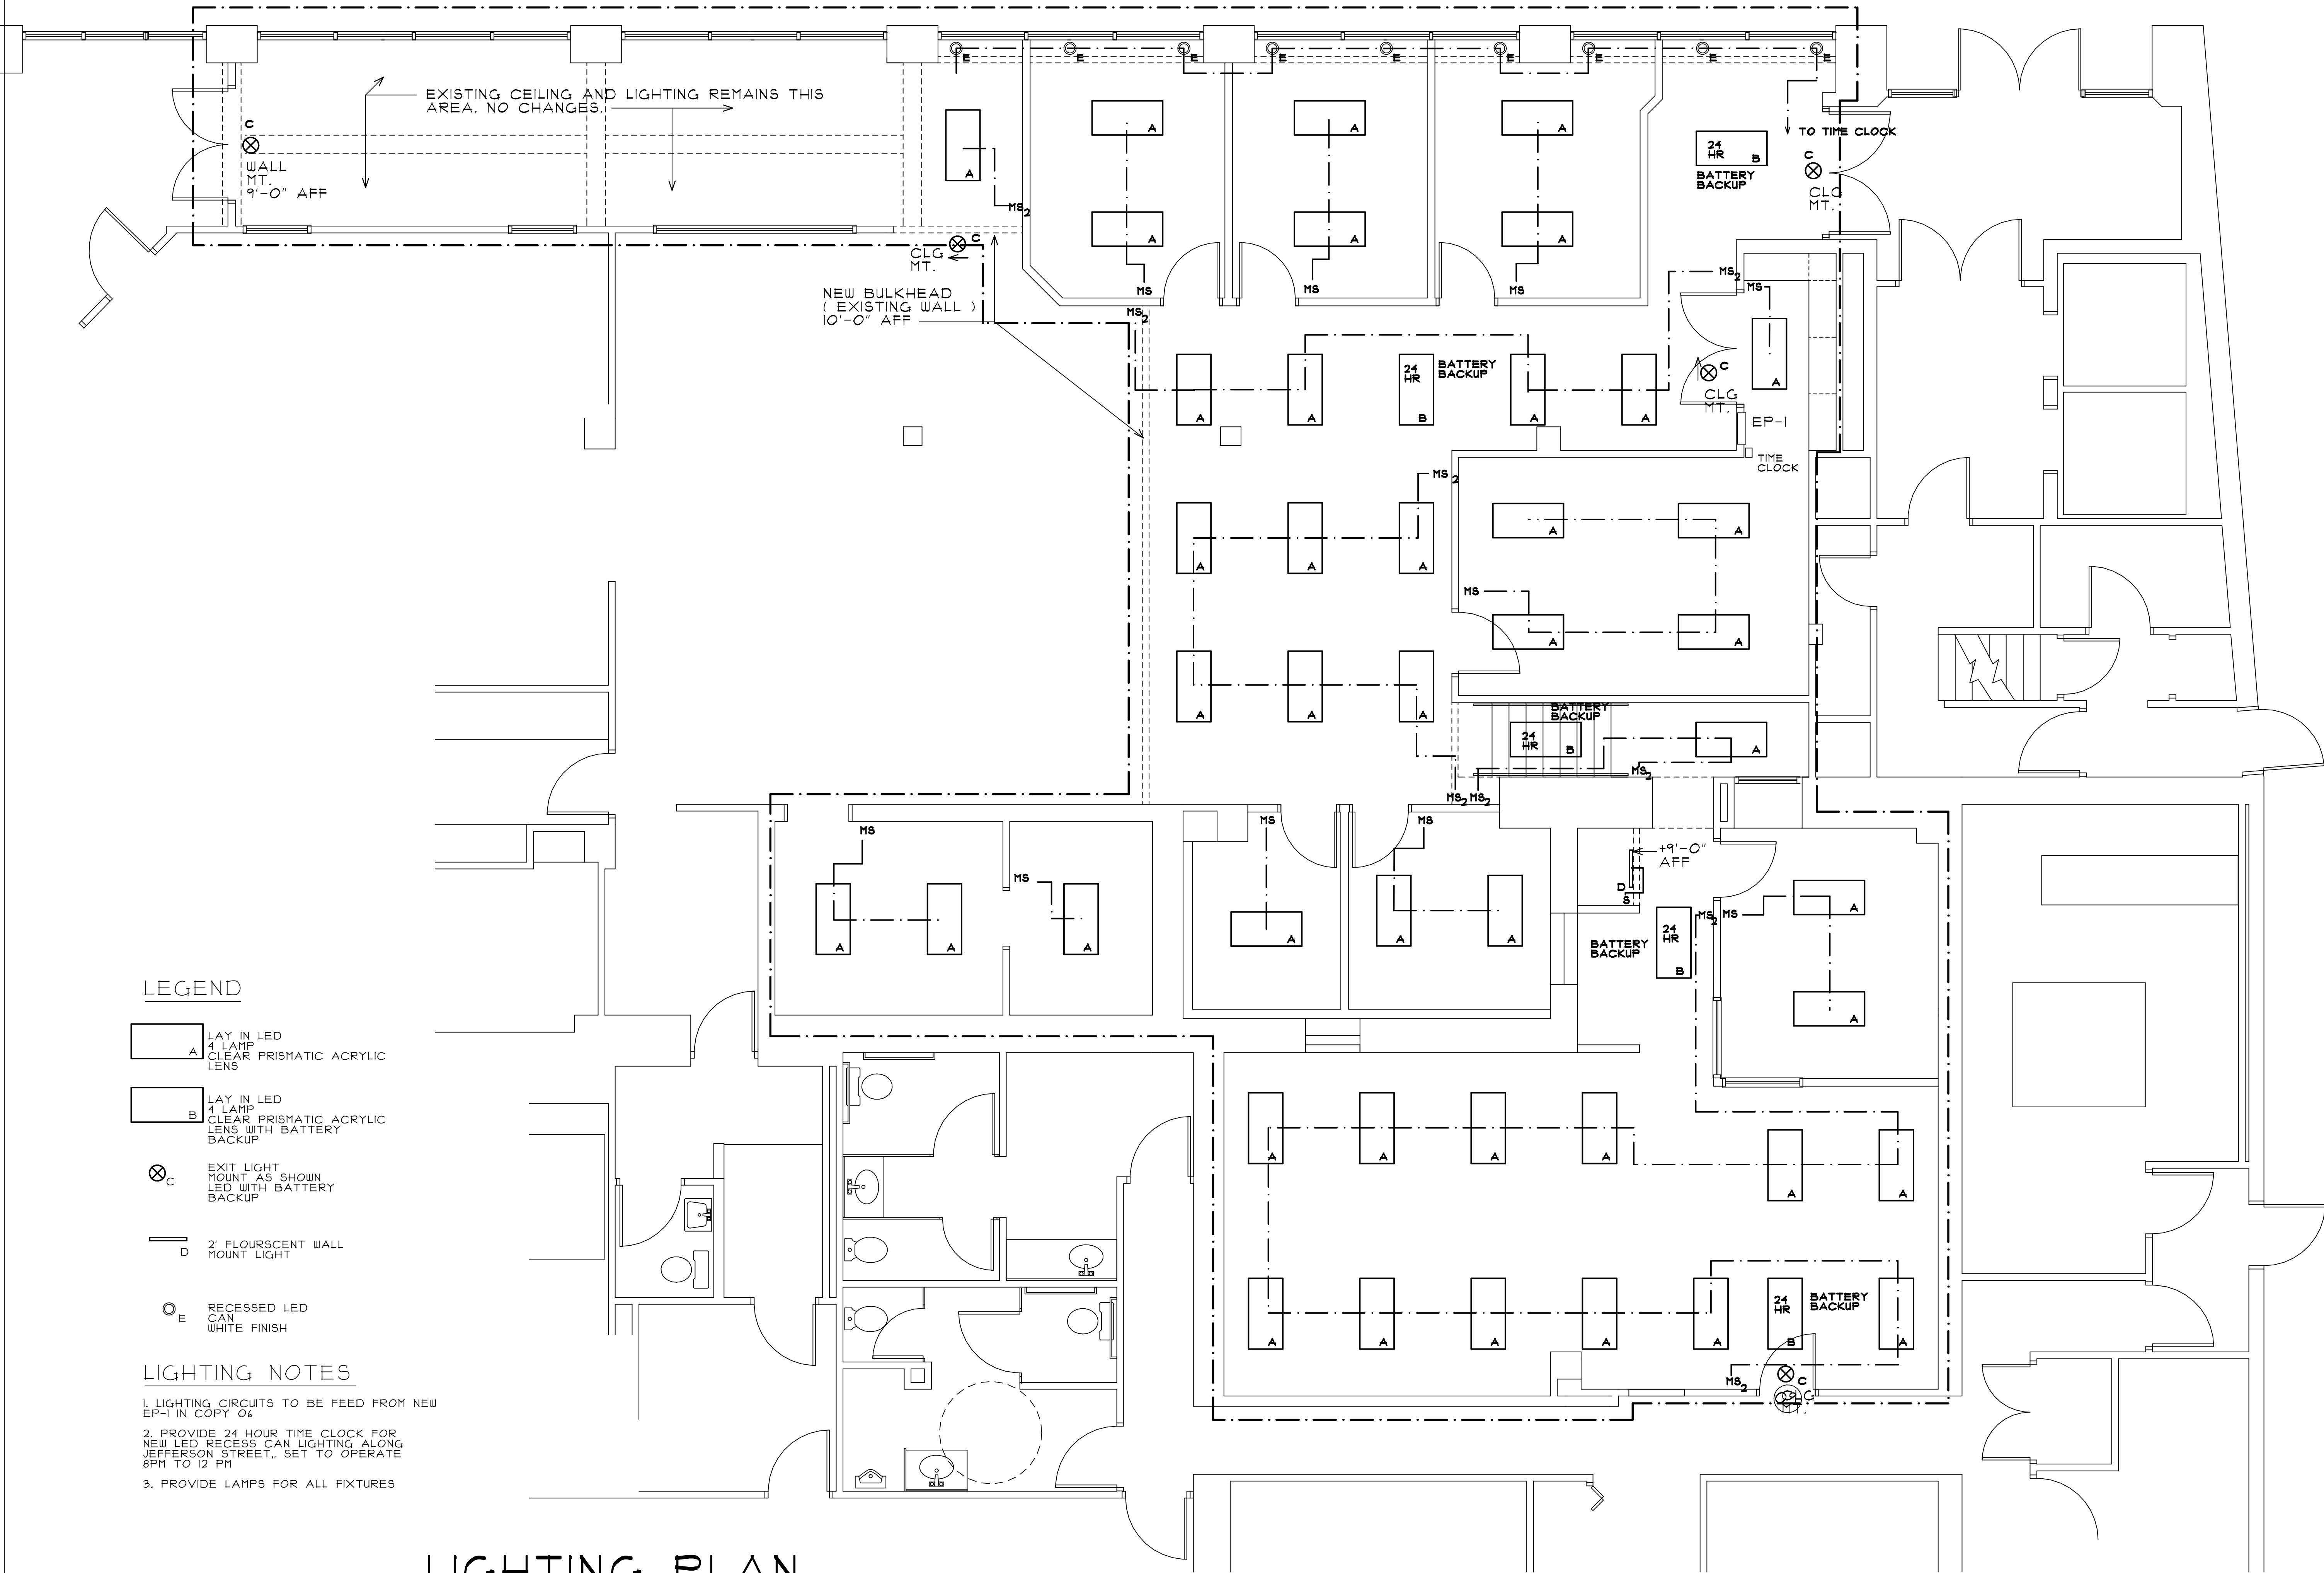
 




LEGEND

-  LAY IN LED 4 LAMP CLEAR PRISMATIC ACRYLIC LENS
-  LAY IN LED 4 LAMP CLEAR PRISMATIC ACRYLIC LENS WITH BATTERY BACKUP
-  EXIT LIGHT MOUNT AS SHOWN LED WITH BATTERY BACKUP
-  2' FLUORESCENT WALL MOUNT LIGHT
-  RECESSED LED CAN WHITE FINISH

LIGHTING NOTES

1. LIGHTING CIRCUITS TO BE FEED FROM NEW EP-1 IN COPY 06
2. PROVIDE 24 HOUR TIME CLOCK FOR NEW LED RECESS CAN LIGHTING ALONG JEFFERSON STREET. SET TO OPERATE 8PM TO 12 PM
3. PROVIDE LAMPS FOR ALL FIXTURES



LIGHTING PLAN

SCALE: 1/4" = 1'-0"
4,211 SF
GROUND LEVEL ENTRY, LOWER LEVEL PLAN

RENOVATIONS
FOR
**COULTER OFFICE
BUILDING**
601 S. JEFFERSON ST
ROANOKE, VA.

△	_____	_____
△	_____	_____
△	_____	_____
△	_____	_____
△	_____	_____

REVISIONS DATE

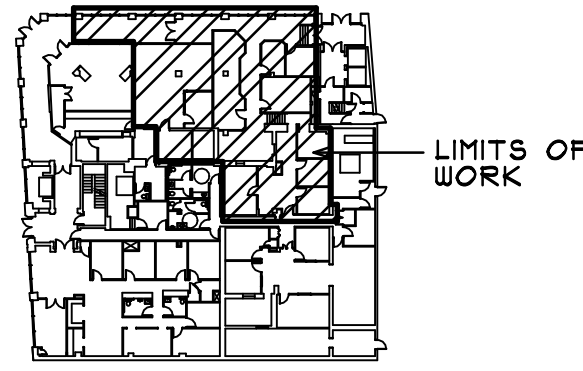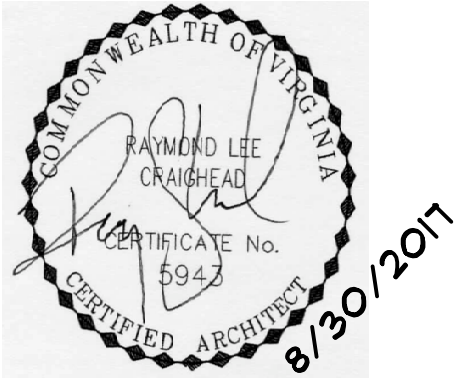

KEY PLAN

INTERIOR ALTERATIONS FOR
**WESTERN VIRGINIA
WATER AUTHORITY**

PROJECT NO: 2017043
DATE: 06/15/2017
DRAWN BY: RLC
CHECKED BY: RLC

APPROVED FOR THE CONTRACTOR DATE

APPROVED FOR THE OWNER DATE

E-1
LIGHTING PLAN
SCALE: 1/4"= 1'-0"
GRAPHIC: