


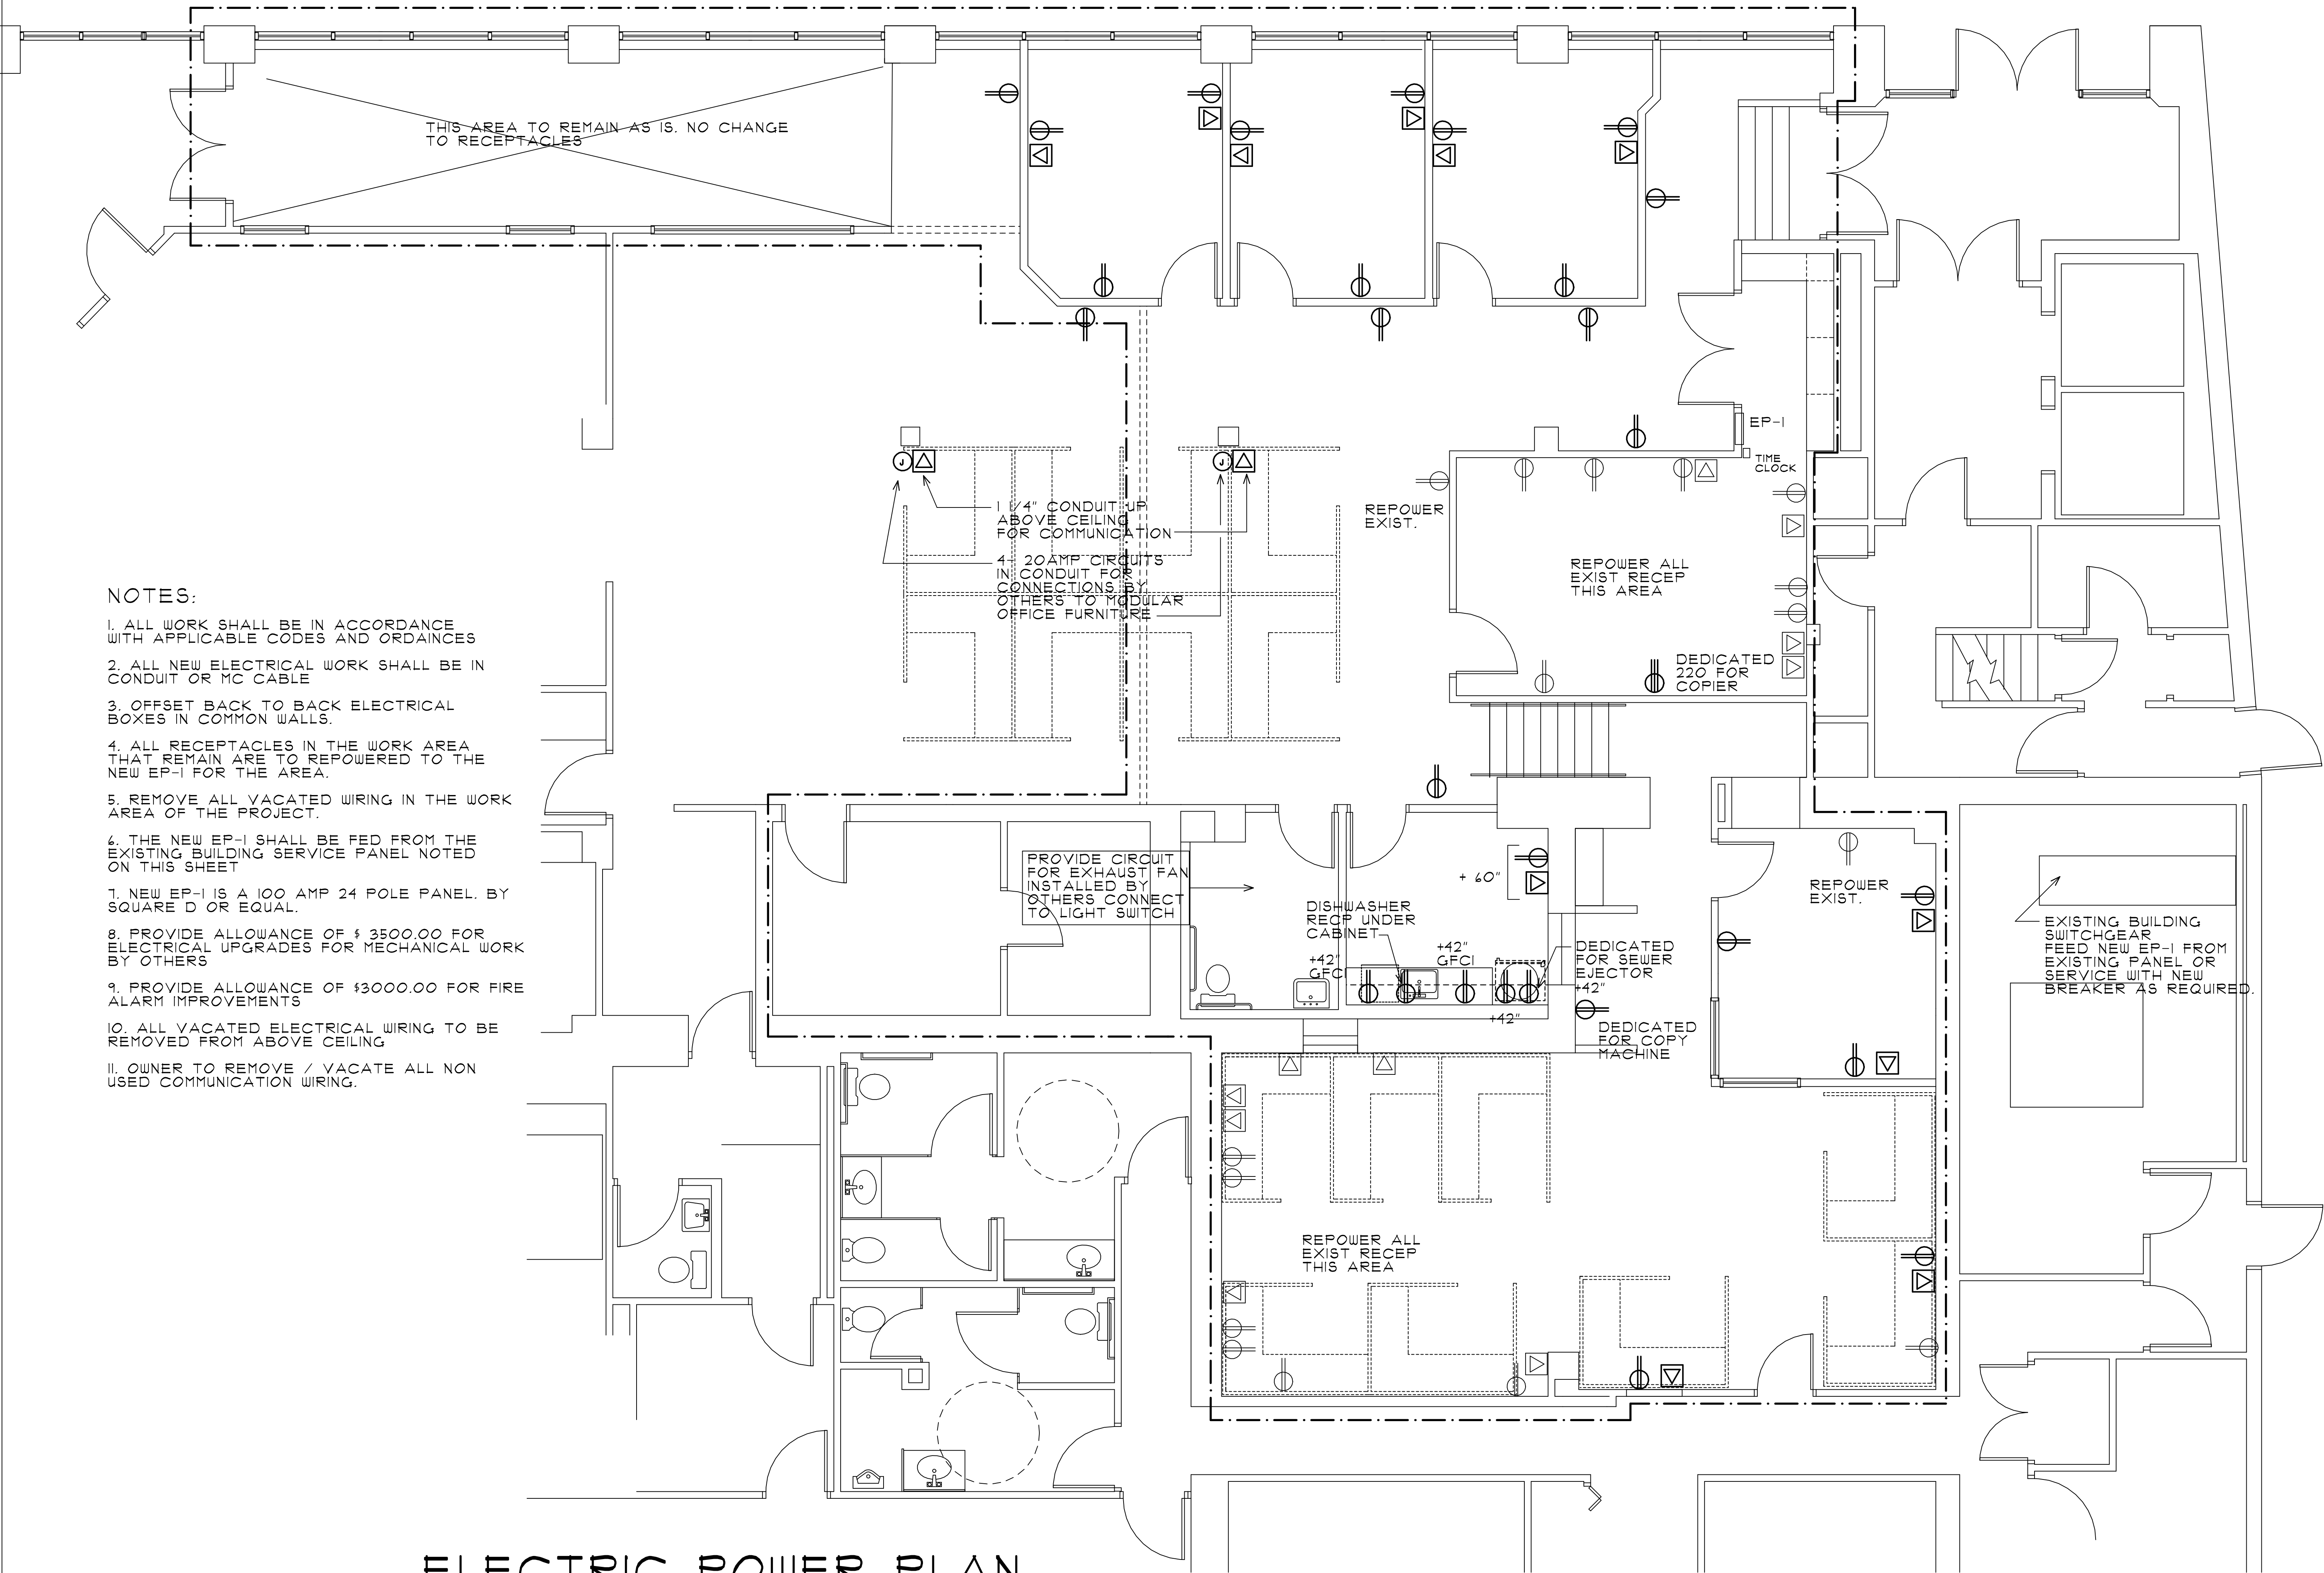

NOTES:

1. ALL WORK SHALL BE IN ACCORDANCE WITH APPLICABLE CODES AND ORDINANCES
2. ALL NEW ELECTRICAL WORK SHALL BE IN CONDUIT OR MC CABLE
3. OFFSET BACK TO BACK ELECTRICAL BOXES IN COMMON WALLS.
4. ALL RECEPTACLES IN THE WORK AREA THAT REMAIN ARE TO REPOWERED TO THE NEW EP-1 FOR THE AREA.
5. REMOVE ALL VACATED WIRING IN THE WORK AREA OF THE PROJECT.
6. THE NEW EP-1 SHALL BE FED FROM THE EXISTING BUILDING SERVICE PANEL NOTED ON THIS SHEET
7. NEW EP-1 IS A 100 AMP 24 POLE PANEL. BY SQUARE D OR EQUAL.
8. PROVIDE ALLOWANCE OF \$ 3500.00 FOR ELECTRICAL UPGRADES FOR MECHANICAL WORK BY OTHERS
9. PROVIDE ALLOWANCE OF \$3000.00 FOR FIRE ALARM IMPROVEMENTS
10. ALL VACATED ELECTRICAL WIRING TO BE REMOVED FROM ABOVE CEILING
11. OWNER TO REMOVE / VACATE ALL NON USED COMMUNICATION WIRING.

ELECTRIC POWER PLAN

SCALE: 1/16" = 1'-0"


4,211 SF

GROUND LEVEL ENTRY, LOWER LEVEL PLAN

RENOVATIONS
FOR
**COULTER OFFICE
BUILDING**
601 S. JEFFERSON ST
ROANOKE, VA.

△	_____	_____
△	-	-
△	-	-
△	-	-
△	-	-

REVISIONS DATE

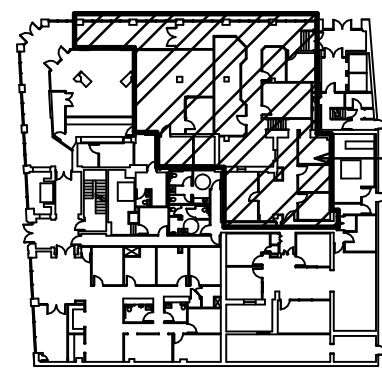

KEY PLAN

INTERIOR ALTERATIONS FOR
**WESTERN VIRGINIA
WATER AUTHORITY**

PROJECT NO: 2011043
DATE: 04/15/2017
DRAWN BY: RLC
CHECKED BY: RLC

APPROVED FOR THE CONTRACTOR DATE

APPROVED FOR THE OWNER DATE

E-2
ELECTRICAL POWER PLAN
SCALE: 1/4"= 1'-0"

GRAPHIC: