


FRANKLIN ROAD

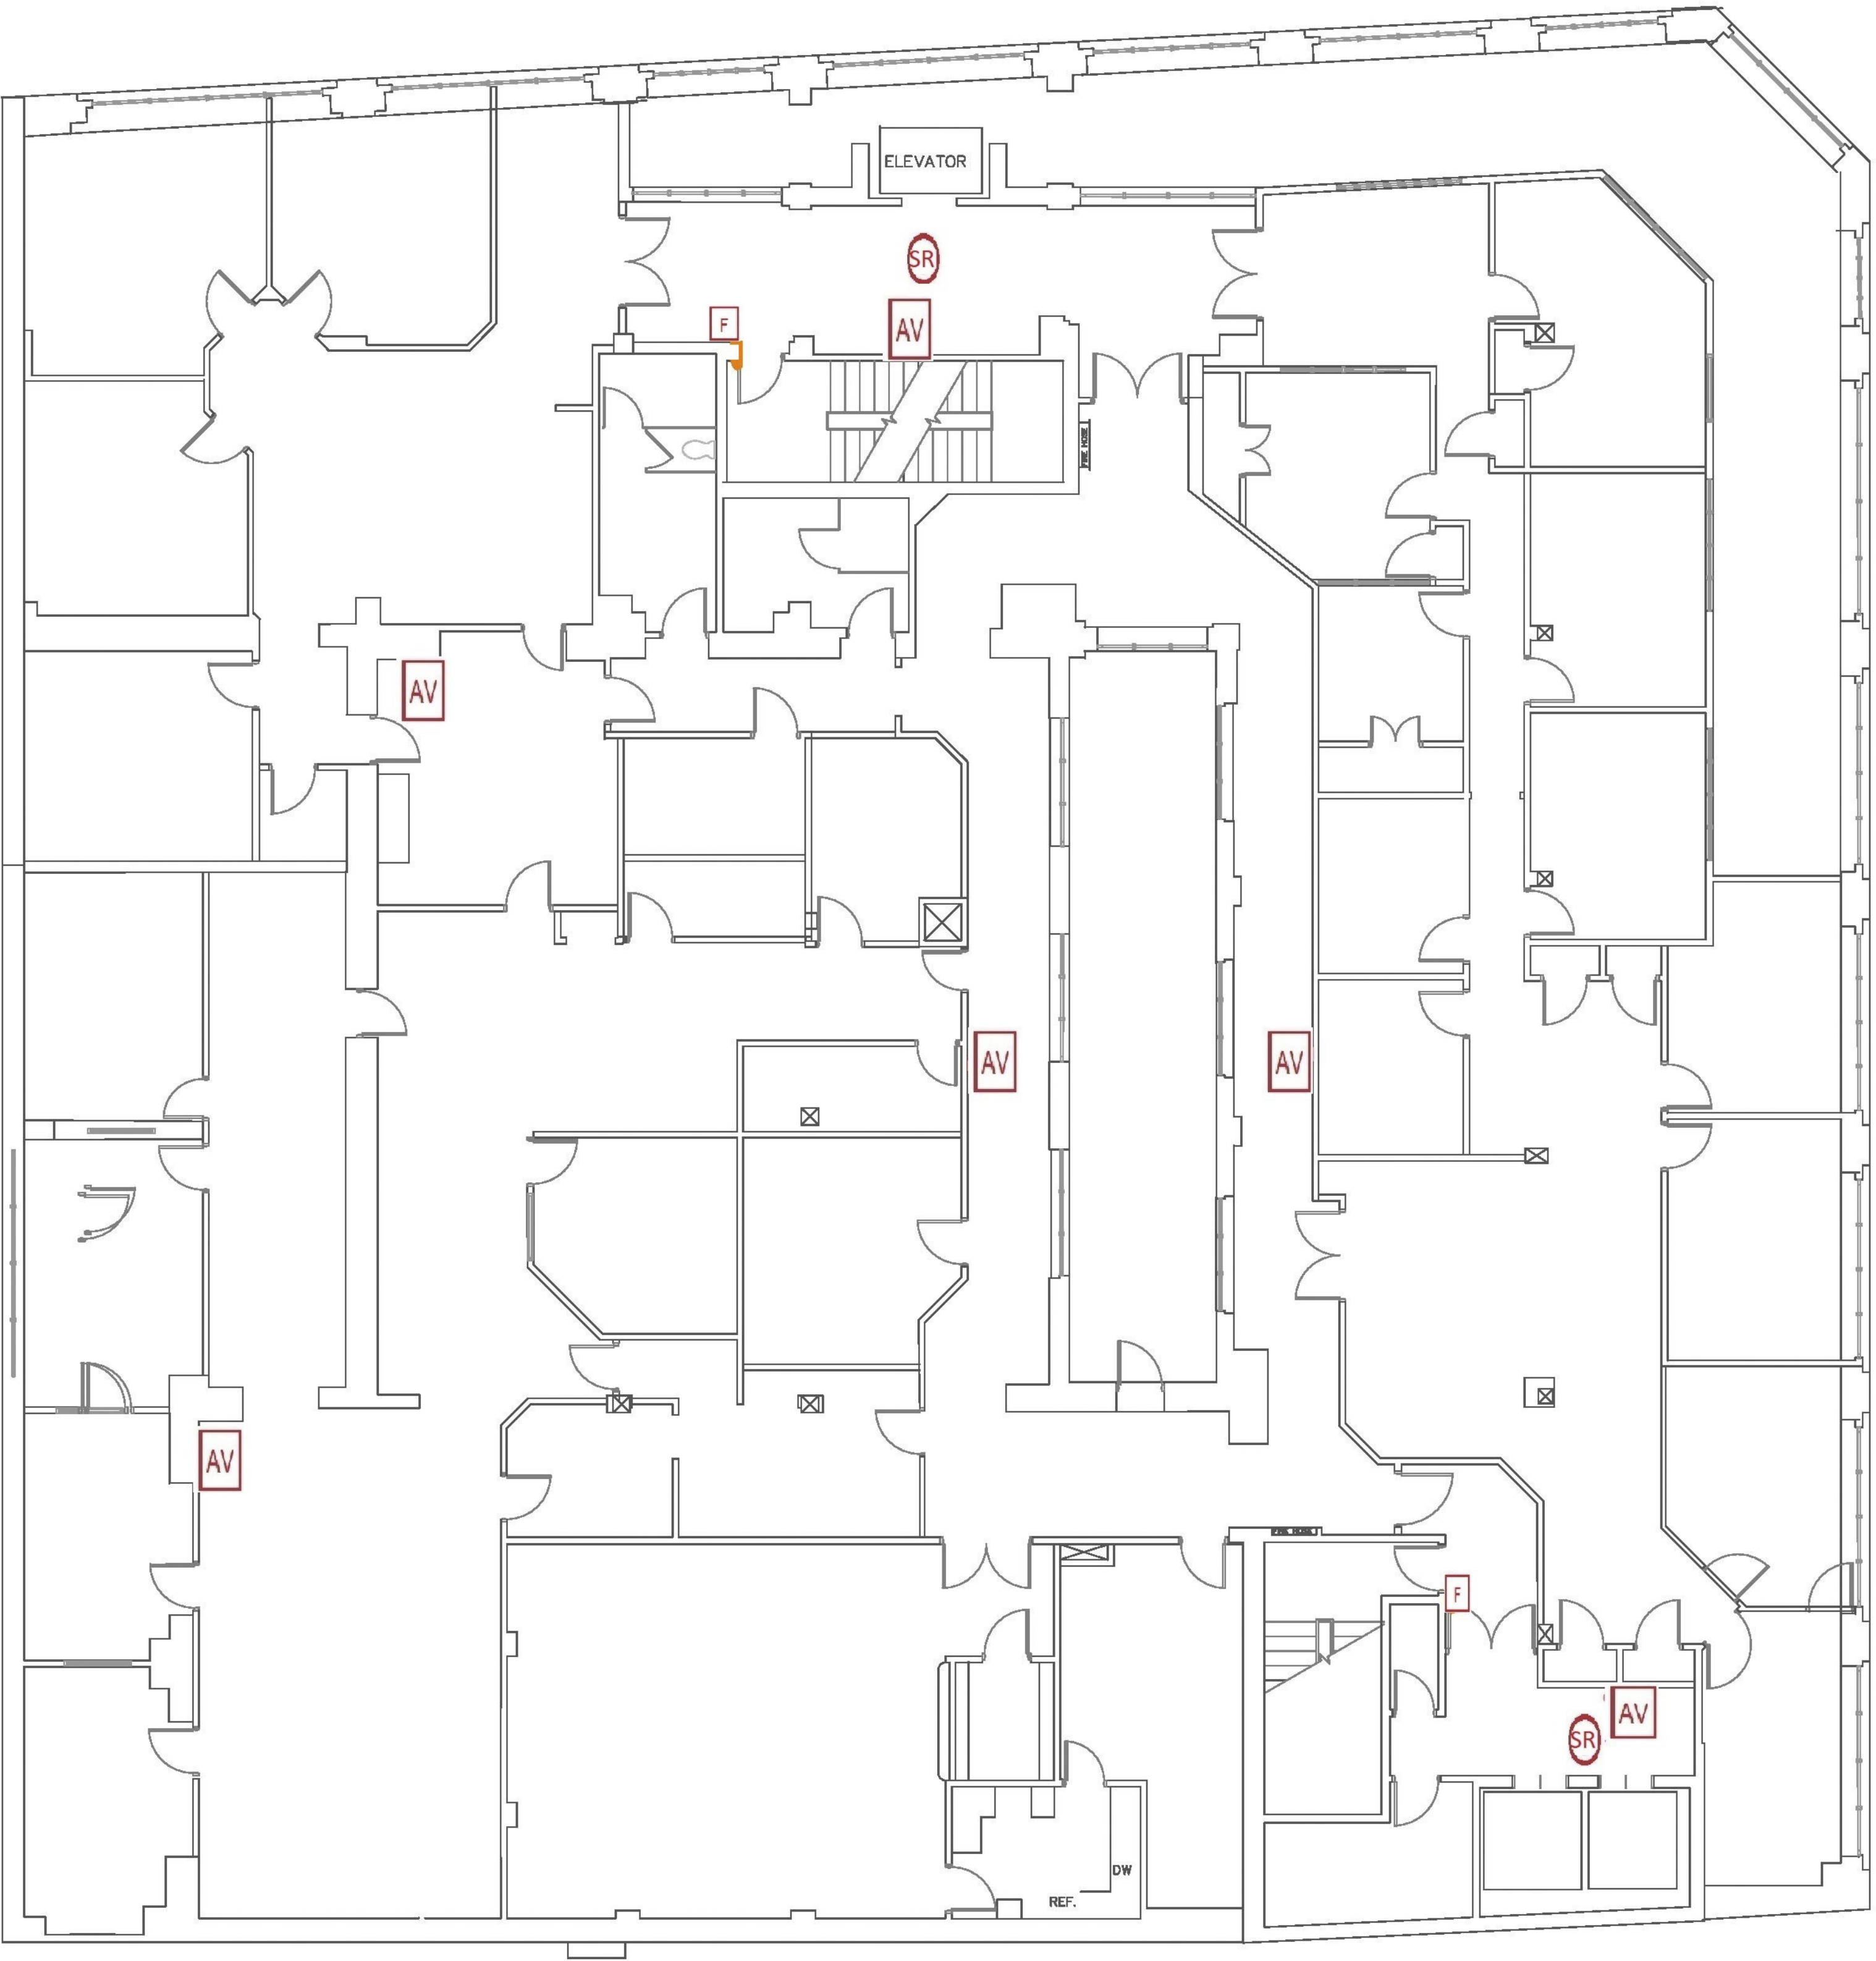

SECOND FLOOR PLAN
SCALE: 1/8" = 1'-0"

JEFFERSON STREET

DESIGN BY:
Star City Fire Protections Inc.



LEDGEND

- FACP Fire Alarm Control Panel
- F MANUAL PULL STATION
- TS SPRINKLER TAMPER SWITCH
- FS SPRINKLER WATERFLOW SWITCH
- AV HORN/STROBE
- V STROBE
- S SYSTEM SMOKE DETECTOR
- FAAN FIRE ALARM ANNUNCIATOR
- DD DUCT DETECTOR
- H HEAT DETECTOR
- SR SYSTEM SMOKE DETECTOR WITH RELAY
- FABP FIRE ALARM BOOSTER PANEL
- Z Monitor Module

REVISION	DATE	DESCRIPTION
DESIGNED BY:	COULTER BUILDING	
DRAWN BY:	SECOND FLOOR	
CHECKED BY:	WESTERN VIRGINIA WATER AUTHORITY	
SCALE:	801 S. JEFFERSON STREET	
DATE:	ROANOKE VA. 24011	
SHEET		FA-3