


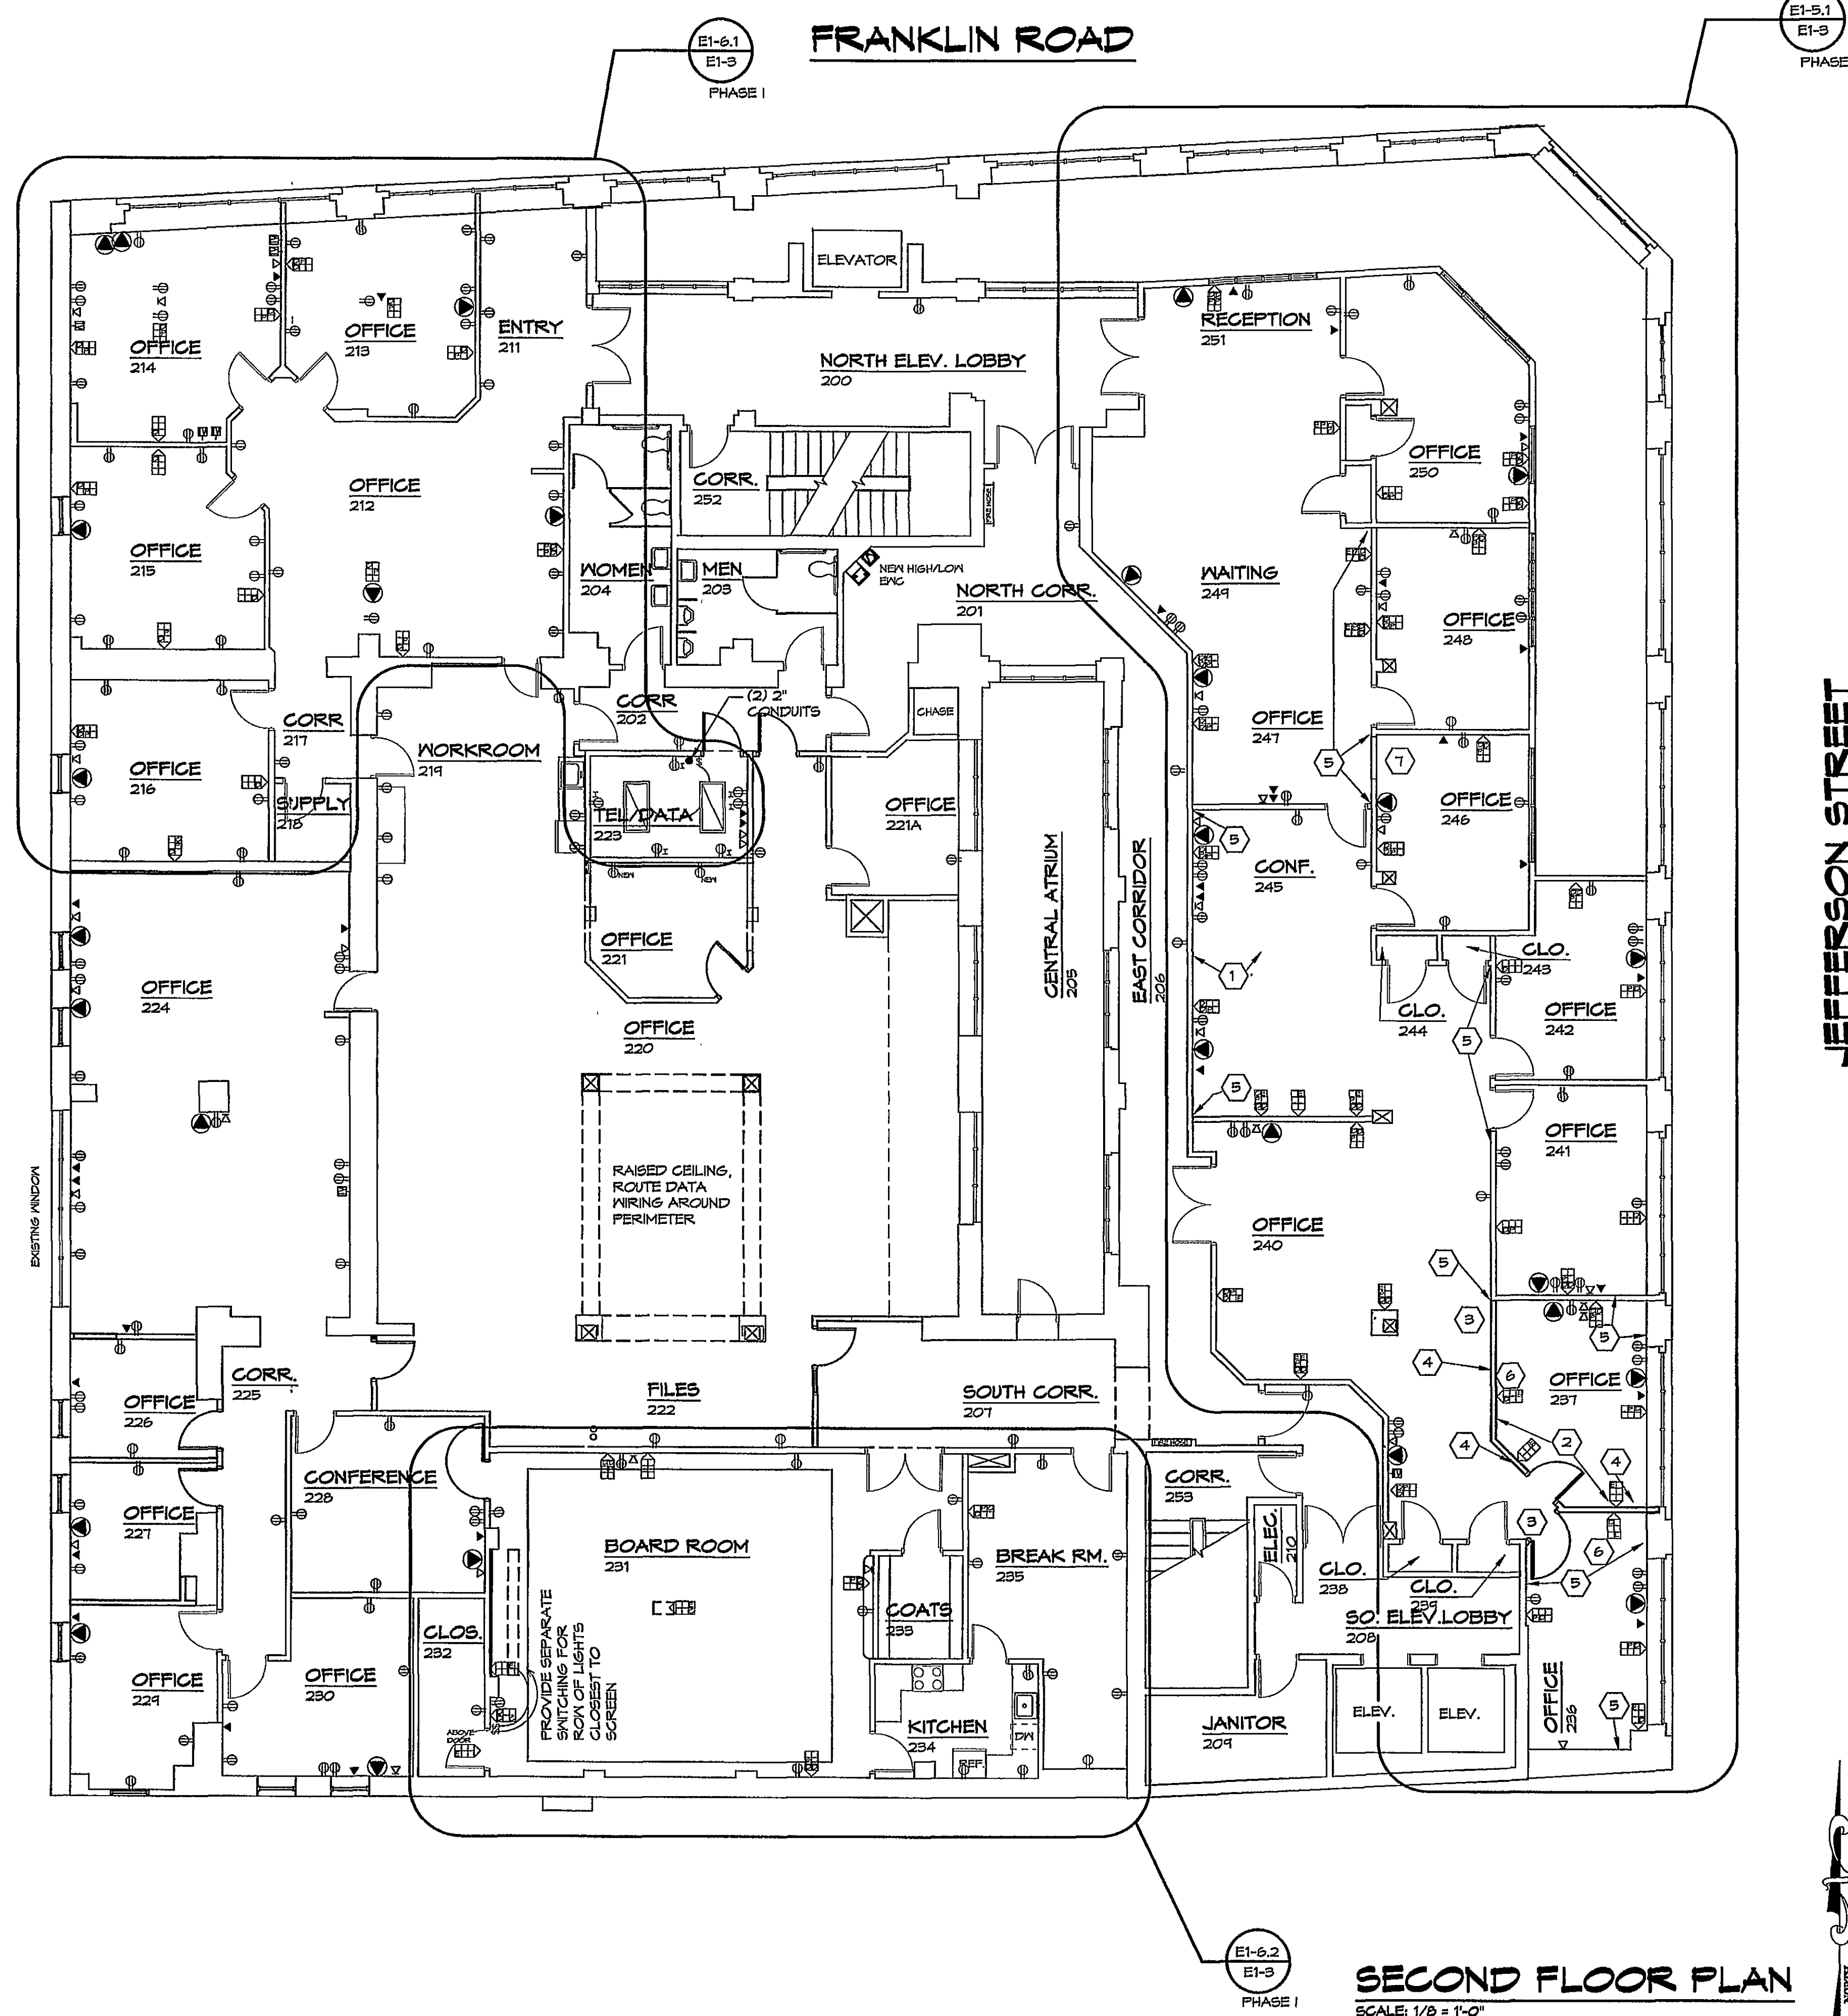

WIRING LEGEND

DATA — WALL DATA
 TELEPHONE — DATA
 COAXIAL — TELEPHONE
 CABLE — ELECTRICAL
 REG.

- ⊕ NEW RECEPTACLE ON NEW 40A CIRCUIT WITH ISOLATION GROUND
- NEW 2- 2" CONDUITS
- ⊕ EXISTING RECEPTACLE TO REMAIN
- ⊕ EXISTING PHONE JACK
- ⊕ EXISTING DATA PORT
- D EXISTING TOKEN RING PORT

SECOND FLOOR PLAN

SCALE: 1/8" = 1'-0"