
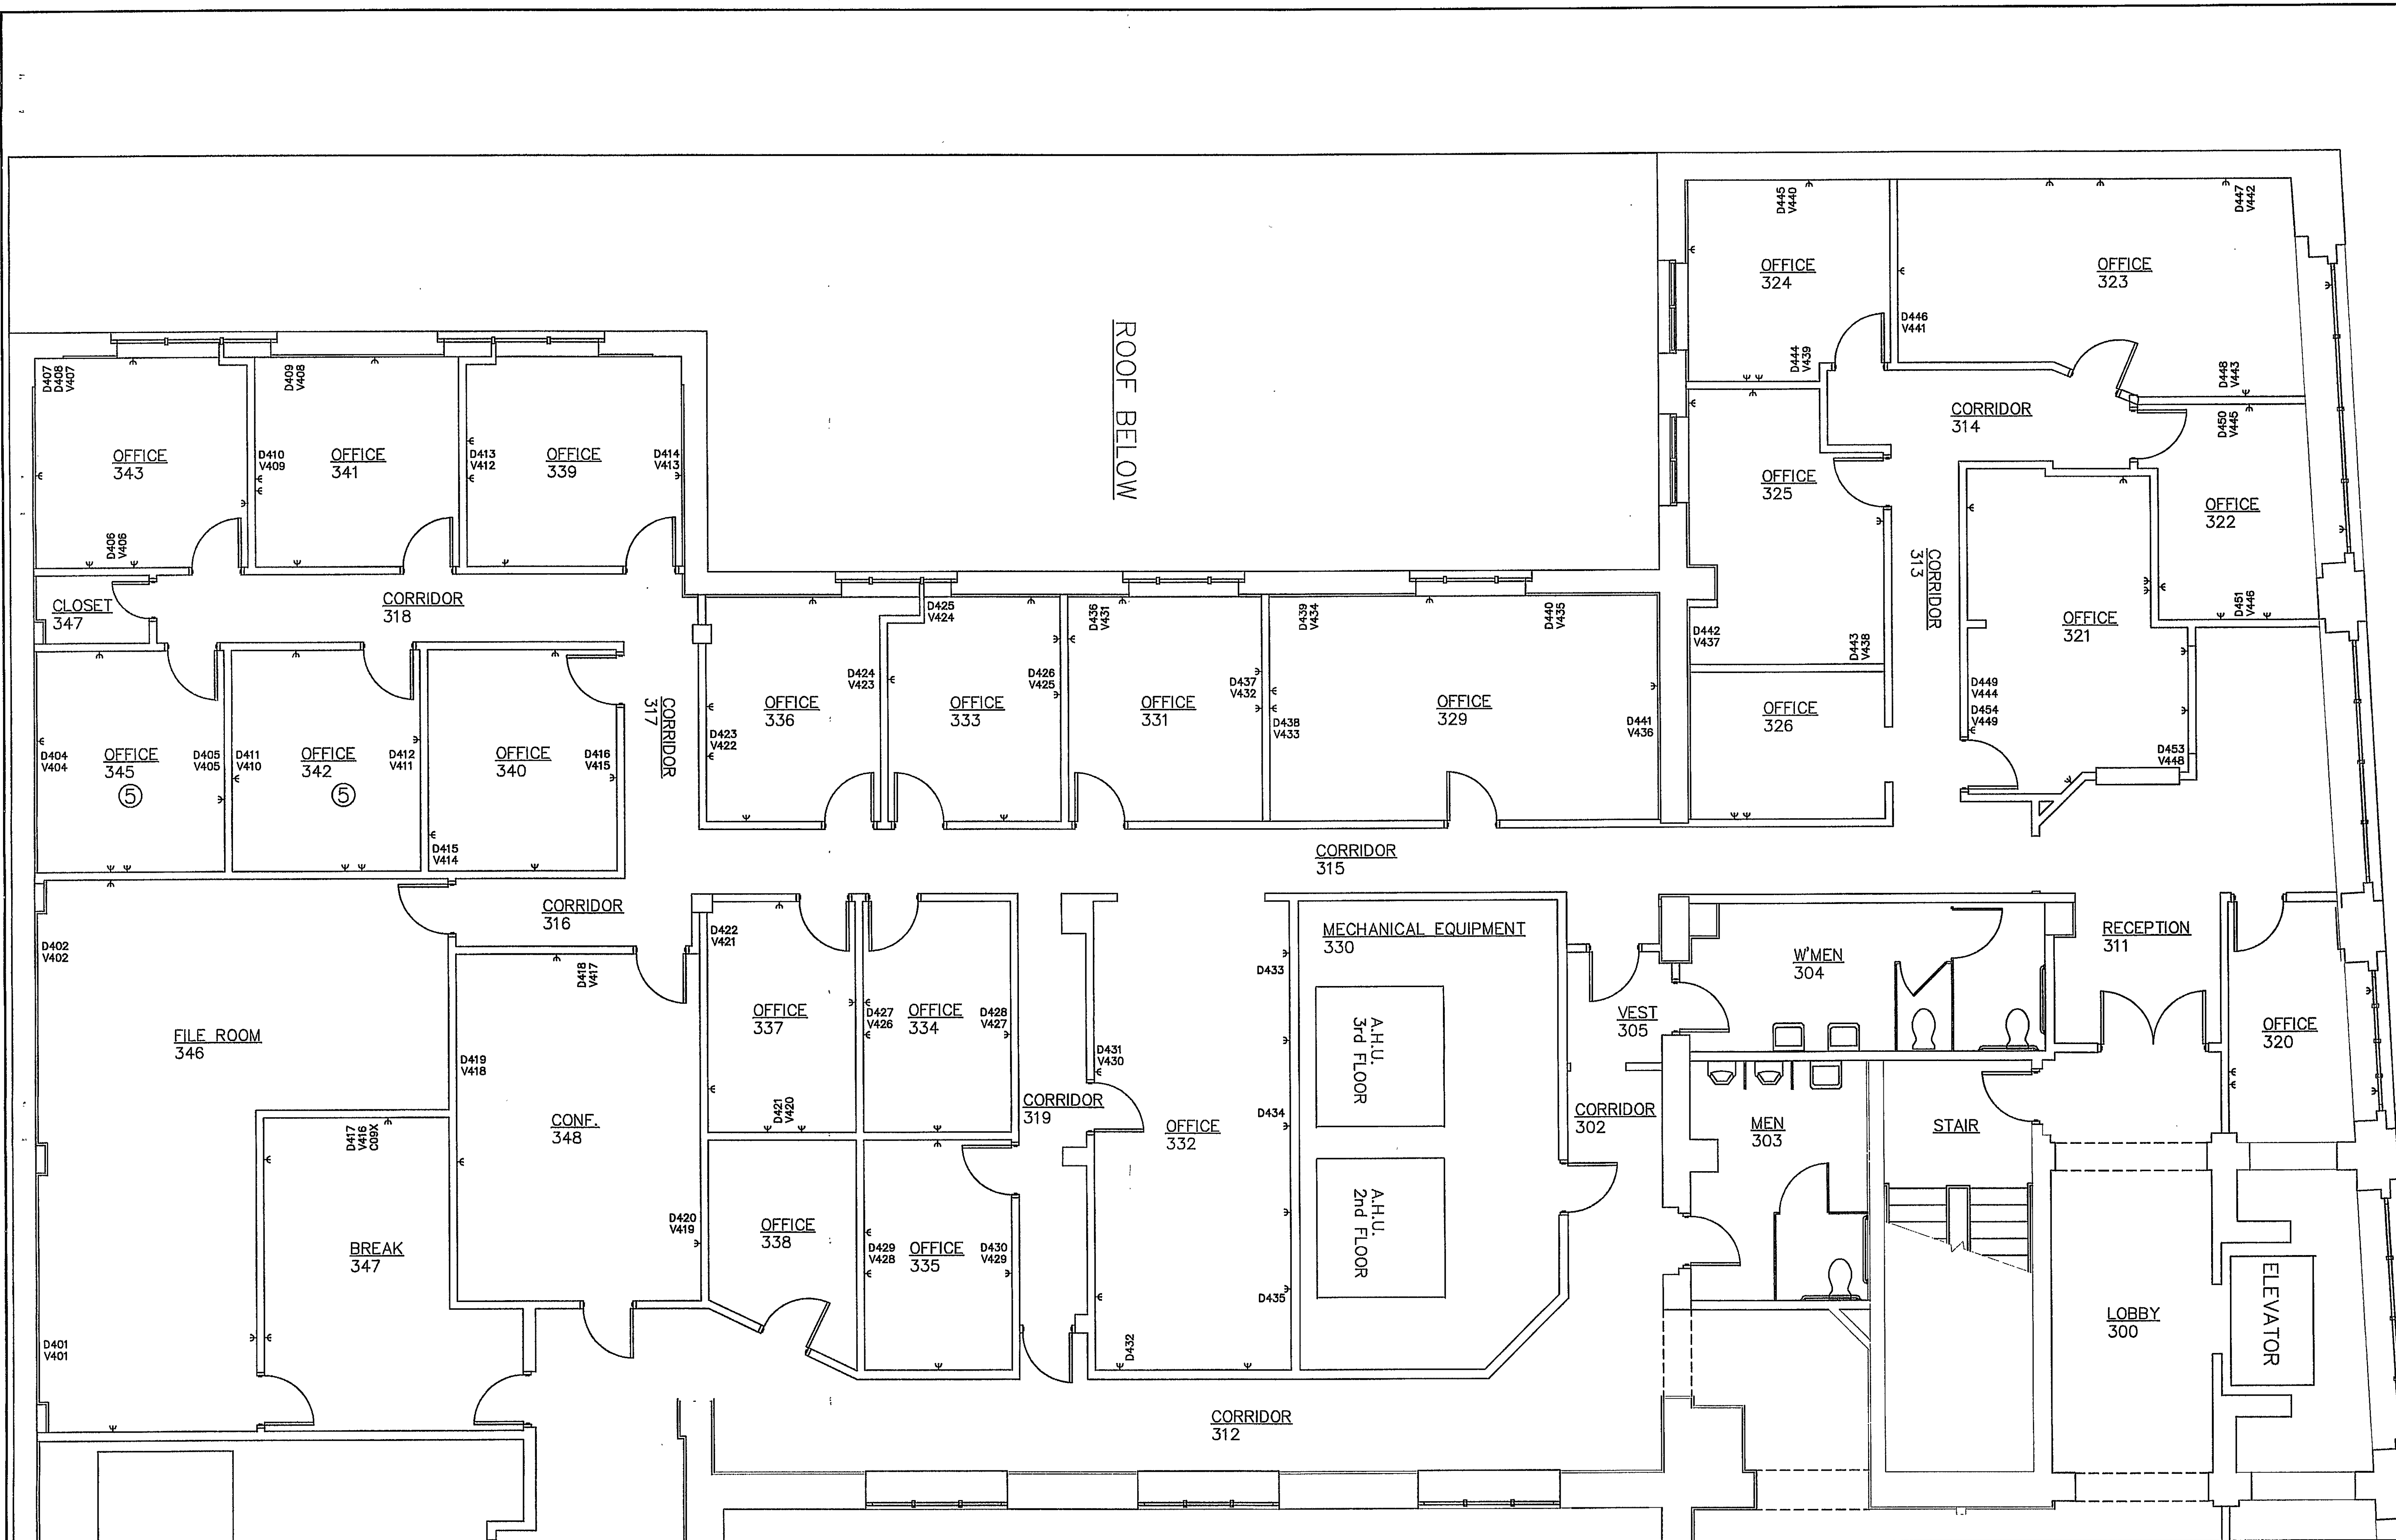


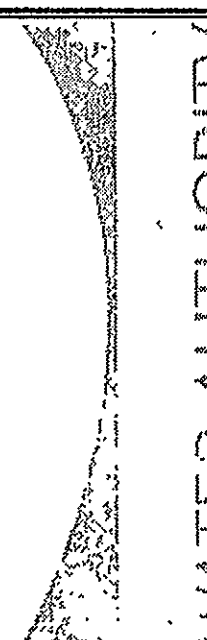

THIRD FLOOR PLAN
SCALE: 1/4" = 1'-0"

 WATER AUTHORITY	
ENGINEERING SERVICES 2012 SOUTH JEFFERSON STREET ROANOKE, VIRGINIA 24014 PHONE: (540) 853-5641	
COULTER BUILDING THIRD FLOOR	
Designed By:	JGR
Drawn By:	RRB
Checked By:	JGR
Date:	09/08/05
Scale:	1/4" = 1'-0"
Plan #:	00-00
Sheet:	1 OF