



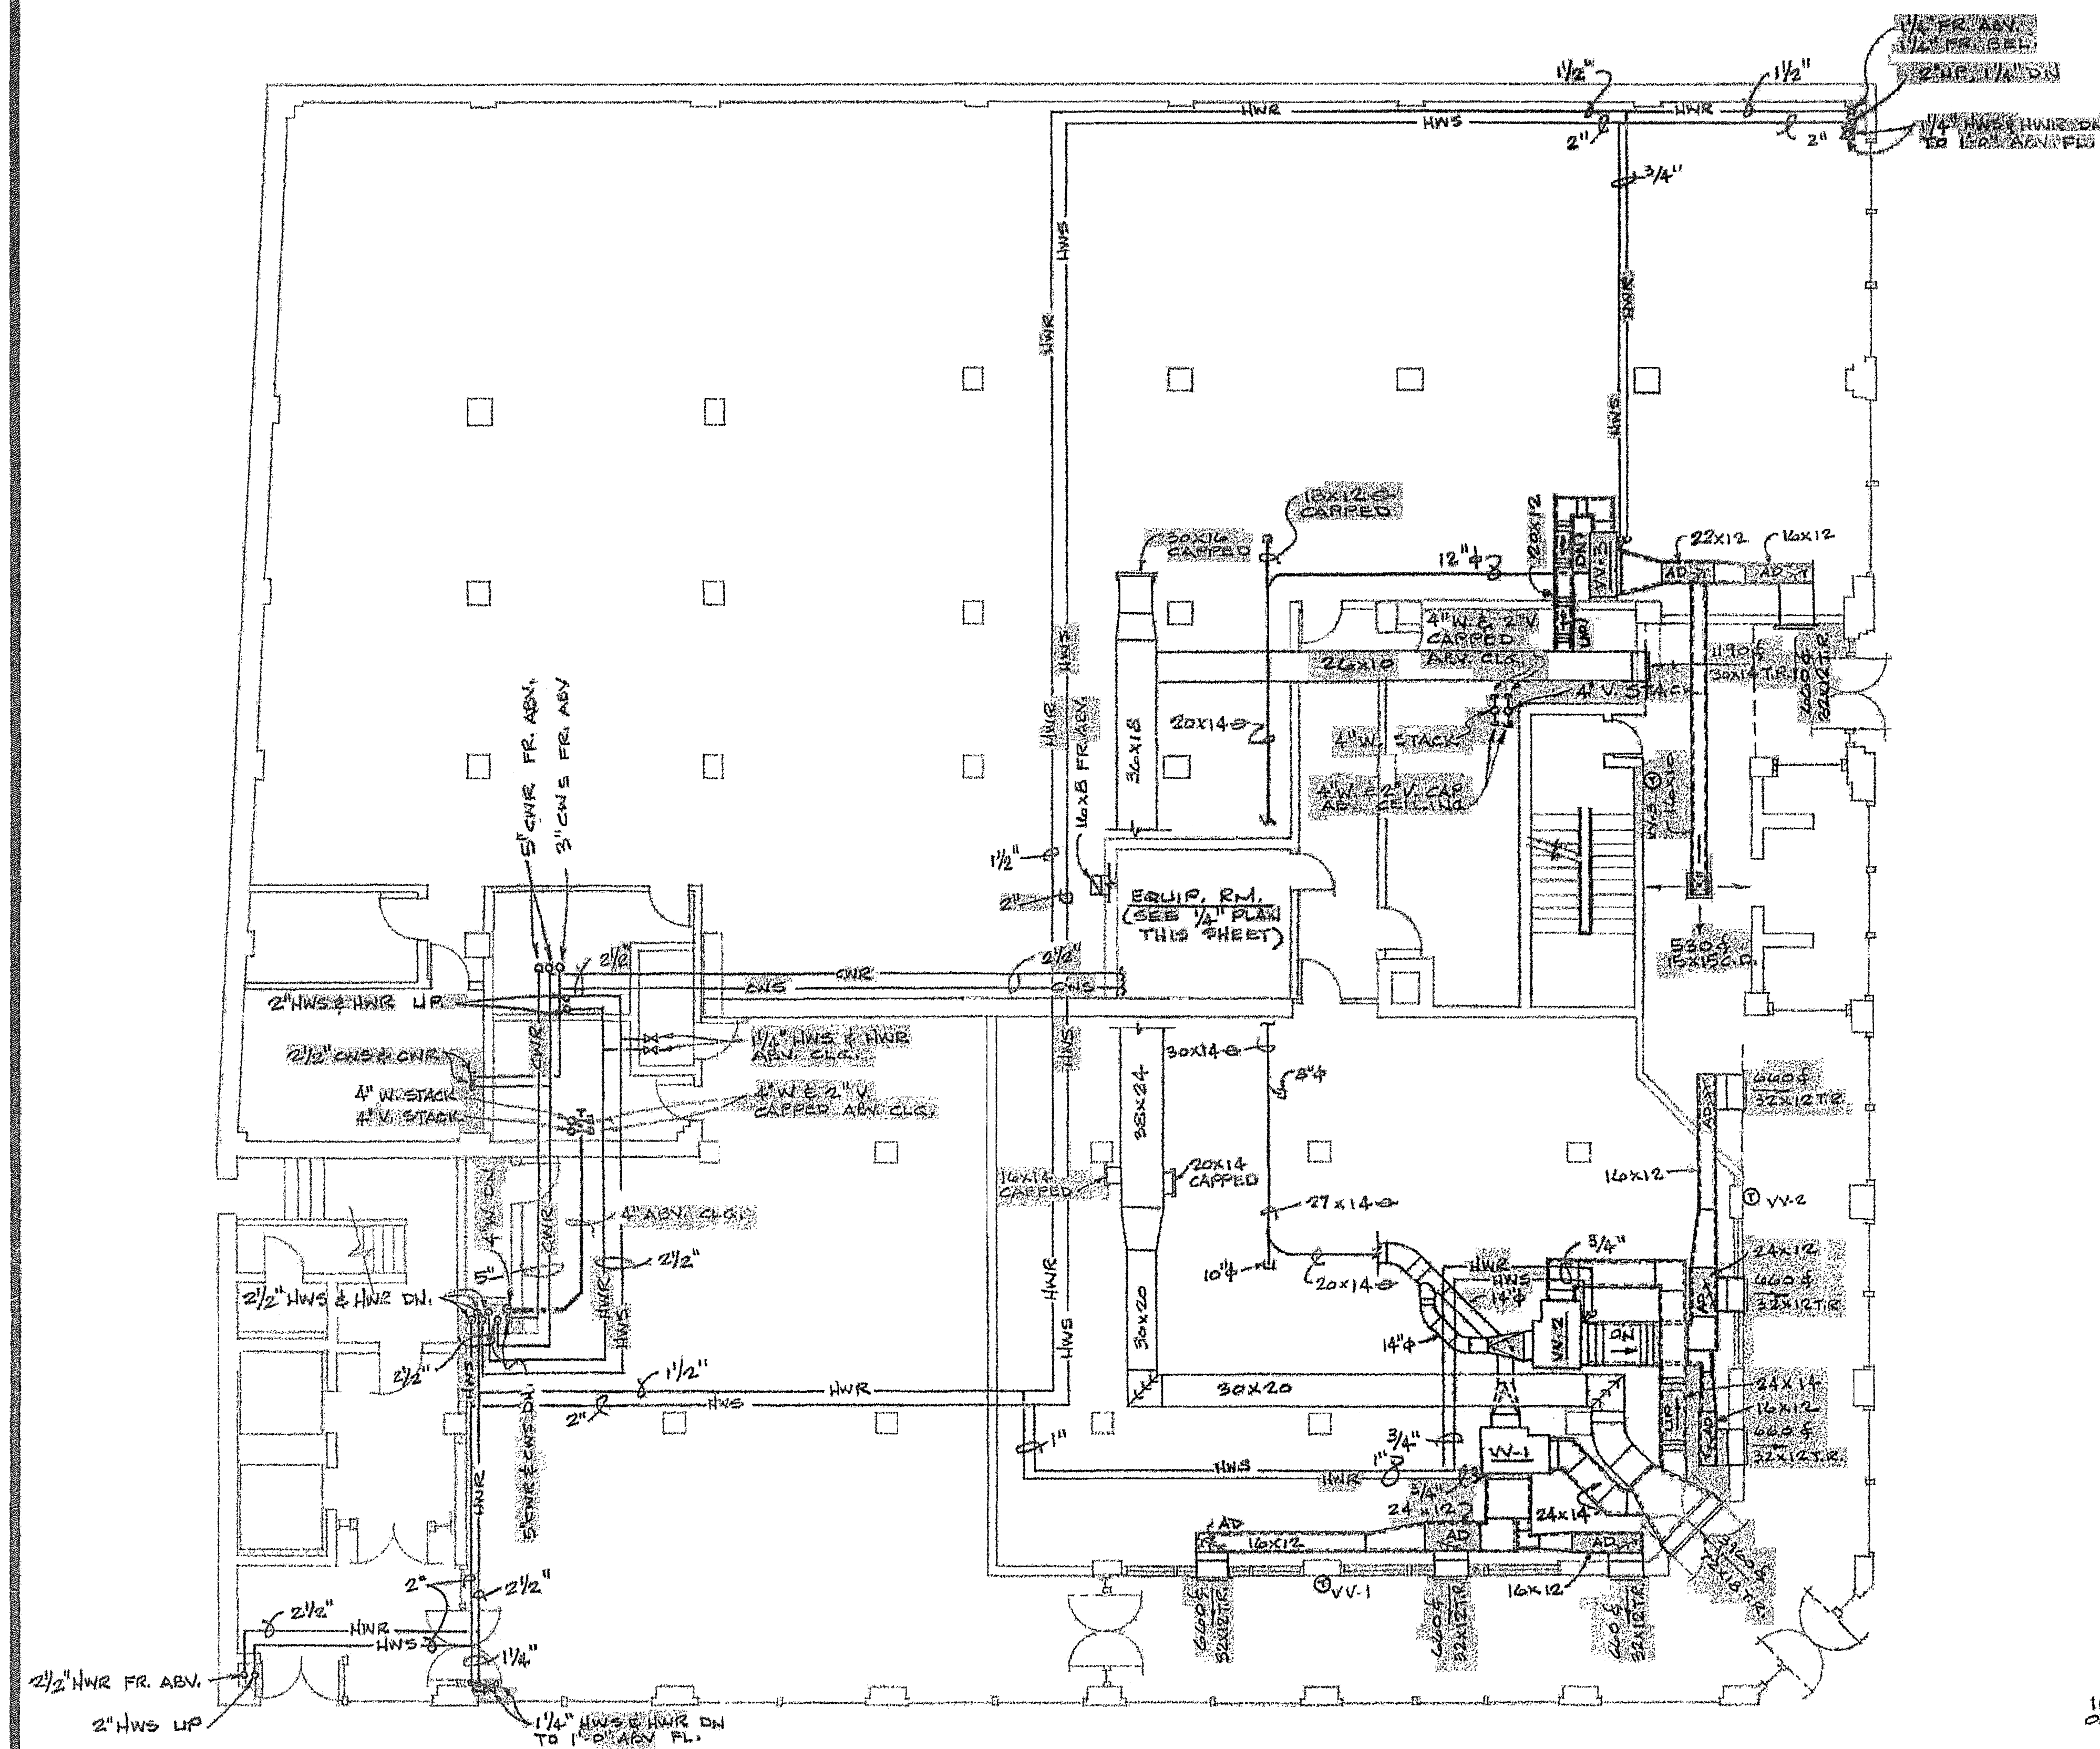

FIRST FLOOR PLAN


SCALE: 1/8" = 1'-0"

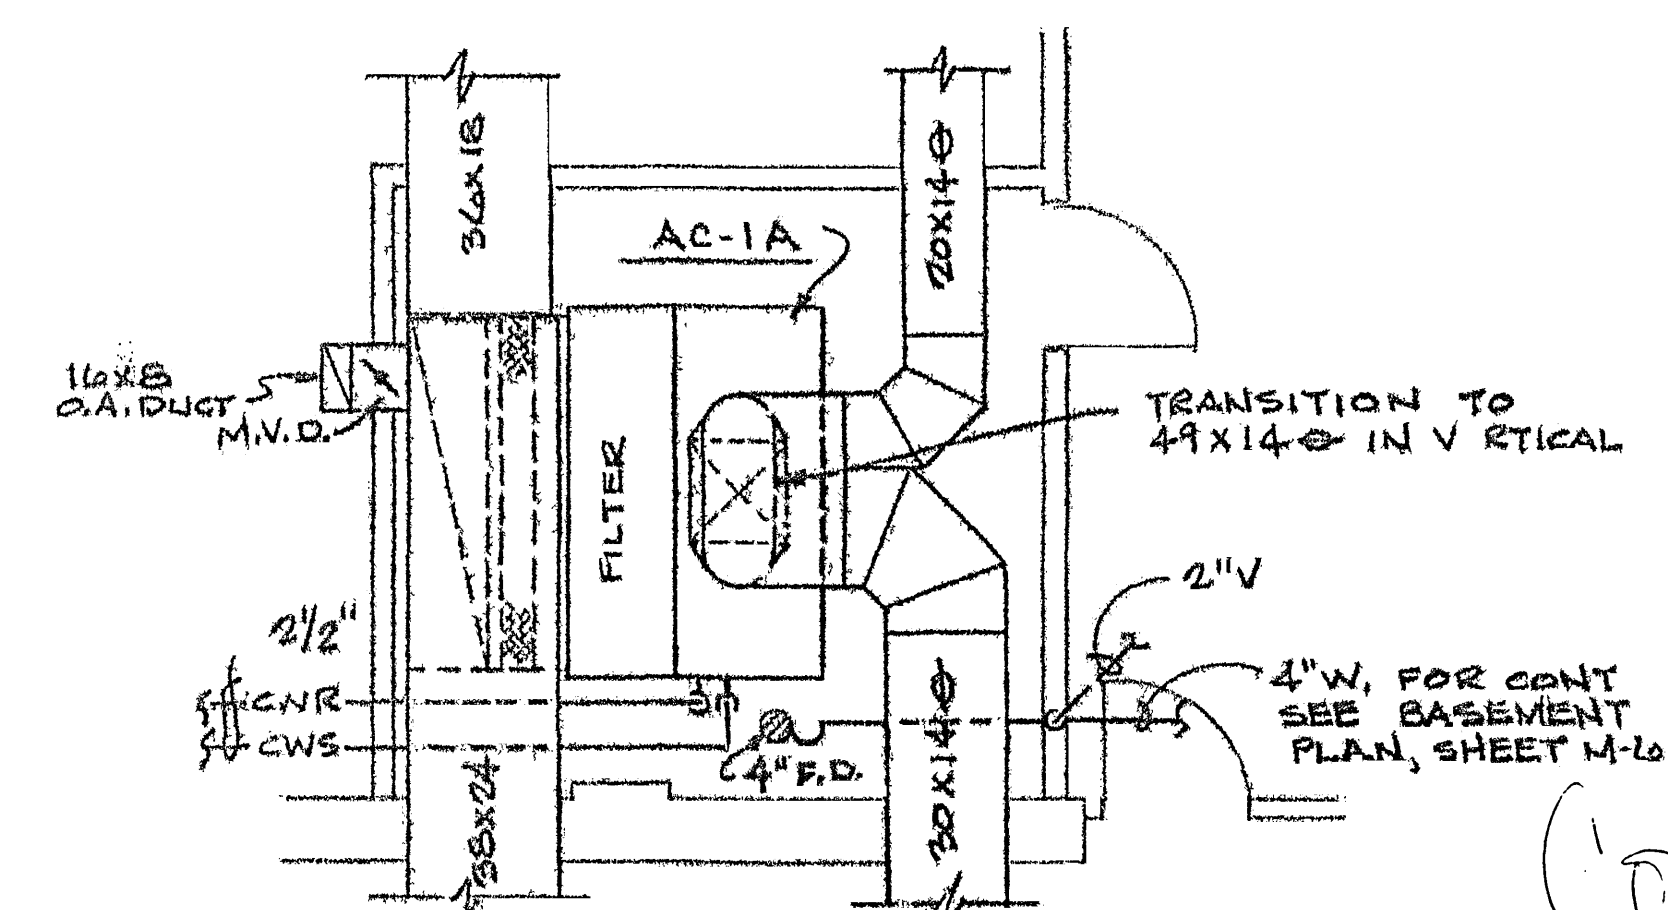

EQUIPMENT ROOM PLAN

SCALE: 1/4" = 1'-0"

LEGEND

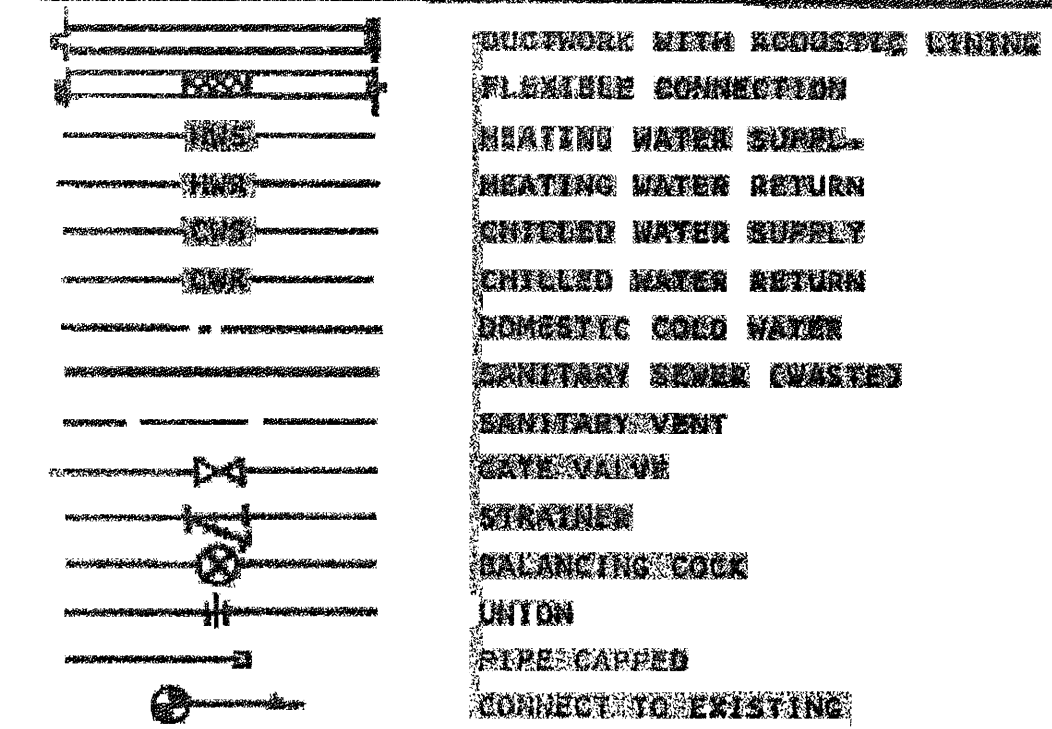

|      |                  |      |             |
|------|------------------|------|-------------|
| ABV. | ABOVE            | FDN. | FLOOR DRAIN |
| CEV. | CEILING          | FR.  | FROM        |
| CD.  | CEILING DIFFUSER | FR.  | FROM        |
| C.O. | CLEAN OUT        | FR.  | FROM        |
| Φ    | CUSTOMER/MINUTE  | FR.  | FROM        |
| DN.  | DOWN             | FR.  | FROM        |
| Φ    | FLAT OVAL DUCT   | FR.  | FROM        |
| FL.  | FLOOR            | FR.  | FROM        |

RENOVATIONS & ALTERATIONS TO


COULTER BLDG. & NATL BLDG. CO.

JEFFERSON ST. AT FRANKLIN RD.

CHARLES D. KEEFER, II

Consulting Engineer

Roanoke, Virginia

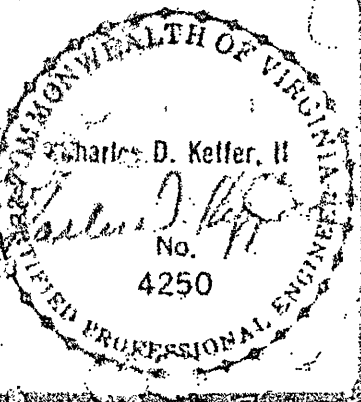

JULY 25, 1986

86-05

M-1  
of 6

Coulter 4/2001  
Mechanical  
Print