



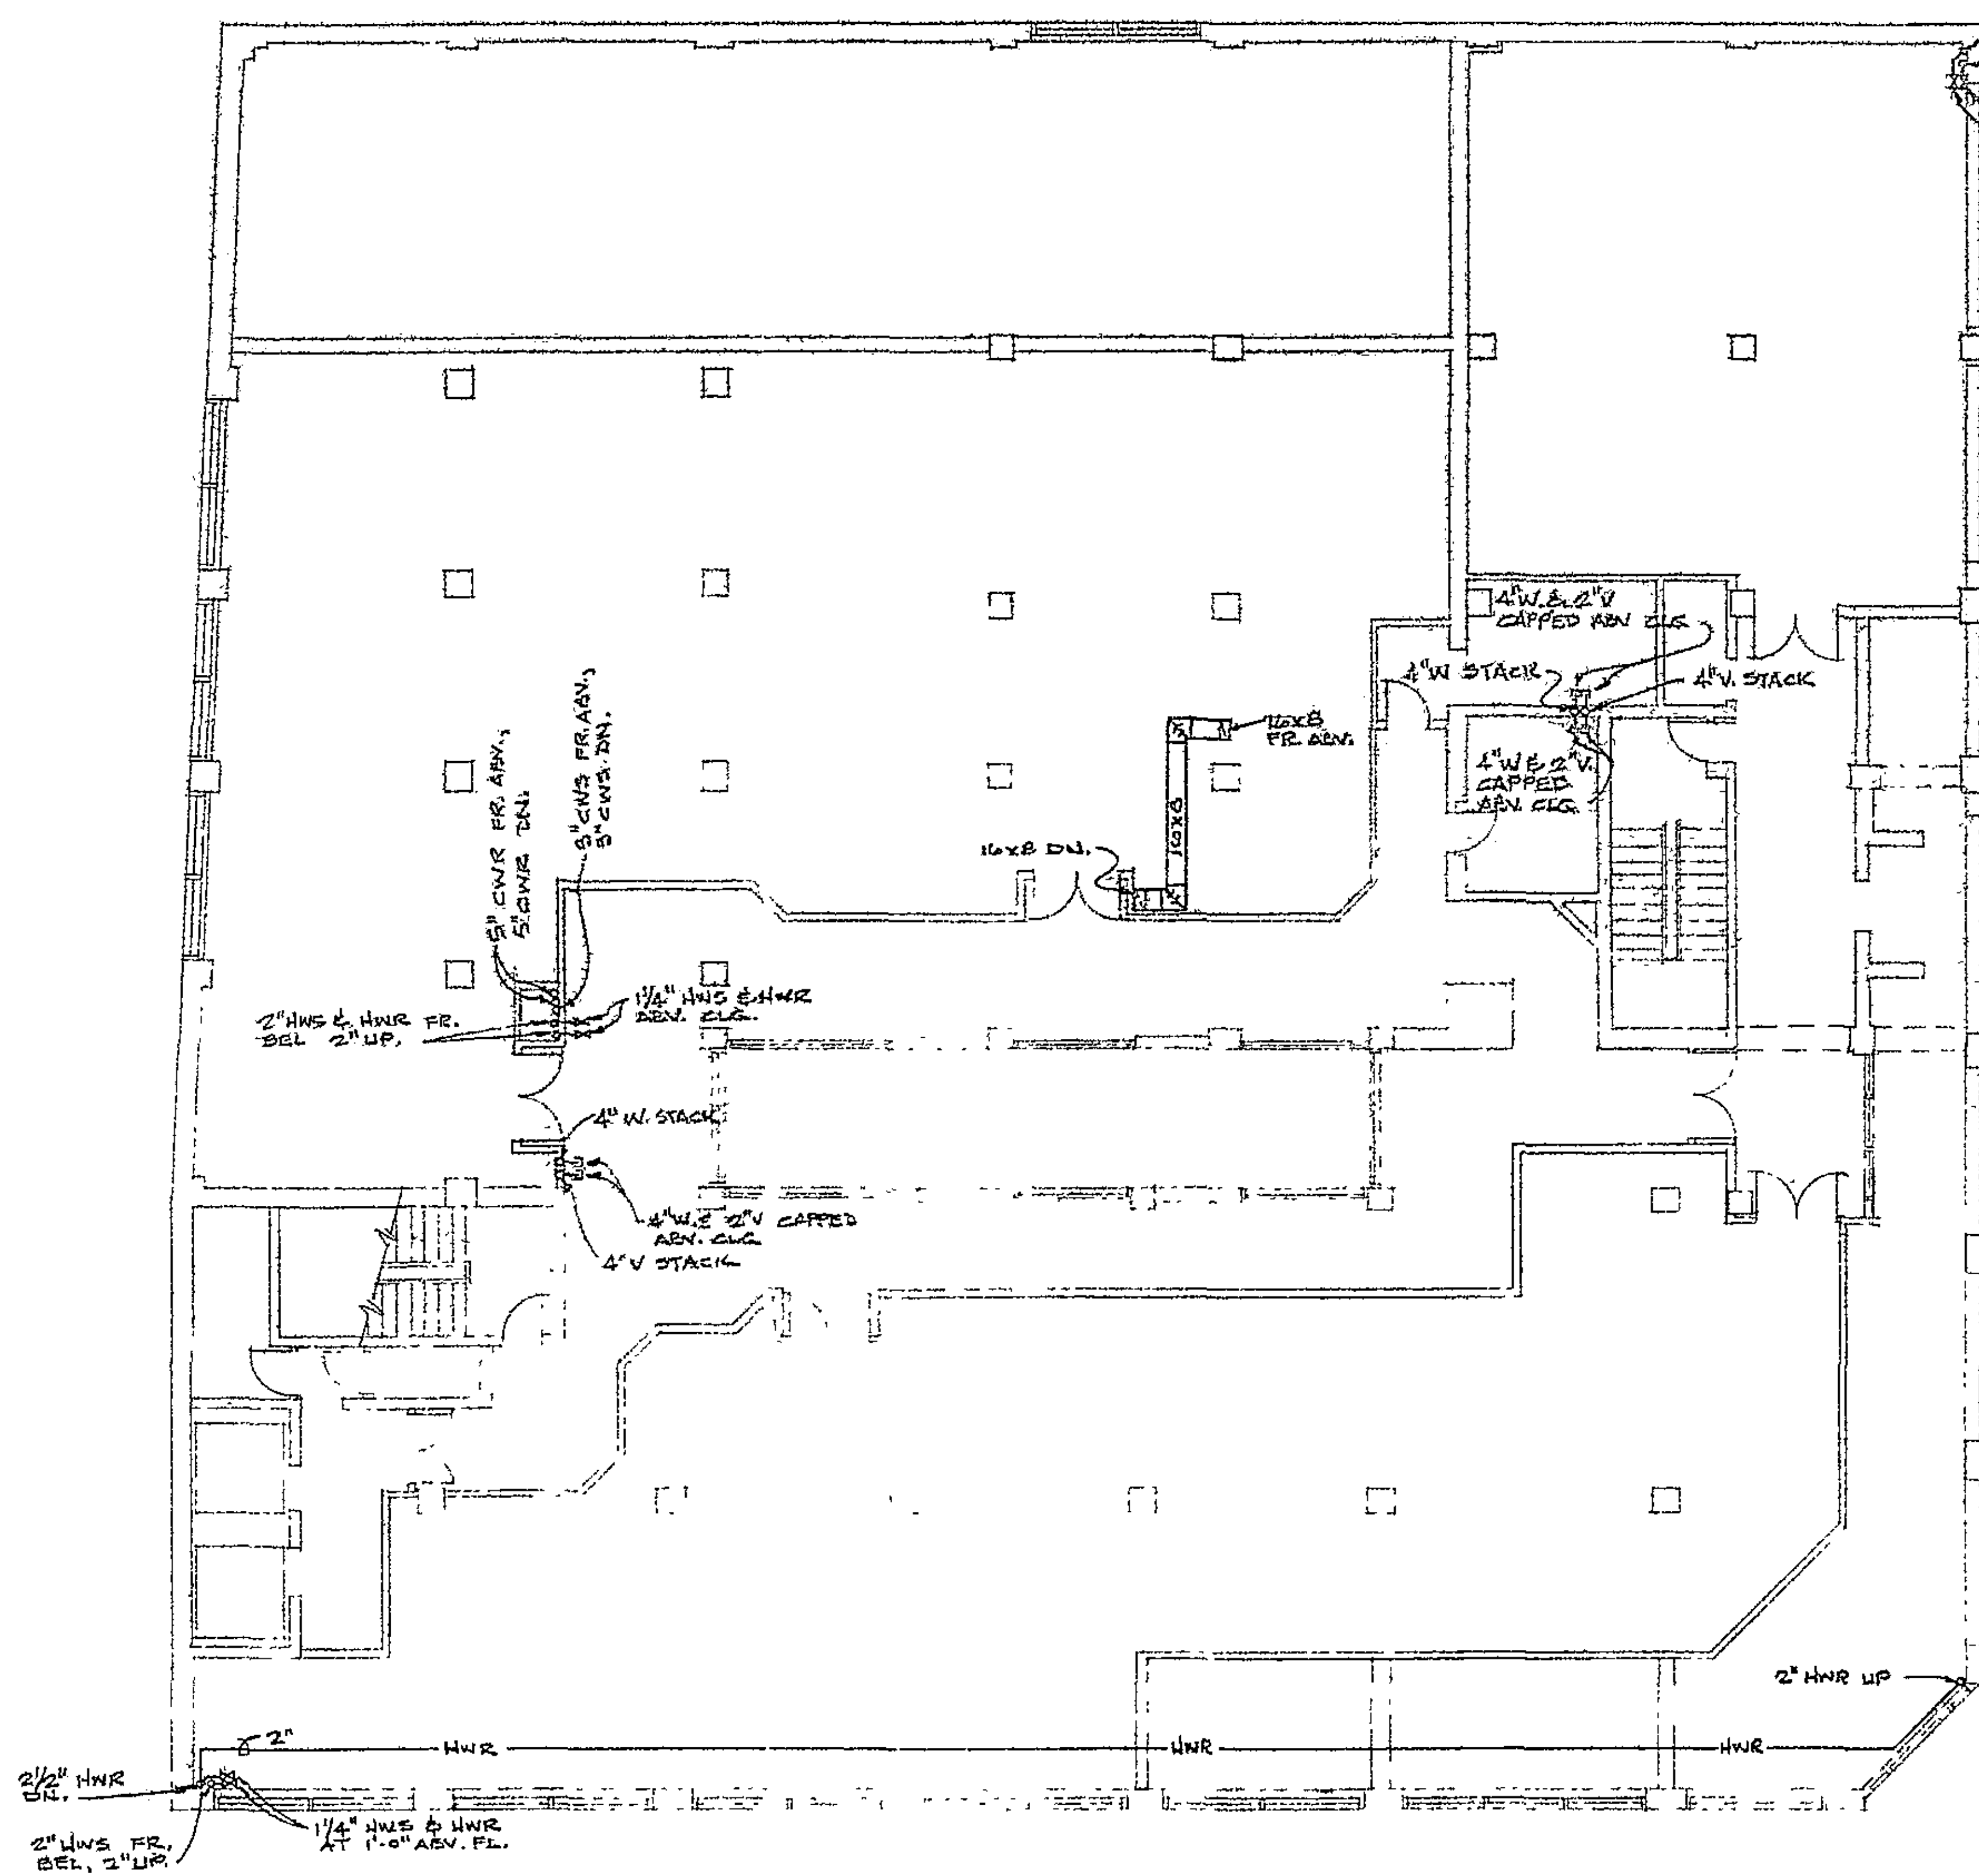


SECOND FLOOR PLAN


SCALE: 1/8" = 1'-0"

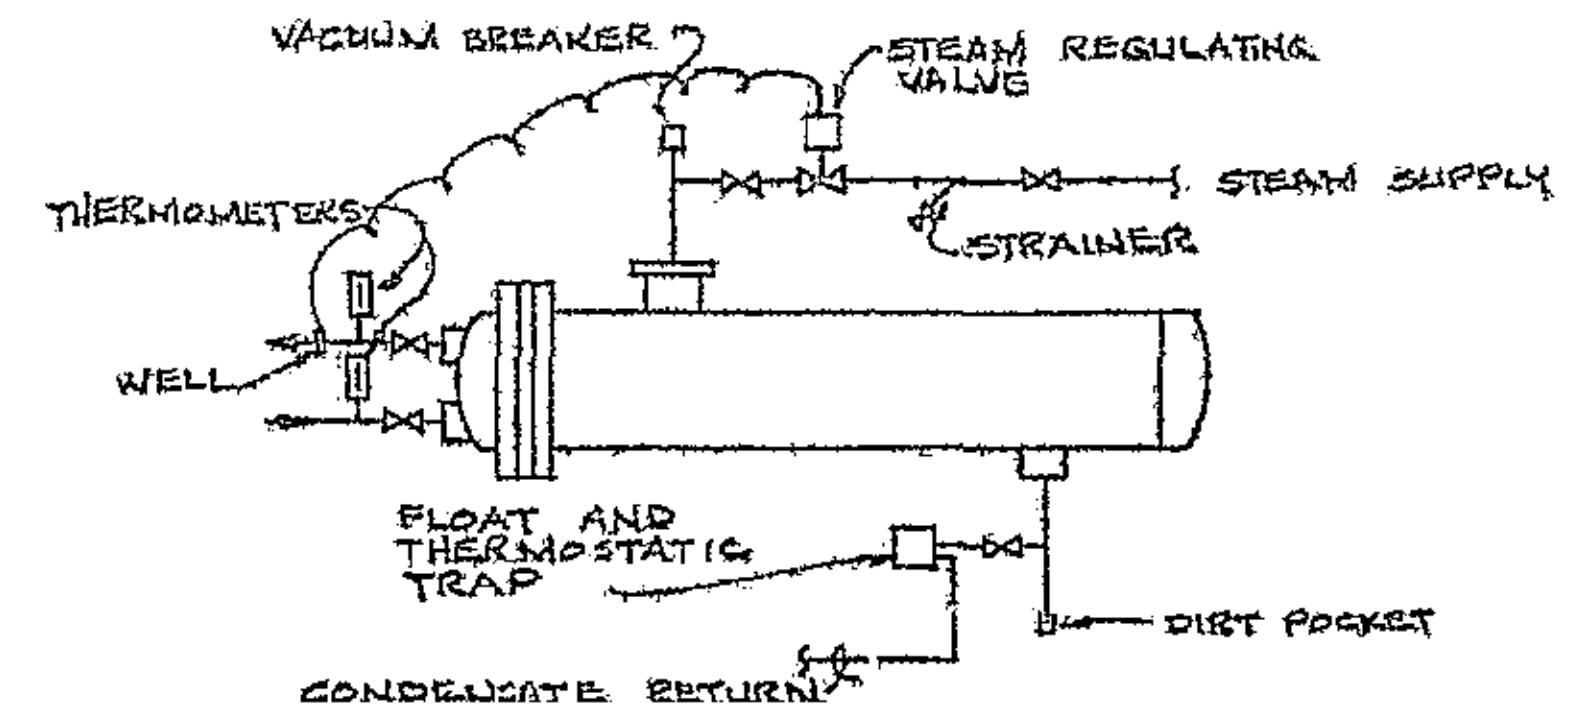

CONVERTER CONNECTION DETAIL  
SCHEMATIC

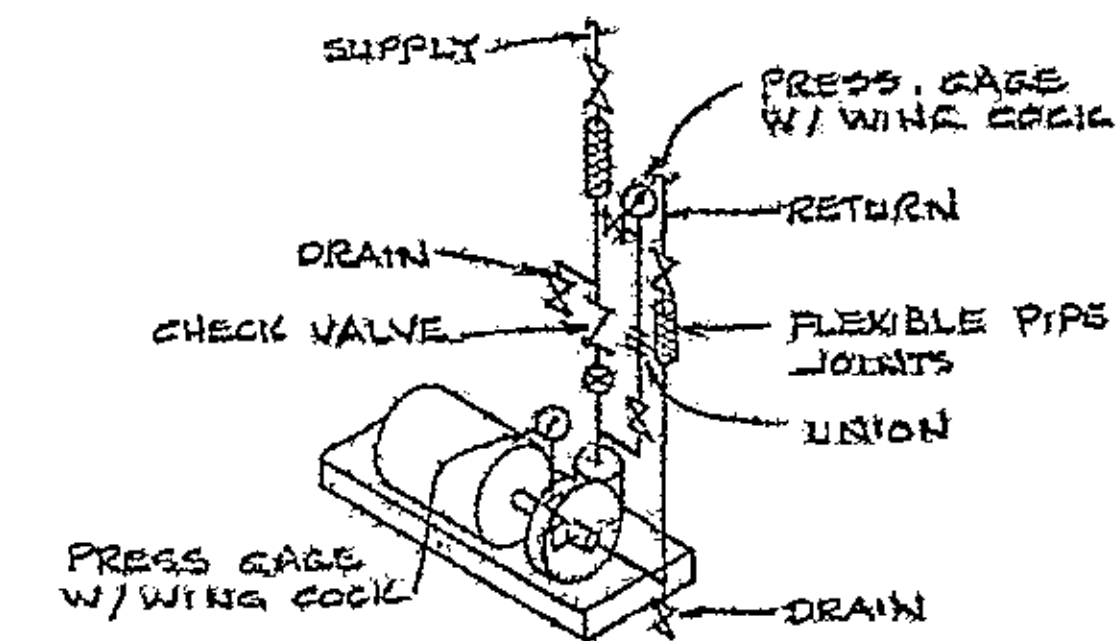

PUMP CONNECTION DETAIL  
SCHEMATIC

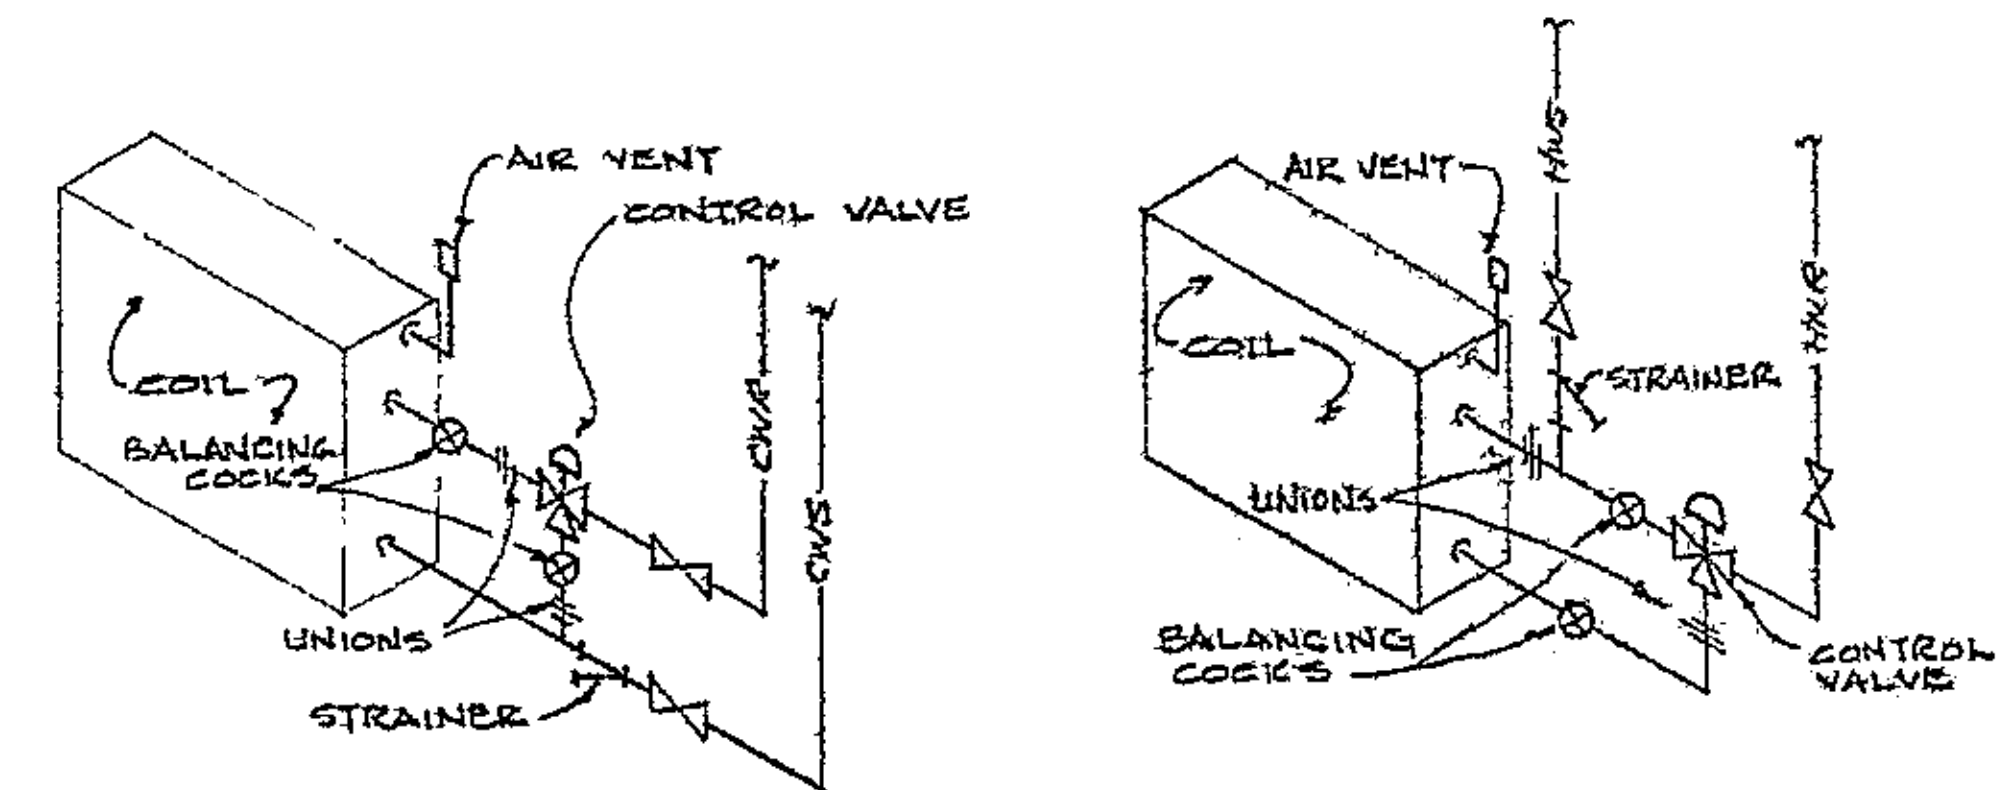


COIL CONNECTION DETAILS  
SCHEMATIC

| REVISION/ | BY |
|-----------|----|
|           |    |
|           |    |
|           |    |
|           |    |
|           |    |
|           |    |
|           |    |

RENOVATIONS & ALTERATIONS TO  
COULTER BLDG & NATL. BUS. COL. BLDG  
JEFFERSON ST. AT FRANKLIN RD. ROANOKE VIRGINIA

CHARLES D. KEEFER, II  
Consulting Engineer  
Roanoke, Virginia

MECHANICAL SECOND FLOOR PLAN

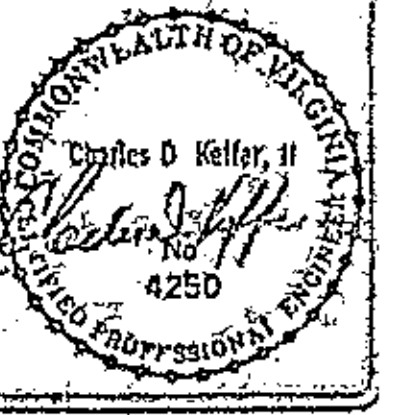

|         |               |
|---------|---------------|
| DRAWN   | CUD/CDK       |
| CHECKED | CDK           |
| DATE    | JULY 25, 1986 |
| SCALE   | AS NOTED      |
| NO. NO. | 86-05         |
| SHEET   | ONE           |
| M-2     |               |
| OF      | 6 SHEETS      |