


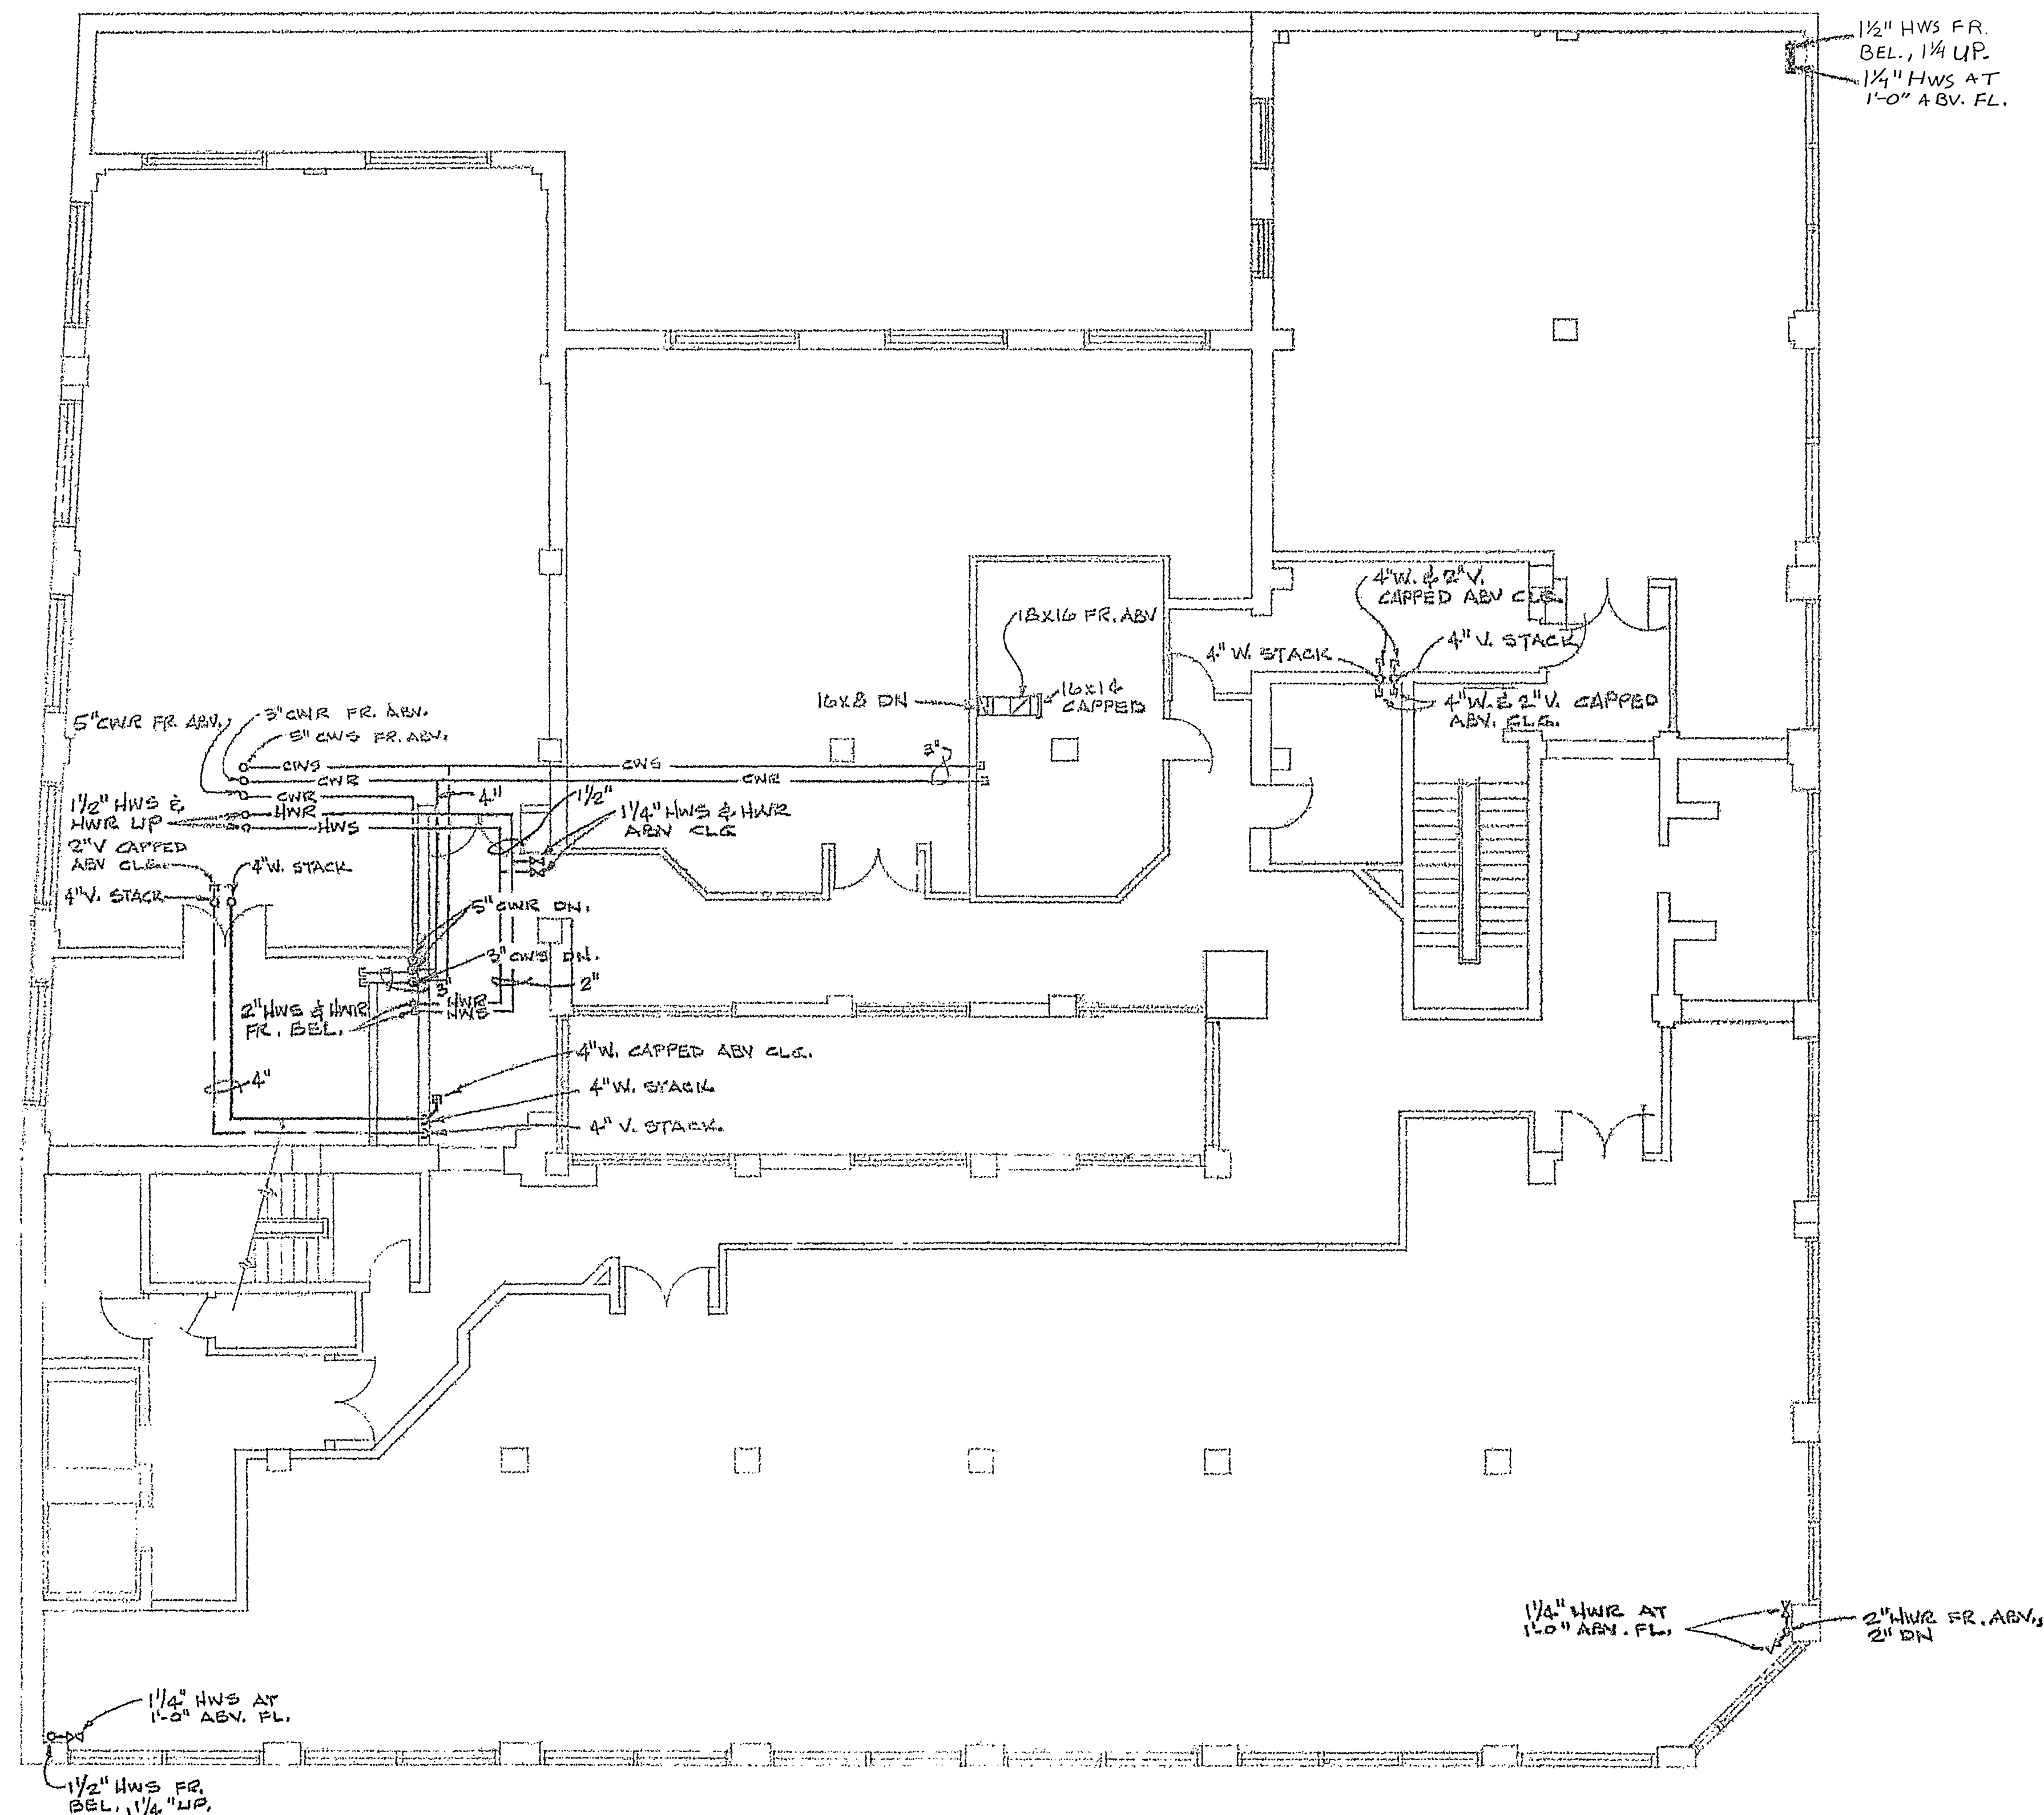


THIRD FLOOR PLAN
SCALE: 1/8" = 1'-0"

REVISION	BY

RENOVATIONS & ALTERATIONS TO
COULTER BLDG & NAT'L BUS. COL. BLDG
 JEFFERSON ST. AT FRANKLIN RD. ROANOKE, VIRGINIA

CHARLES D. KEEFER, II
 Consulting Engineer
 Roanoke, Virginia

MECHANICAL - THIRD FLOOR PLAN

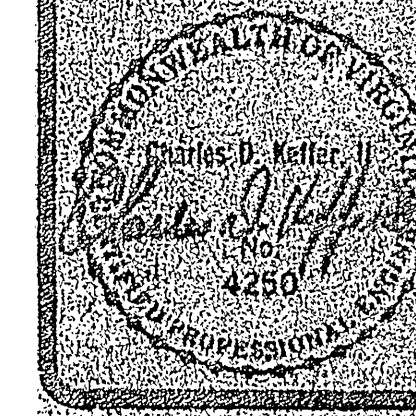

DRAWN CJD/CDV
CHECKED CJD
DATE JULY 25, 1986
SCALE AS NOTED
JOB NO. 86-05
SHEET M-3
OF 7 SHEETS