


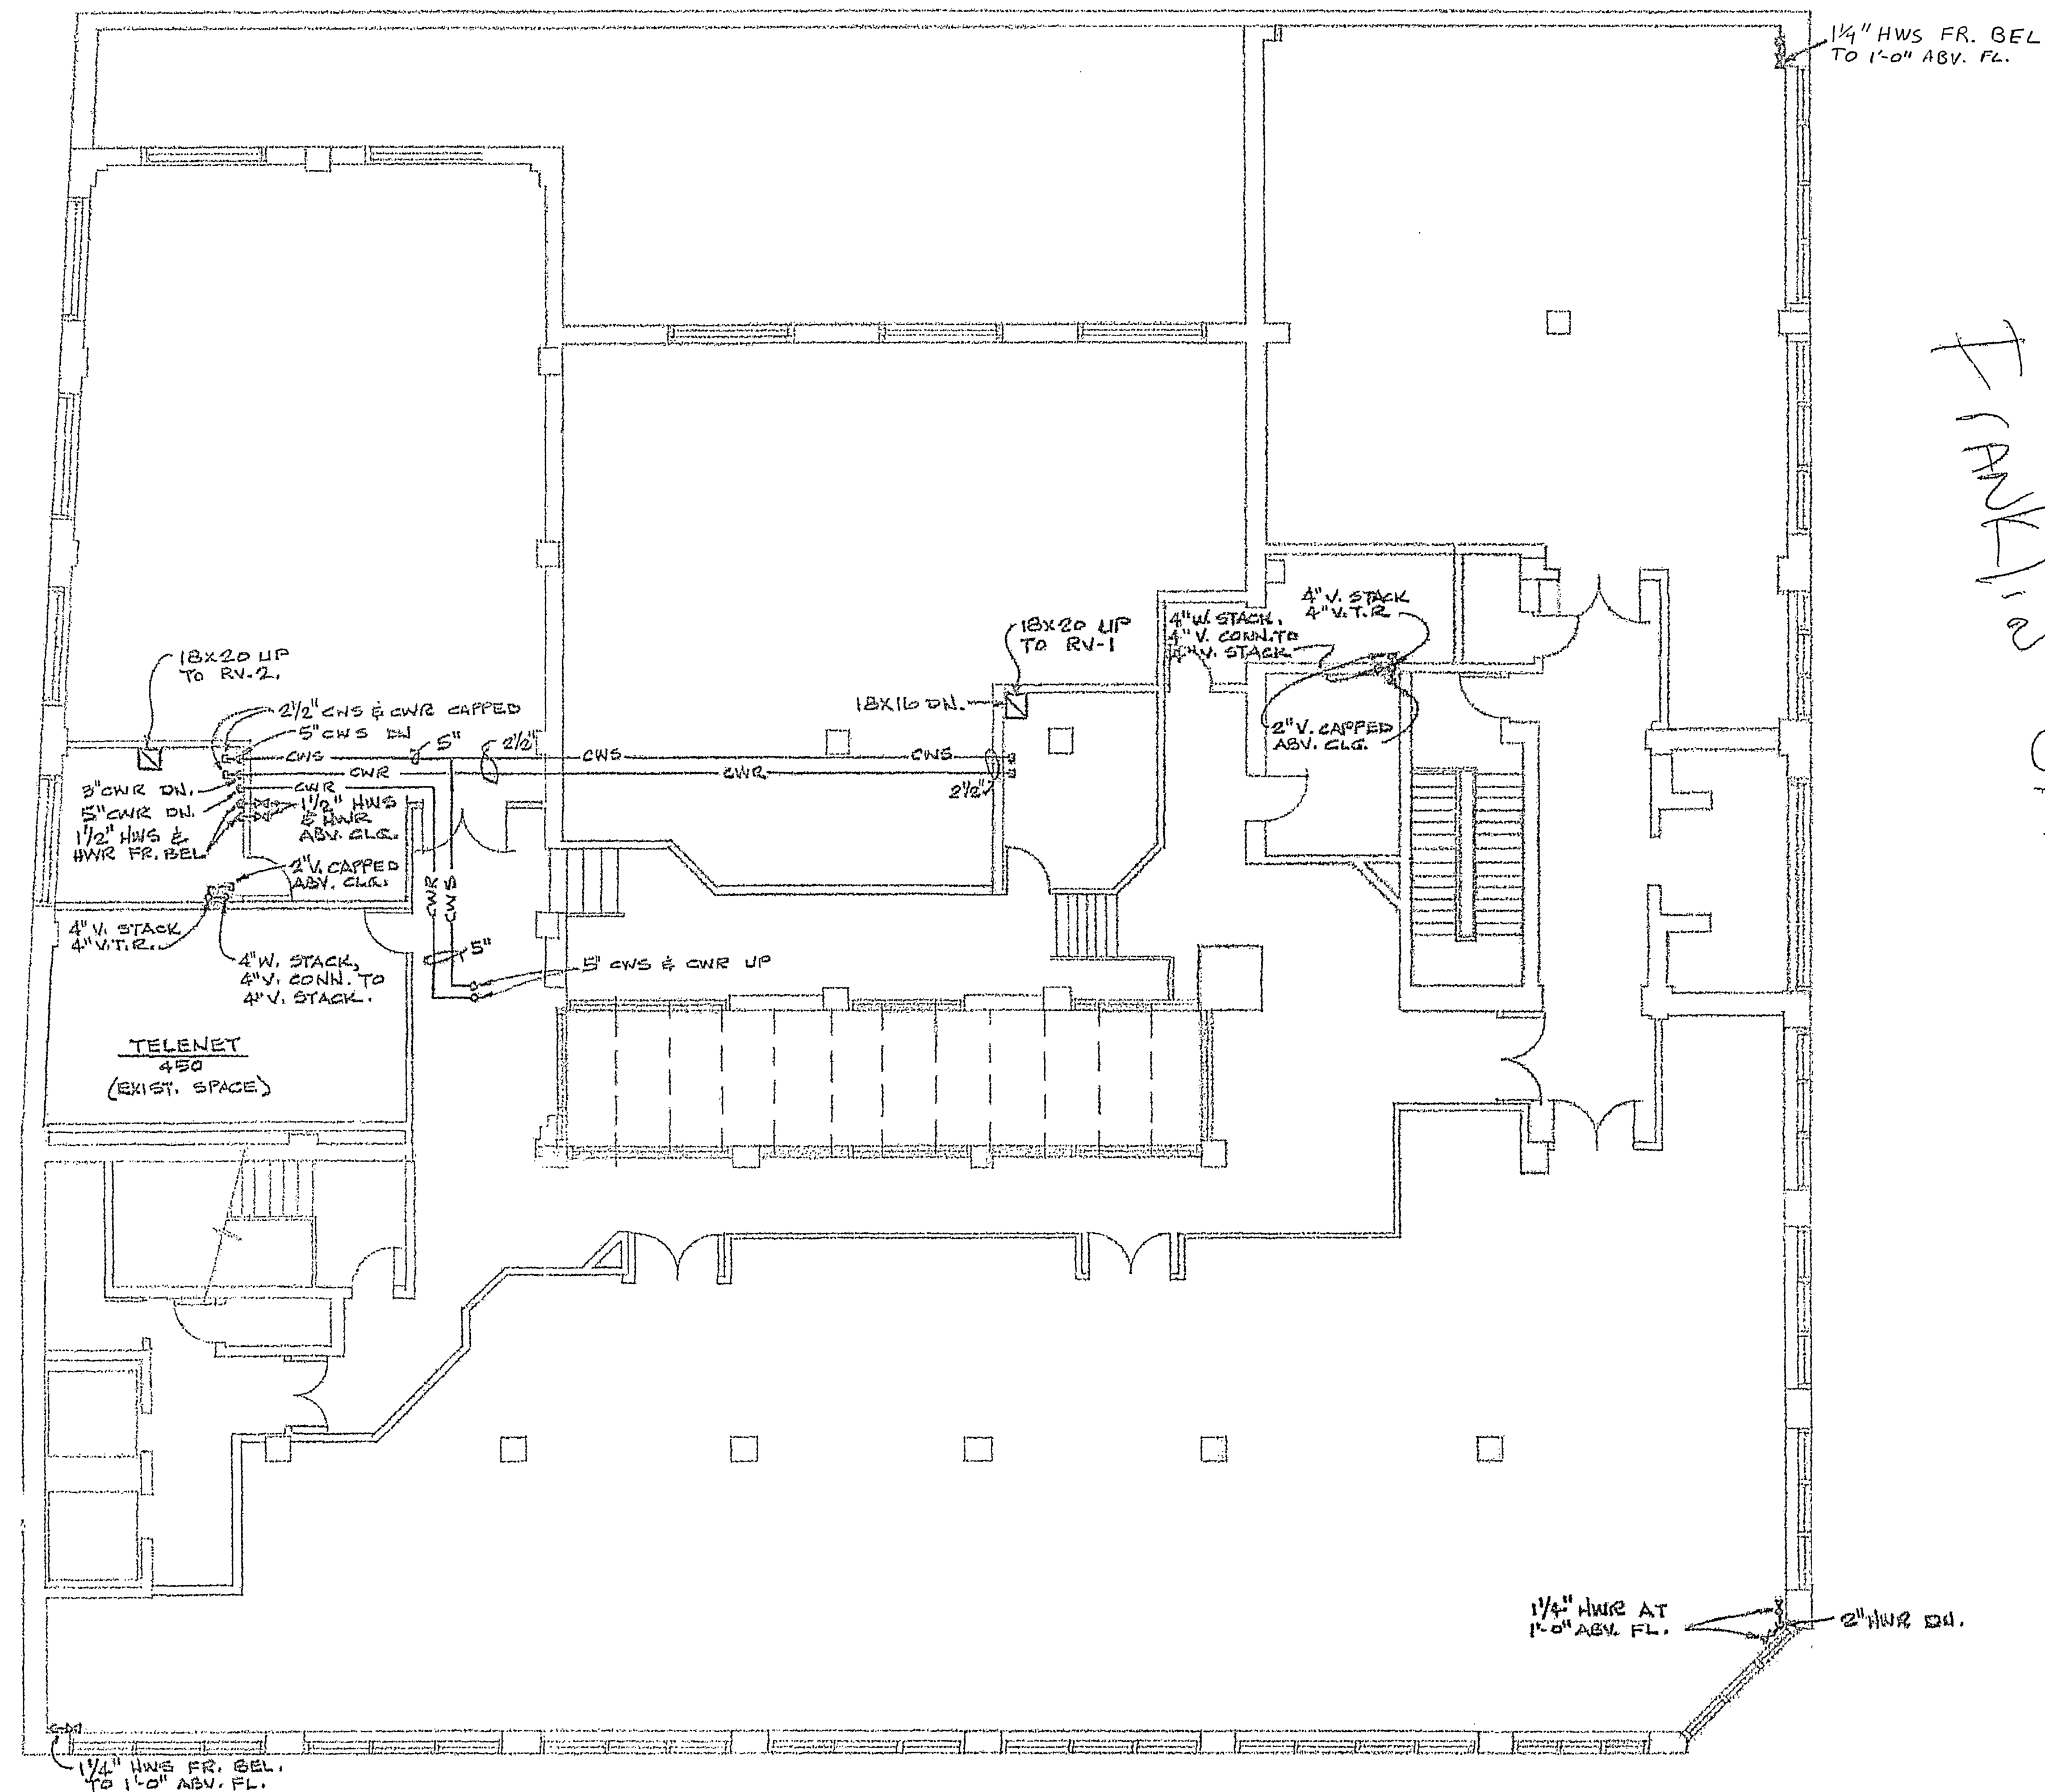

FOURTH FLOOR PLAN
SCALE: 1/8" = 1'-0"


Jefferson St.

Franklin St.

REVISIONS	BY

CHARLES D. KEEFER, JR.
Consulting Engineer
Roanoke, Virginia
MECHANICAL - FLOOR PLAN

RENOVATIONS & ALTERATIONS TO
COULTER BLDG. & NATL. BUS. COL. BLDG.
JEFFERSON ST. AT FRANKLIN RD. ROANOKE, VIRGINIA

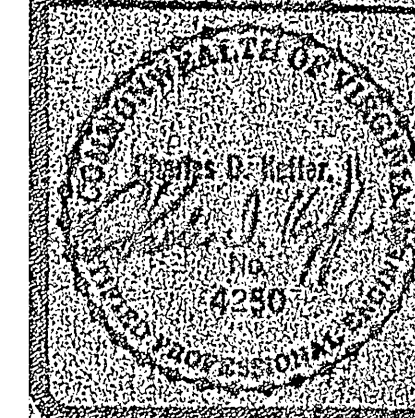

DRAWN	OLD/SPC
CHECKED	SPC
DATE	JULY 25, 1986
SCALE	AS NOTED
JOB NO.	86-06
SHEET	M-4
OF	6 SHEETS