


#5 Needs Board 605
#7 Needs Board 605

12x8
10

3rd Floor Outline

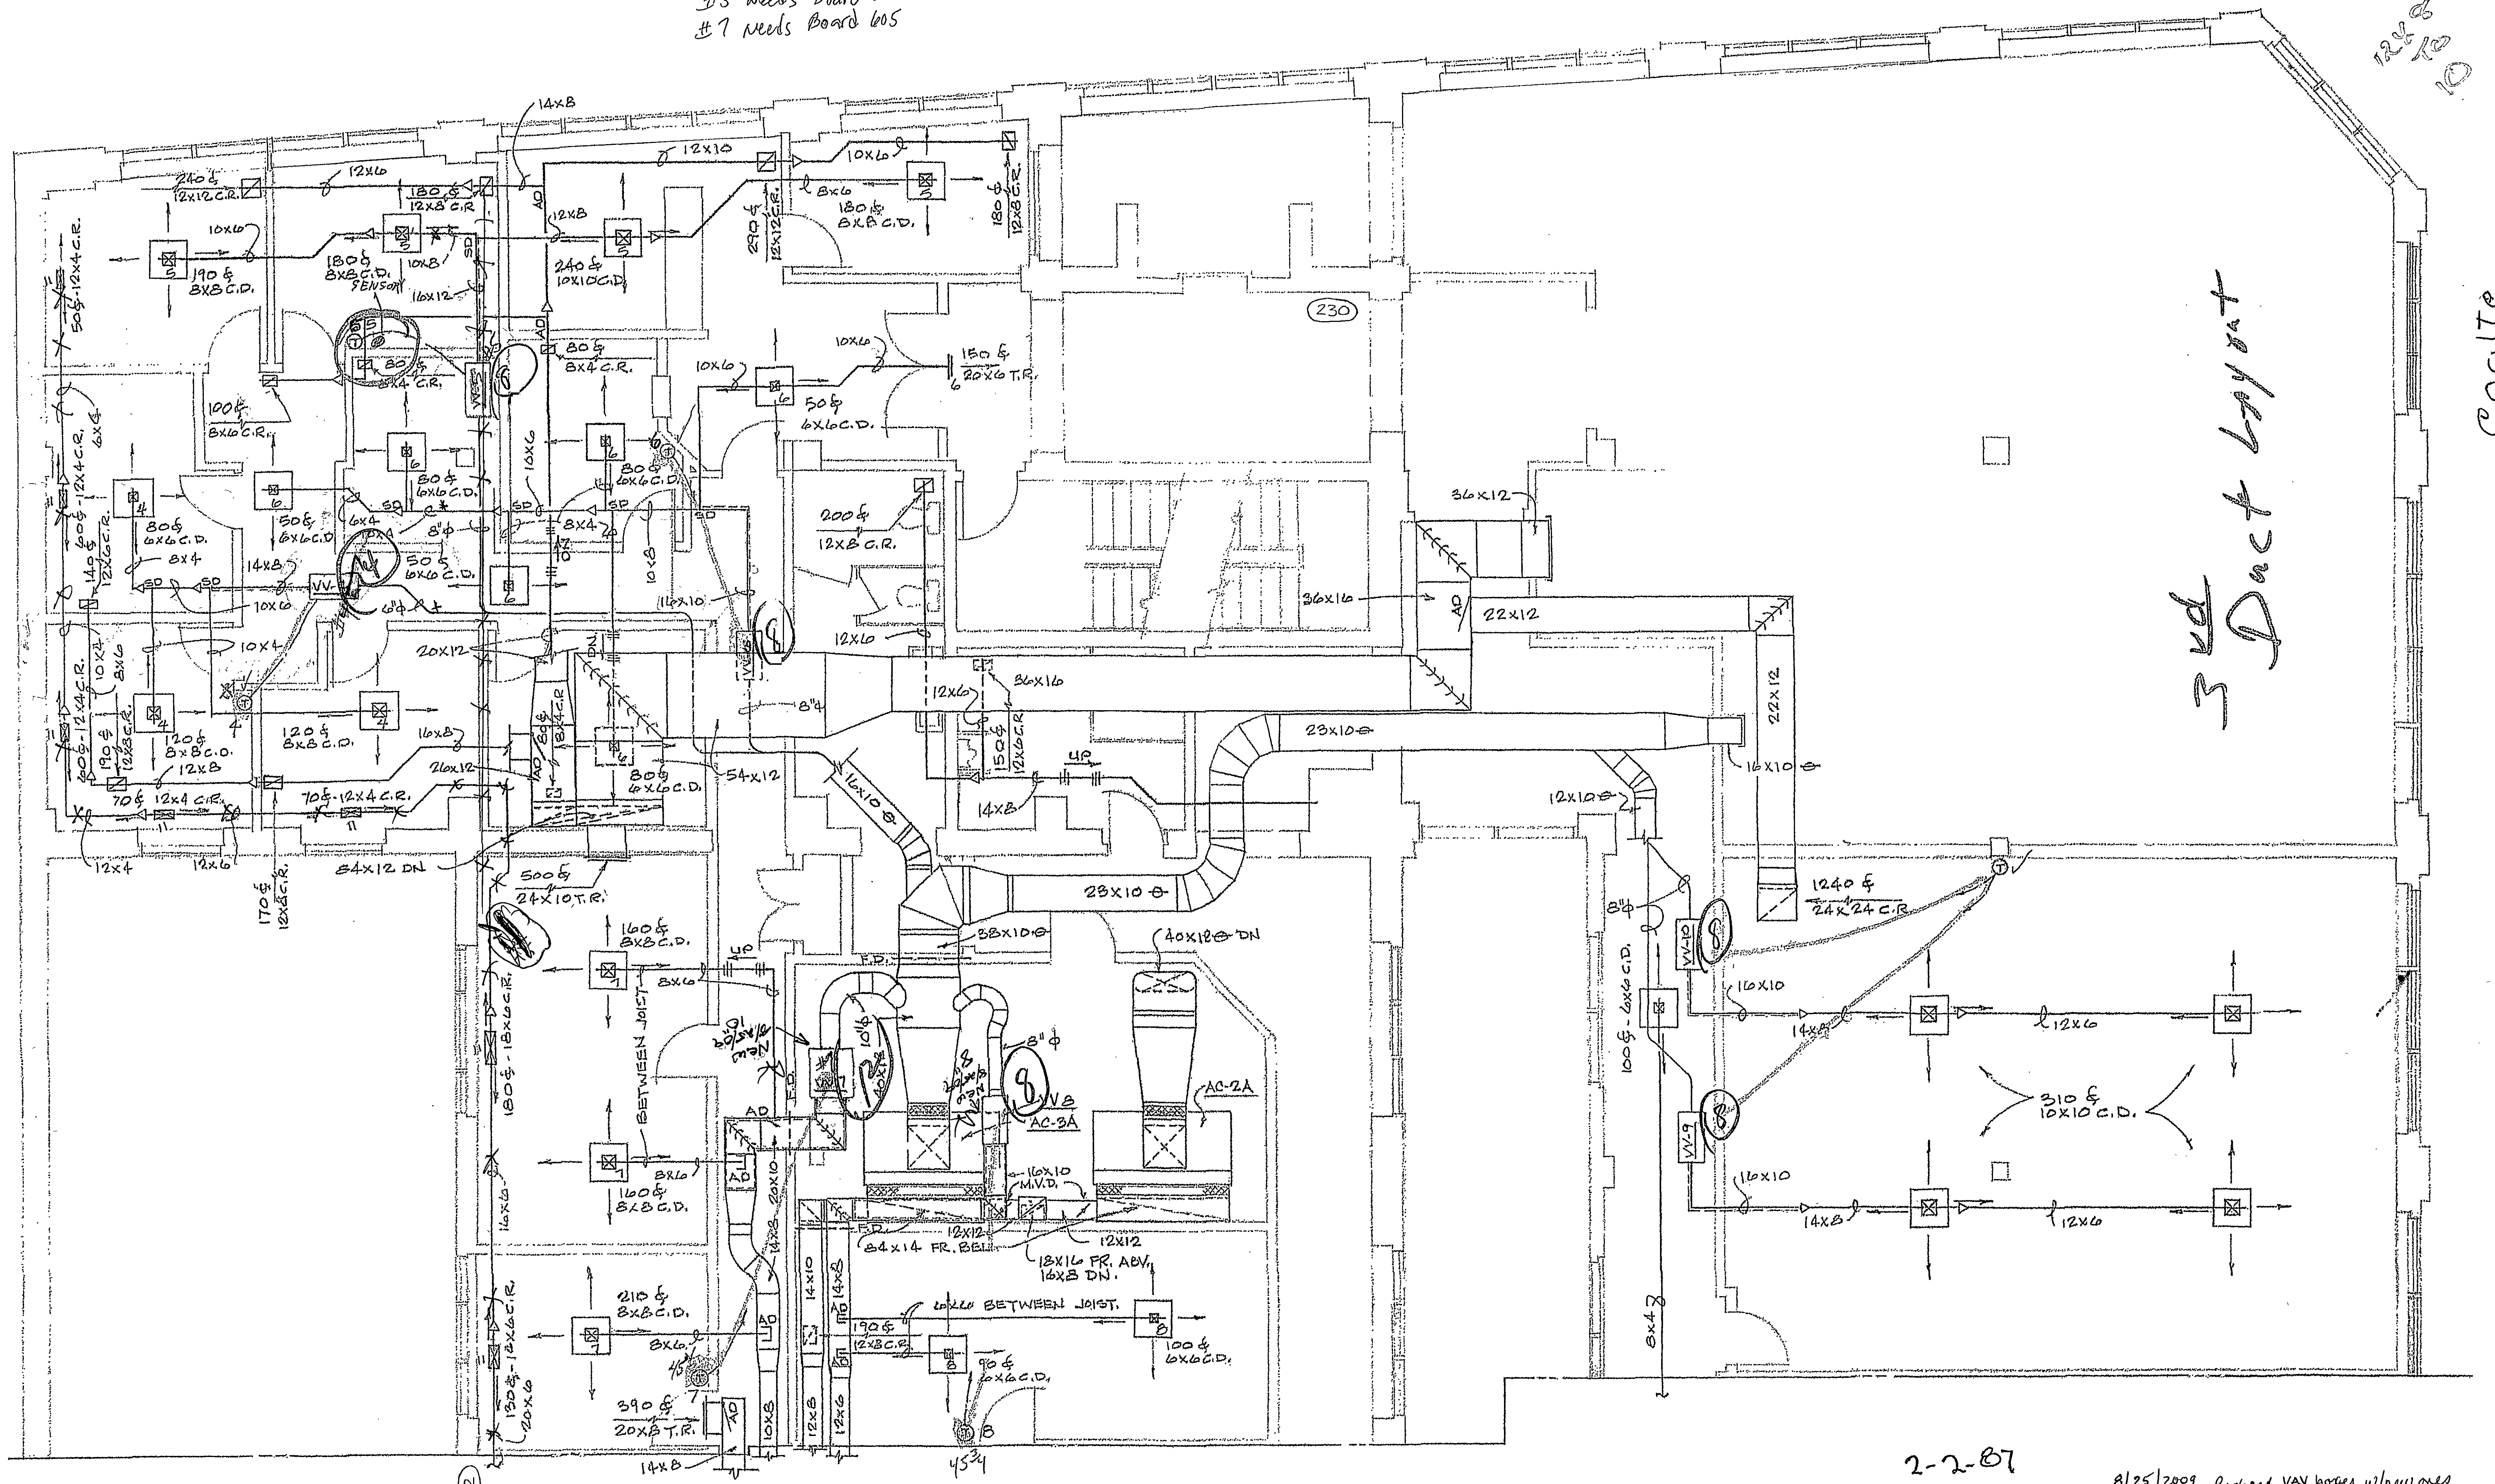

THIRD FLOOR PLAN - NORTH
SCALE: 1/4" = 1'-0"

2-2-07

8/25/2009 Replace VAN boxes w/new ones
Return Heat to back office

CHARLES D. KEEFER, II - CONSULTING ENGINEER Roanoke, Virginia	
RENOVATION & ALTERATIONS TO COUNTER BLDG. & NATL. BUSINESS COL. JEFFERSON ST. AT FRANKLIN RD., ROANOKE, VA.	DATE 9 JAN 07
MARTIN BROS. CONTRACTORS, INC. ROANOKE, VIRGINIA	SHEET M-3A

DUCTWORK-HVAC