


#11 Actuator MA-5213-00-2
#12 New VAV Box
#13 12" Box Electric Air Valve
Hot Water 3 Way Valve 3/4"

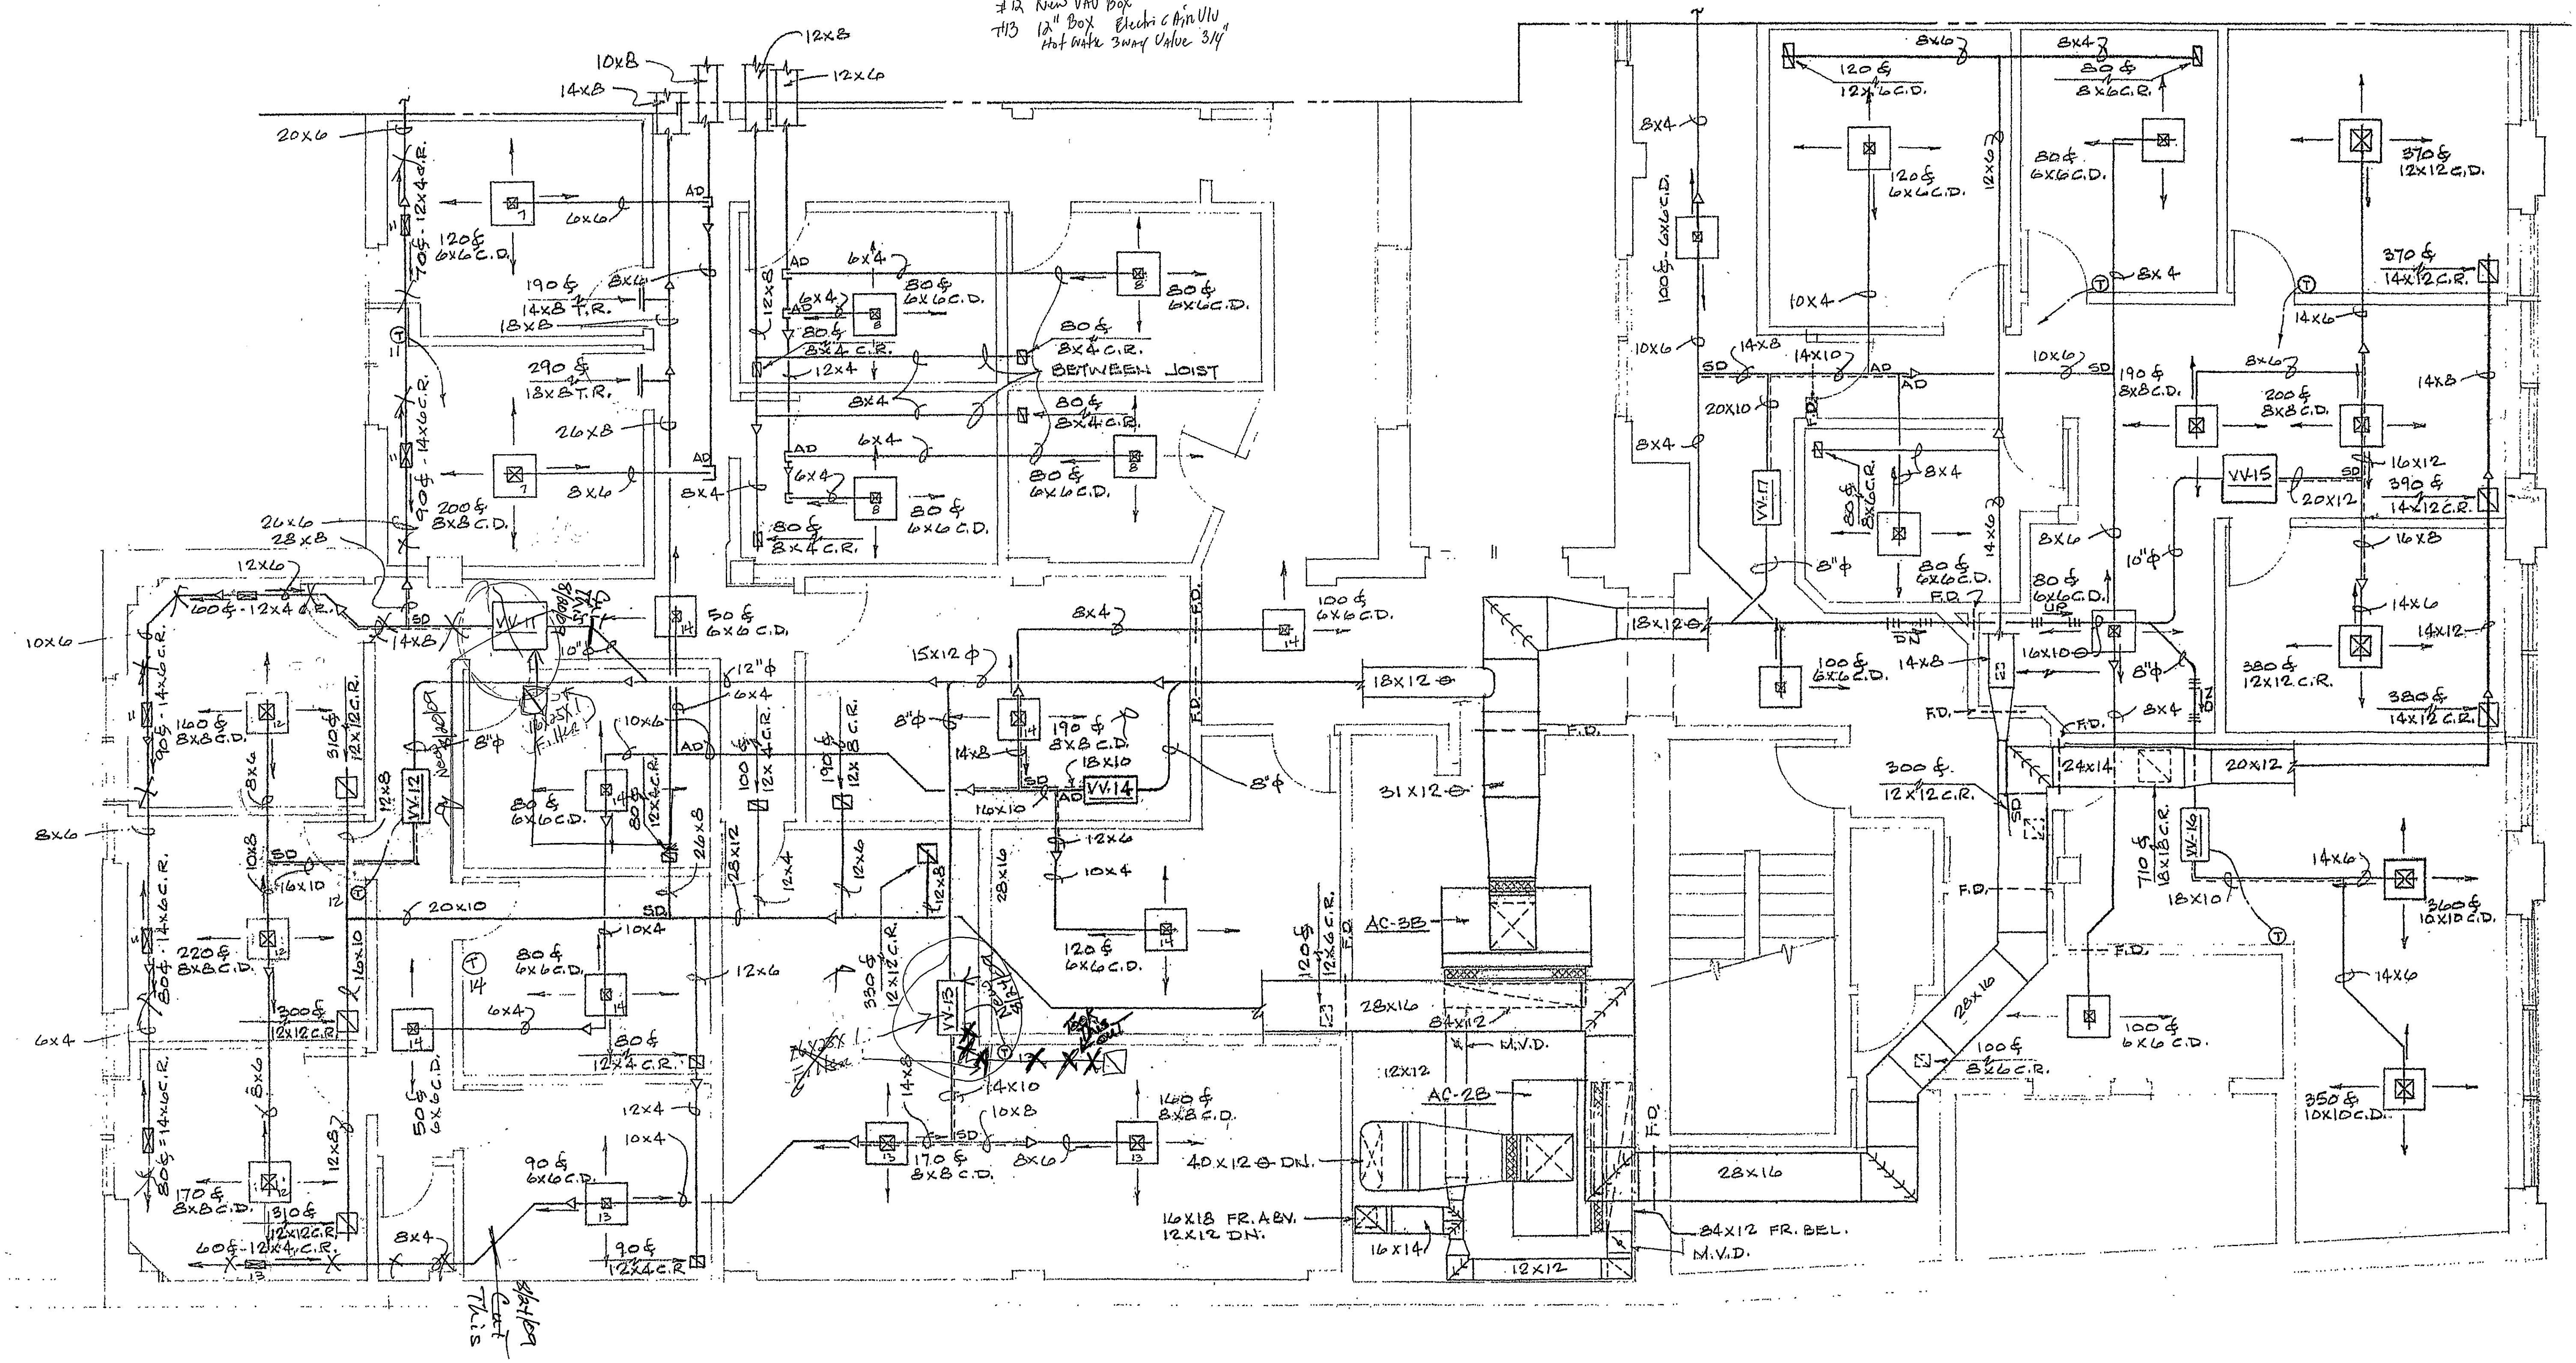

THIRD FLOOR PLAN - SOUTH
SCALE: 1/4" = 1'-0"

8/25/2009 - replaced VAV Boxes w/new ones provide heat to back office
REVISED - 9 FEB '87 - FIRE DAMPERS & DELETE RET. DUCT AD'S.

CHARLES D. KEEFER, II - CONSULTING ENGINEER Roanoke, Virginia	
RENOVATION & ALTERATIONS TO COUNTER BLDG. & NATL. BUSINESS COL. JEFFERSON ST. AT FRANKLIN RD., ROANOKE, VA.	
DATE 30 JAN 87	
MARTIN BROS. CONTRACTORS, INC. ROANOKE, VIRGINIA	SHEET M-3B