


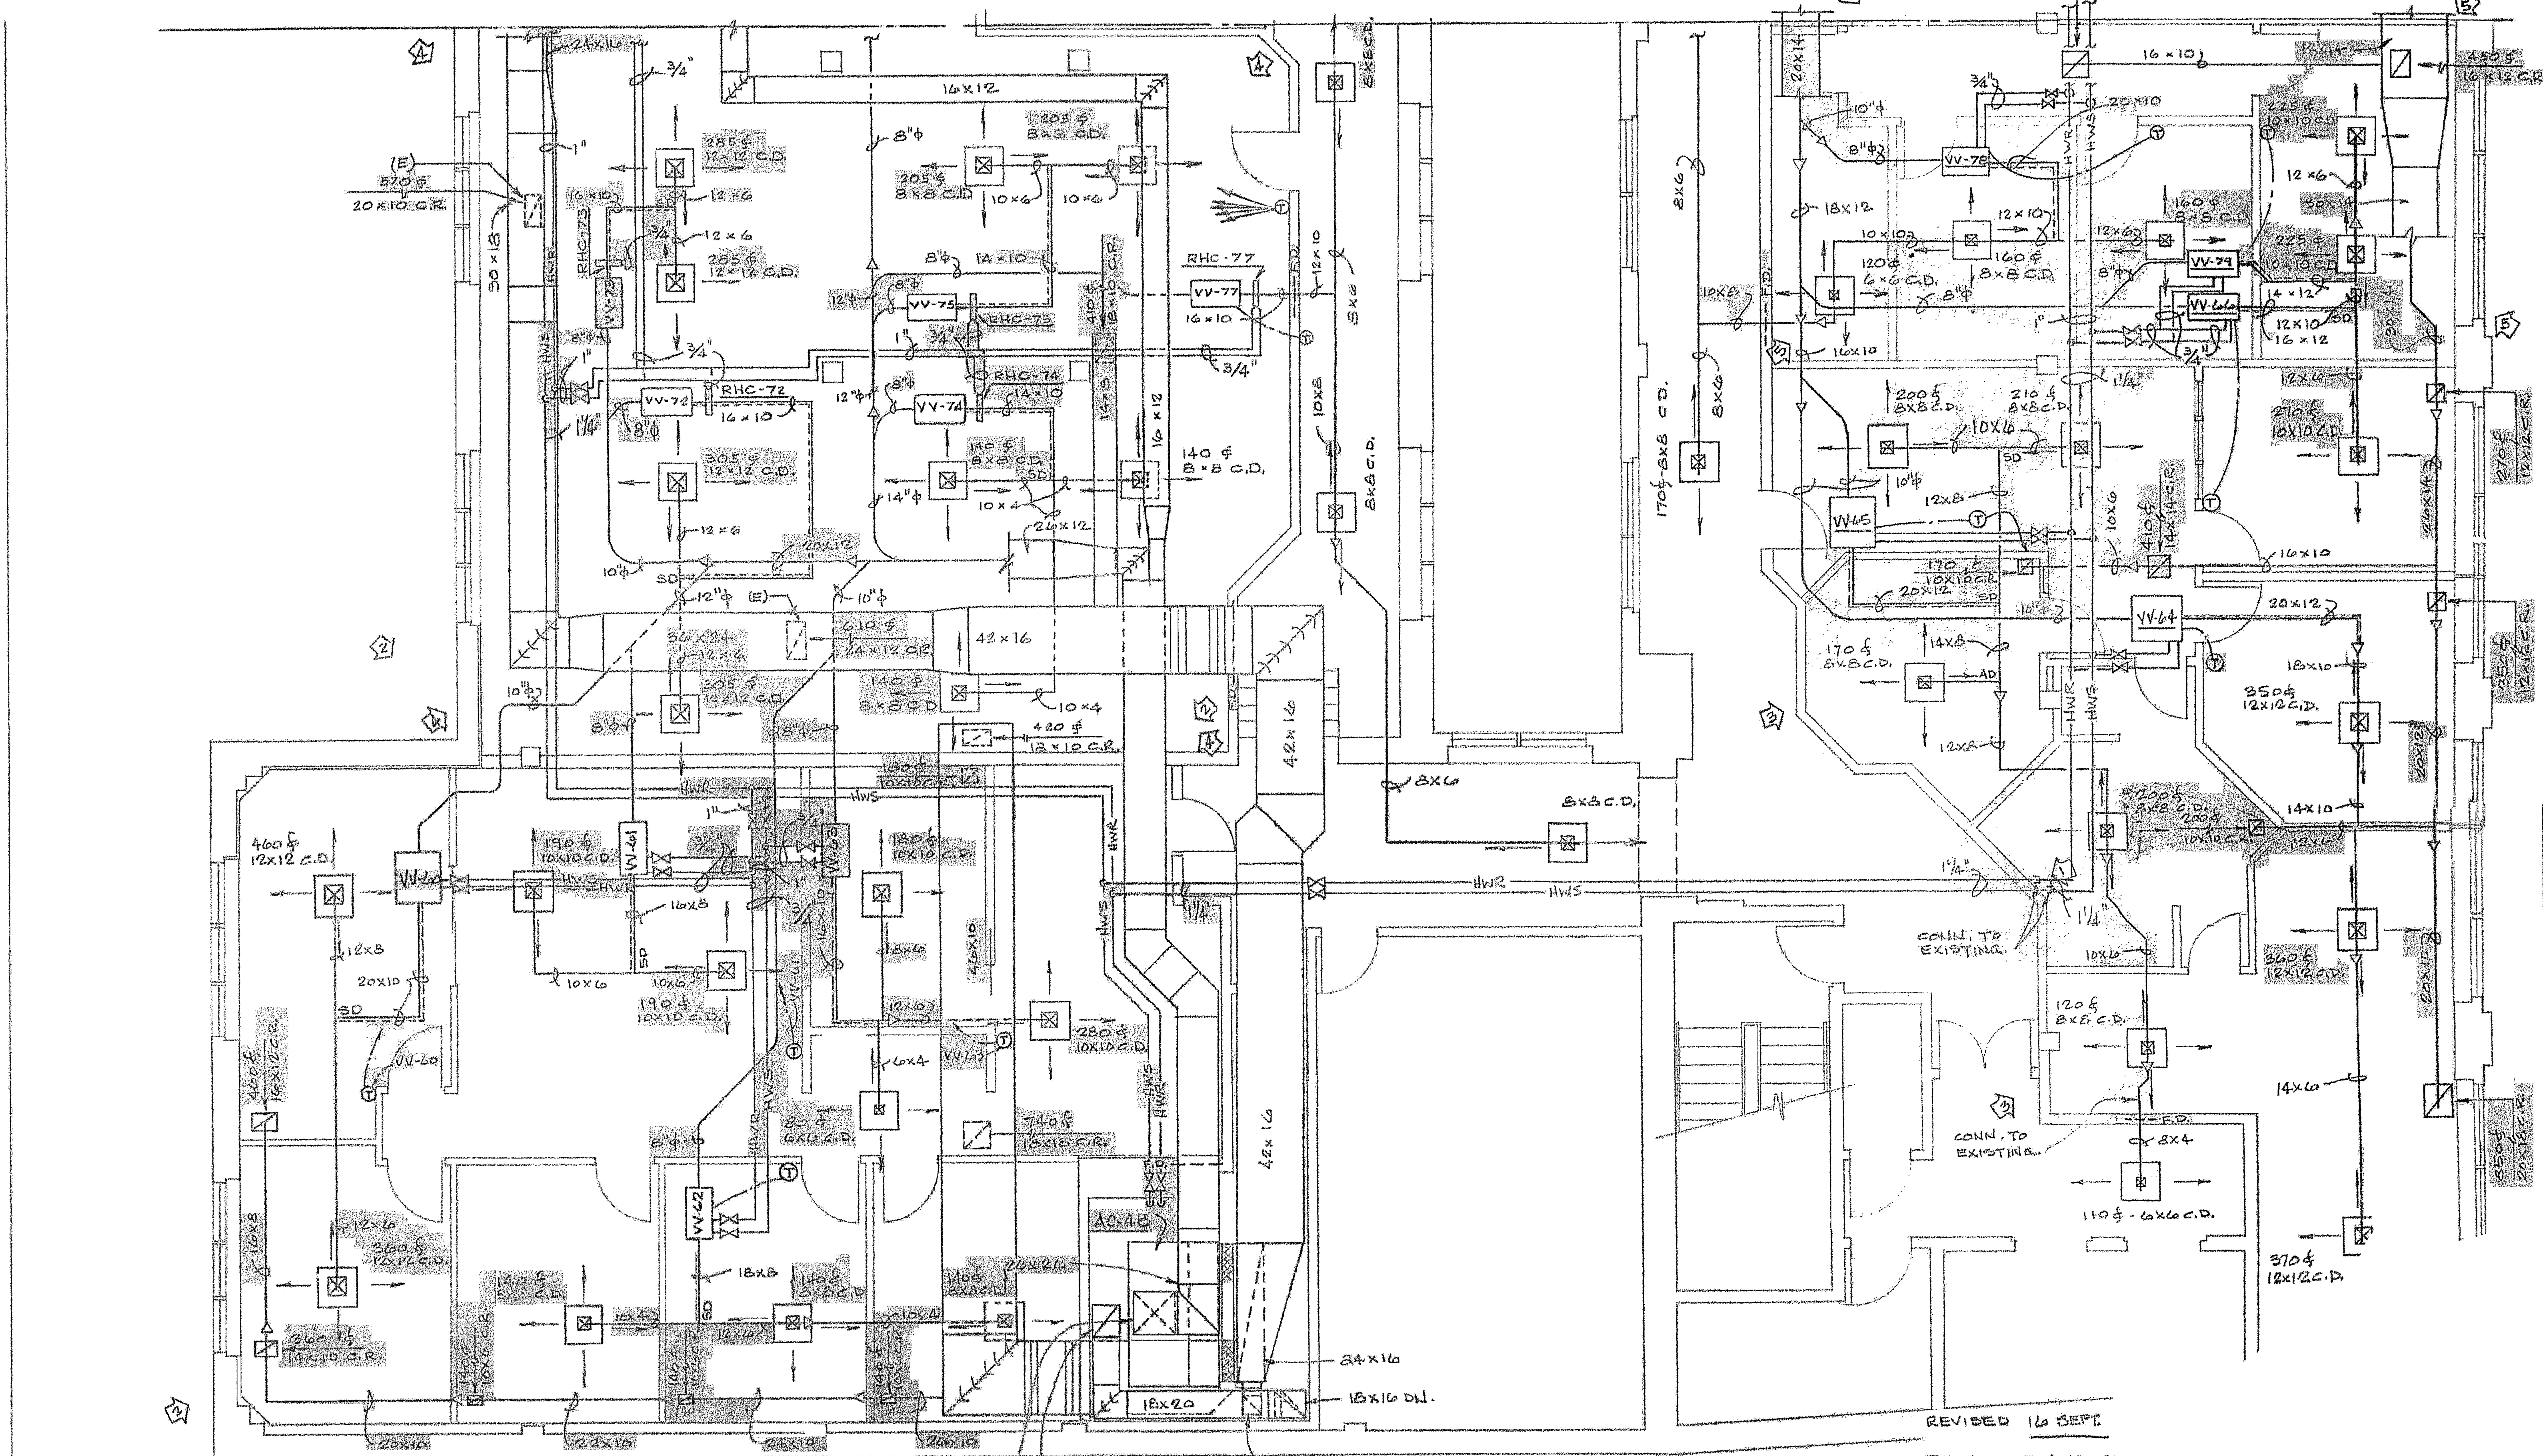

FOURTH FLOOR PLAN - SOUTH

SCALE: 1/4" = 1'-0"

VARIABLE VOLUME BOX SCHEDULE

MARK	CAP. C.F.M.	HEAT CAP. M.B.H.	HEAT WATER G.P.M.	RUNDUTS	MODEL NO.
VV-60	820	23.0	2.5	3/4"	VCWC-12
VV-61	380	10.0	1.0	3/4"	VCWC-08
VV-62	420	11.0	1.1	3/4"	VCWC-08
VV-63	500	14.0	1.4	3/4"	VCWC-08
VV-64	1,080	32.5	3.3	3/4"	VFWC-1211
VV-65	1,010	22.4	2.2	3/4"	VCWC-12
VV-66	720	19.5	2.0	3/4"	VCWC-08
VV-78	780	20.8	2.1	3/4"	VCWC-11(E)
VV-79	450	15.9	1.5	3/4"	VCWC-11(E)

NOTE:
(E) DENOTES EQUIPMENT THAT IS EXISTING AND STORED IN THE WORK AREA.

REVISED 23 SEPT-5 DIXON-HUBBARD-FEINOUR

REVISED 15 MAY - 4 SUITE 450

DUCTWORK HVAC

REVISED 16 SEPT.

REVISED 5 AUG. 81

REVISED 6 JULY '88 -

CHARLES D. KEEFER II - CONSULTING ENGINEER
Roanoke Virginia

RENOVATION & ALTERATIONS TO
COULTER BLDG. & NATL. BUSINESS COL.
JEFFERSON ST. AT FRANKLIN RD., ROANOKE, VA.

MARTIN BROS. CONTRACTORS, INC.
ROANOKE VIRGINIA

DATE
1988
SHEET
M4B