




JEFFERSON STREET

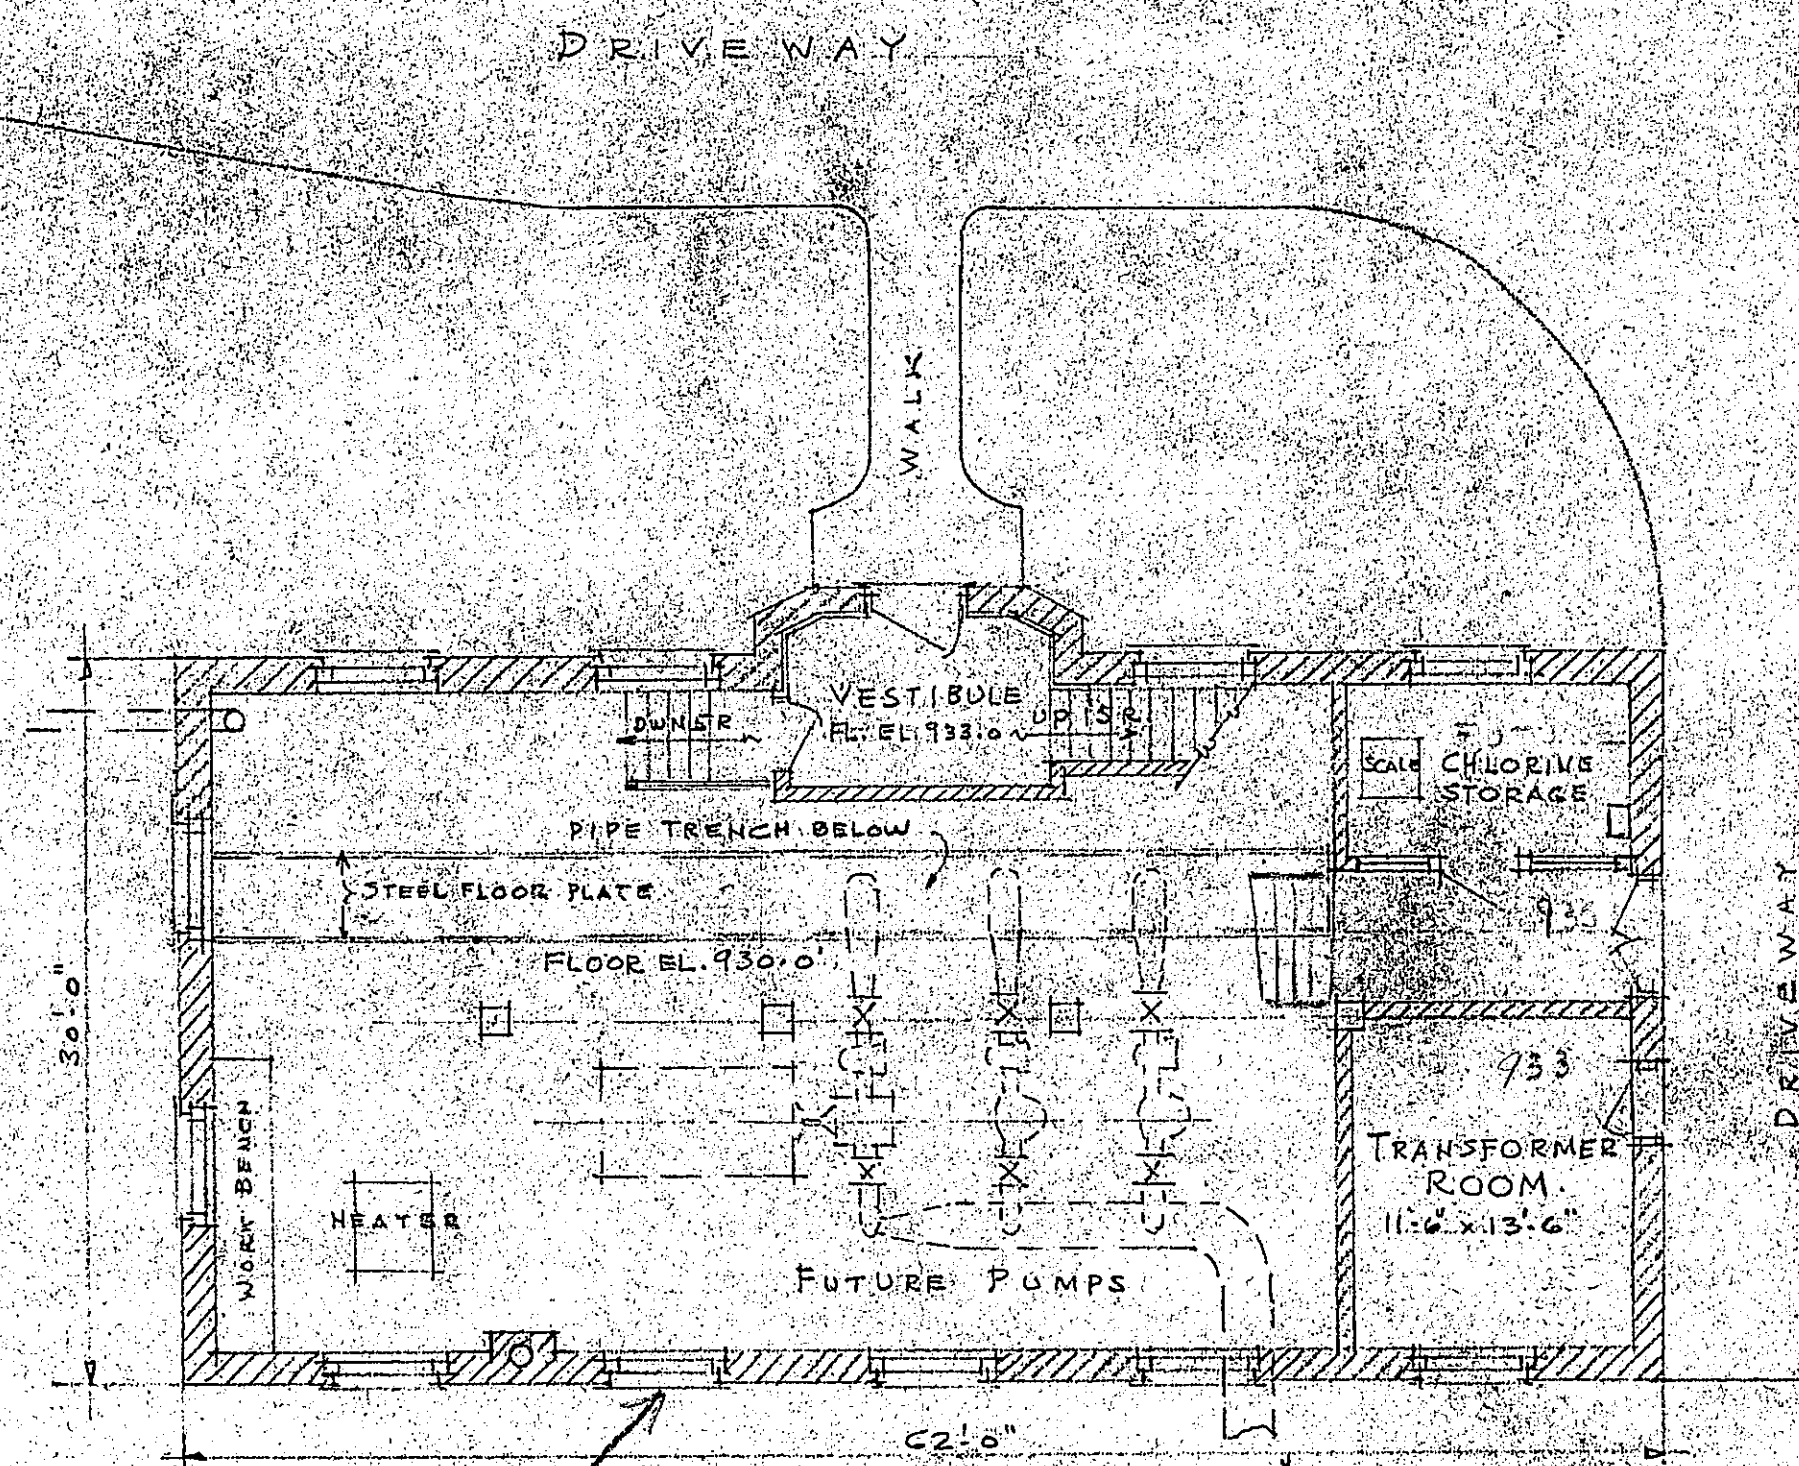


MAIN FLOOR PLAN
SCALE 1/8" = 1'-0"

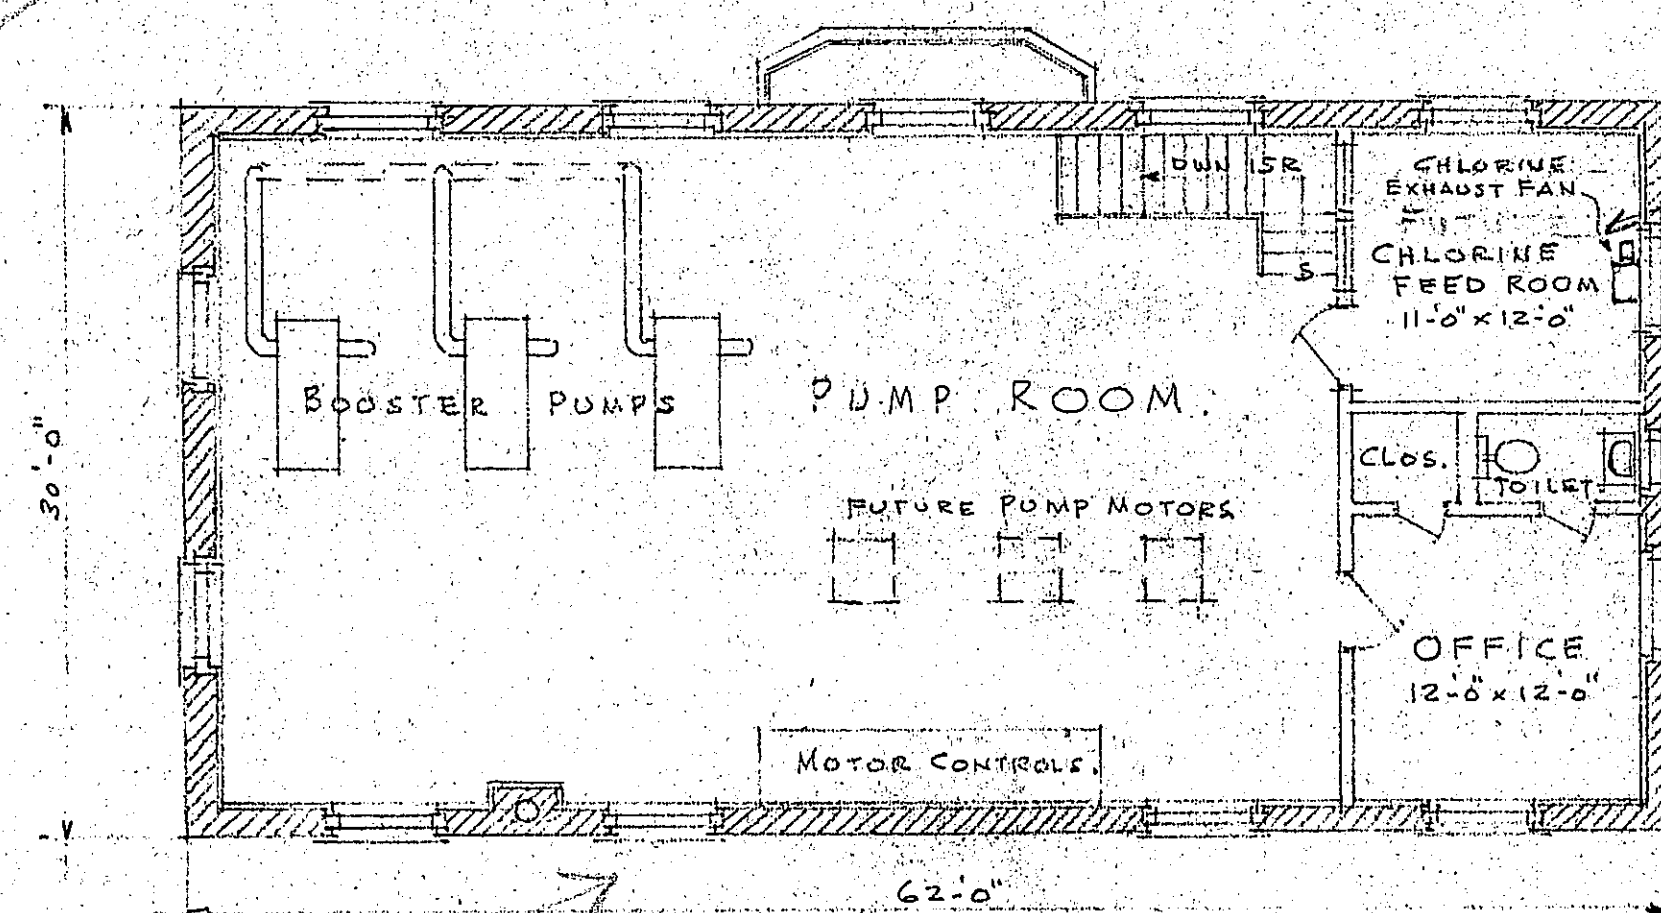

SECOND FLOOR PLAN
SCALE 1/8" = 1'-0"

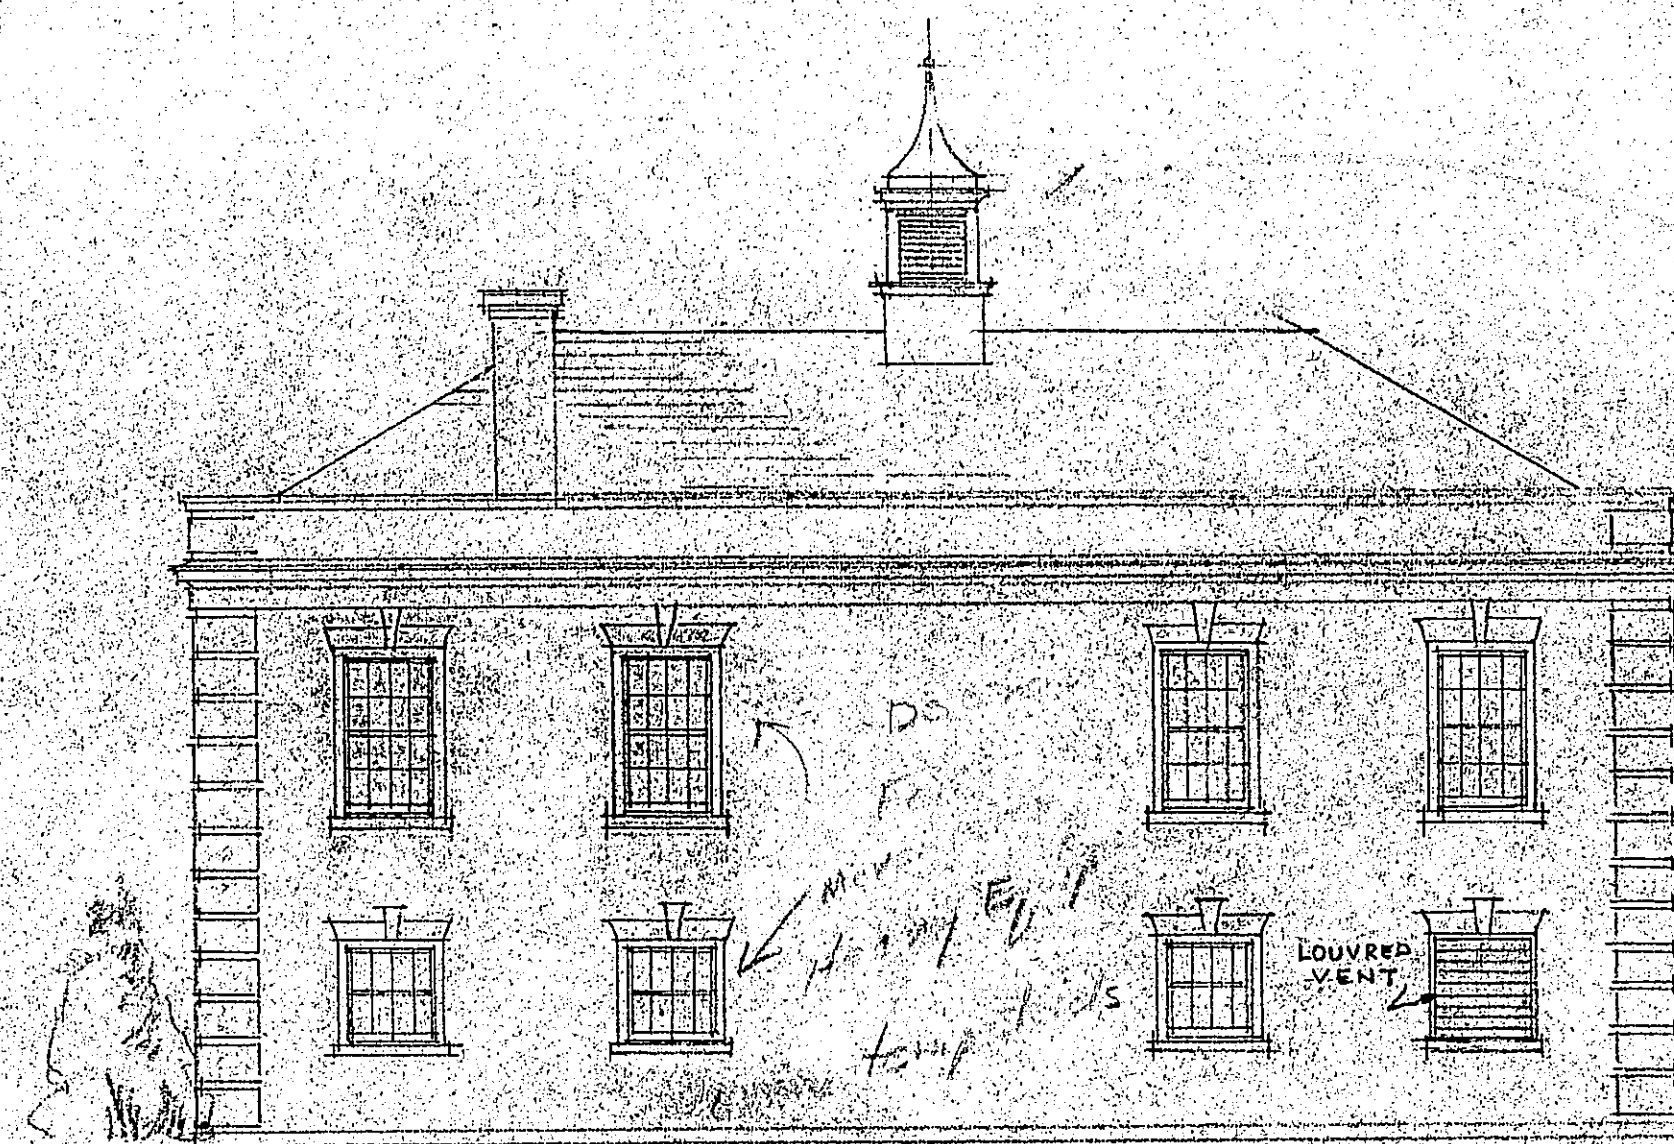


SOUTH ELEVATION
SCALE 1/8" = 1'-0"

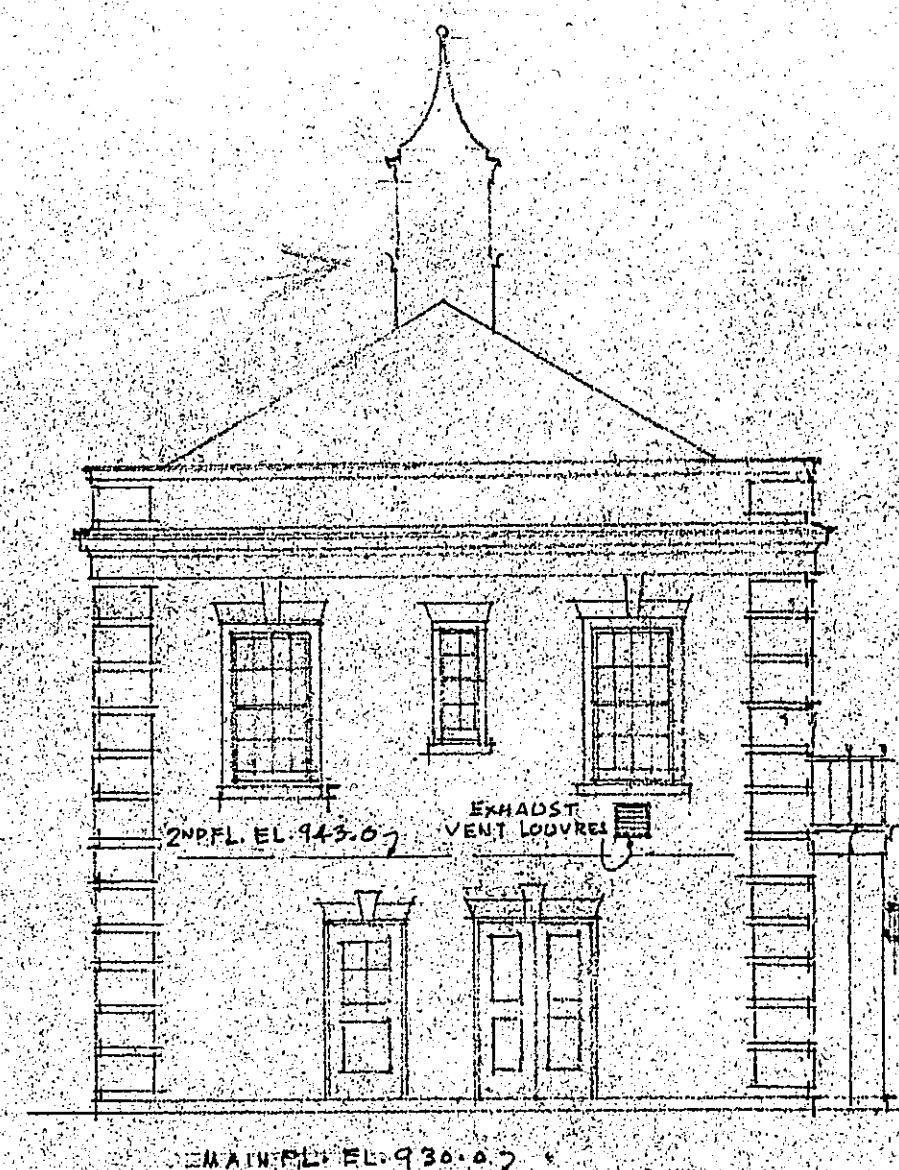

EAST ELEVATION
SCALE 1/8" = 1'-0"

Detail for Transformer Room
to be prepared by A.P.E.C.

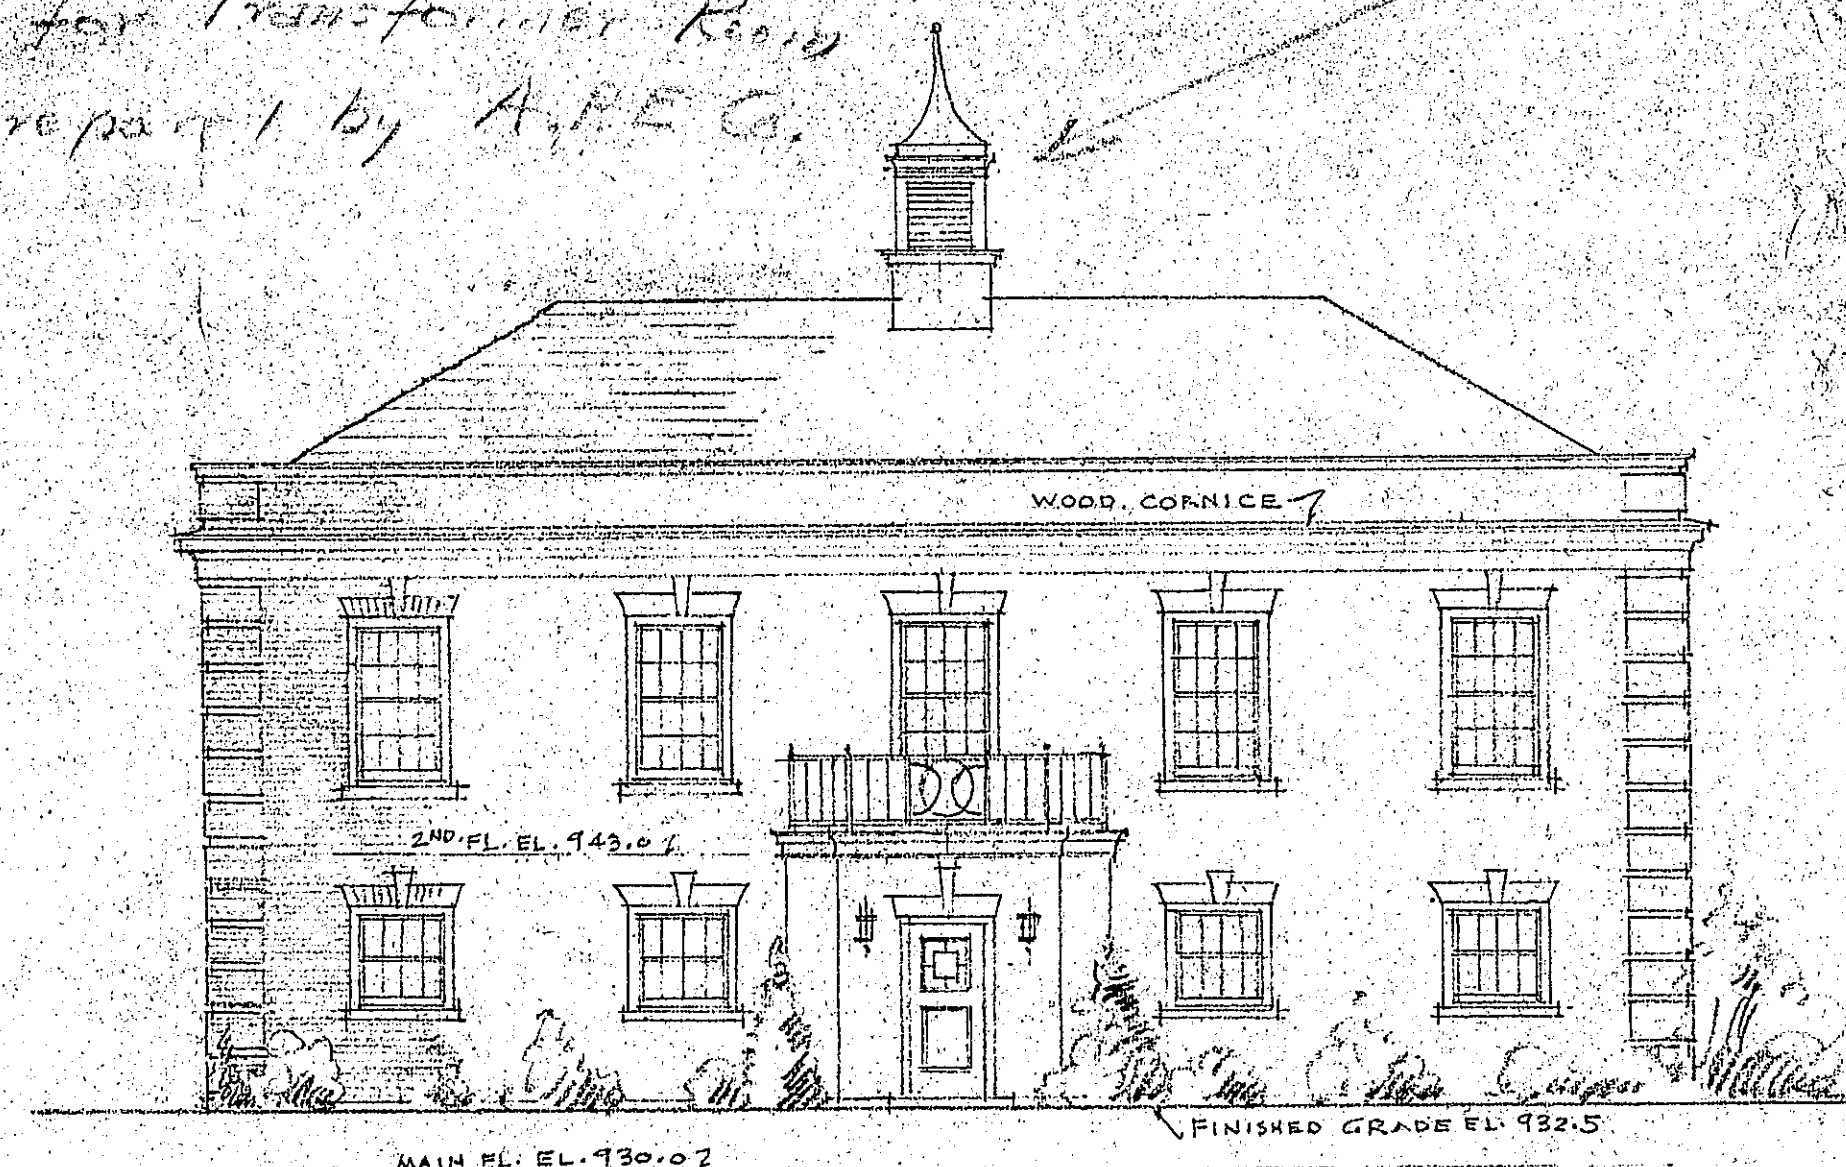

NORTH (FRONT) ELEVATION
SCALE 1/8" = 1'-0"



WEST ELEVATION
SCALE 1/8" = 1'-0"

DESIGN FOR THE
CRYSTAL SPRING PUMPING STATION
CITY OF ROANOKE
WATER DEPARTMENT

ALVORD, BURDICK AND HOWSON
ENGINEERS CHICAGO.
MAY 31, 1951.