




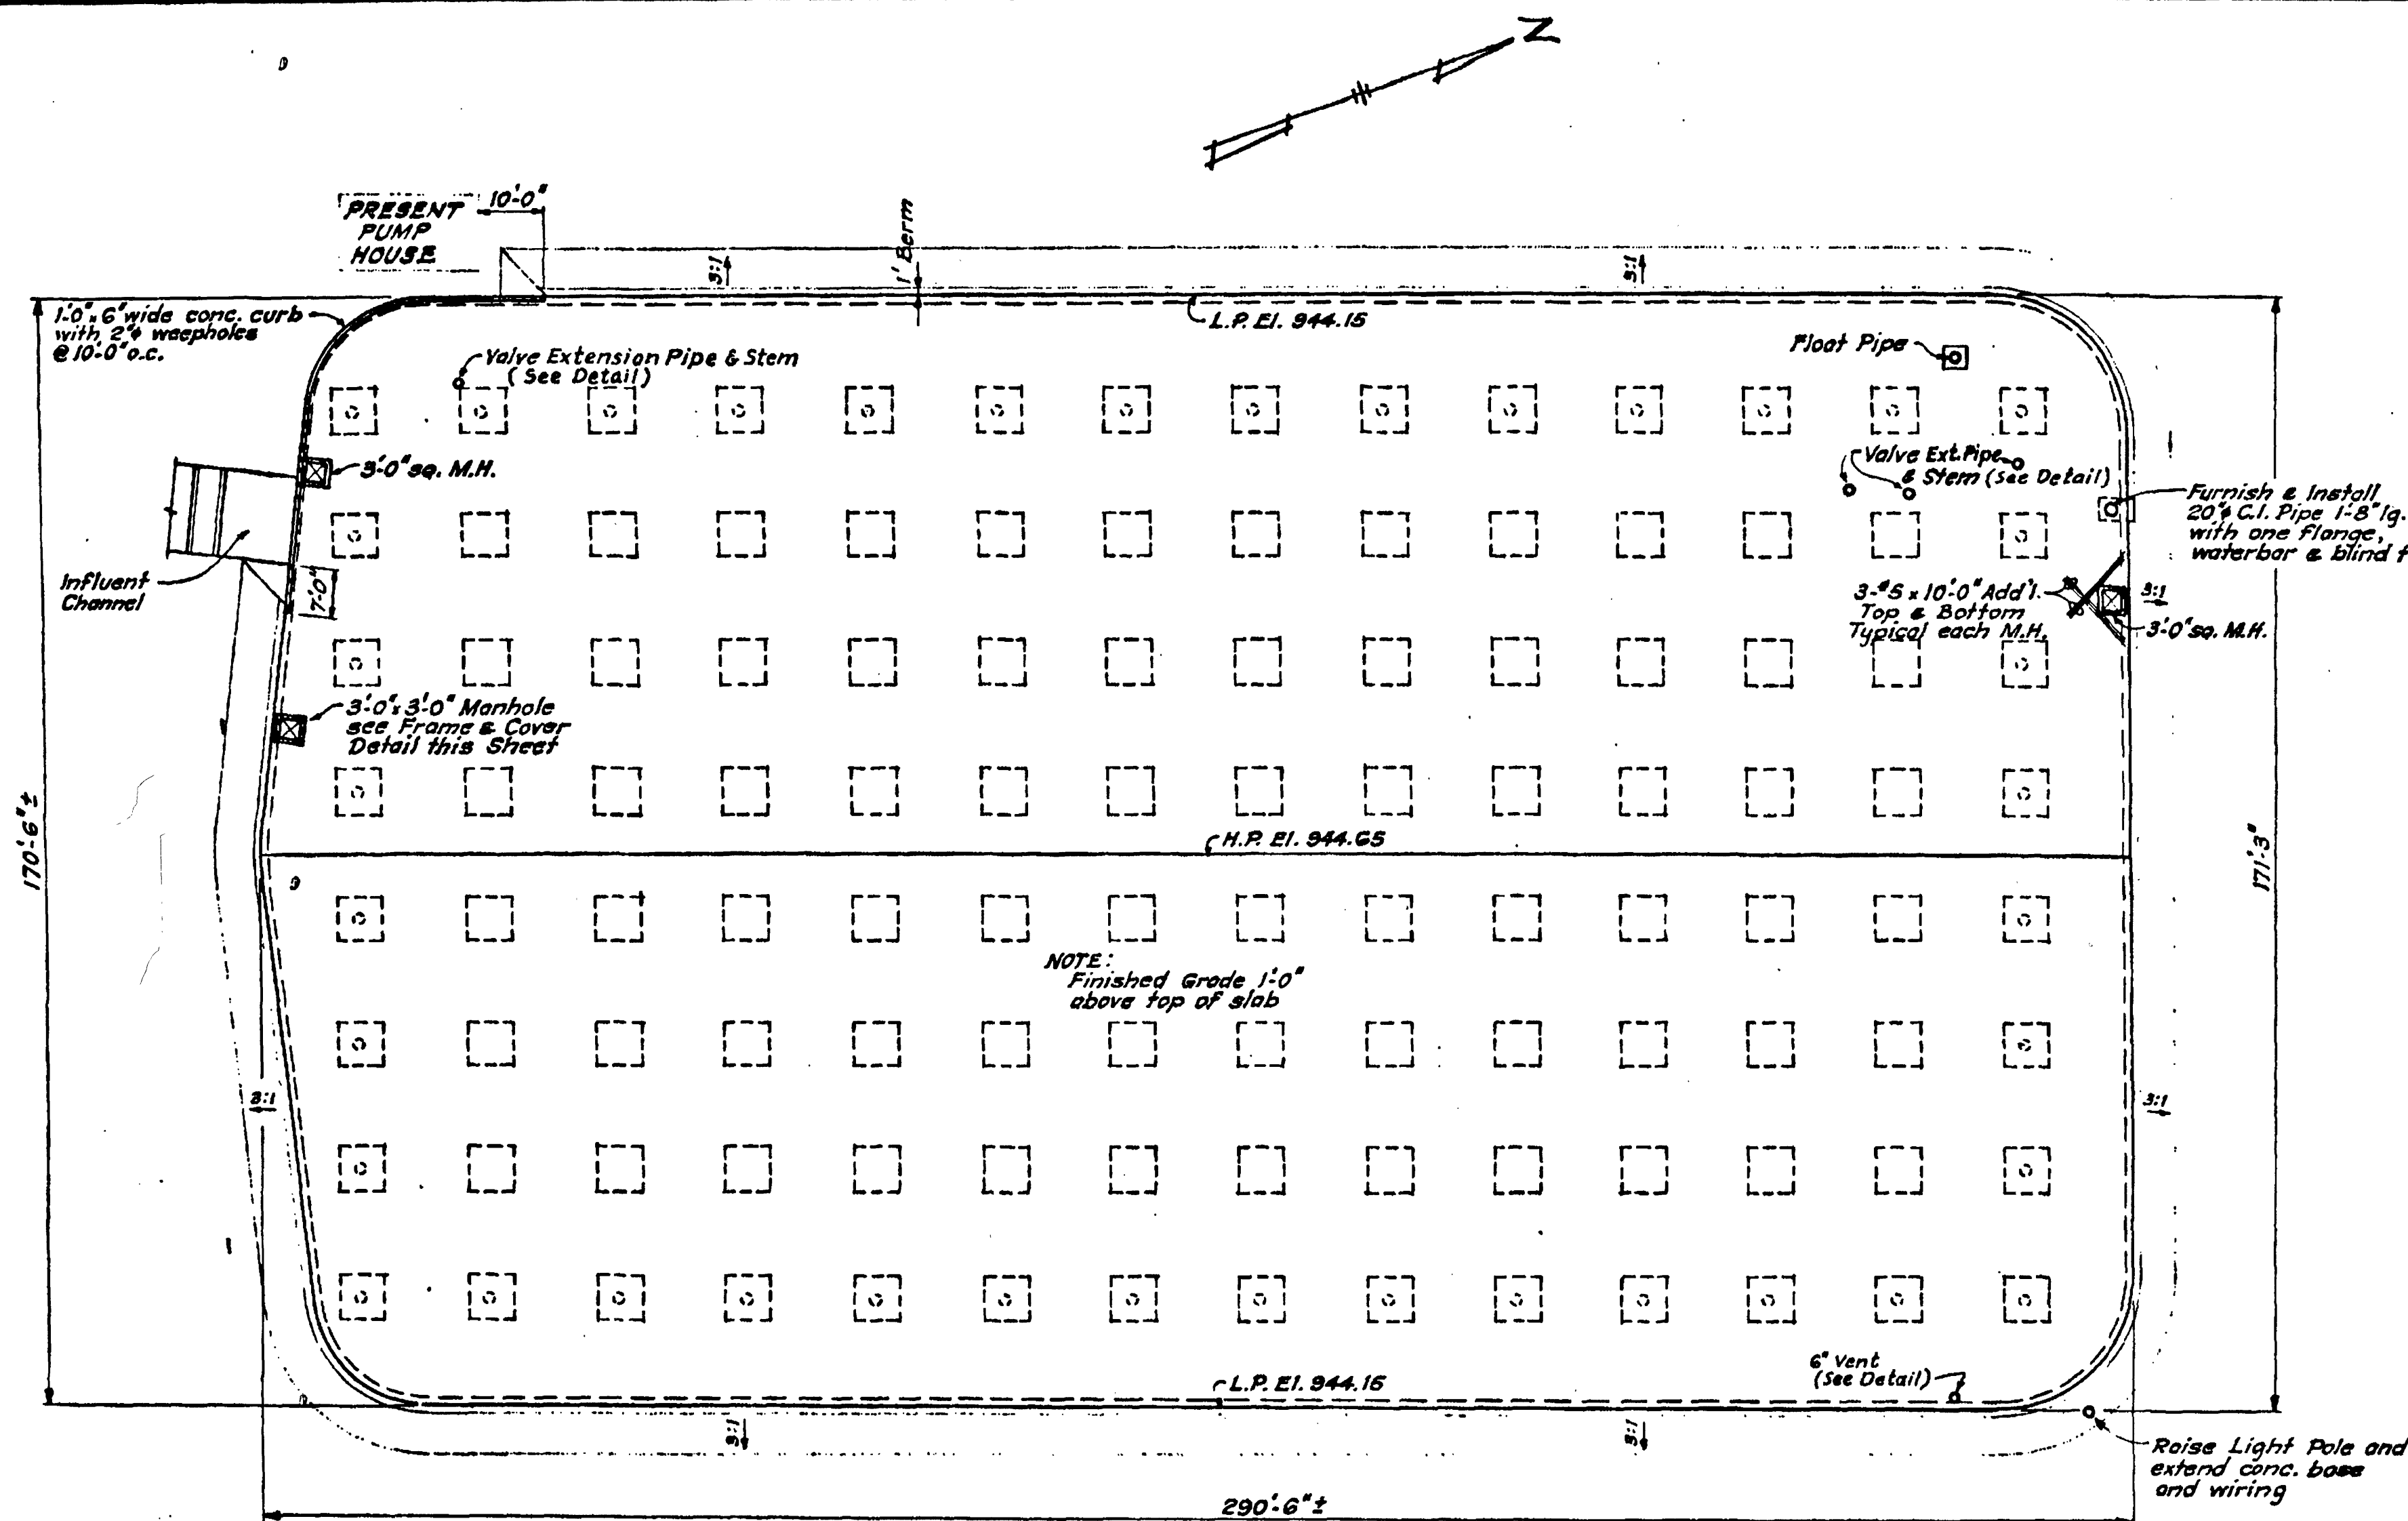


ROOF PLAN
Scale: 1" = 20'

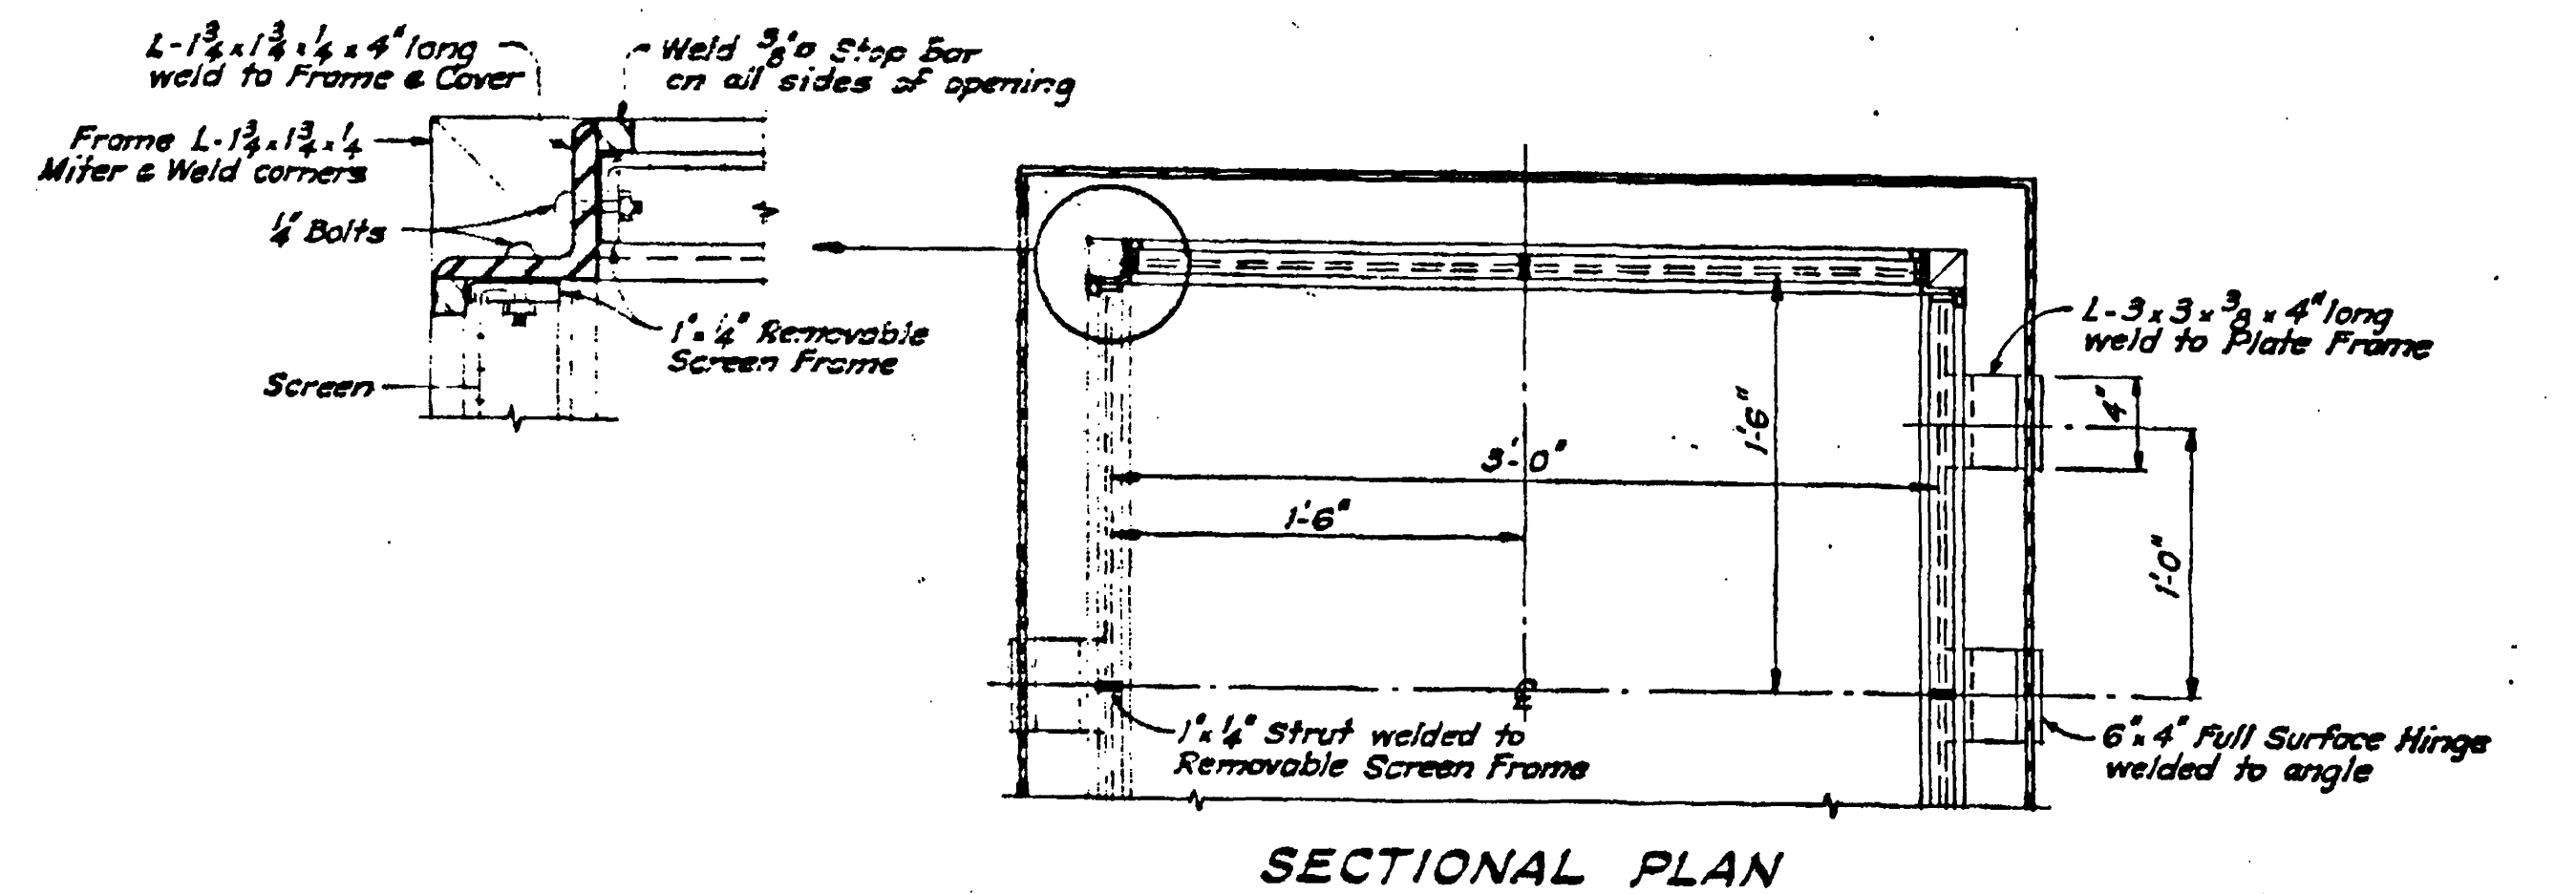


SECTIONAL PLAN

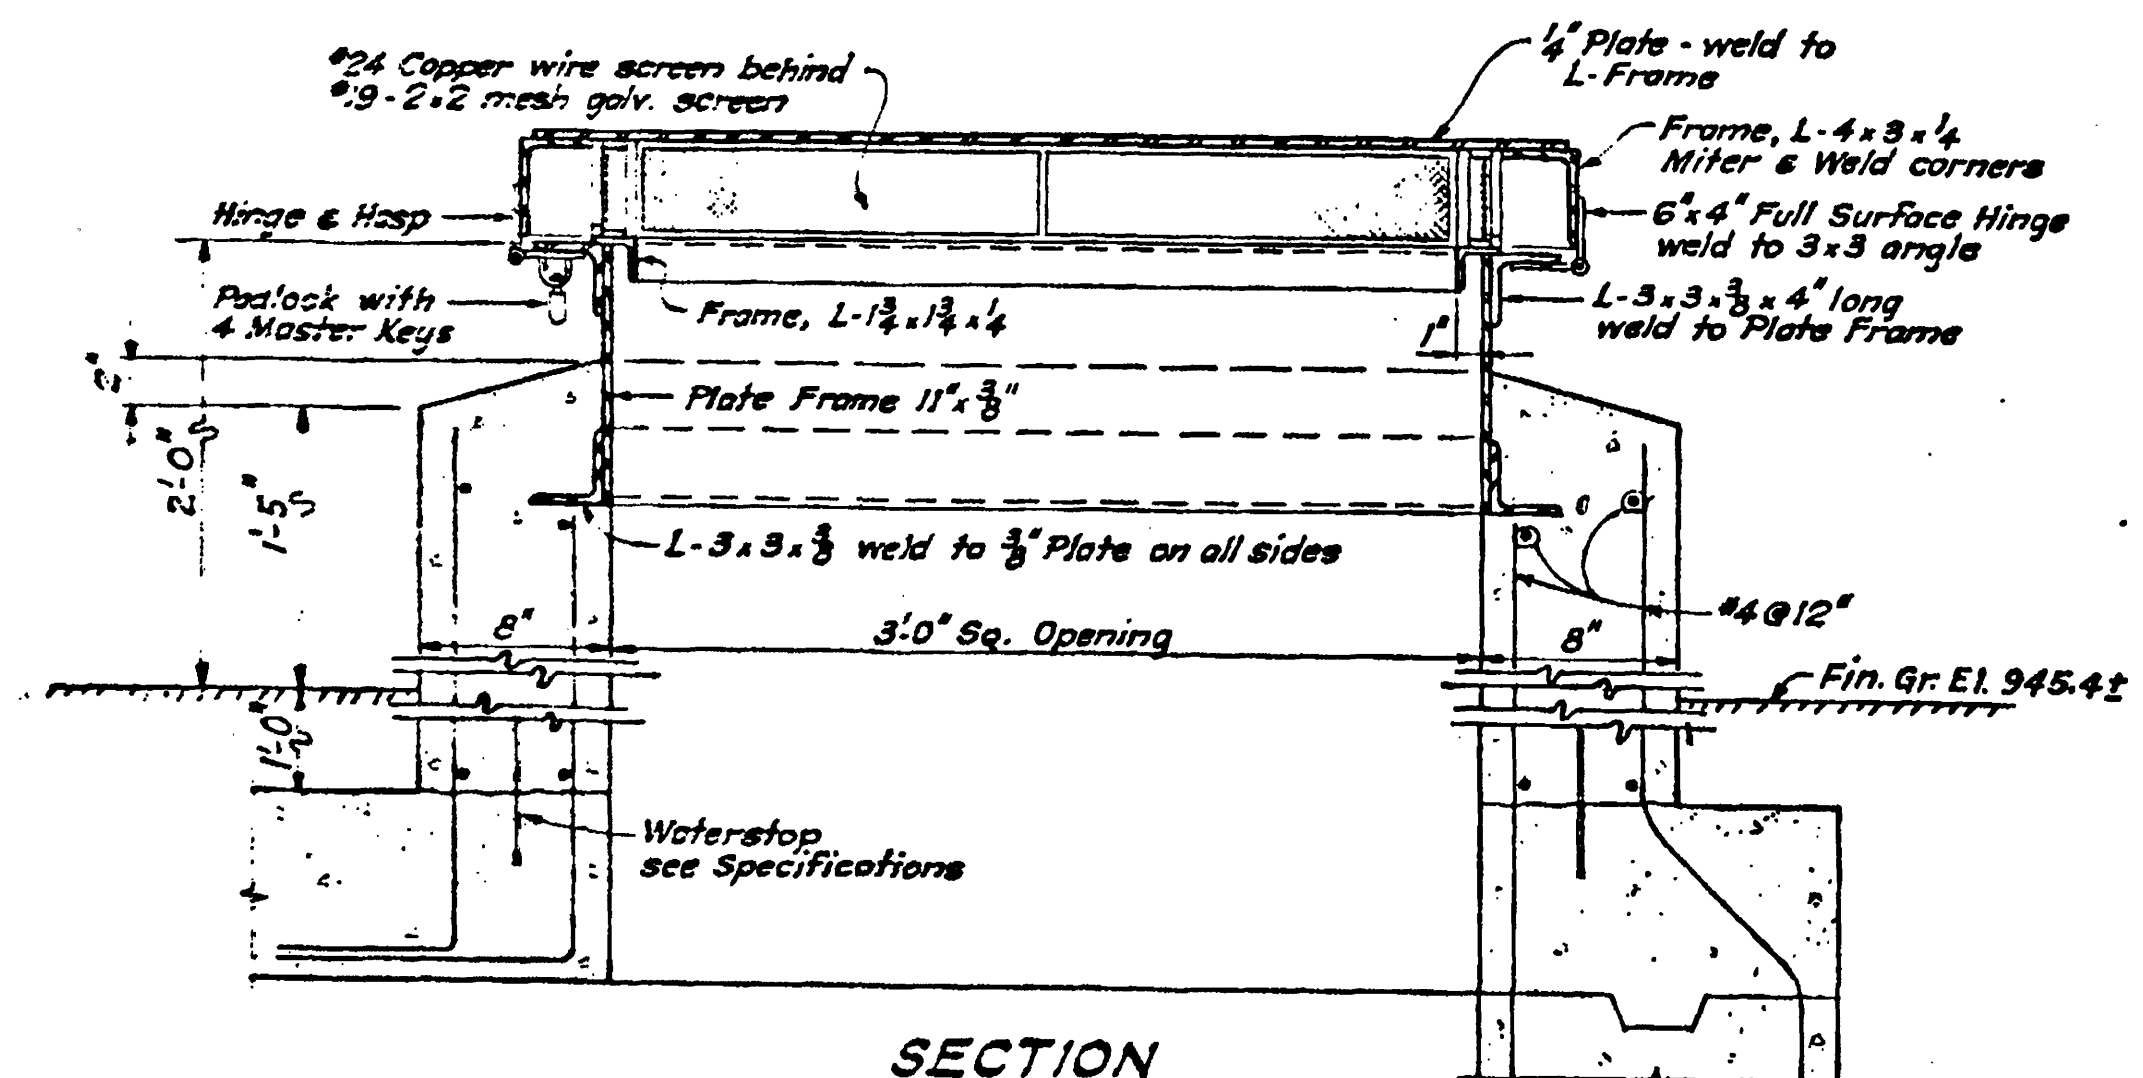


SECTION
DETAILS OF MANHOLE FRAME & COVER
Scale: 1/2" = 1'-0"

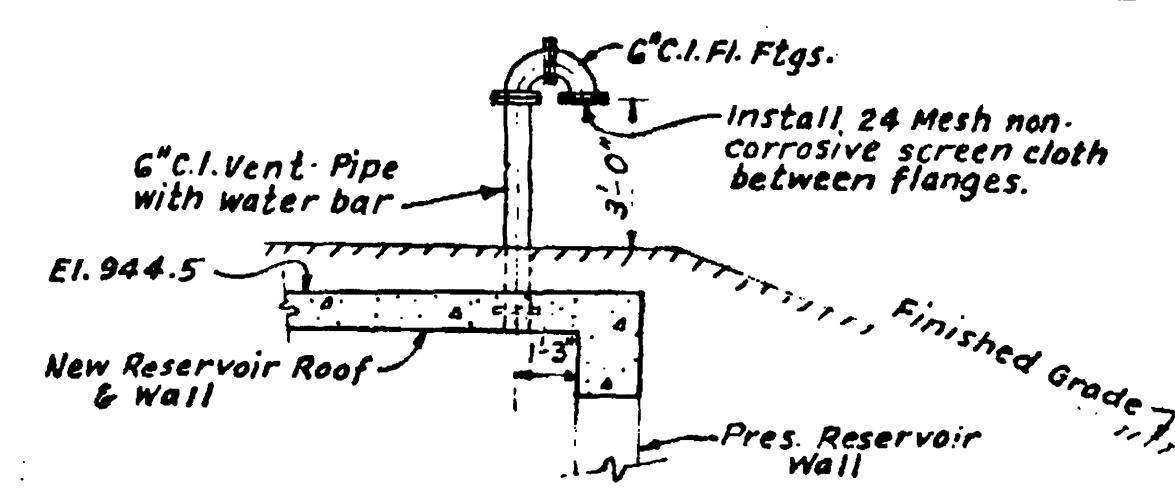


DETAIL OF VENT
Scale: 1/4" = 1'-0"

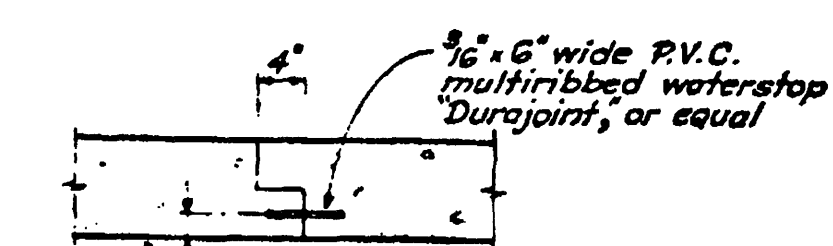


SLAB CONSTR. JOINT
Scale: 3/4" = 1'-0"

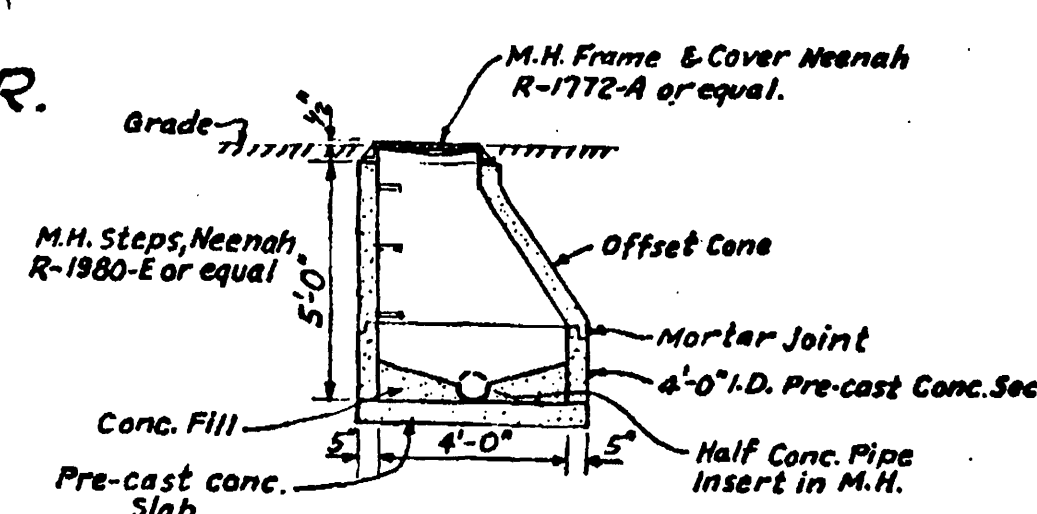


DETAIL OF MANHOLE
Scale: 1/4" = 1'-0"

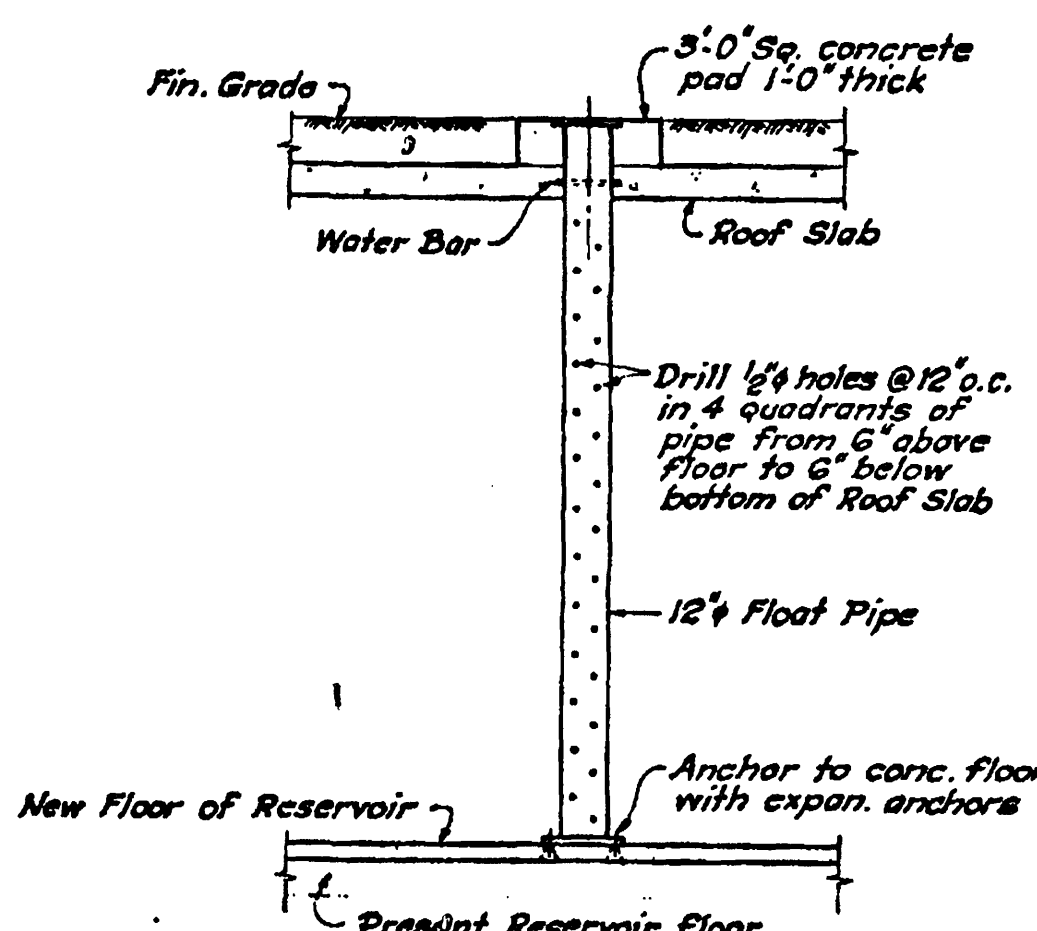


DETAIL OF FLOAT PIPE
Scale: 1/4" = 1'-0"

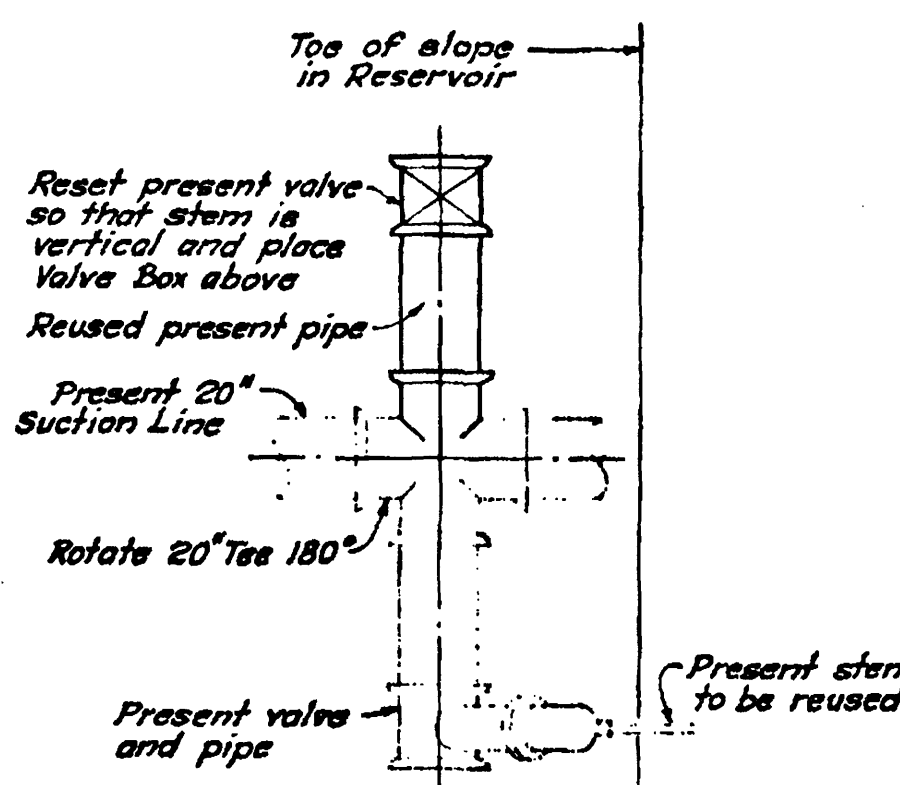

DETAIL OF RELOCATED 20" VALVE & PIPE
Scale: 1/4" = 1'-0"

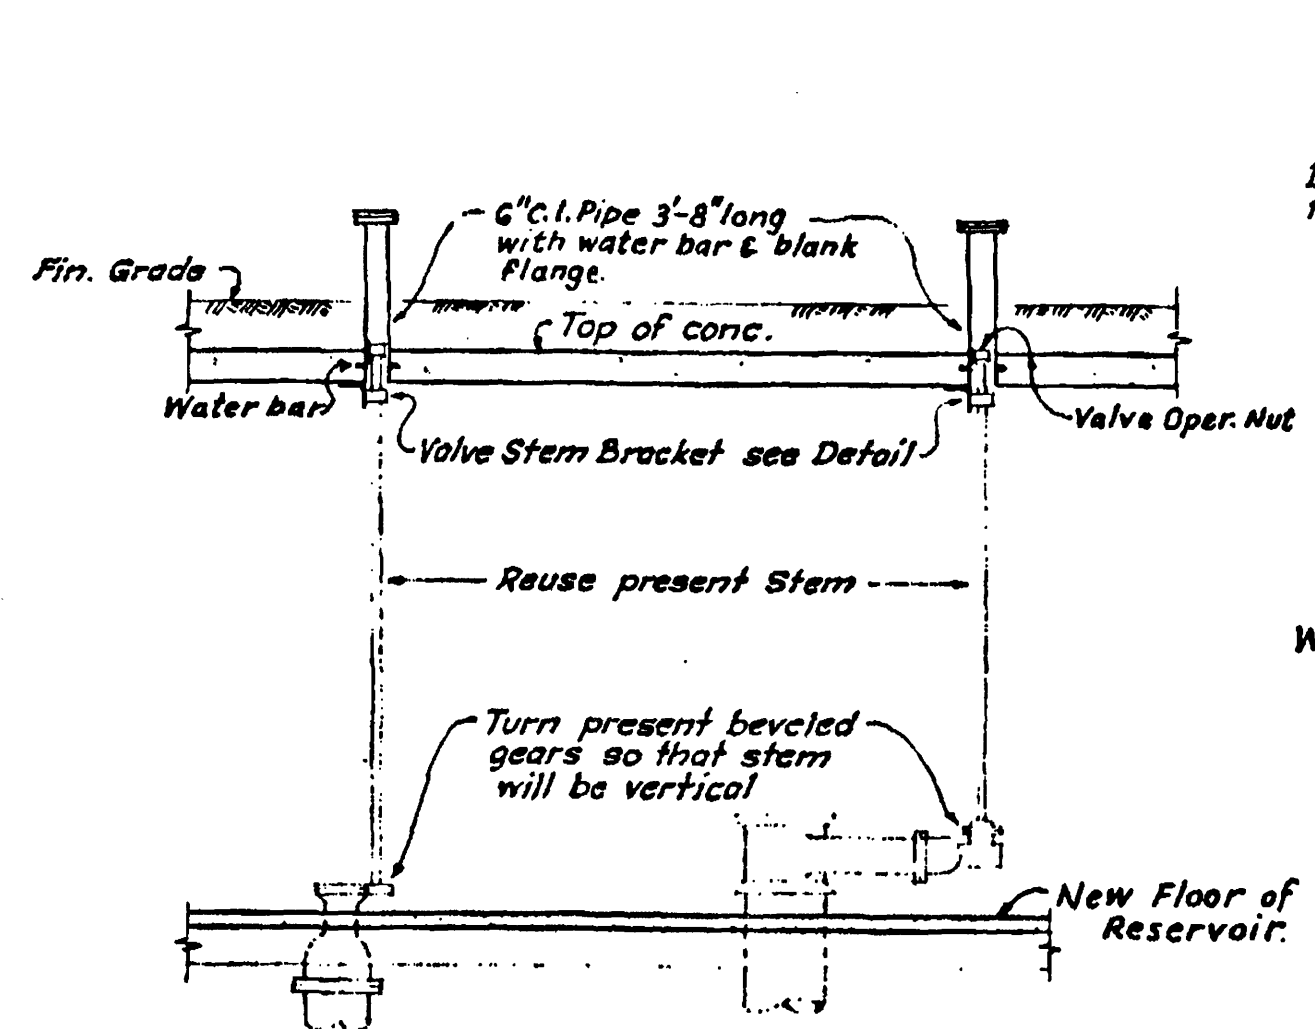

DETAIL OF VALVE EXTENSION PIPE & STEM
Scale: 1/4" = 1'-0"

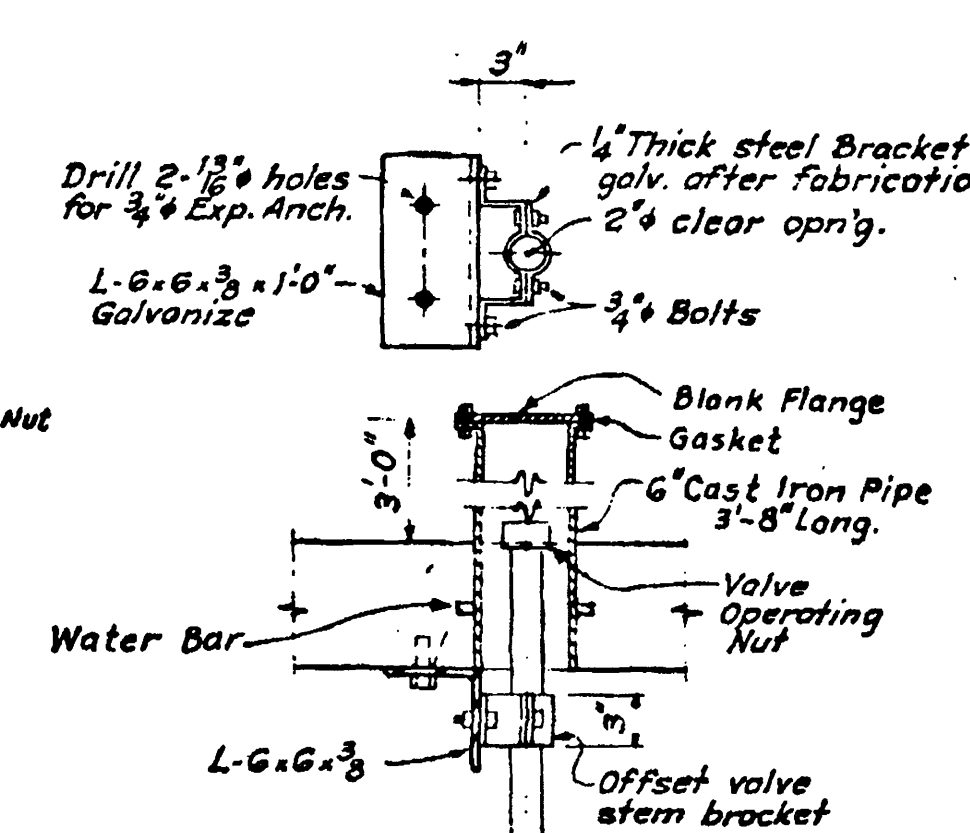

DETAIL OF VALVE STEM BRACKET
Scale: 1" = 1'-0"

DATE	REV.	DESCRIPTION	BY
11/22/01			
 Philip R. ... CITY ENGINEER			
GUNITE CRYSTAL SPRINGS RESERVOIR 2006 S. JEFFERSON ST. FOR WATER DEPARTMENT ROANOKE, VIRGINIA			
OFFICE OF CITY ENGINEER MUNICIPAL BUILDING, ROOM 350 215 CHURCH AVENUE, S.W. ROANOKE, VIRGINIA 24001			
DRAWN CHECKED APPROVED DATE 1-08-01 PLAN NO. 00-12-68			SHEET OF 3