


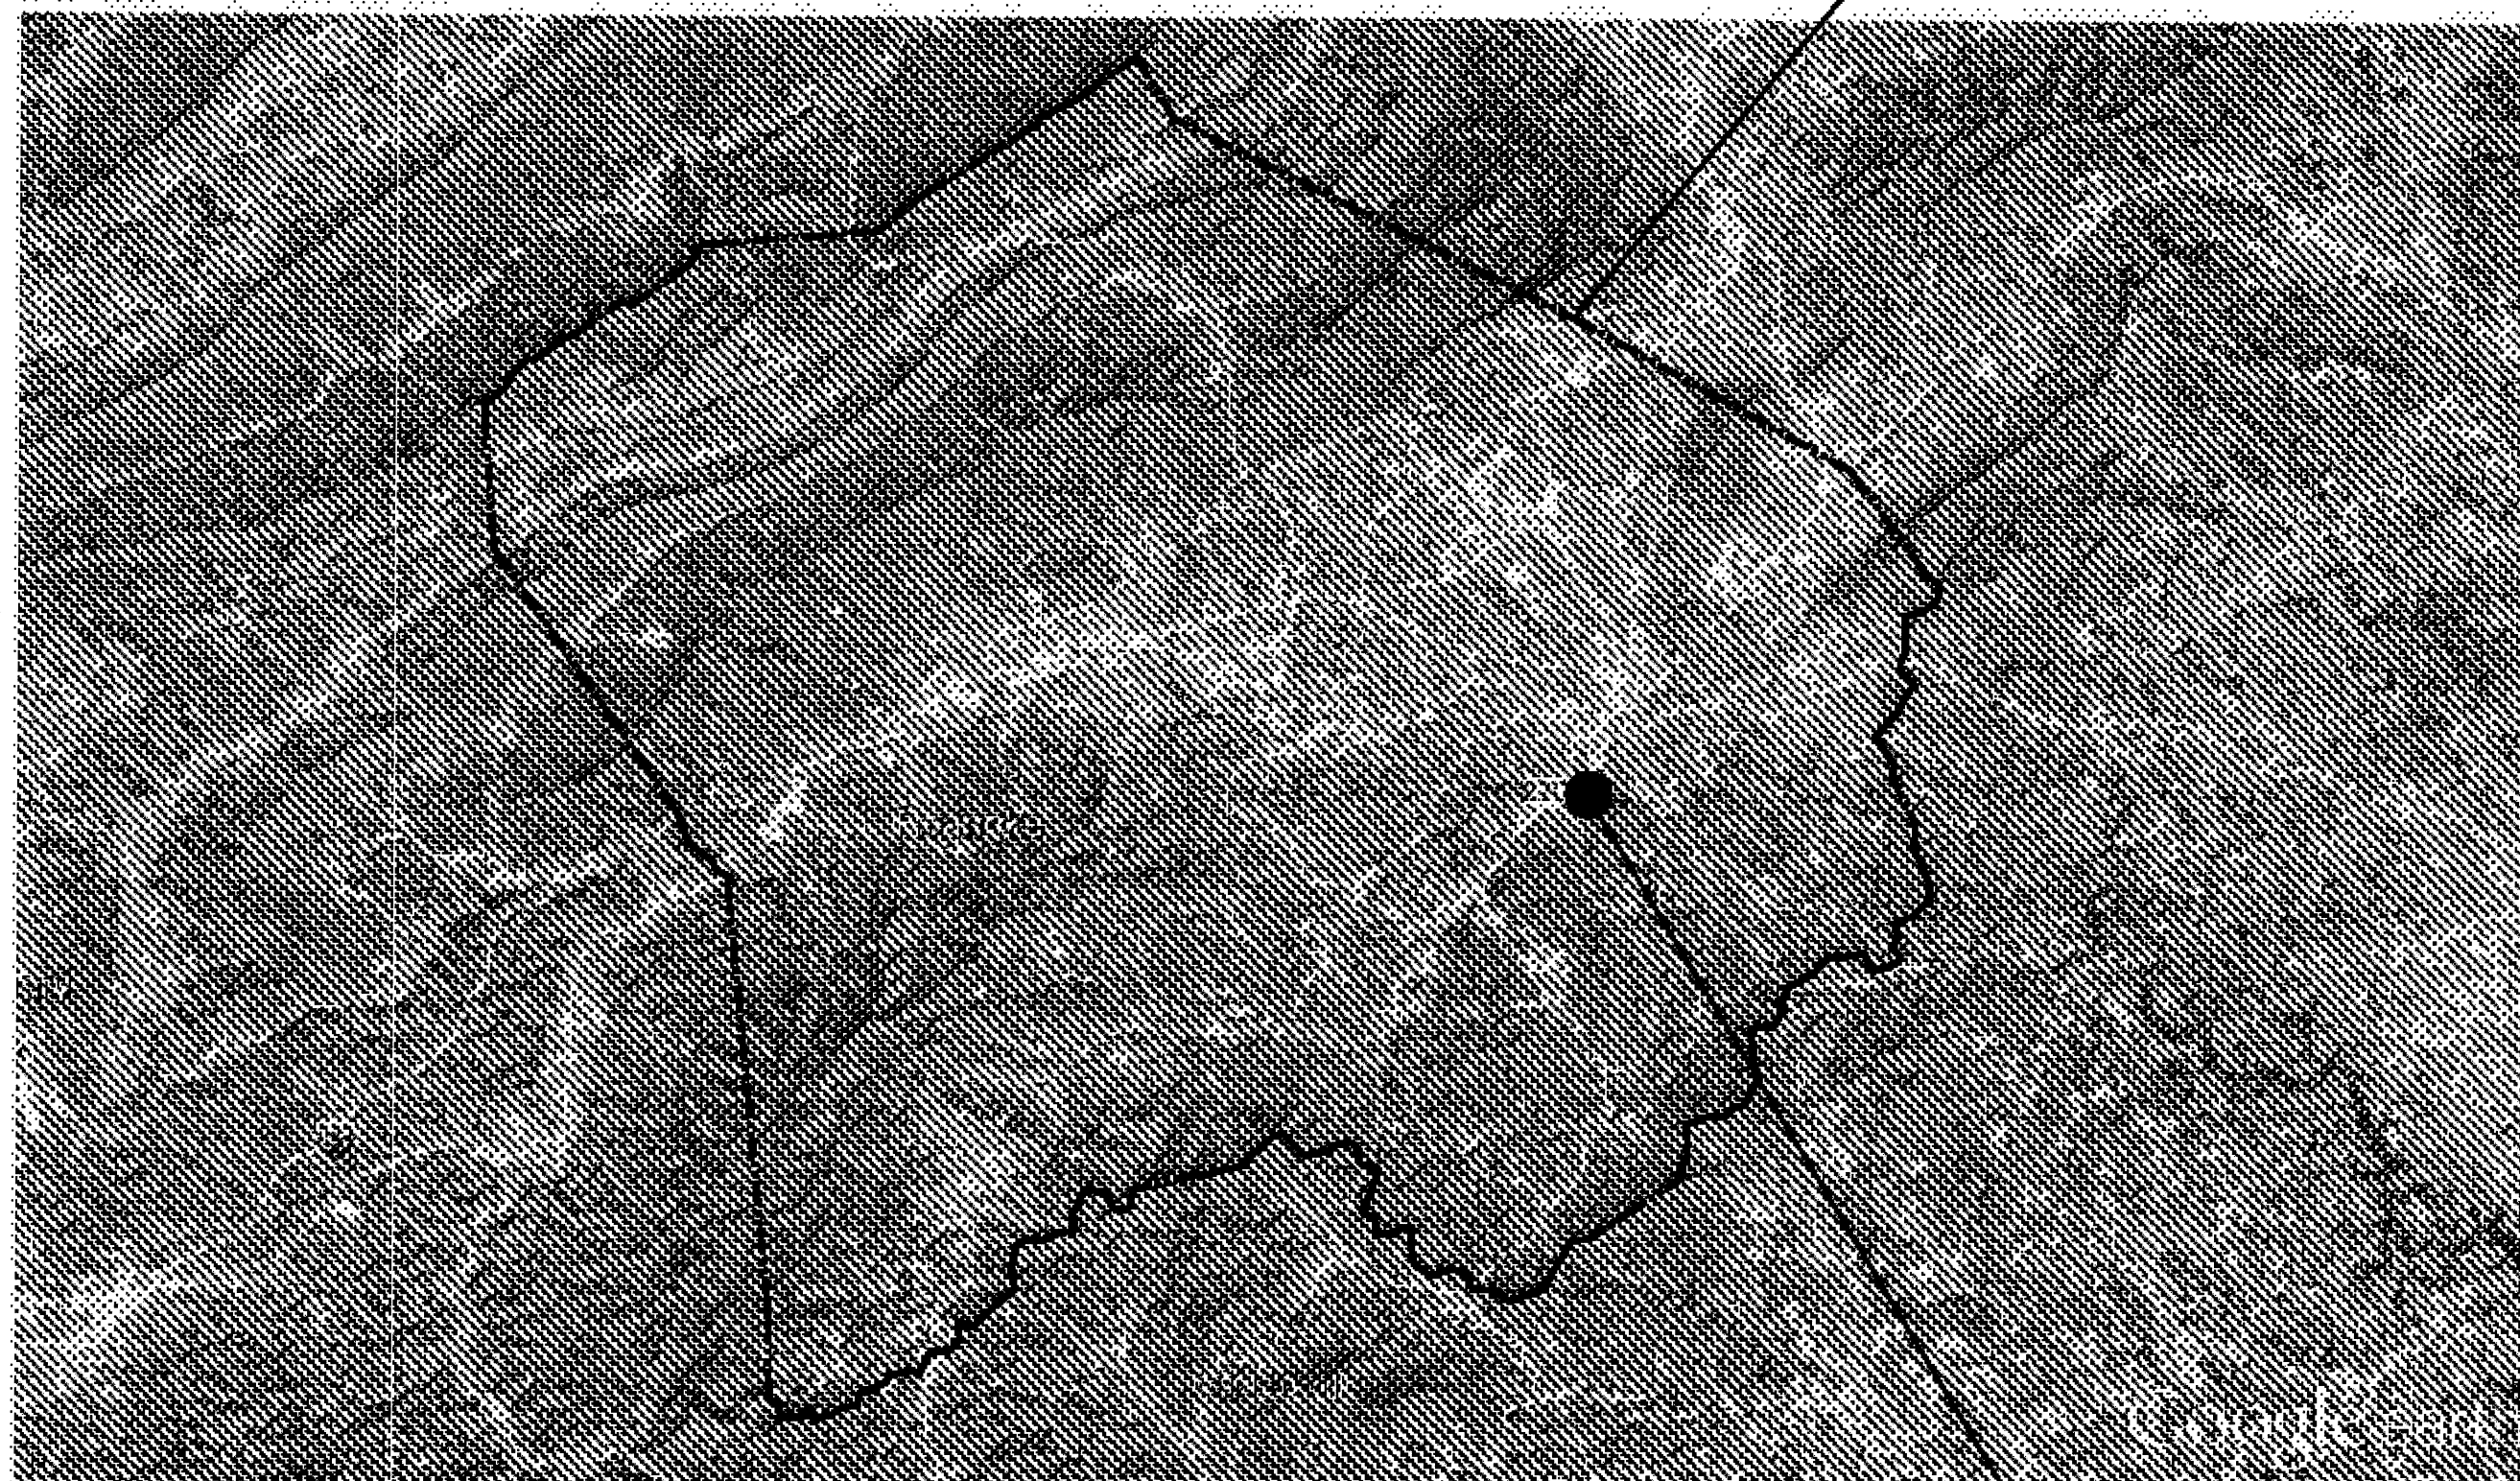


SITE VICINITY MAP



SITE LOCATION MAP

INDEX TO DRAWINGS

<u>SHEET NO</u>	<u>DWG NO</u>	<u>DRAWING TITLE</u>
1	G-0001	COVER SHEET
2	G-0002	INDEX TO DRAWINGS, SITE VICINITY AND LOCATION MAPS
3	G-0003	GENERAL LEGEND AND ABBREVIATIONS
4	G-0004	PERSPECTIVE RENDERING
5	C-1000	CIVIL OVERALL SITE PLAN
6	C-1001	CIVIL PLAN AND PROFILES
7	C-1002	CIVIL EROSION & SEDIMENT CONTROL NOTES
8	C-1003	CIVIL EROSION & SEDIMENT CONTROL PLAN
9	C-1004	CIVIL EROSION & SEDIMENT CONTROL DETAILS
10	C-1005	CIVIL DETAILS
11	A-2001	ARCHITECTURAL LOW LIFT AND HIGH ZONE PUMP STATION SECOND FLOOR PLANS, DETAILS, AND SCHEDULES
12	S-0001	STRUCTURAL GENERAL NOTES
13	S-0002	STRUCTURAL SPECIAL INSPECTION NOTES
14	S-0003	STRUCTURAL SPECIAL INSPECTION NOTES
15	S-2001	STRUCTURAL LOW LIFT AND HIGH ZONE PS SECOND FLOOR PLAN AND DETAILS
16	S-5001	STRUCTURAL STANDARD DETAILS
17	M-2001	PROCESS MECHANICAL CLEARWELL STORAGE TANK PLAN AND DETAILS
18	M-3001	PROCESS MECHANICAL CLEARWELL STORAGE TANK SECTIONS AND DETAILS
19	M-3002	PROCESS MECHANICAL CLEARWELL STORAGE TANK SECTIONS AND DETAILS
20	M-5001	PROCESS MECHANICAL CLEARWELL STORAGE TANK DETAILS
21	M-5002	DETAILS
22	BS-2001	BUILDING SERVICES LOW LIFT AND HIGH ZONE PS FIRST AND SECOND FLOOR PLANS
23	BS-8001	BUILDING SERVICES LOW LIFT AND HIGH ZONE PS SCHEDULES AND DETAIL
24	E-0001	ELECTRICAL LEGEND AND SYMBOLS
25	E-0002	ELECTRICAL LEGEND AND SYMBOLS
26	E-0003	ELECTRICAL LEGEND AND SYMBOLS
27	E-0004	ELECTRICAL ABBREVIATIONS
28	E-2000	ELECTRICAL SITE PLAN
29	E-2001	ELECTRICAL LOW LIFT AND HIGH ZONE SECOND FLOOR PLANS AND MCC ELEVATION
30	E-5001	ELECTRICAL DETAILS
31	E-5002	ELECTRICAL DETAILS
32	E-8001	ELECTRICAL LOW LIFT AND HIGH ZONE PS DIAGRAMS
33	E-8002	ELECTRICAL CONTROL SCHEMATIC AND CABLE BLOCK DIAGRAMS
34	I-0001	INSTRUMENTATION AND CONTROL LEGEND AND SYMBOLS
35	I-0002	INSTRUMENTATION AND CONTROL LEGEND AND SYMBOLS
36	I-5001	INSTRUMENTATION AND CONTROL DETAILS
37	I-8001	INSTRUMENTATION AND CONTROL P&ID

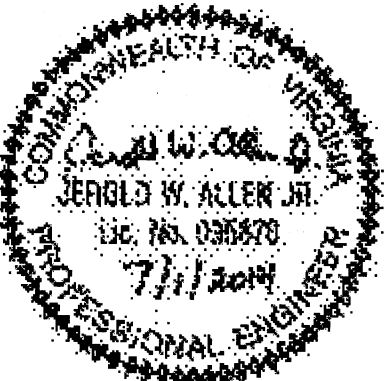[illegible]

CH2MHILL.

INDEX TO DRAWINGS SITE VICINITY AND LOCATION MAPS

VERIFY SCALE	
BAR IS ONE INCH ON ORIGINAL DRAWING.	
0	1"
DATE	JUNE 2014
PROJ	475481
DWG	G-0002
SHEET	2 of 37