


GENERAL SHEET NOTES

1. REFER TO DRAWING HV0.01 FOR PLUMBING LEGEND, ABBREVIATIONS, AND GENERAL NOTES.


DEMOLITION KEYNOTES

- ① REMOVE EXISTING PLUMBING FIXTURE. REMOVE EXISTING ASSOCIATED CW BACK TO LOCATION SHOWN AND CAP. REMOVE EXISTING 4" SANITARY BELOW FLOOR BACK TO LOCATION SHOWN AND PLUG. REMOVE EXISTING 2" VENT BACK TO PENETRATION AT FLOOR ABOVE AND CAP.
- ② REMOVE EXISTING LAV/SINK. REMOVE EXISTING ASSOCIATED CW, HW, AND HWR BACK TO LOCATION SHOWN AND CAP. REMOVE EXISTING 4" SANITARY BELOW FLOOR BACK TO LOCATION SHOWN AND PLUG. REMOVE EXISTING 2" VENT BACK TO PENETRATION AT FLOOR ABOVE AND CAP.
- ③ REMOVE EXISTING 1-1/4" DCW AND 1" DHW CROSSING FUTURE ELECTRICAL ROOM AND PREPARE FOR CONNECTION TO NEW 1-1/4" DCW AND 1" DHW OUTSIDE OF THIS AREA.

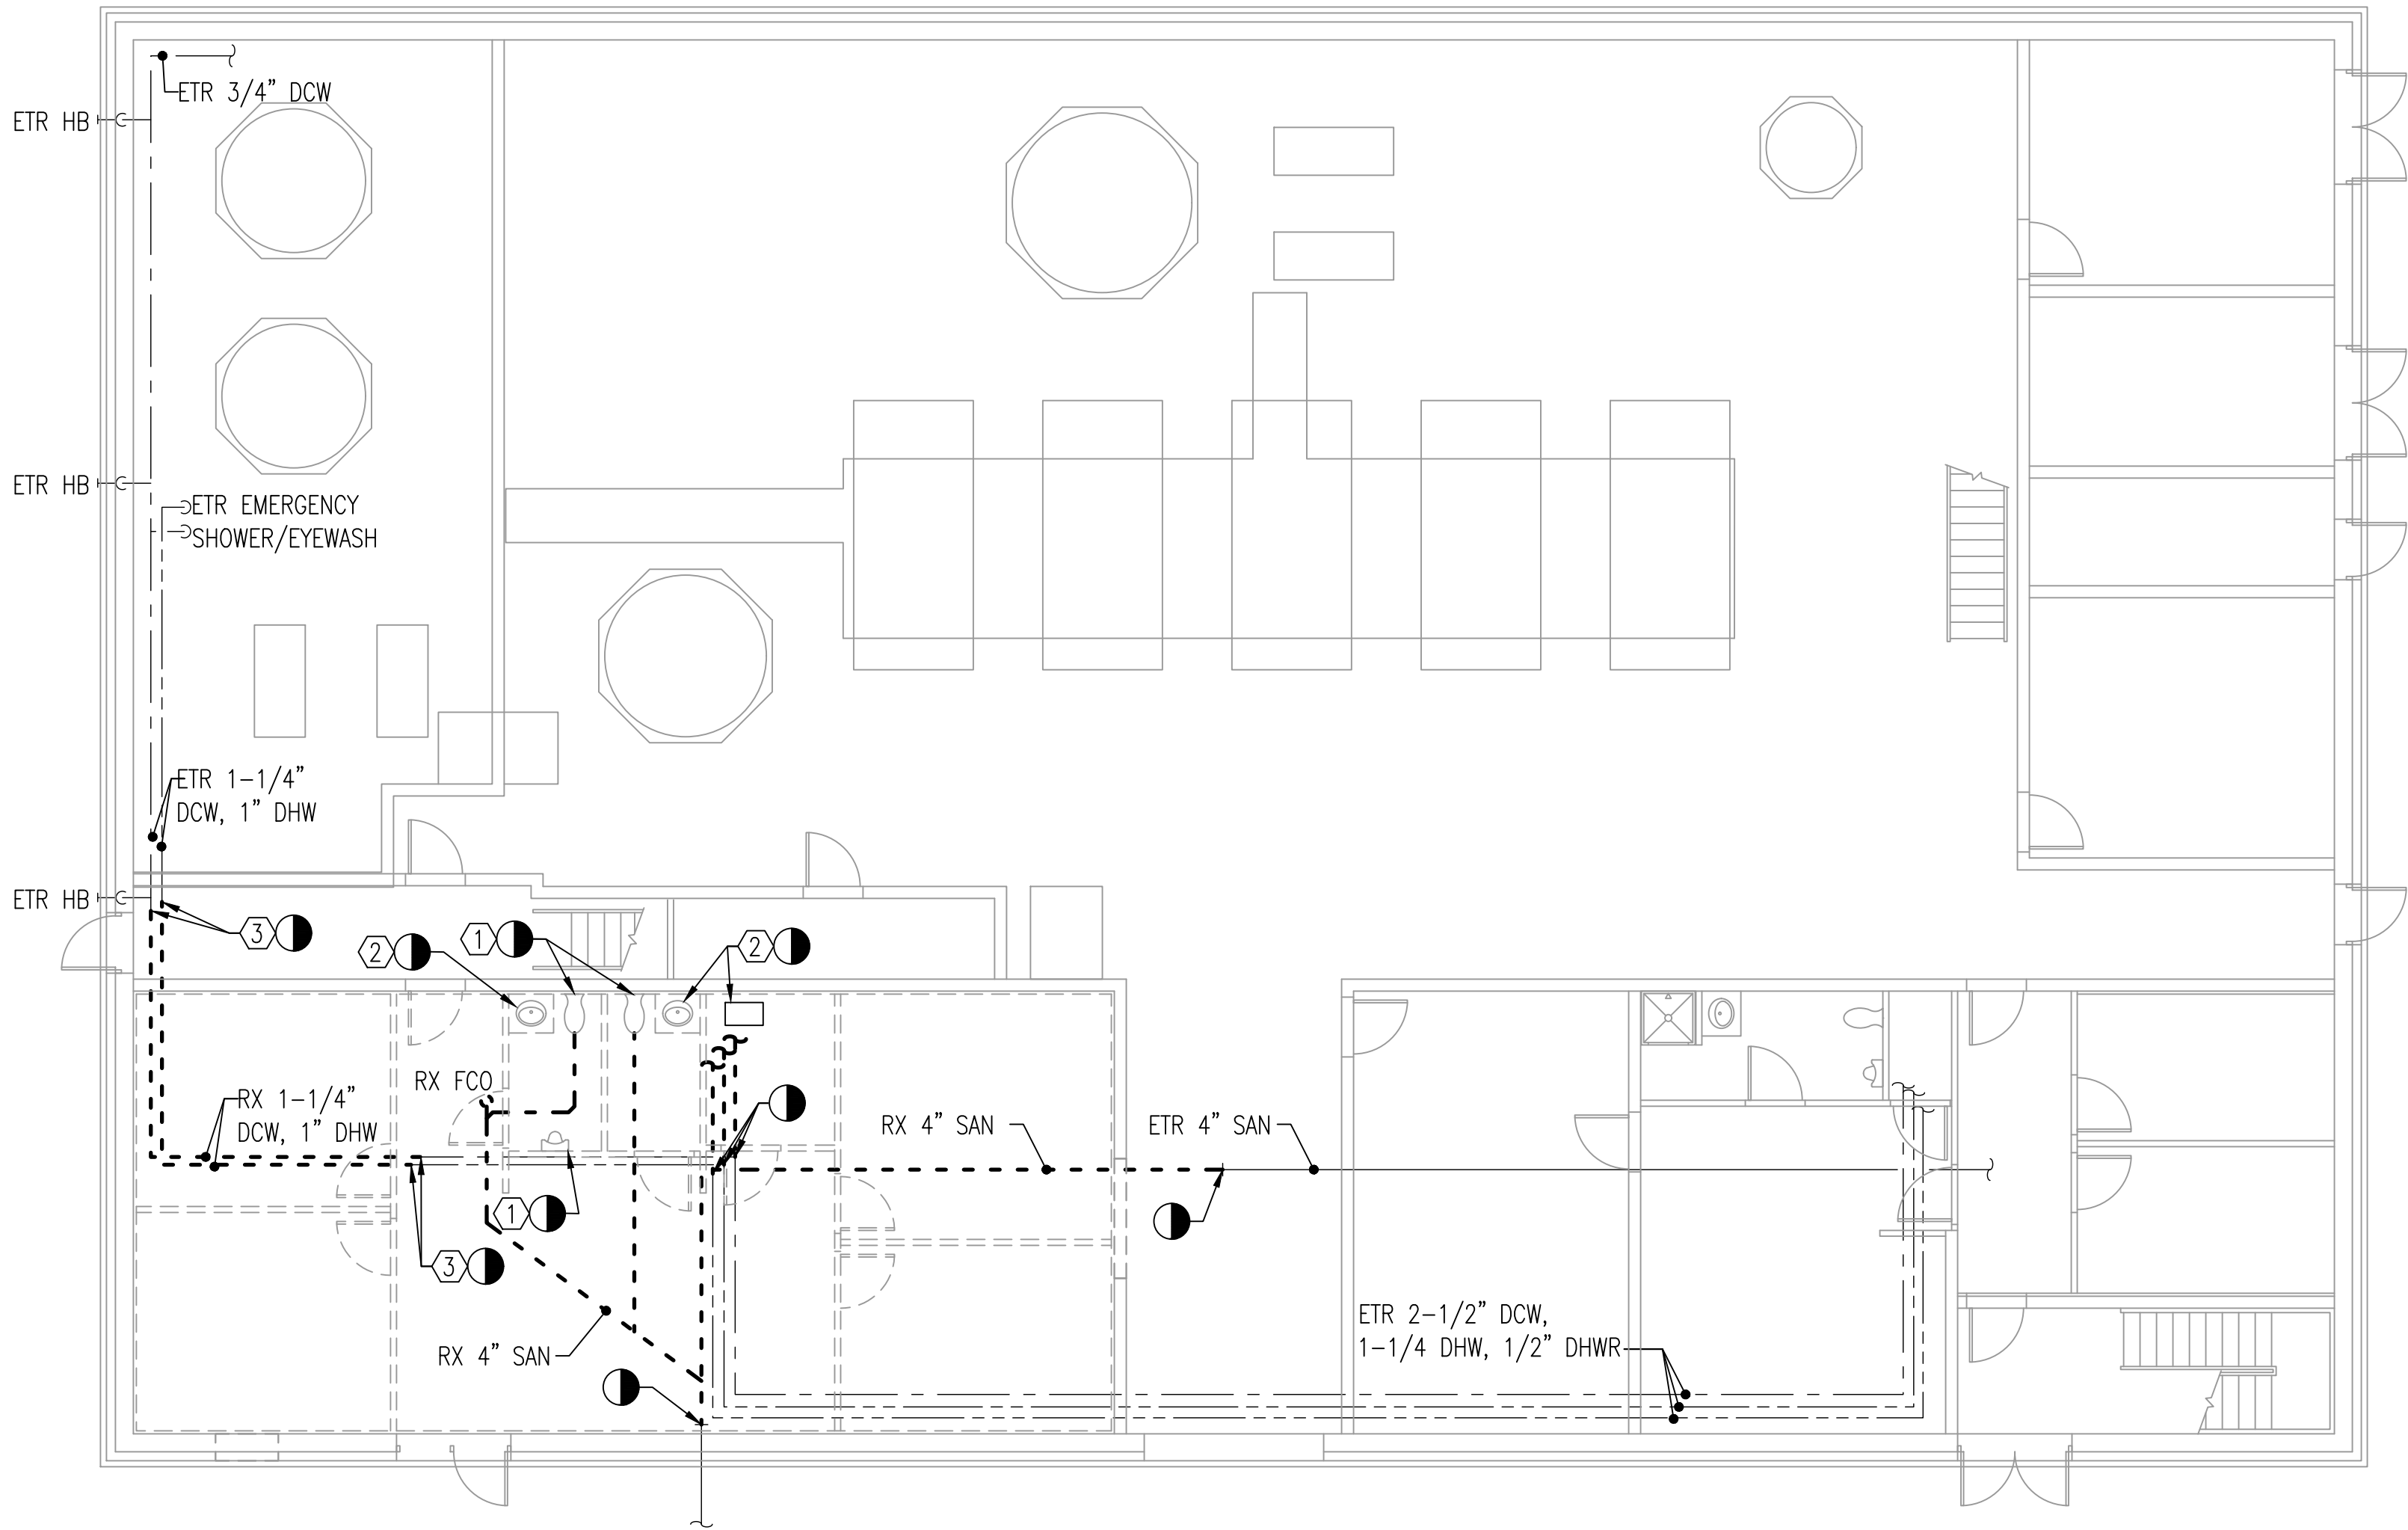

PLUMBING FLOOR PLAN - DEMOLITION

SCALE: 1/8" = 1'-0"

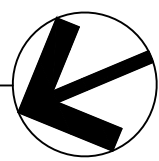

WESTERN VIRGINIA WATER AUTHORITY
601 South Jefferson Street, Suite 300
Roanoke, Virginia 24011

DES: NAE
DRAWN: NAE
CHECK: CAH
DATE: 1/24/20

SCALE: 1/8" = 1'-0"
HORIZ: N/A
VERT: N/A

CRYSTAL SPRING
PUMP STATION RELOCATION

PLUMBING FLOOR PLAN - DEMOLITION

REV	DATE	DESCRIPTION

DRAWING	SHEET
PD1.01	38