



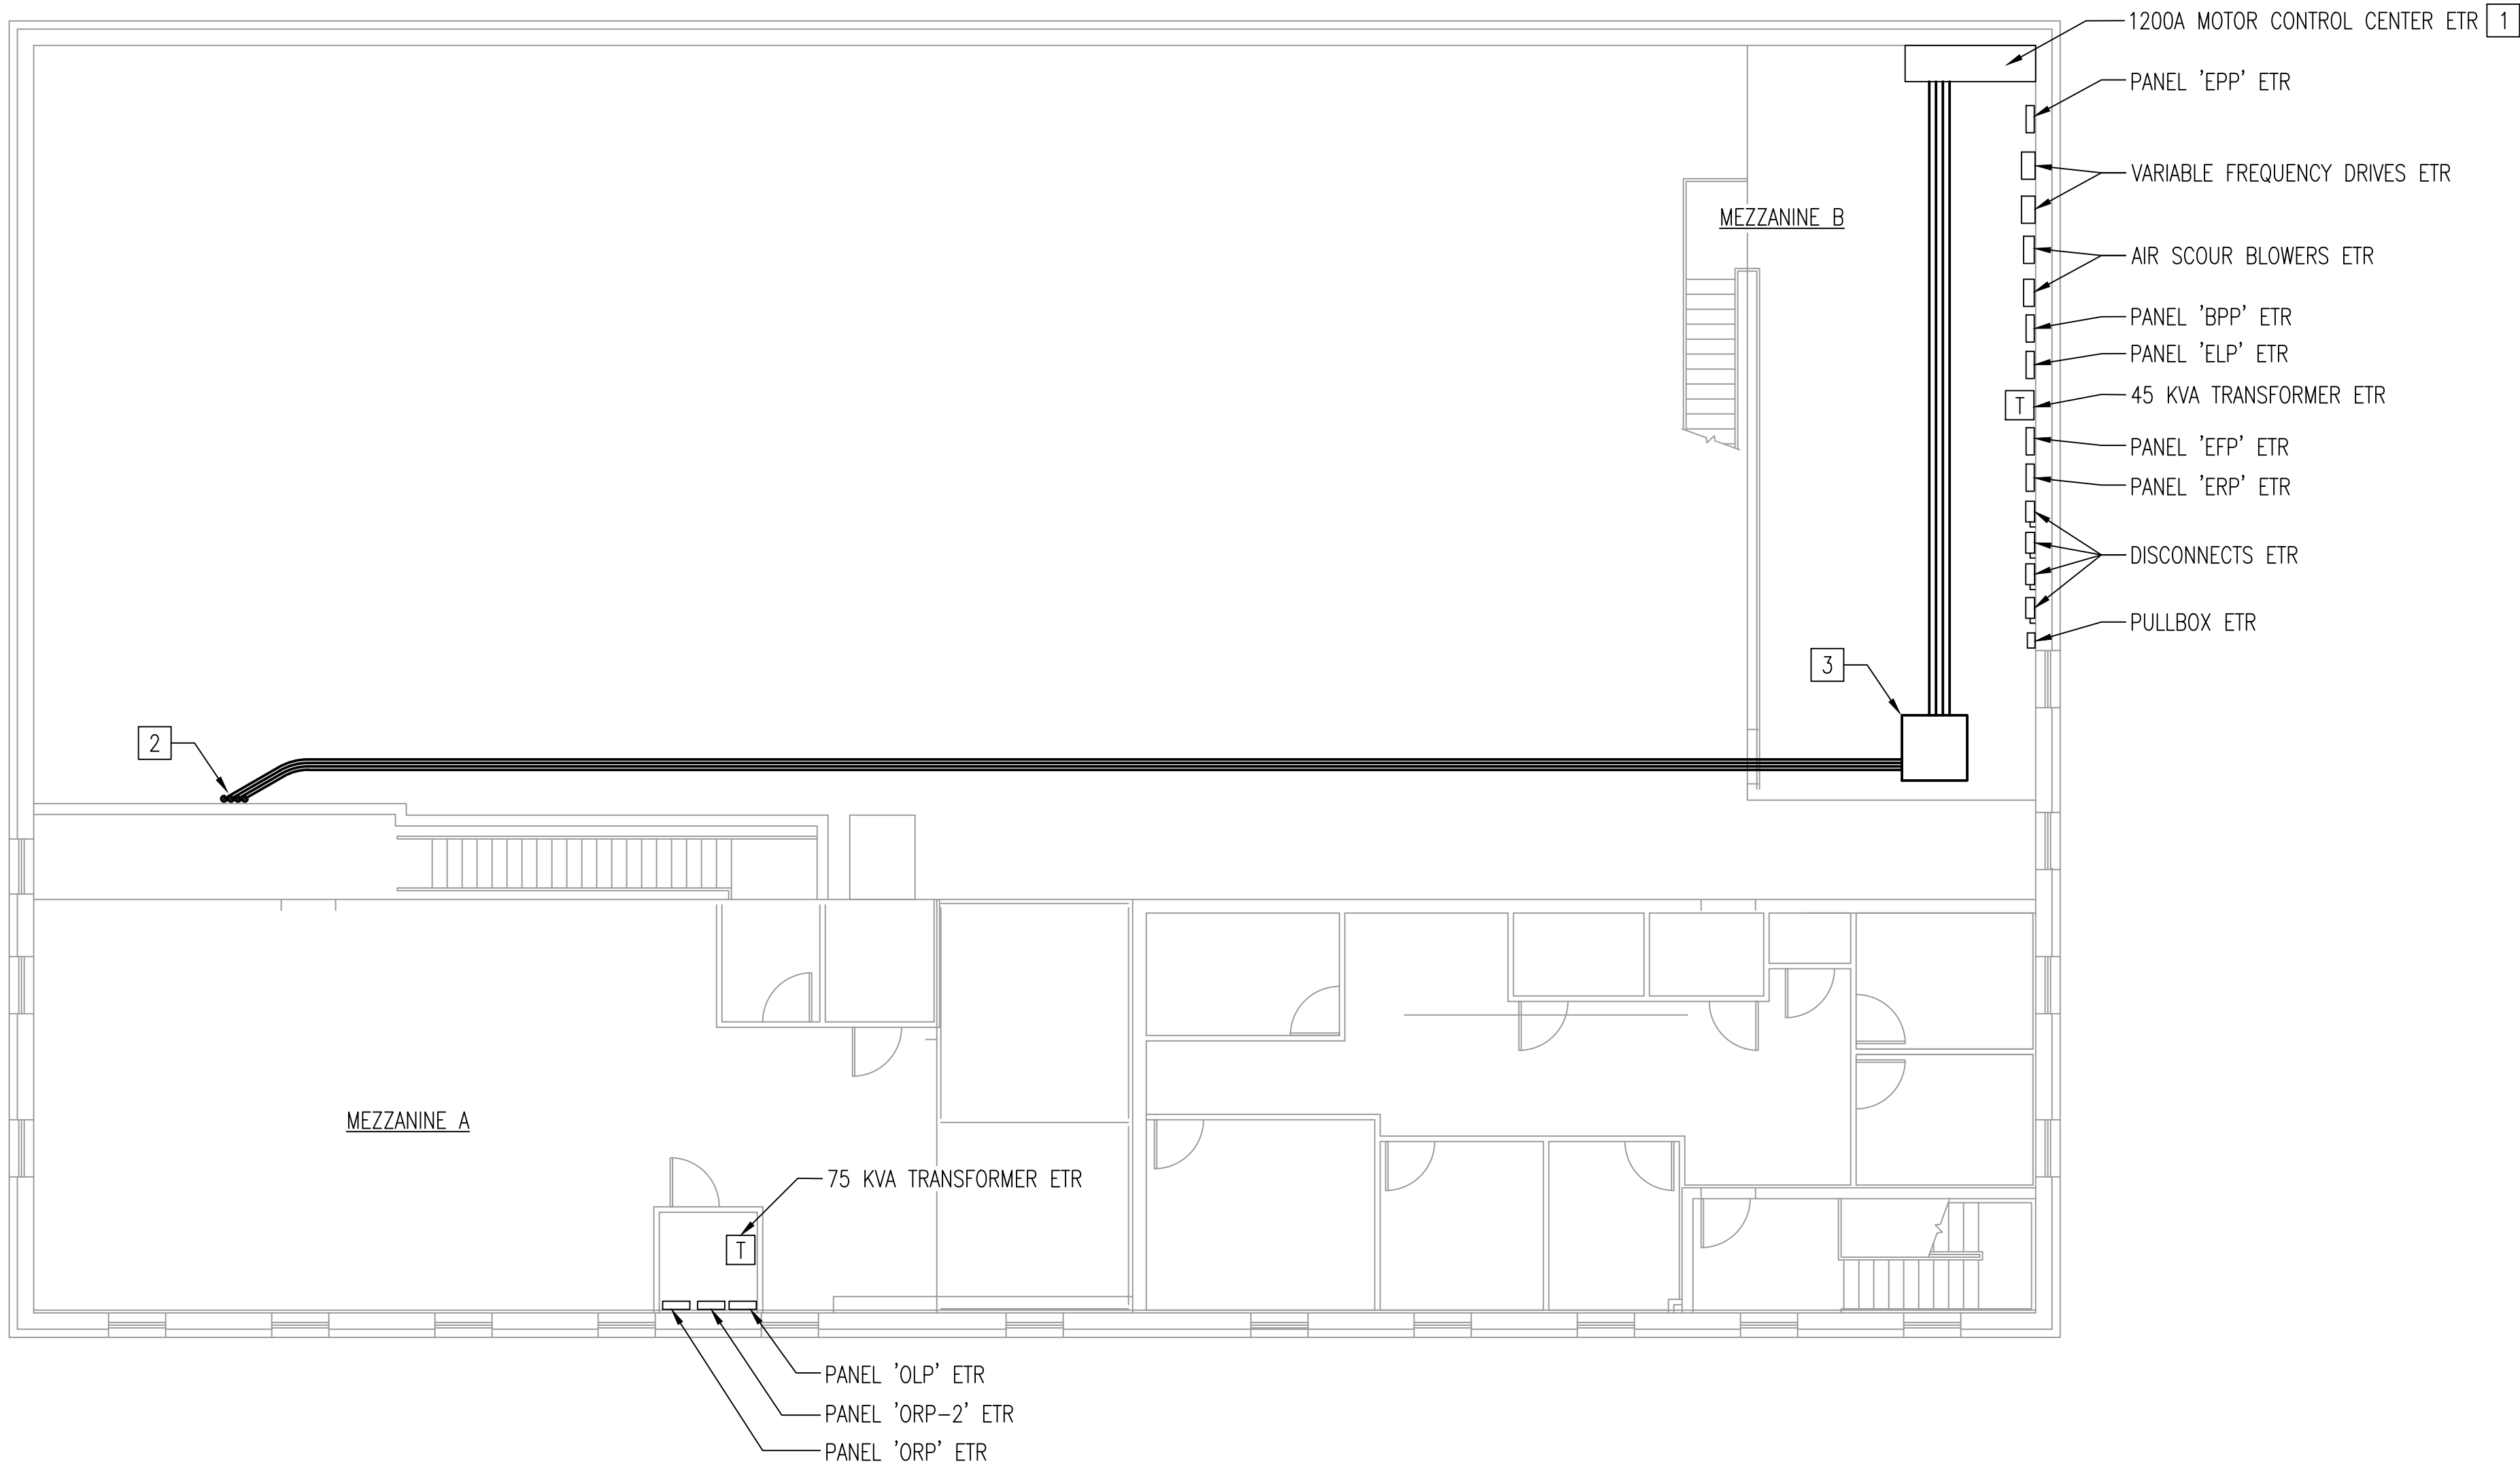

POWER MEZZANINE LEVEL PLAN
SCALE: 1/8" = 1'-0"

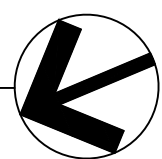


GENERAL SHEET NOTES

1. REFER TO DRAWINGS E0.01 FOR LEGEND AND ABBREVIATIONS AND E0.02 FOR DEFINITIONS AND GENERAL NOTES.
2. REFER TO DRAWING E5.01 FOR SINGLE LINE DIAGRAM.
3. REFER TO DRAWING E7.01 FOR FEEDER SCHEDULE AND DRAWING E7.02 FOR PANELBOARD SCHEDULES.
4. ALL INTERIOR ELECTRICAL EQUIPMENT SHALL BE IN NEMA 3R ENCLOSURE, UON.
5. ALL EXTERIOR ELECTRICAL EQUIPMENT SHALL BE IN NEMA 4X ENCLOSURE, UON.
6. COORDINATE FINAL LOCATIONS OF DEVICES WITH OTHER TRADES.

SHEET KEYNOTES

1. CONNECT FEEDER TO EXISTING MCC JUNCTION BOX ABOVE UNIT.
2. FEEDER TO MCC, EXTEND CONDUITS OVERHEAD. SEE DRAWING E3.01 FOR CONDUIT CONTINUATION.
3. OVERHEAD NEMA 3R RATED PULLBOX 48L"x48W"x12".

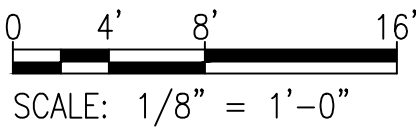



Whitman, Requardt & Associates, LLP
1700 Kraft Dr, Suite 1200, Blacksburg, VA 24060

WESTERN VIRGINIA WATER AUTHORITY
601 South Jefferson Street, Suite 300
Roanoke, Virginia 24011

DES:	EJB	SCALE:	1/8" = 1'-0"
DRAWN:	EJB	HORIZ:	N/A
CHECK:	IHK	VERT:	N/A
DATE:	1/24/20		

CRYSTAL SPRING
PUMP STATION RELOCATION

ELECTRICAL POWER PLAN –
MEZZANINE

DRAWING
E3.02

SHEET
60

REV	DATE	DESCRIPTION