




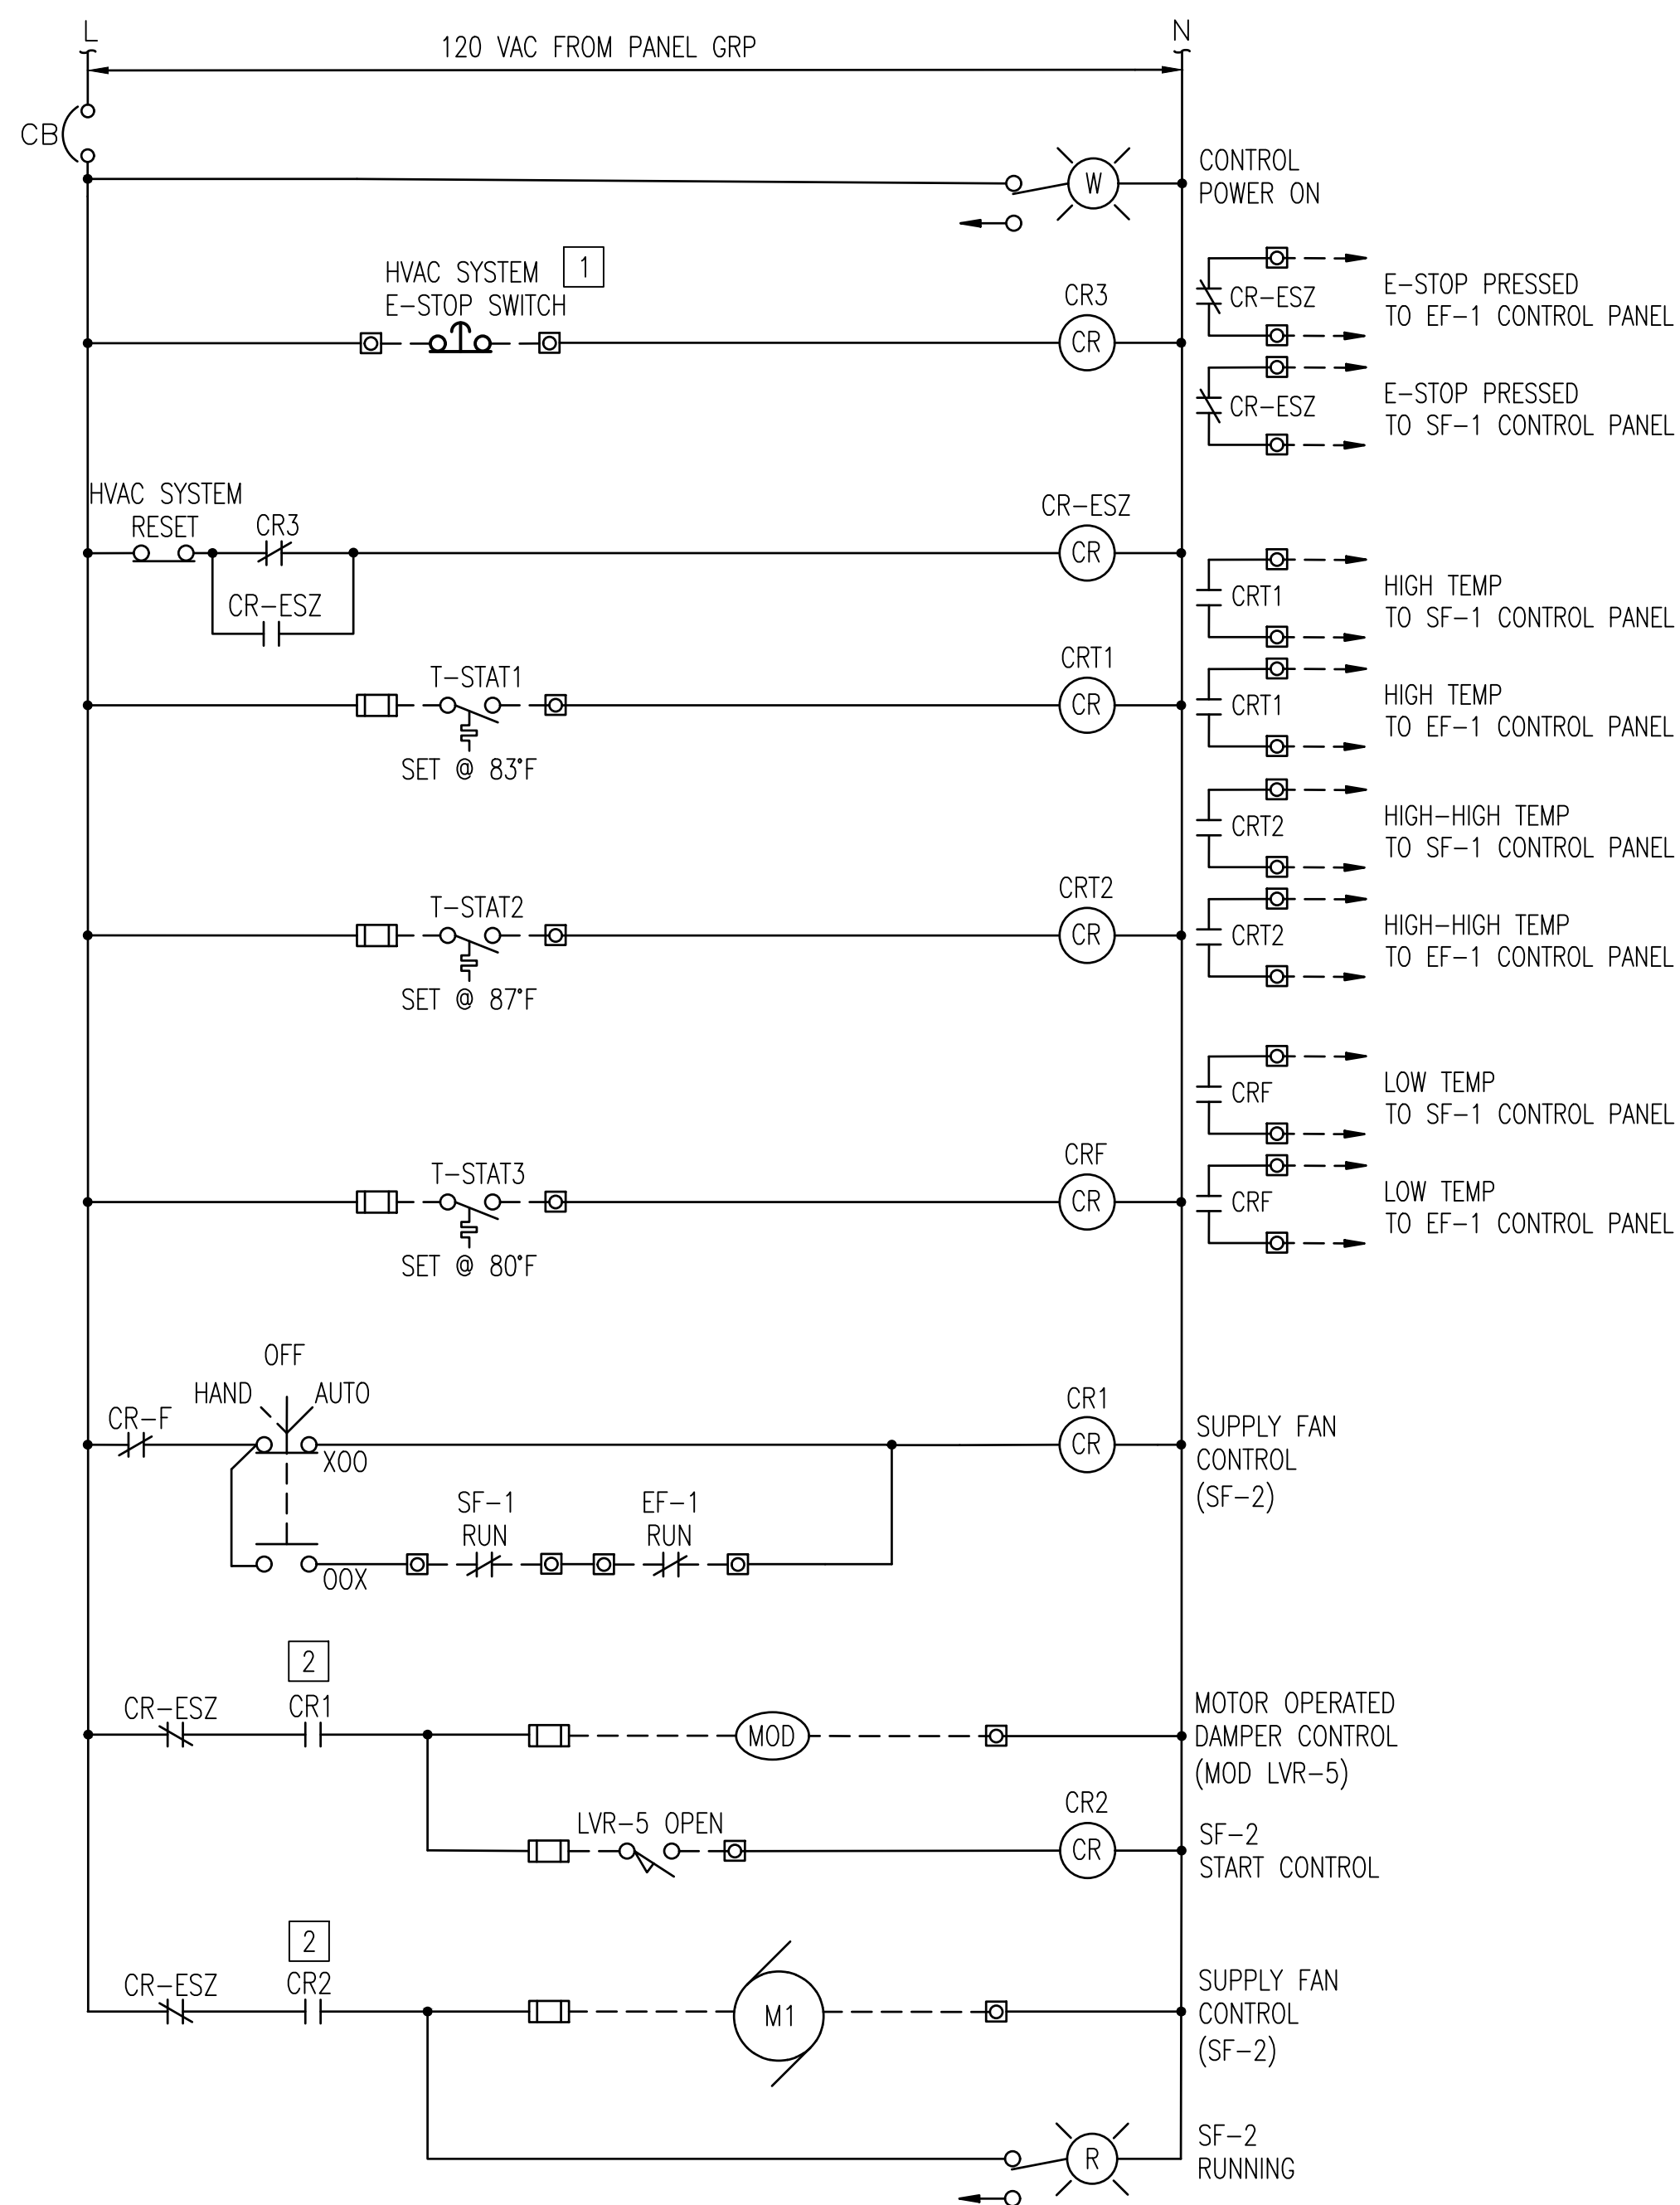


1 VENTILATION CONTROL PANEL ELEMENTARY
SCALE: NONE

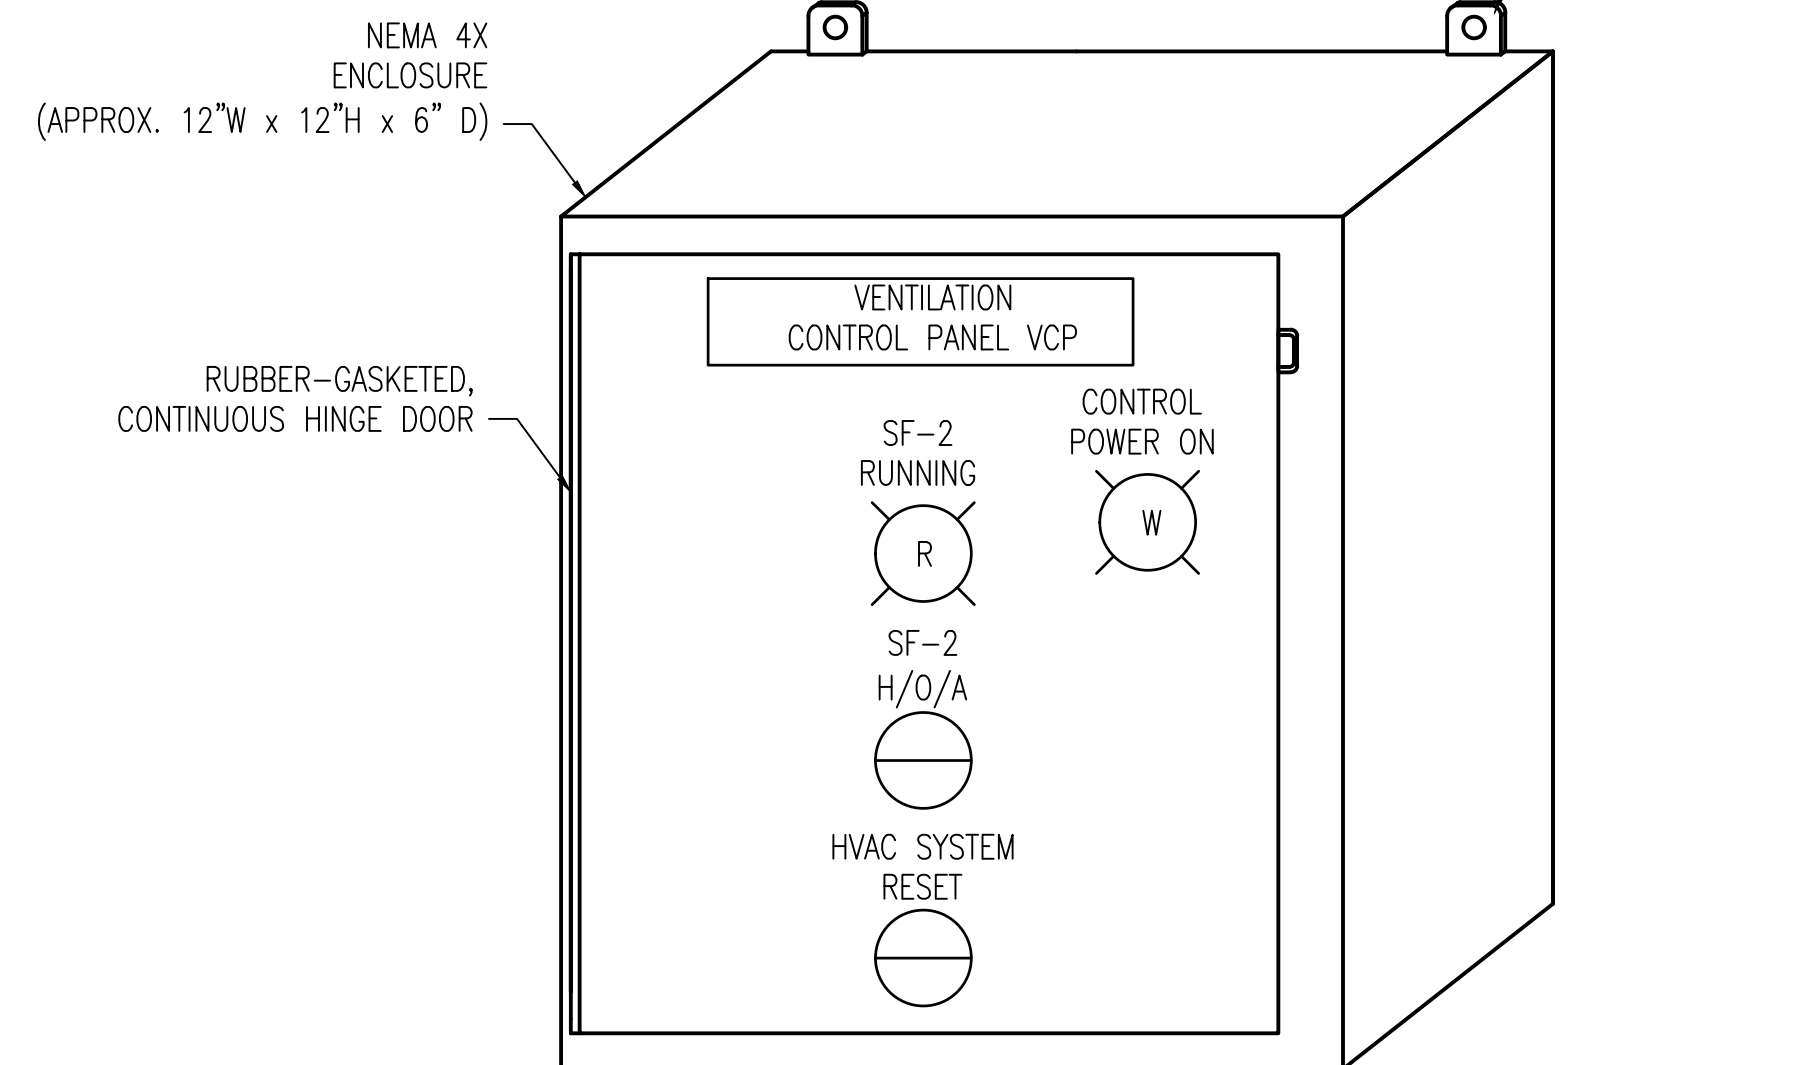

2 VENTILATION CONTROL PANEL ELEVATION
SCALE: NONE

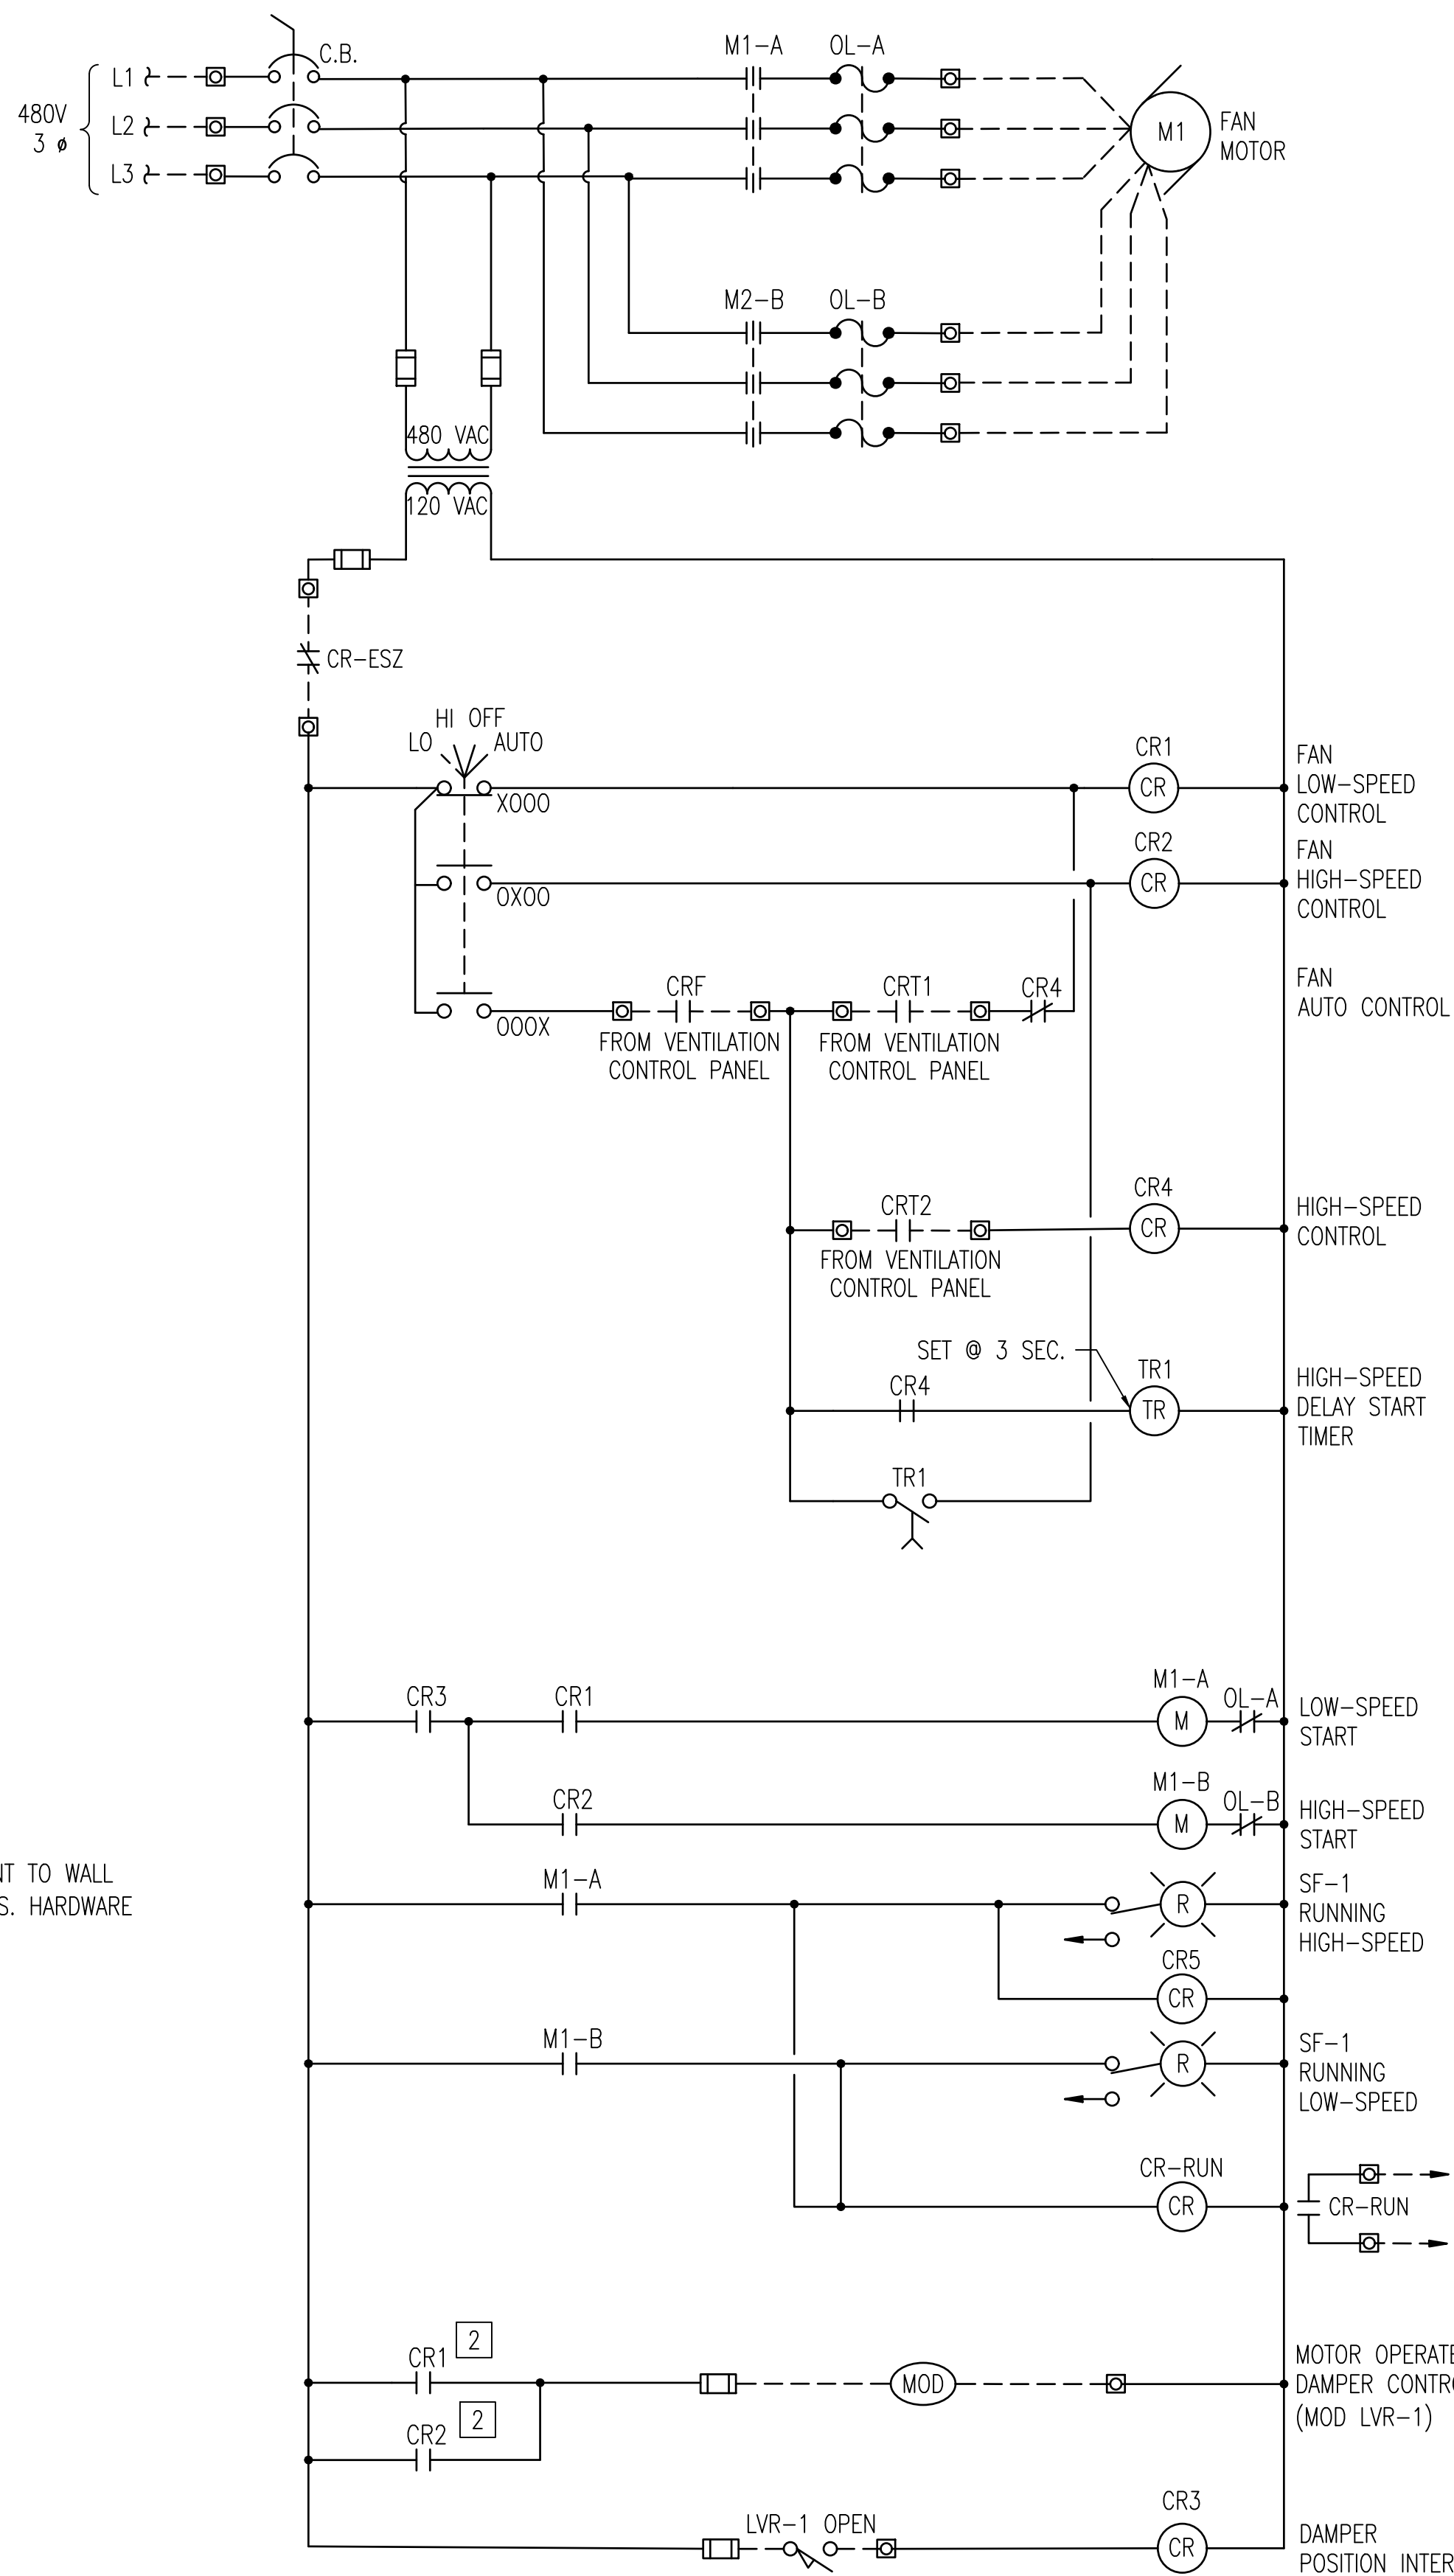

3 2-SPEED FAN MOTOR STARTER ELEMENTARY
SCALE: NONE
(SF-1 SHOWN, TYP. FOR EF-1)

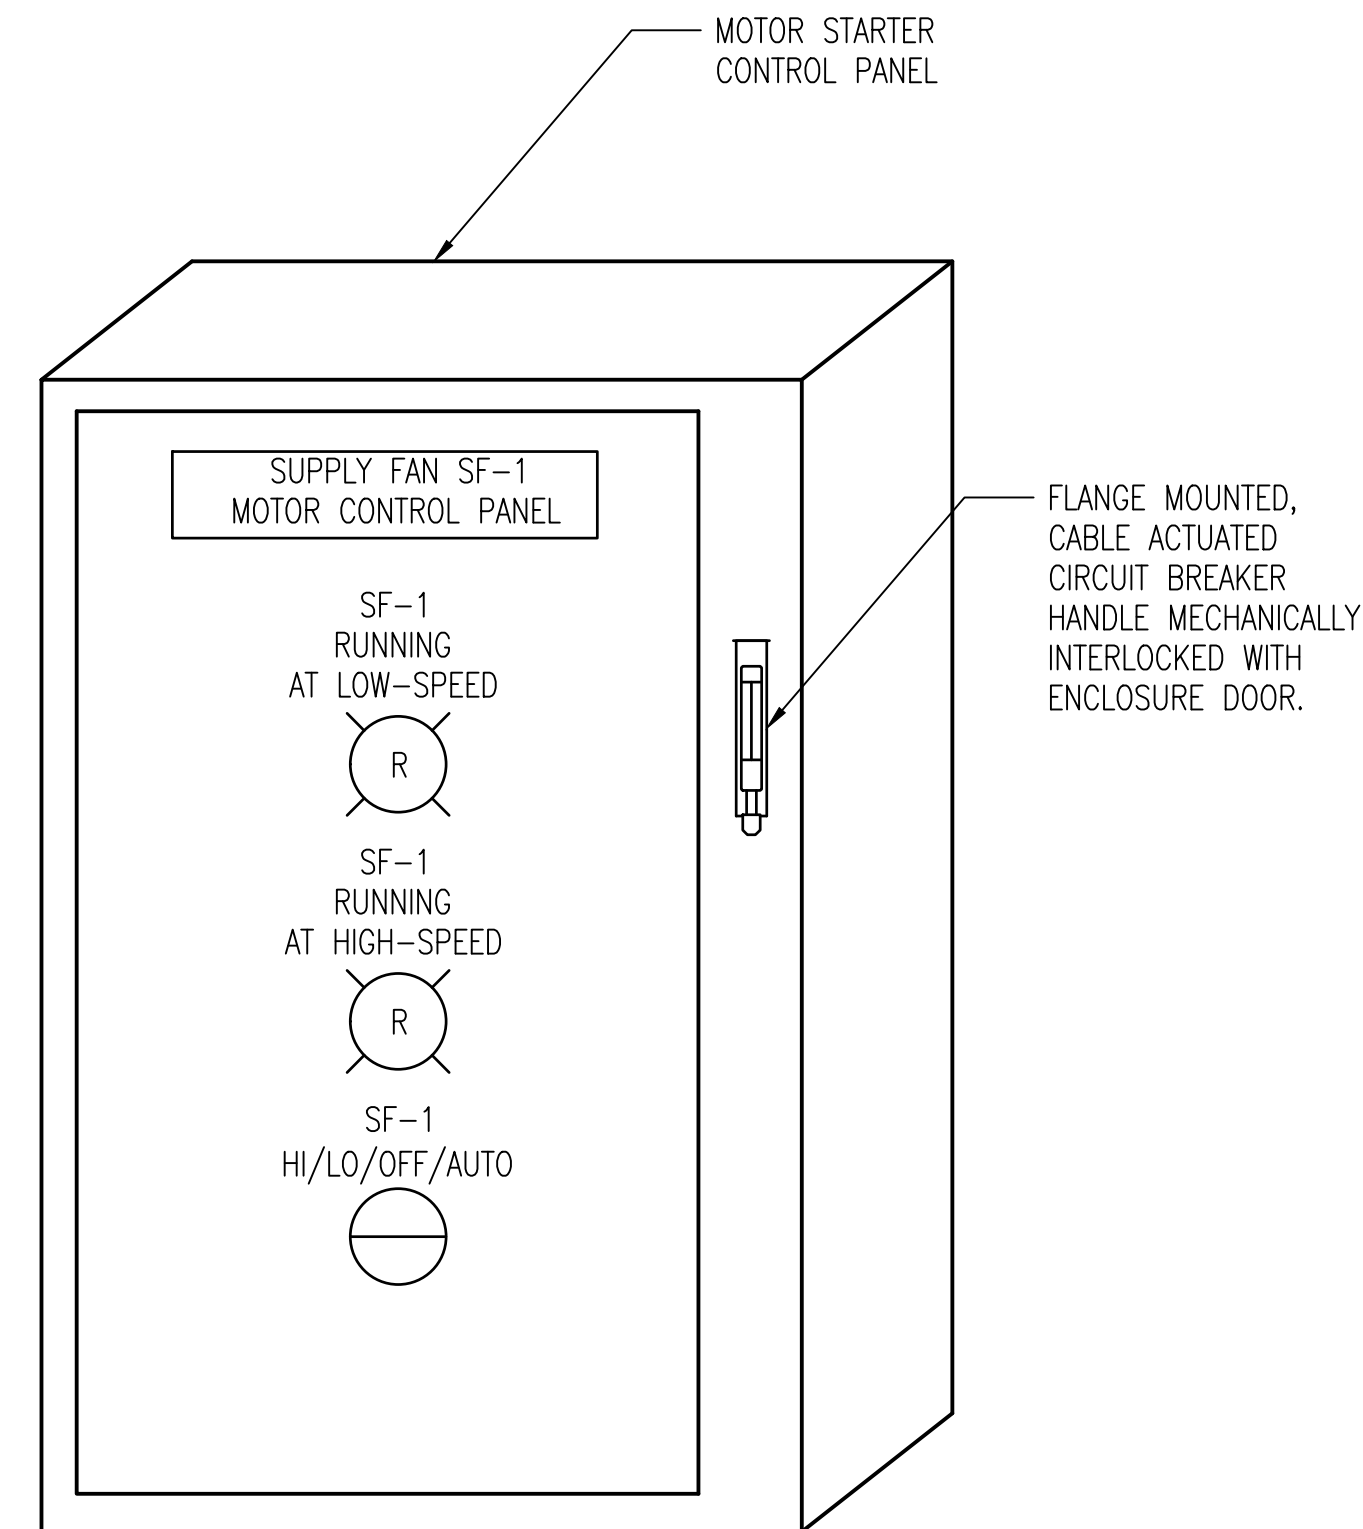


4 2-SPEED FAN MOTOR CONTROL PANEL ELEVATION
SCALE: NONE
(SF-1 SHOWN, TYP. FOR EF-1)

GENERAL SHEET NOTES

- SEE I&C SYMBOLS, LEGENDS AND ABBREVIATIONS SHEETS FOR DETAILS.
- LABEL ALL EQUIPMENT WITHIN THE CONTROL PANEL INCLUDING TERMINAL BLOCKS, RELAYS AND CIRCUIT BREAKERS WITH ASSOCIATED CIRCUIT OR ID NUMBER.
- REFER TO ELECTRICAL & MECHANICAL DRAWINGS FOR ADDITIONAL INSTALLATION, LOCATIONS, AND EQUIPMENT REQUIREMENTS.

SHEET KEYNOTES [X]

- EMERGENCY HVAC SHUTOFF SWITCH. REFER TO PLAN DRAWING FOR LOCATION.
- PROVIDE MOTOR STARTER RELAY RATED FOR MOTOR FULL LOAD.

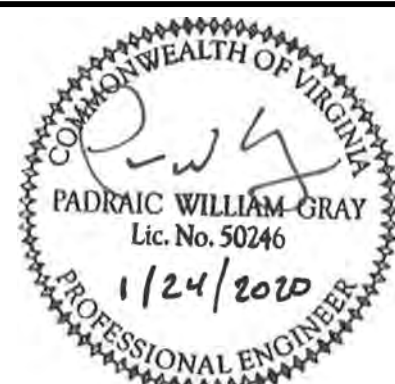

WESTERN VIRGINIA WATER AUTHORITY
601 South Jefferson Street, Suite 300
Roanoke, Virginia 24011

DES: JJN
DRAWN: JJN
CHECK: PWG
DATE: 1/24/20

SCALE: NOT TO SCALE
HORIZ: N/A
VERT: N/A

CRYSTAL SPRING
PUMP STATION RELOCATION

HVAC CONTROL DIAGRAMS

DRAWING
10.10

SHEET
76