



CRYSTAL SPRING
WATER TREATMENT PLANT
CITY OF ROANOKE, VIRGINIA

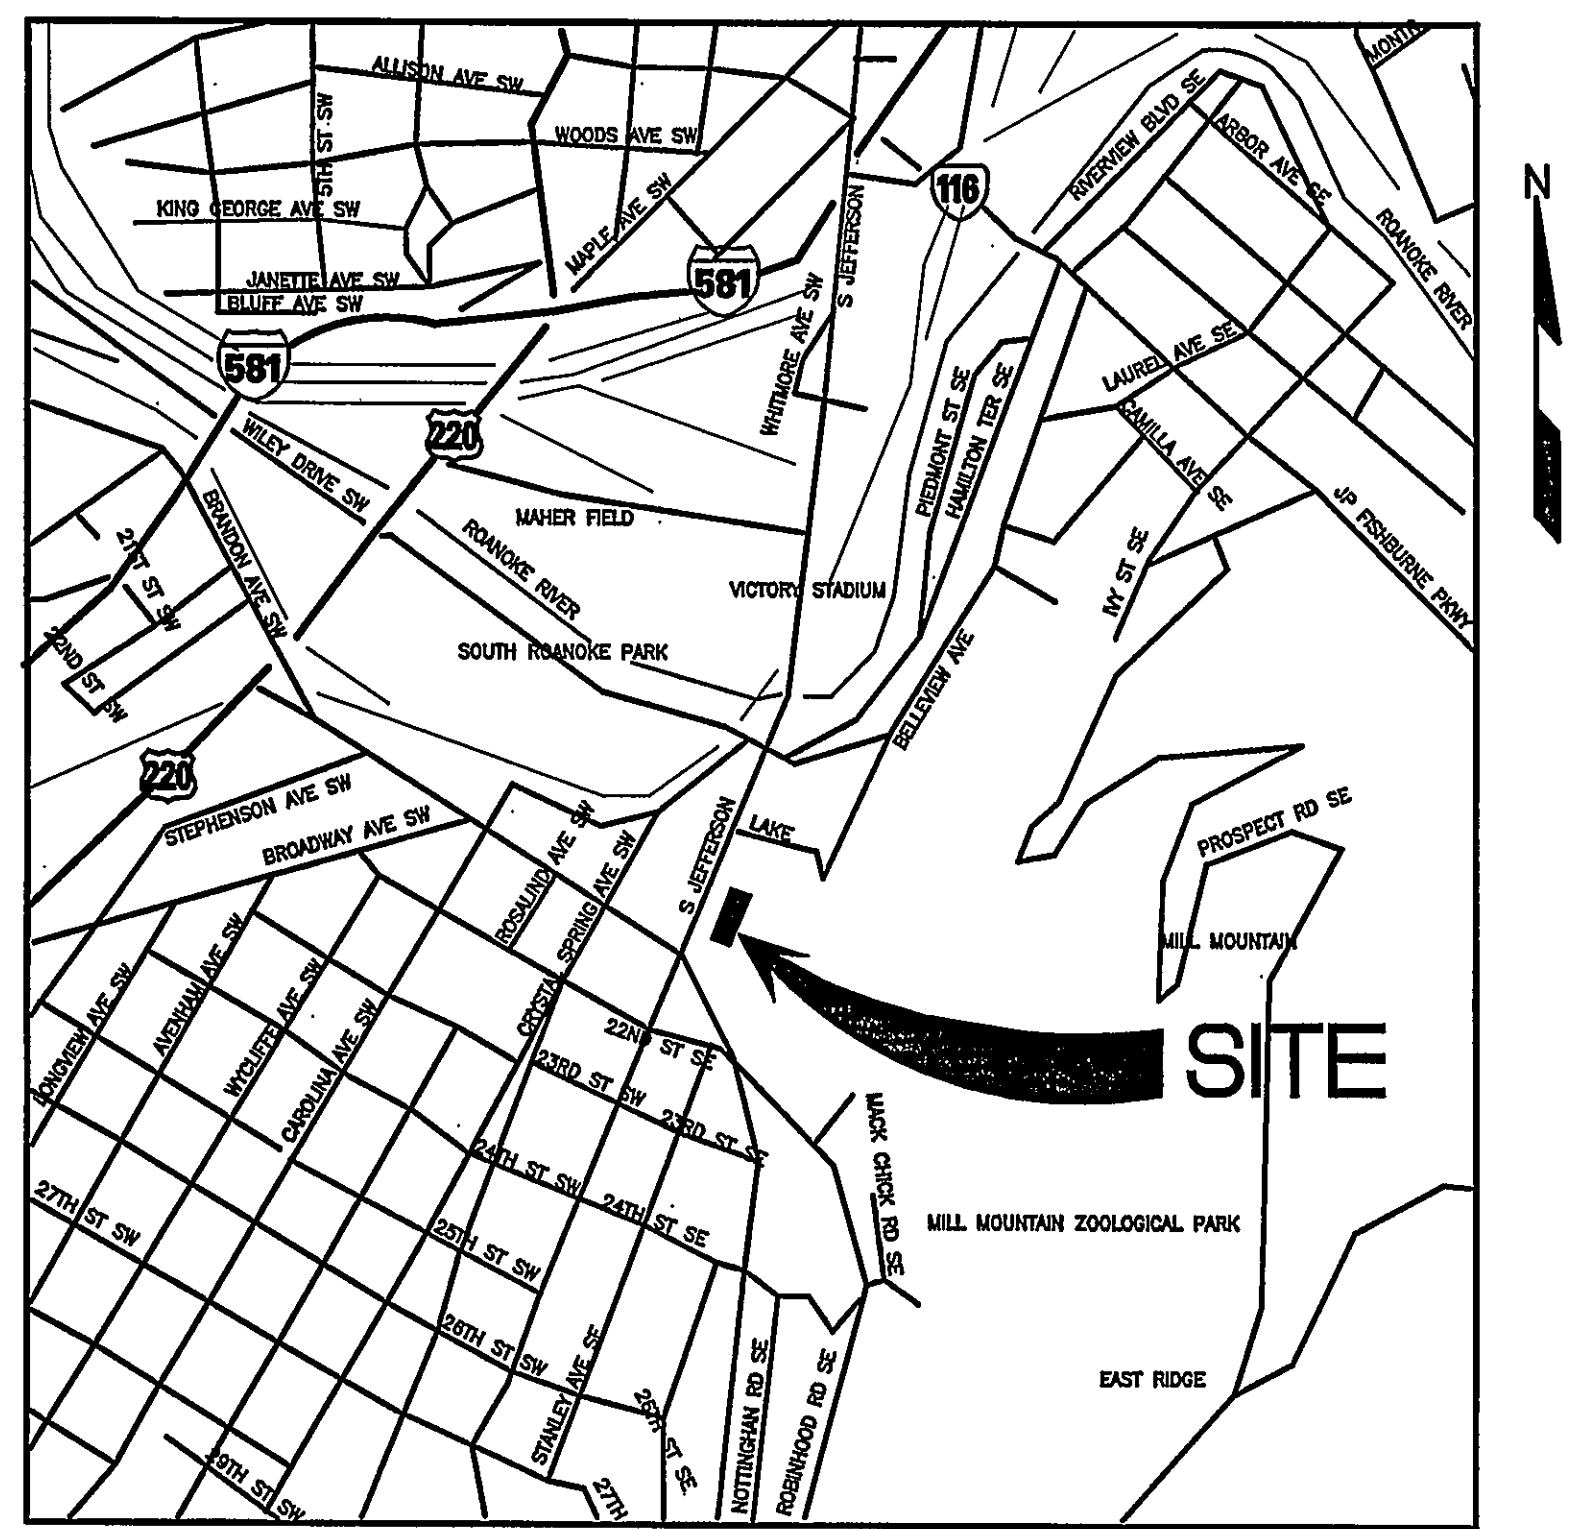

LOCATION MAP
NOT TO SCALE

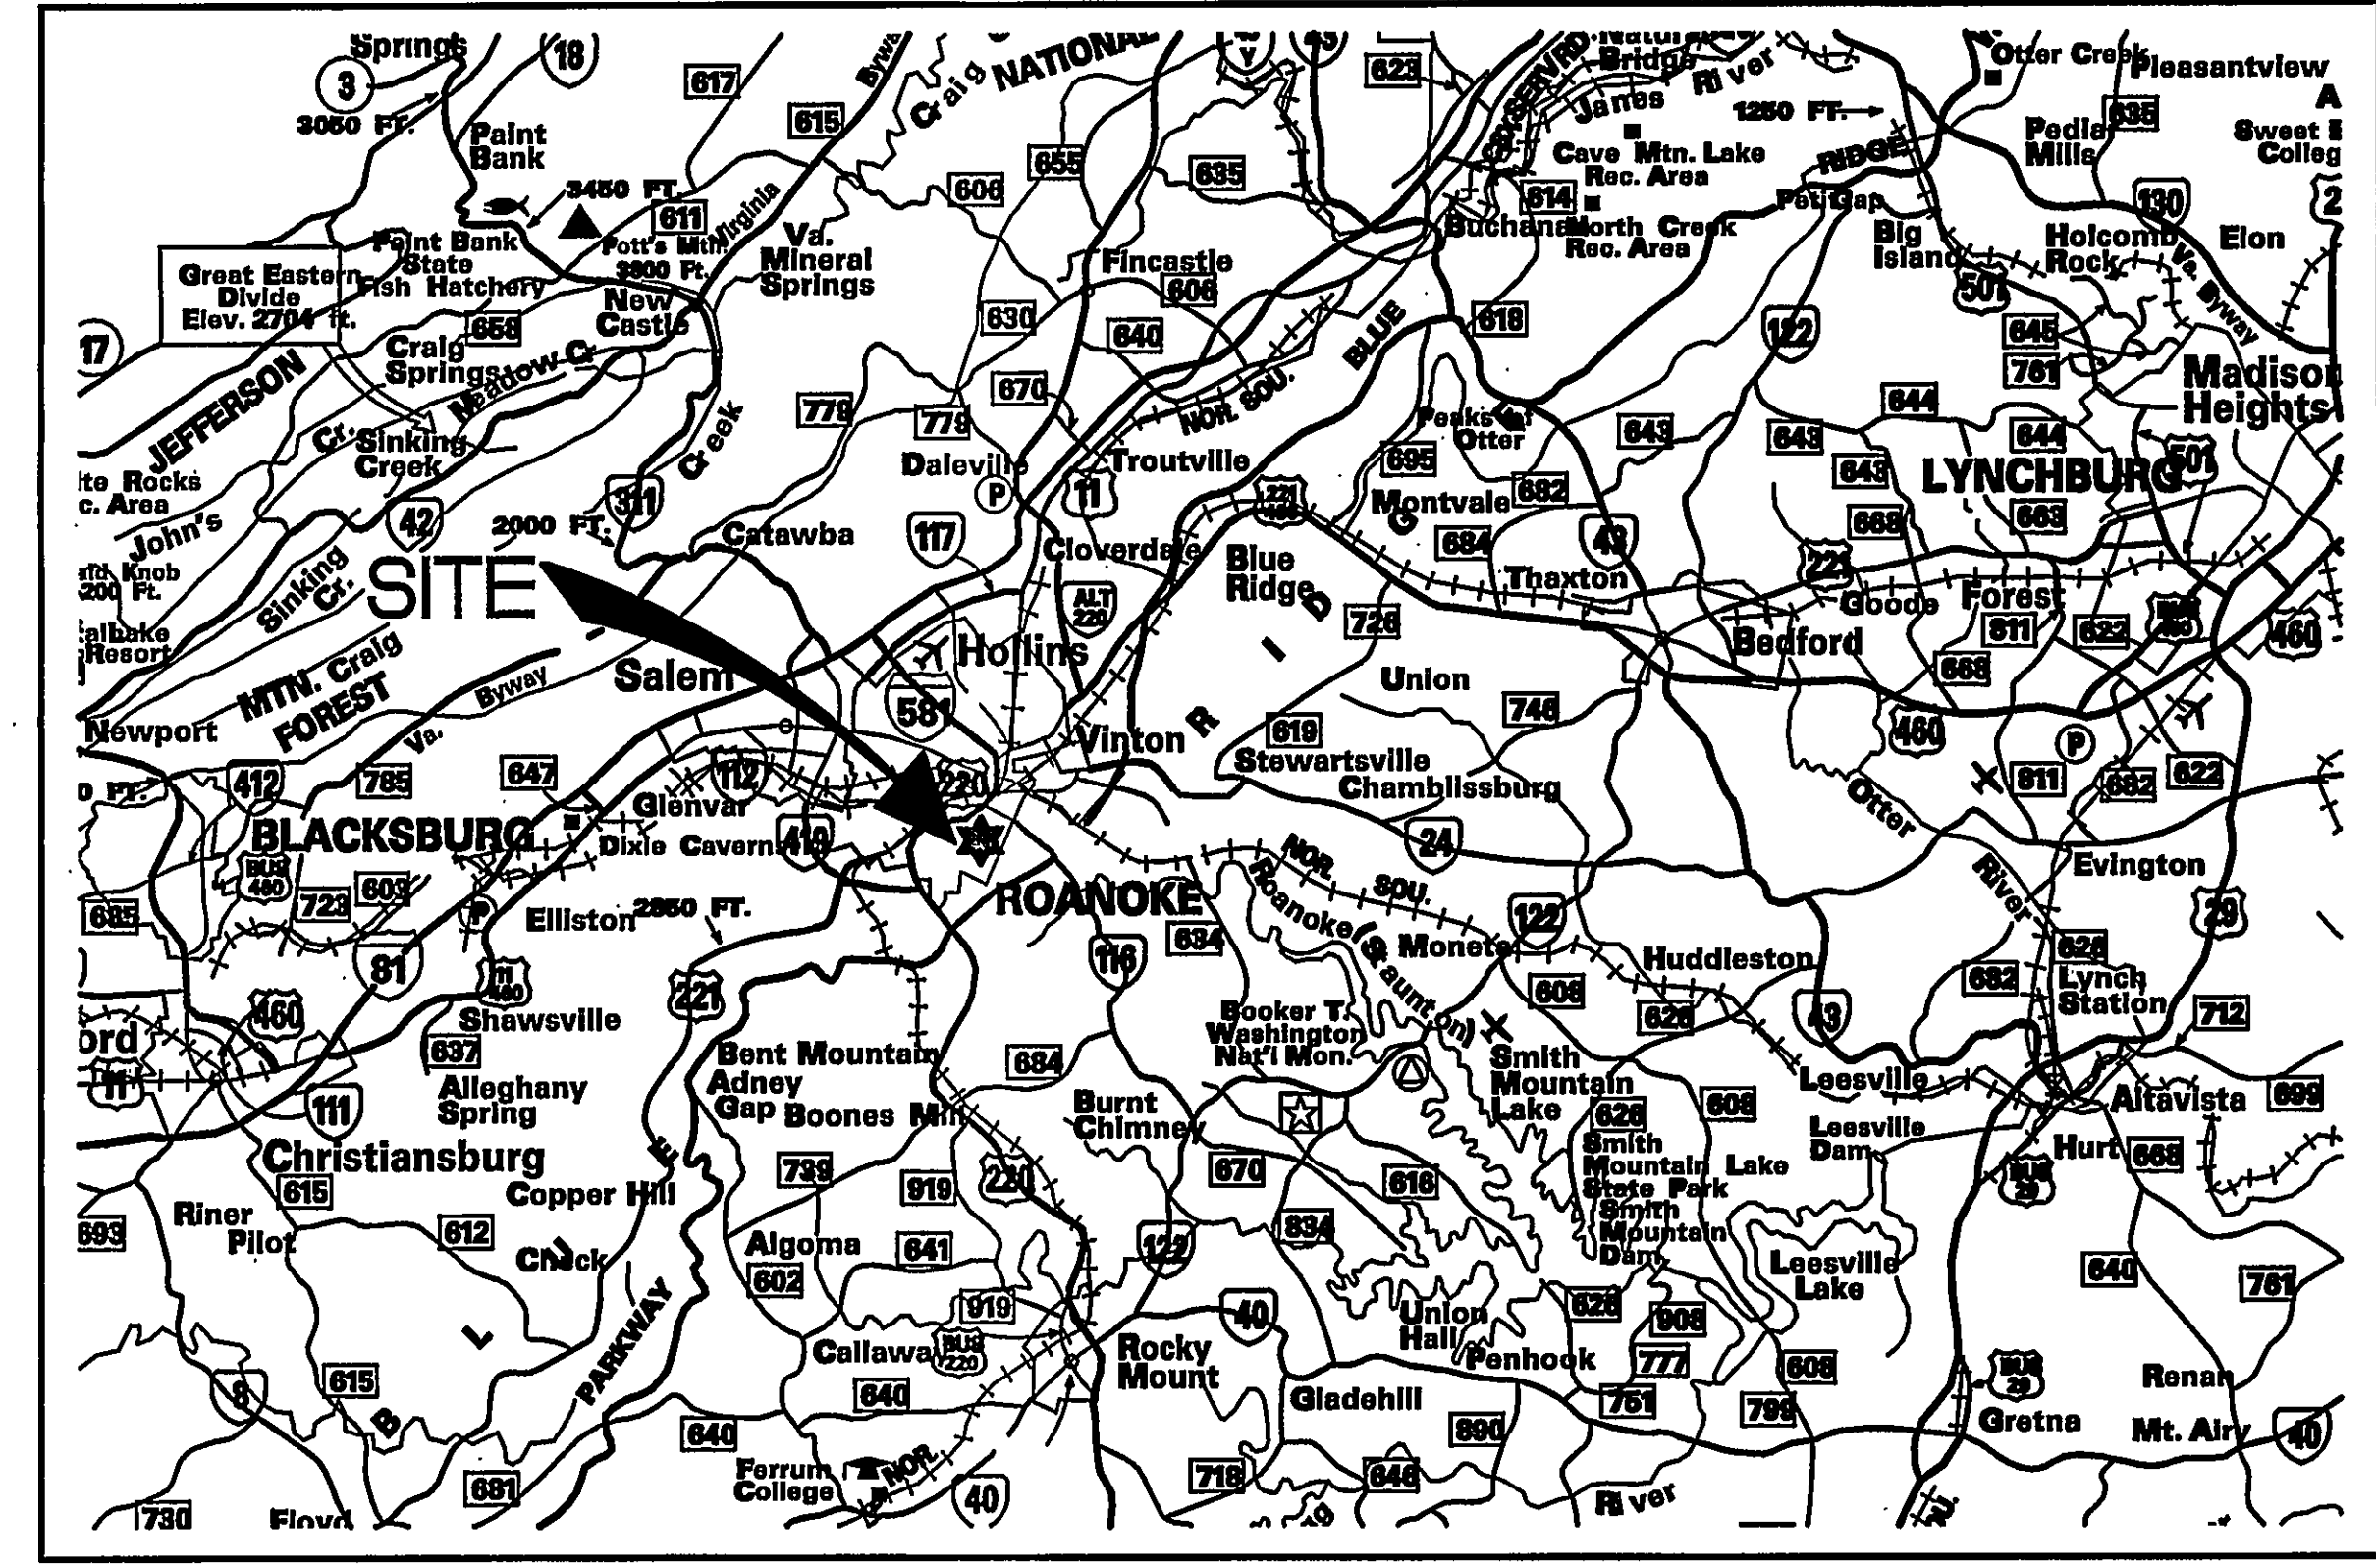

VICINITY MAP
NOT TO SCALE

DRAWING INDEX

SHEET NO.	DWG. NO.	TITLE	SHEET NO.	DWG. NO.	TITLE	SHEET NO.	DWG. NO.	TITLE	SHEET NO.	DWG. NO.	TITLE
GENERAL			STRUCTURAL			PROCESS			ELECTRICAL		
1	CS-1	COVER SHEET	22	S-1	FOUNDATION PLAN	45	P-17	COMPRESSOR/AIR SYSTEM SECTIONS	62	E-1	LEGEND, ABBREVIATIONS, AND ONE-LINE DIAGRAM
CIVIL			23	S-2	SECOND FLOOR & MEZZANINE FRAMING PLAN	46	P-19	CHLORINE AND FLUORIDE FEED SECTIONS	63	E-2	ONE-LINE DIAGRAM
2	D-1	SITE DEMOLITION PLAN	24	S-3	ROOF FRAMING PLANS	47	P-20	TANK SCHEDULE	64	E-3	ELECTRICAL SERVICE, LIGHTNING PROTECTION, AND GROUNDING PLAN
3	C-1	SITE PLAN - DIMENSIONAL LAYOUT	25	S-4	TRUSS ELEVATIONS AND DETAILS	48	P-21	VALVE SCHEDULE	65	E-4	MEZZANINE PLAN - ELECTRICAL SERVICE AND DISTRIBUTION EQUIPMENT
4	C-2	SITE PLAN - GRADING AND UTILITIES	26	S-5	STEEL ROOF SECTIONS AND DETAILS	49	P-22	DETAILS	66	E-5	MAIN FLOOR PLAN - LIGHTING
5	C-3	EROSION CONTROL PLAN & DETAILS	27	S-6	FOUNDATION SECTIONS & DETAILS	50	P-23	DETAILS	67	E-6	SECOND FLOOR AND MEZZANINE PLAN - LIGHTING
6	C-4	UTILITY AND ROAD PROFILES	28	S-7	GENERAL NOTES AND STANDARD DETAILS	51	P-24	P&ID LEGEND	68	E-7	MAIN FLOOR PLAN - POWER
7	C-5	PLAN, ELEVATIONS AND SECTION PUMP STATION & STRAINER VAULT	PROCESS			52	P-25	P&ID FEED & BACKWASH FORWARDING SYSTEM	69	E-8	SECOND FLOOR AND MEZZANINE PLAN - POWER
8	C-6	SPRING BOX AND RESERVOIR MODIFICATIONS	29	P-1	LEGEND & ABBREVIATIONS	53	P-26	P&ID E108M10C-102 CMF TRAIN	70	E-9	ELECTRICAL SITE PLAN
9	C-7	PUMP STATIONS AND VAULTS PLANS, SECTIONS & DETAILS	30	P-2	GENERAL SITE SCHEMATIC	54	P-27	P&ID CLEAN IN PLACE AND CHEMICAL HANDLING SYSTEM	71	E-10	SCHEDULES
10	C-8	NEUTRALIZATION TANK AND PUMP STATION	31	P-3	DETAILED PROCESS SCHEMATIC	55	P-28	P&ID WASTE, NEUTRALIZATION	72	E-11	PANEL SCHEDULES
11	C-9	DETAILS	32	P-4	MISCELLANEOUS SCHEMATICS	56	P-29	P&ID PROCESS AND CONTROL AIR			
ARCHITECTURAL			33	P-5	CIP SCHEMATIC	MECHANICAL					
12	A-1	MAIN FLOOR AND ROOF PLAN	34	P-6	AIR DELIVERY SCHEMATIC	57	M-1	HVAC PLAN - 1ST & 2ND FLOOR			
13	A-2	SECOND FLOOR PLAN	35	P-7	HYDRAULIC PROFILE	58	M-2	HEAT PUMP WATER PIPING SCHEMATIC			
14	A-3	WEST AND SOUTH ELEVATIONS	36	P-8	PLAN - PROCESS	59	M-3	SCHEDULES			
15	A-4	EAST AND NORTH ELEVATIONS	37	P-9	TRENCH & UNDER SLAB PIPING PLAN						
16	A-5	FINISH SCHEDULE	38	P-10	PLAN - MODULAR UNITS	60	PL-1	PLUMBING & FIRE SUPPRESSION			
17	A-6	OPENING SCHEDULE & DETAILS	39	P-11	PLAN - COMPRESSOR & CHEMICAL FEED	61	PL-2	PLUMBING SCHEDULE & RISERS			
18	A-7	WALL SECTIONS	40	P-12	PLAN - CIP EQUIPMENT						
19	A-8	ENLARGED STAIR PLANS AND DETAILS	41	P-13	MICROFILTRATION UNIT SECTIONS						
20	A-9	ENLARGED STAIR PLANS AND DETAILS	42	P-14	MICROFILTRATION UNIT SECTIONS						
21	A-10	REFLECTED CEILING PLANS	43	P-15	BACKWASH FORWARDING SYSTEM SECTIONS						
			44	P-16	CIP DELIVERY SYSTEM SECTIONS						

RECORD DRAWING
DATE: MAY 1, 2003

Wiley & Wilson
ARCHITECTS ENGINEERS PLANNERS
An Employee-Owned Company

2310 LANGHORNE ROAD
LYNCHBURG, VIRGINIA 24501
(804) 947-1901

P.O. BOX 877
LYNCHBURG, VIRGINIA 24505-0877

IN ASSOCIATION WITH

HDR
HDR Engineering, Inc.
5700 LAKE WRIGHT DRIVE
NORFOLK, VIRGINIA 23502
757-222-1500

DESIGNED JLW	DRAWN JLW/EJLB	PROJECT CRYSTAL SPRING WATER TREATMENT PLANT FOR THE CITY OF ROANOKE, VIRGINIA
CHECKED MKJ	REVIEWED	REFERENCE GENERAL
COMM. NO. 200171.01		TITLE COVER SHEET
CADD NO. 2001711.DGN		
DATE AUG 26, 2001	DWG. NO. CS-1	SHEET NO. 1 OF 72
		REV. 0