
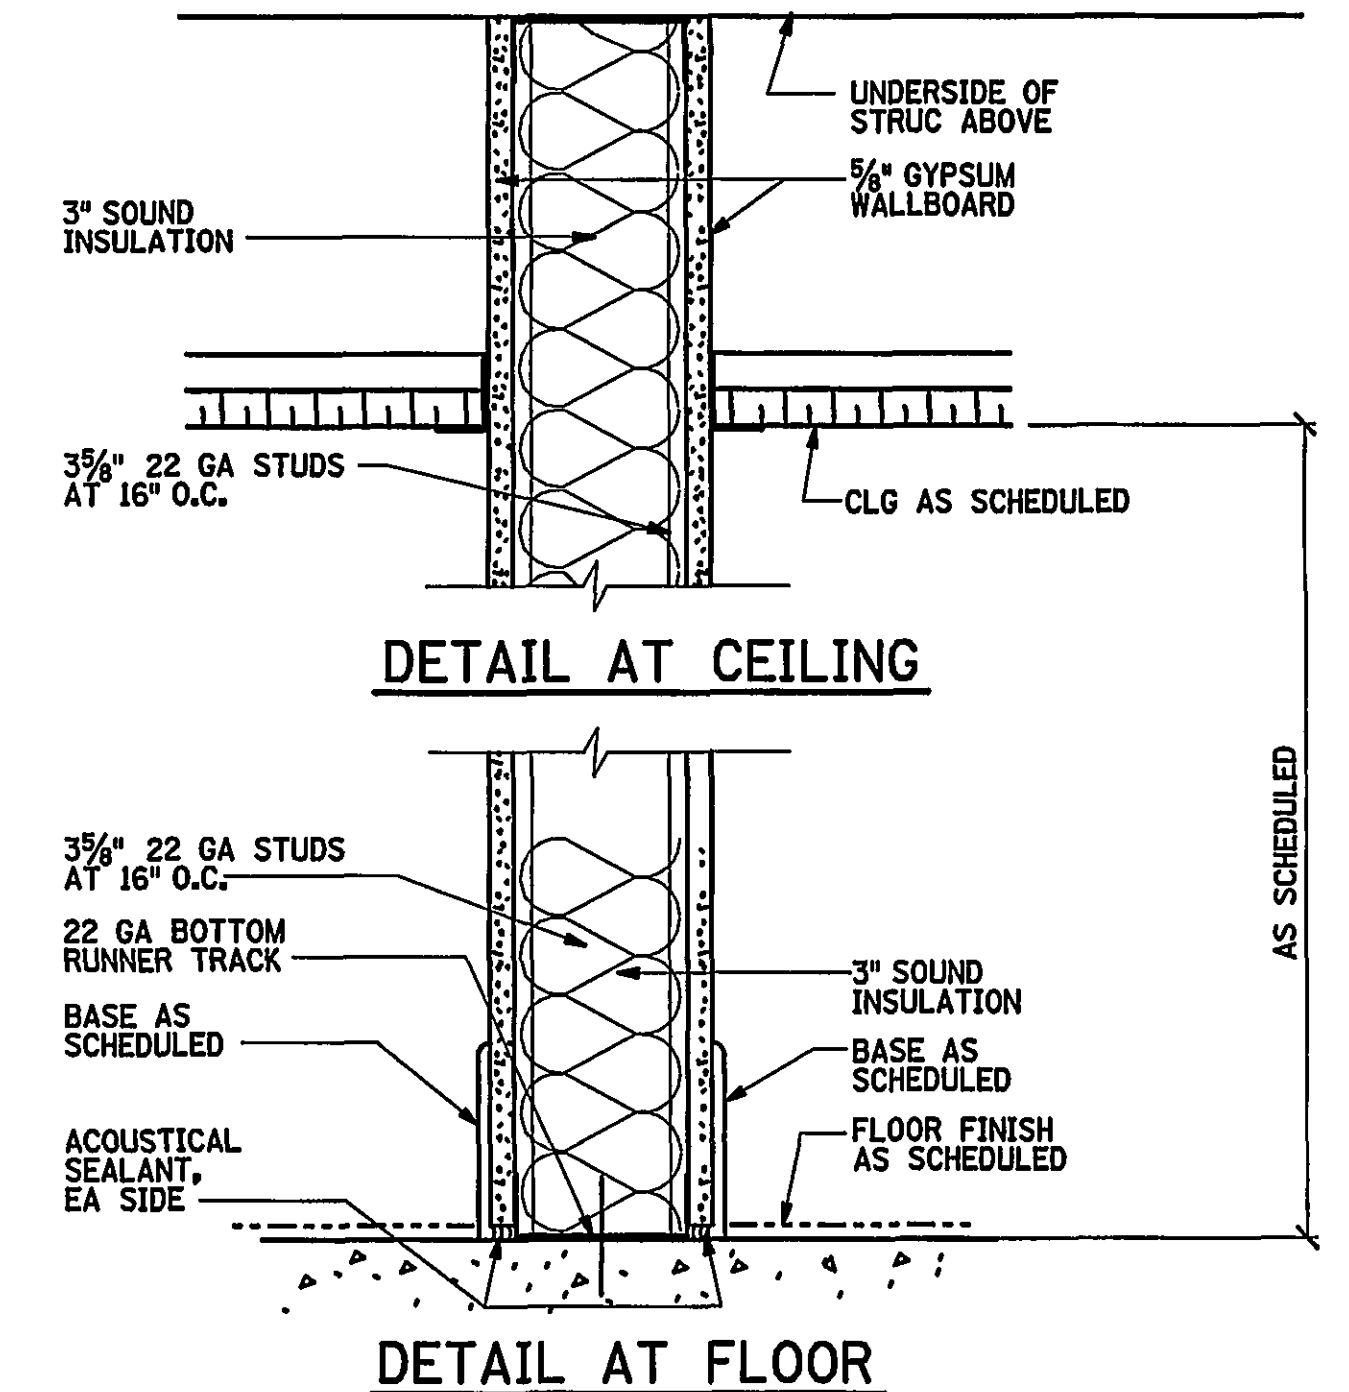
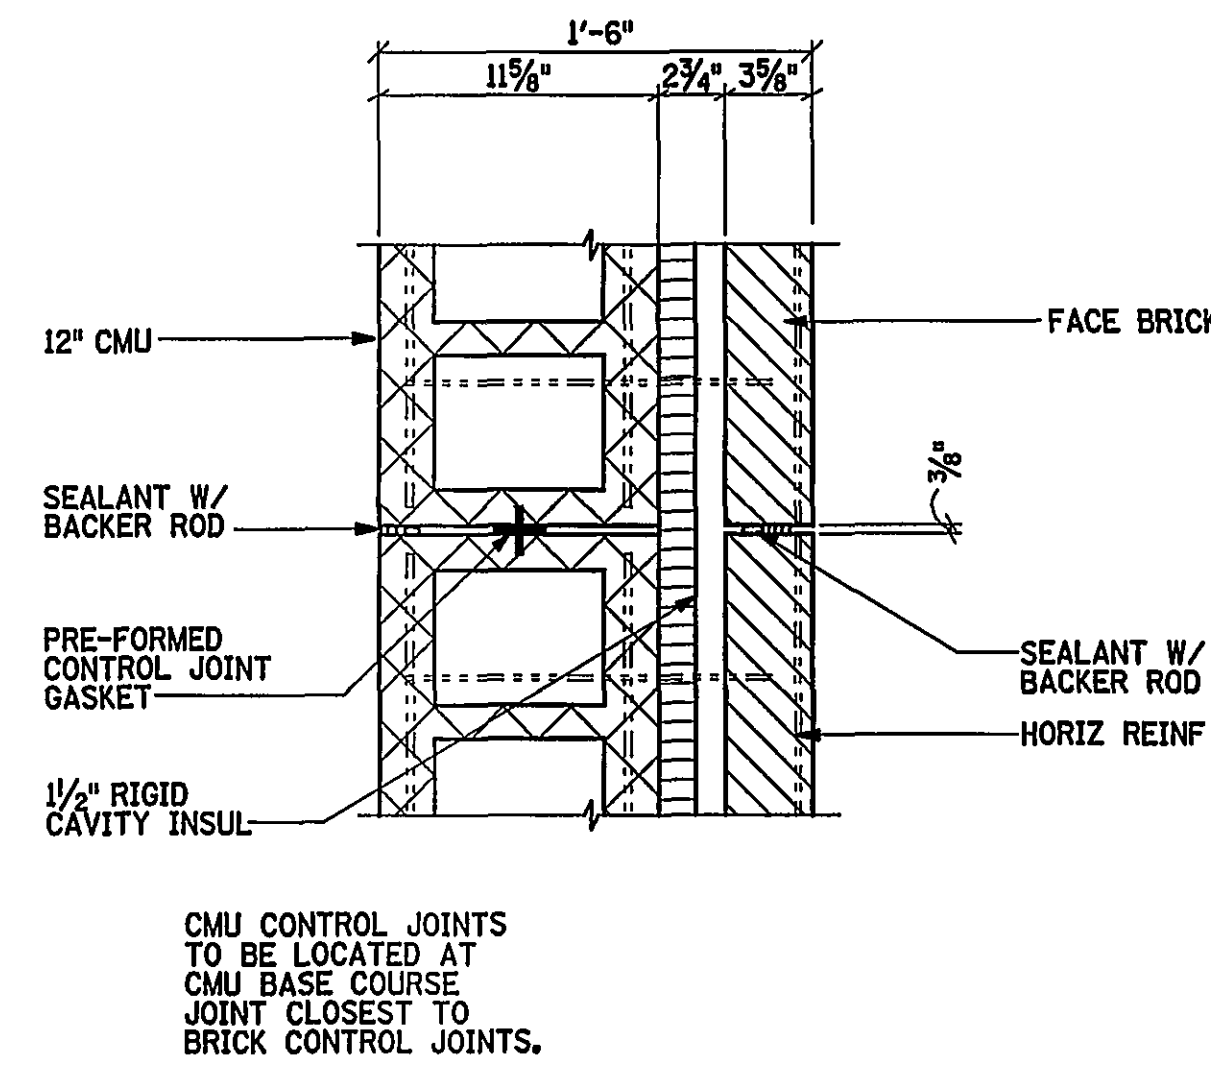
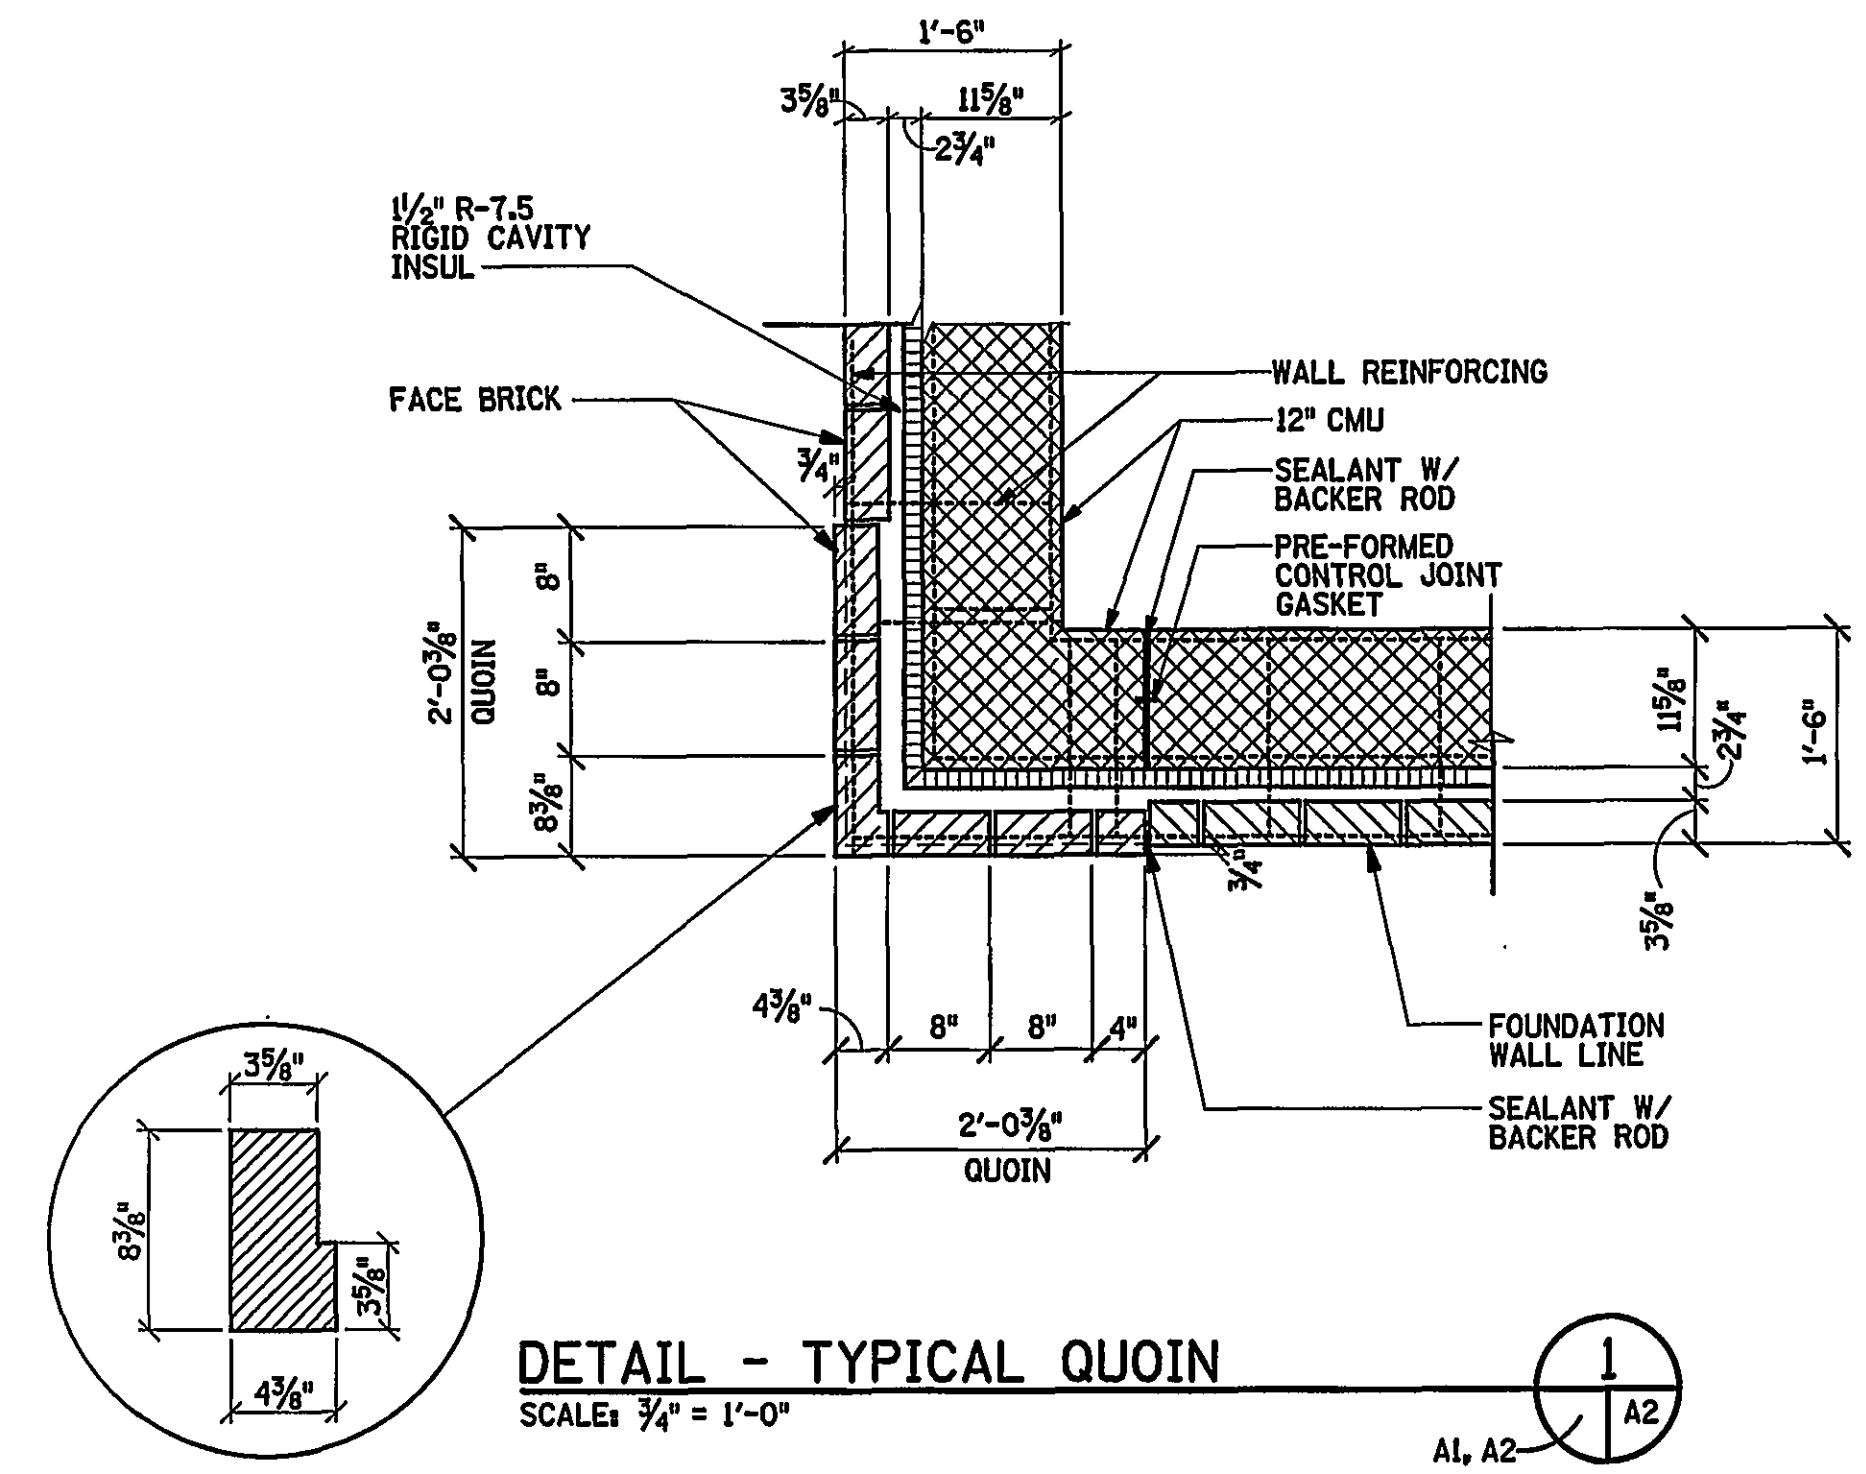


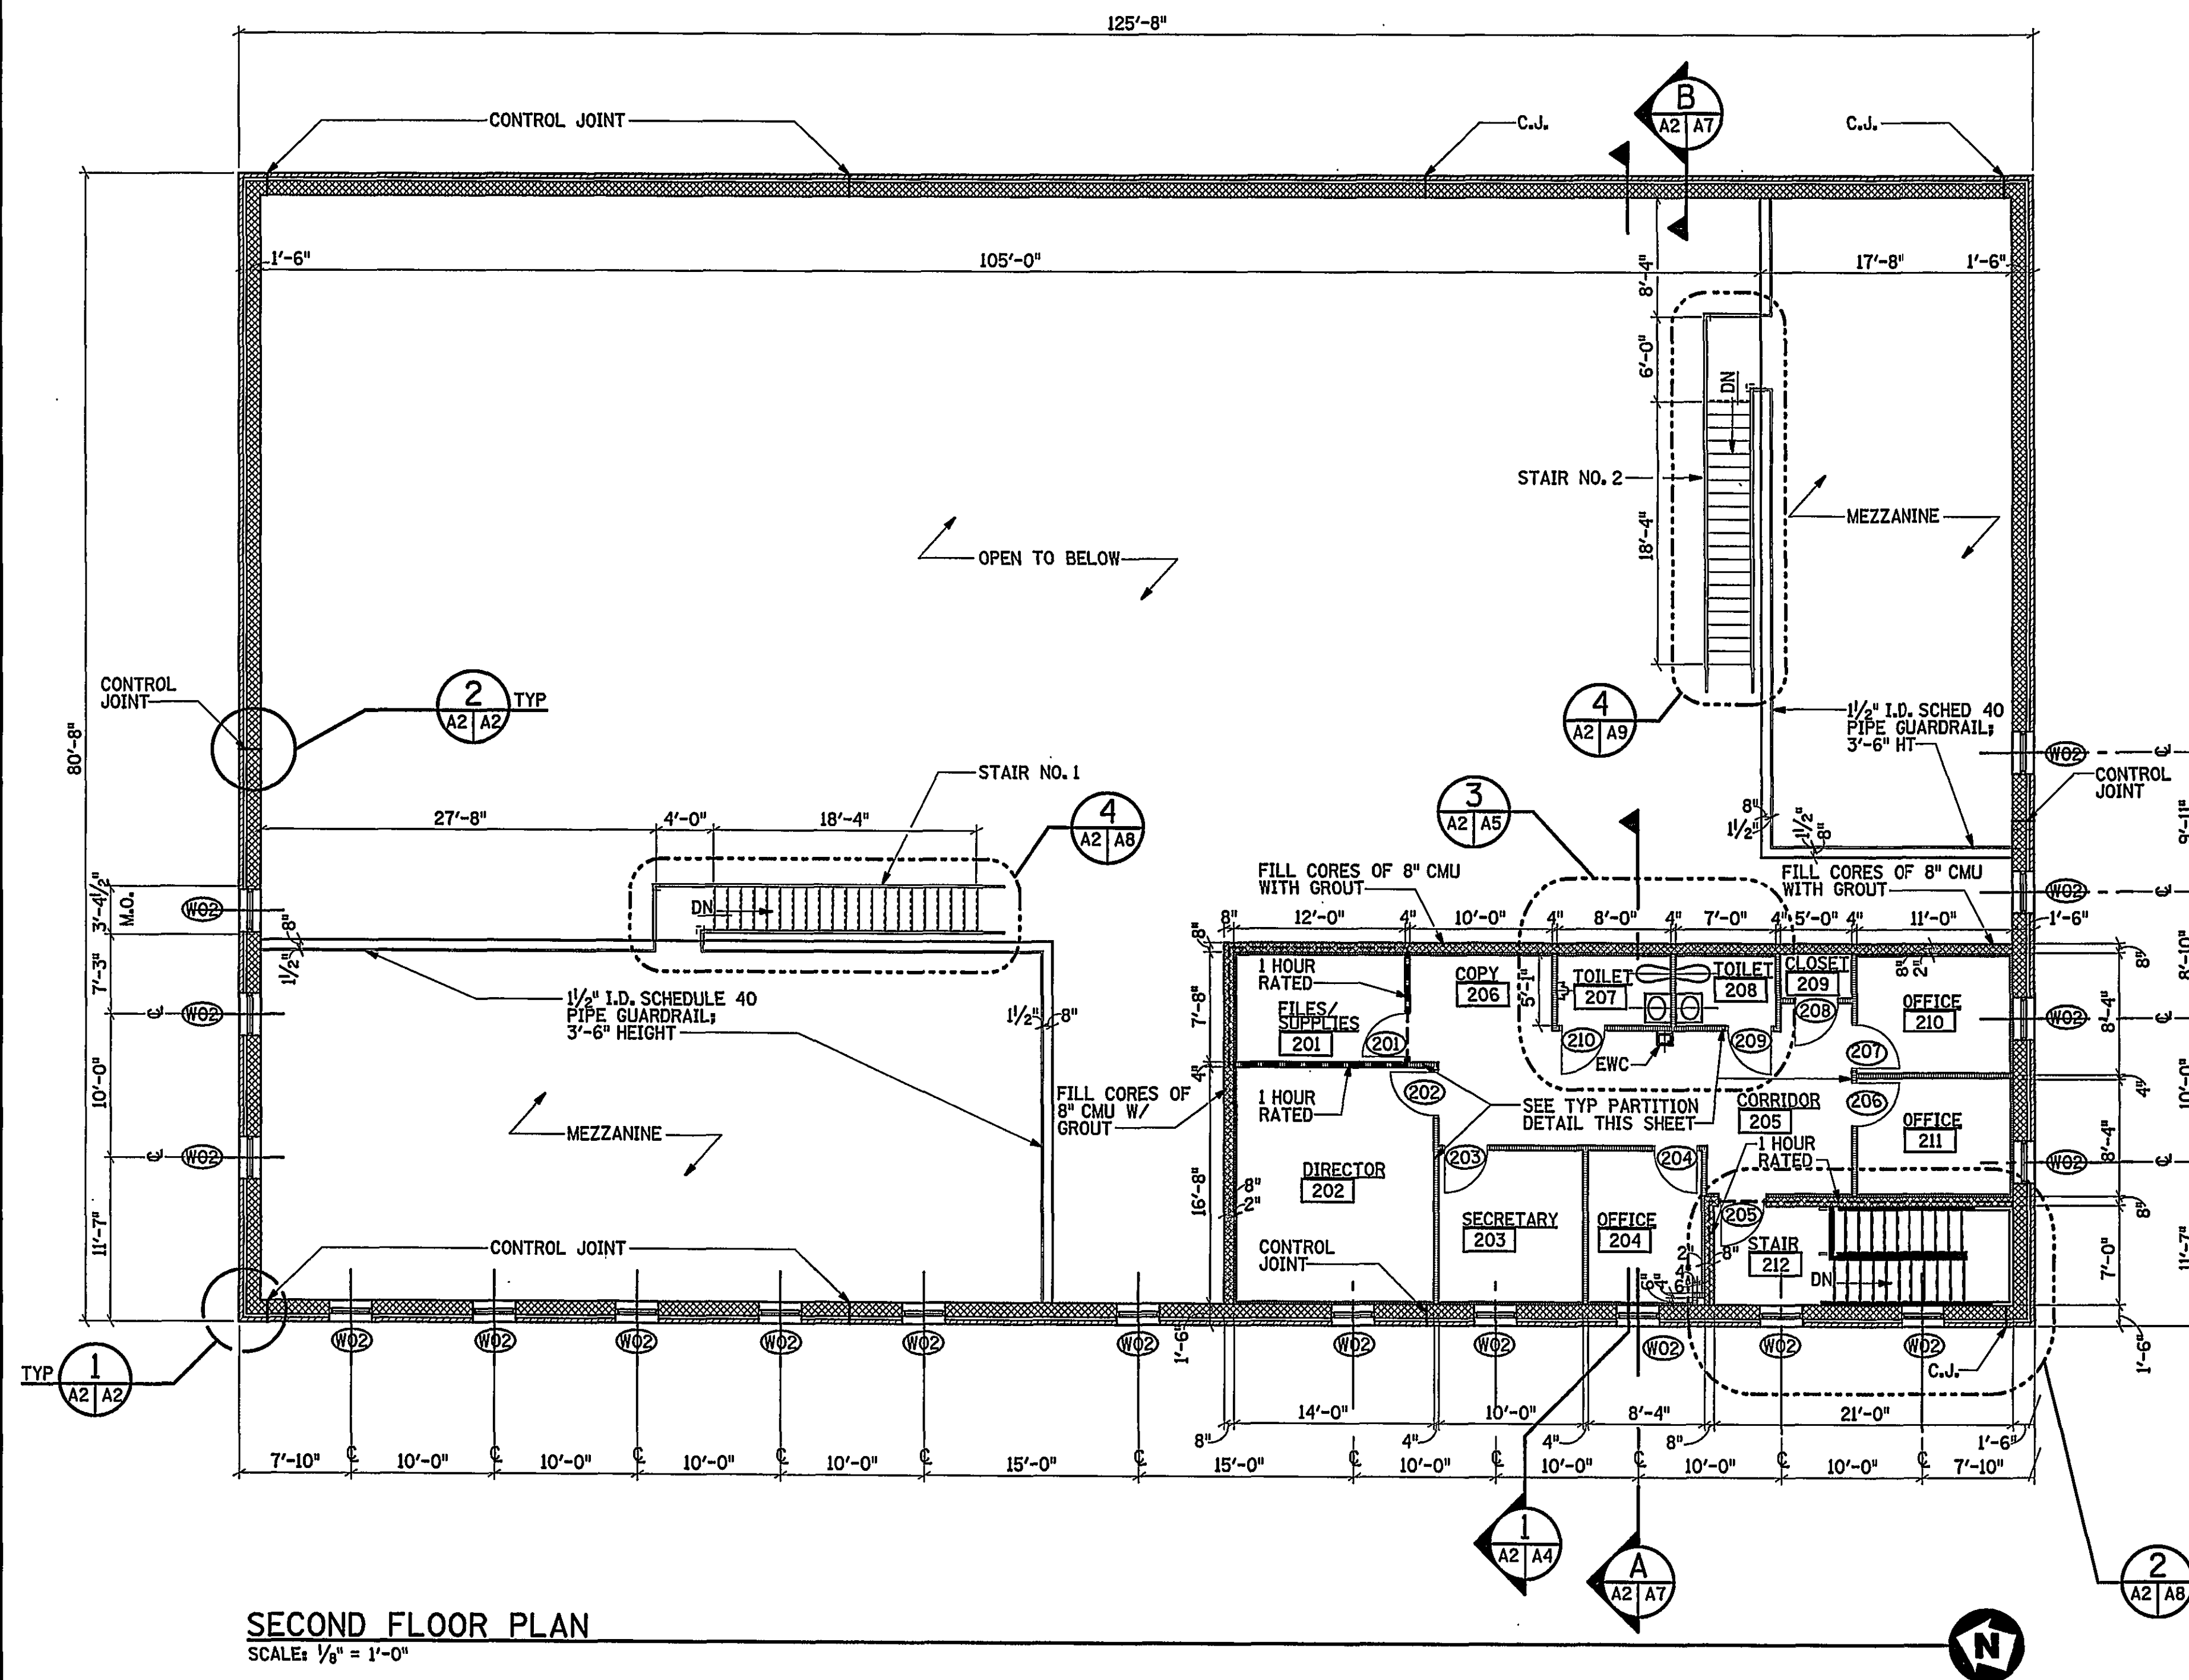

REV.	DATE	BY	APP.	DESCRIPTION
5-01-03	JLW	MKJ		RECORD DRAWING

RECORD DRAWING
DATE: MAY 1, 2003

Wiley & Wilson
ARCHITECTS ENGINEERS PLANNERS
An Employee-Owned Company
2310 LANGHORNE ROAD
LYNCHBURG, VIRGINIA 24501
(804) 947-1901

IN ASSOCIATION WITH
HDR
HDR Engineering, Inc.
5700 LAKE WRIGHT DRIVE
NORFOLK, VIRGINIA 23502
757-222-1500

DESIGNED JRM	DRAWN EJLB	PROJECT CRYSTAL SPRING WATER TREATMENT PLANT FOR THE CITY OF ROANOKE, VIRGINIA
CHECKED MKJ	REVIEWED	REFERENCE ARCHITECTURAL
COMM. NO. 200171.01		TITLE SECOND FLOOR PLAN
CADD NO. 200171A2.DGN		
DATE AUG 26, 2001	DWG. NO. A-2	SHEET NO. 13 OF 72
		REV. 0

IF THIS DRAWING IS A REDUCTION,
GRAPHIC SCALE MUST BE USED.