




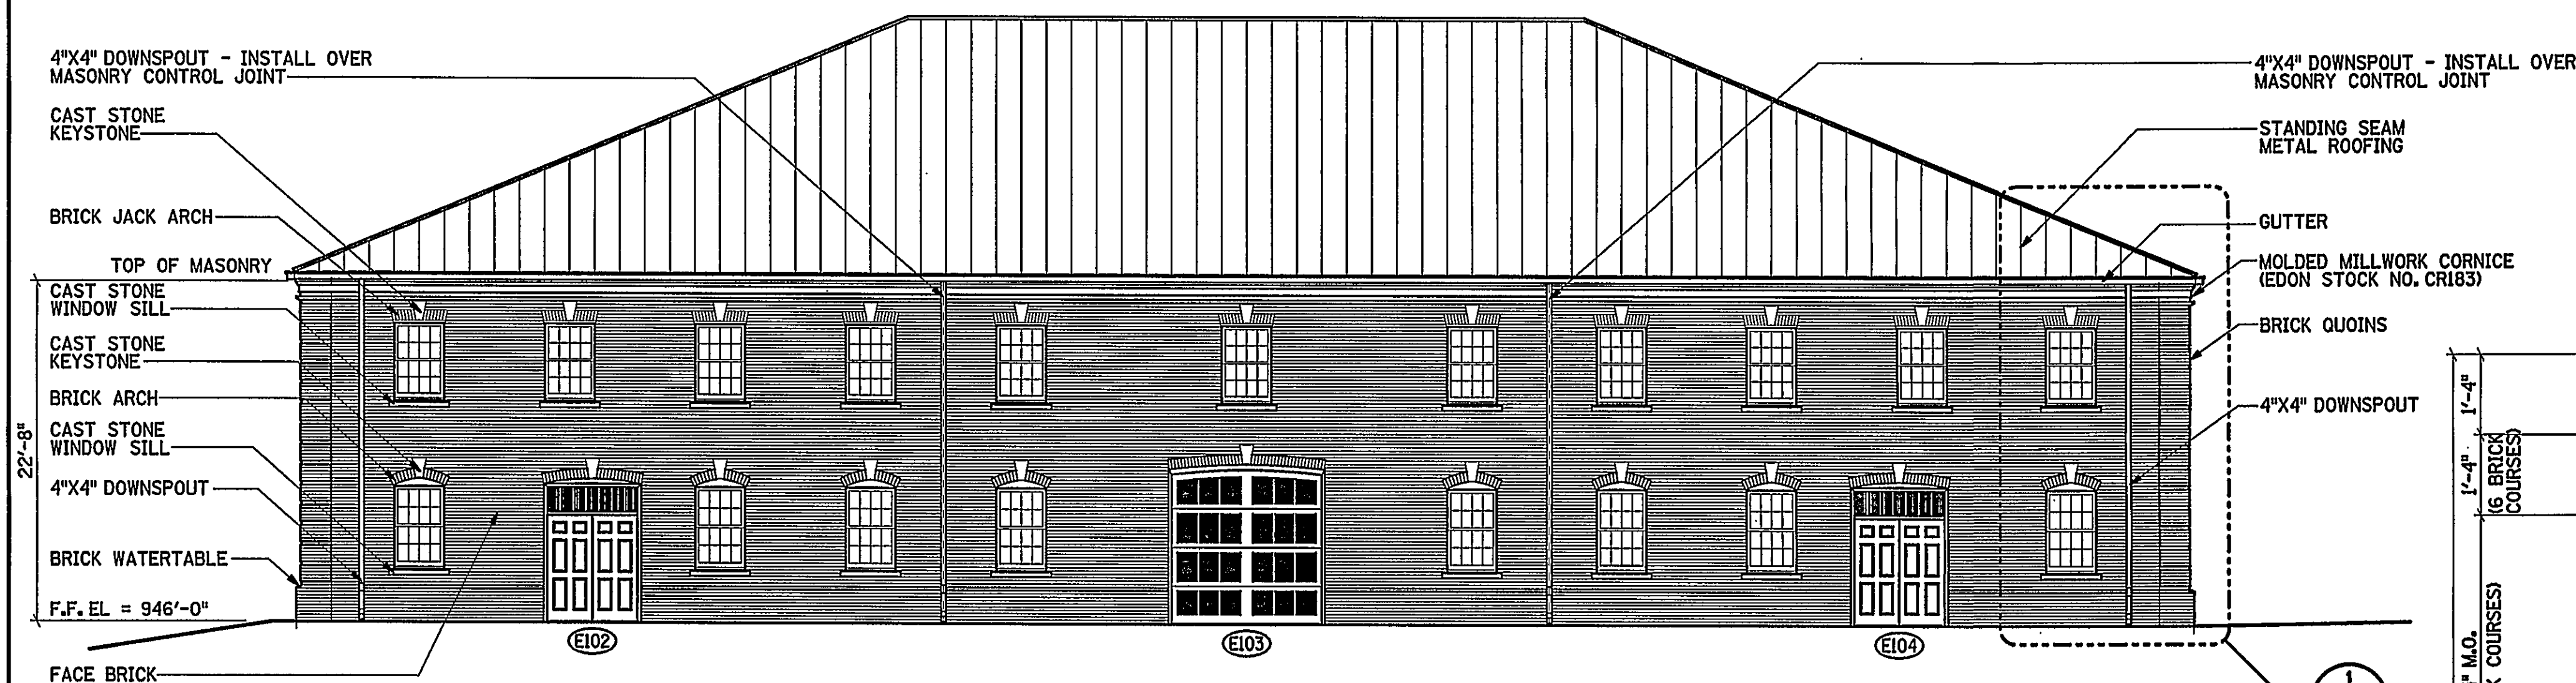


WEST ELEVATION
SCALE: 1/8" = 1'-0"

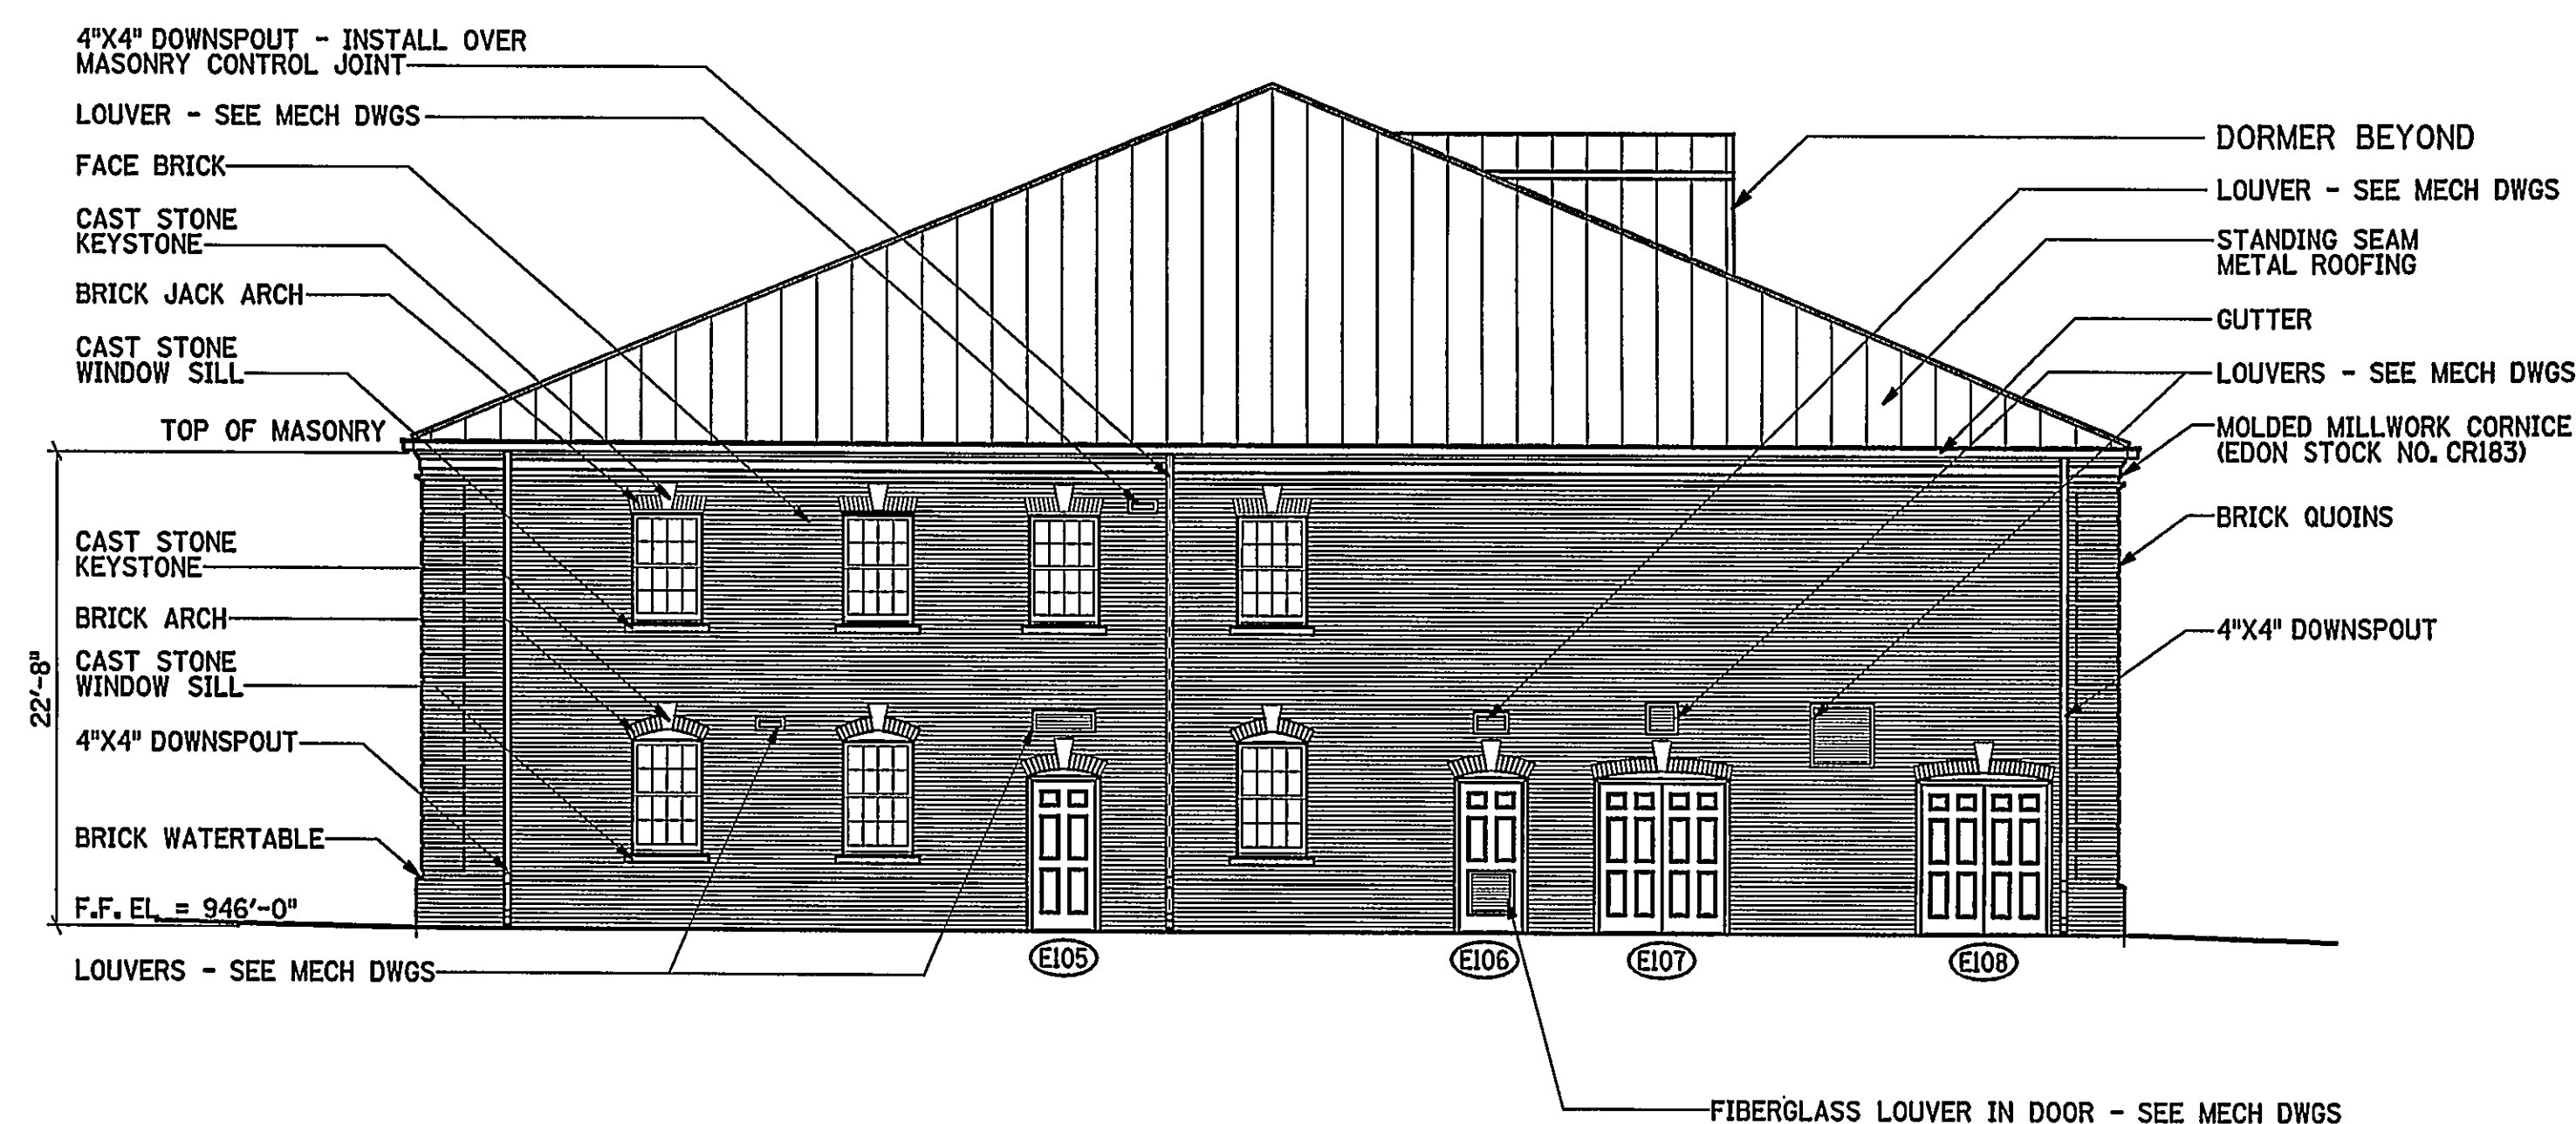

SOUTH ELEVATION
SCALE: 1/8" = 1'-0"

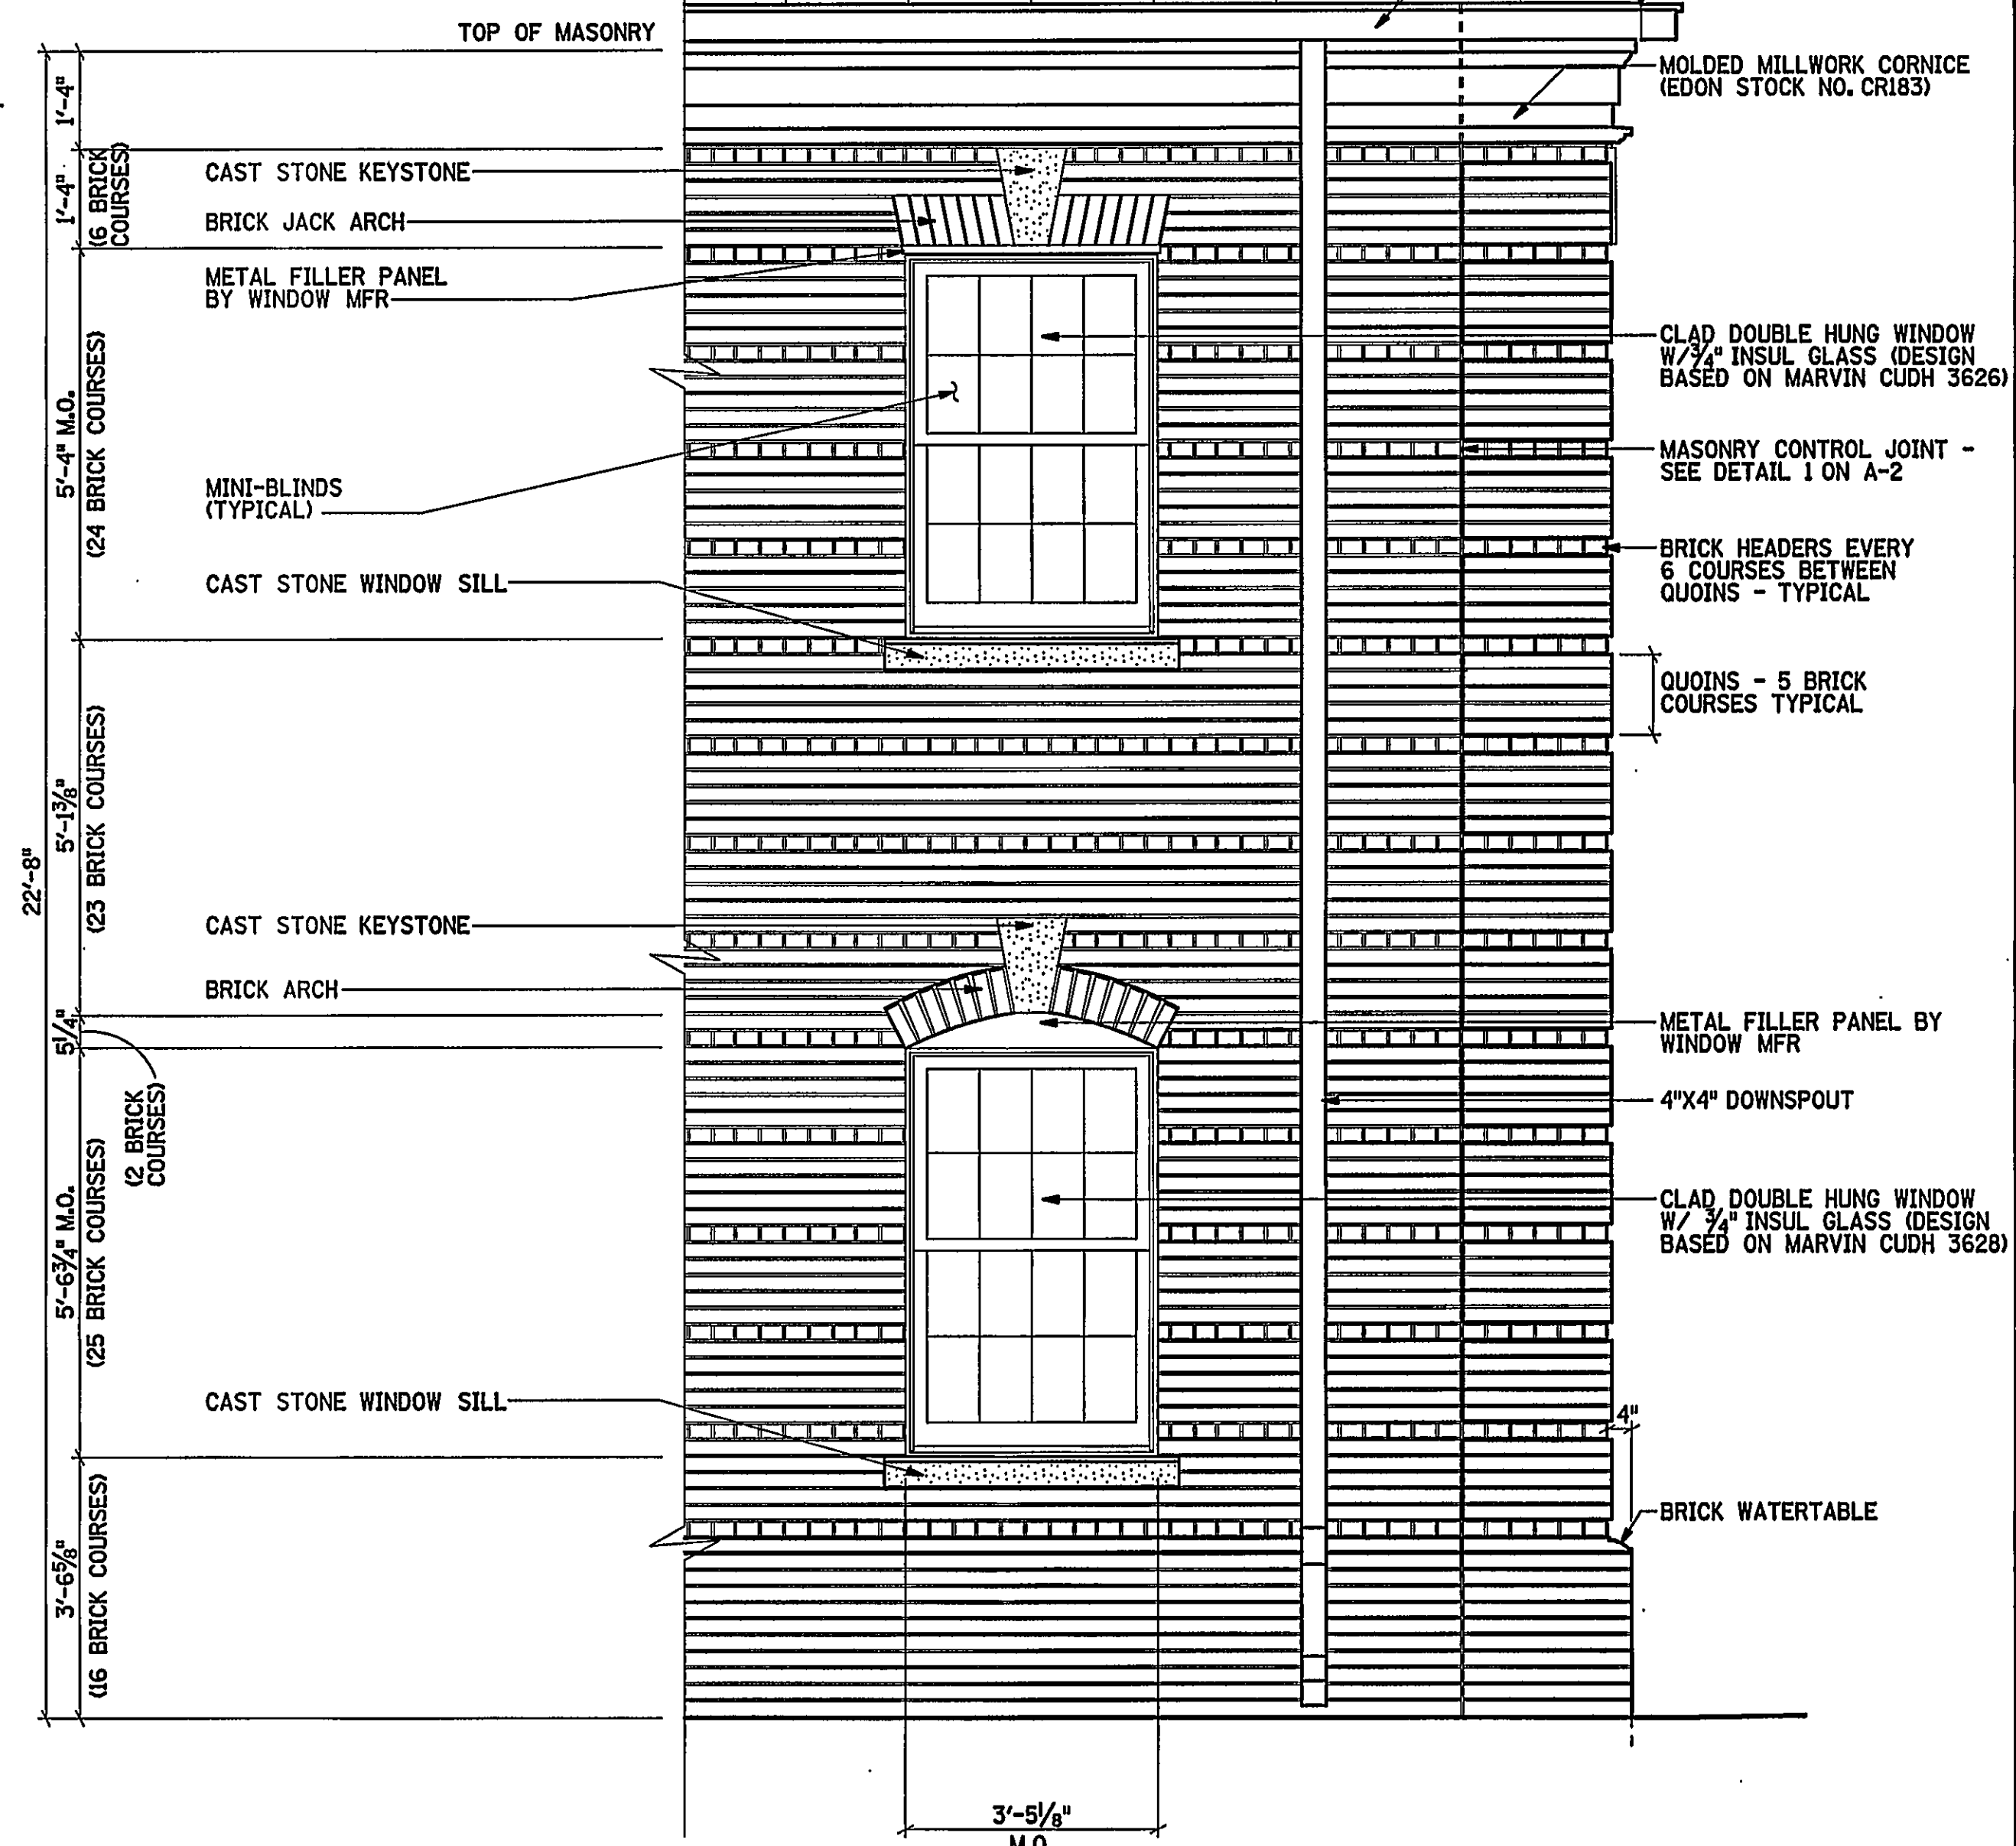

ENLARGED ELEVATION
SCALE: 1/2" = 1'-0"

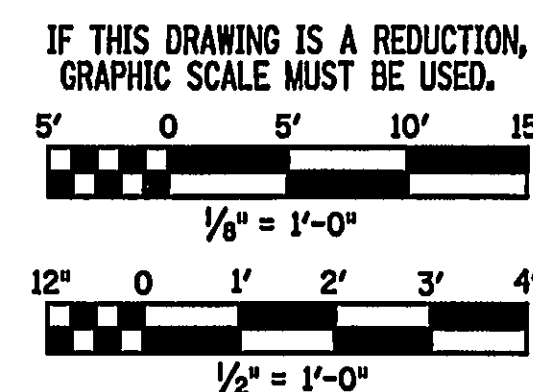

1	9/14/01	EJLB	MKJ	SOUTH ELEVATION ROOM 102 LOUVER SIZE HAS BEEN INCREASED
	5-01-03	JLW	MKJ	RECORD DRAWING
REV.	DATE	BY	APP.	DESCRIPTION

RECORD DRAWING

DATE: MAY 1, 2003

Wiley & Wilson
ARCHITECTS ENGINEERS PLANNERS
An Employee-Owned Company

2310 LANGHORNE ROAD
LYNCHBURG, VIRGINIA 24501
(804) 947-1901

P.O. BOX 877
LYNCHBURG, VIRGINIA 24505-0877

HDR

HDR Engineering, Inc.
5700 LAKE WRIGHT DRIVE
NORFOLK, VIRGINIA 23502
757-222-1500

DESIGNED JRM	DRAWN EJLB	PROJECT CRYSTAL SPRING WATER TREATMENT PLANT FOR THE CITY OF ROANOKE, VIRGINIA
CHECKED MKJ	REVIEWED	REFERENCE ARCHITECTURAL
COMM. NO. 200171.01		TITLE WEST AND SOUTH ELEVATIONS
CADD NO. 200171A3.DGN		DWG. NO. A-3
DATE AUG 26, 2001		SHEET NO. 14 OF 72
		REV. 0