
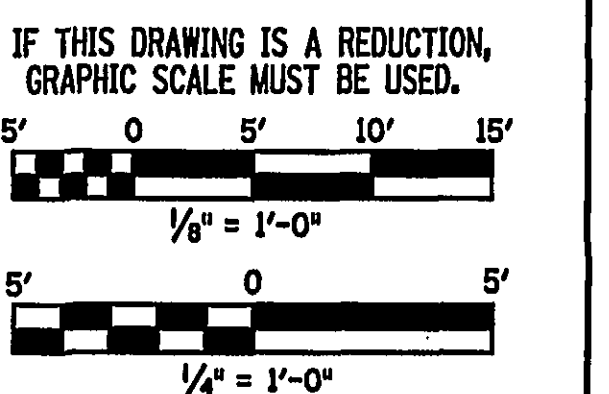
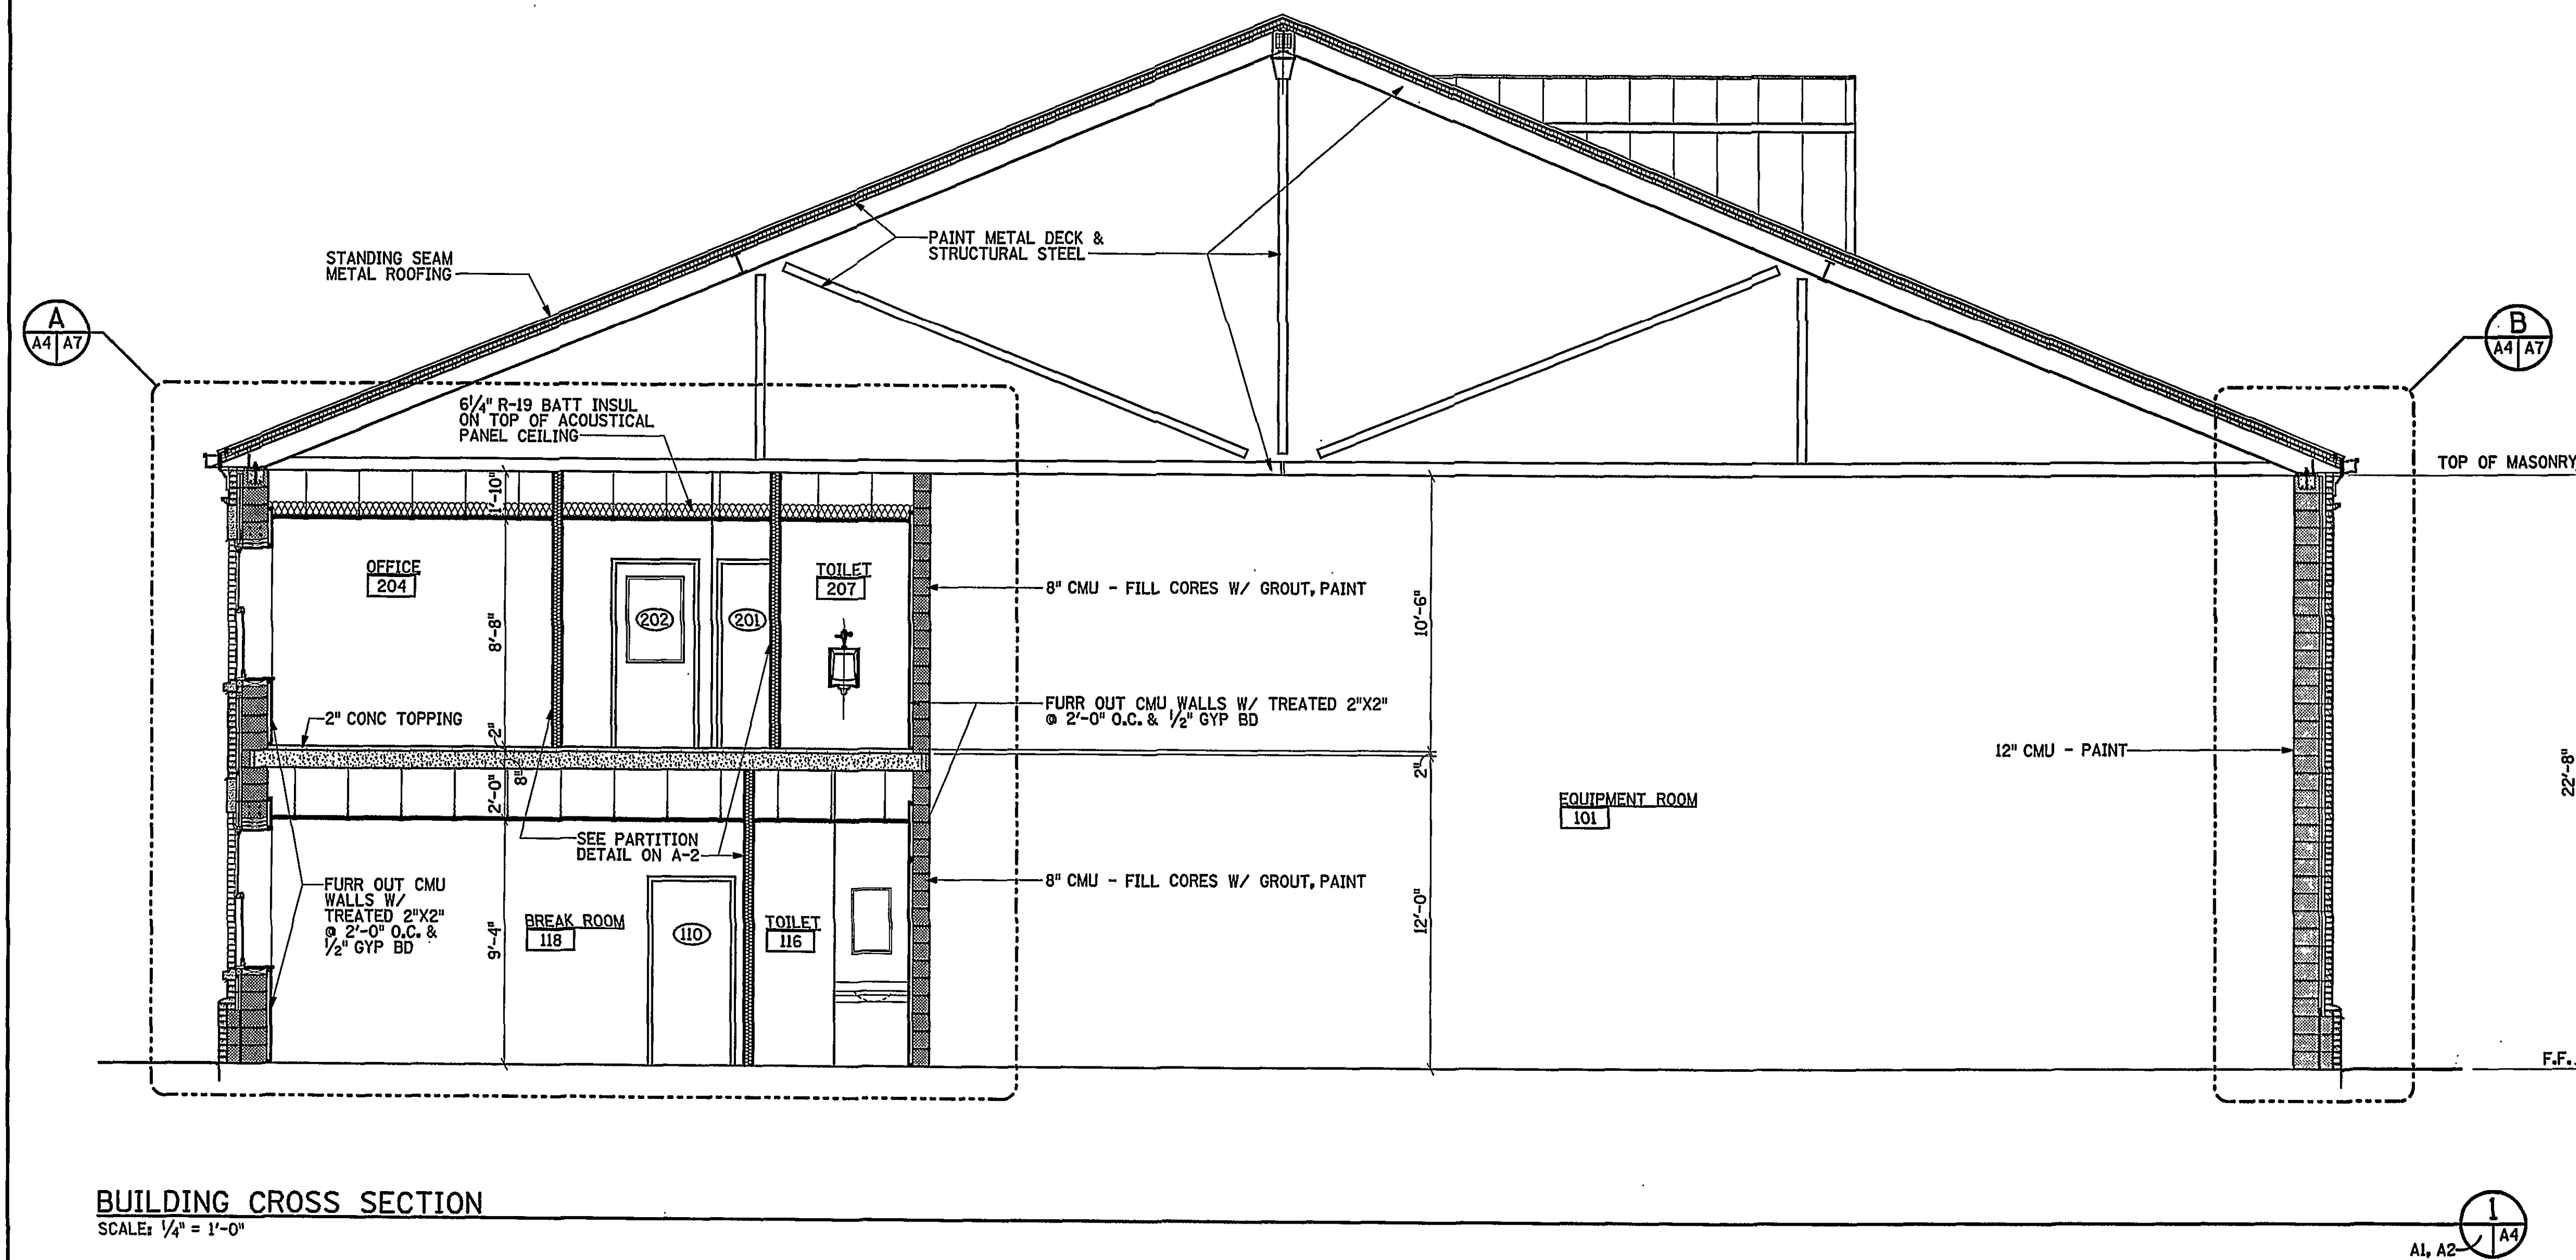


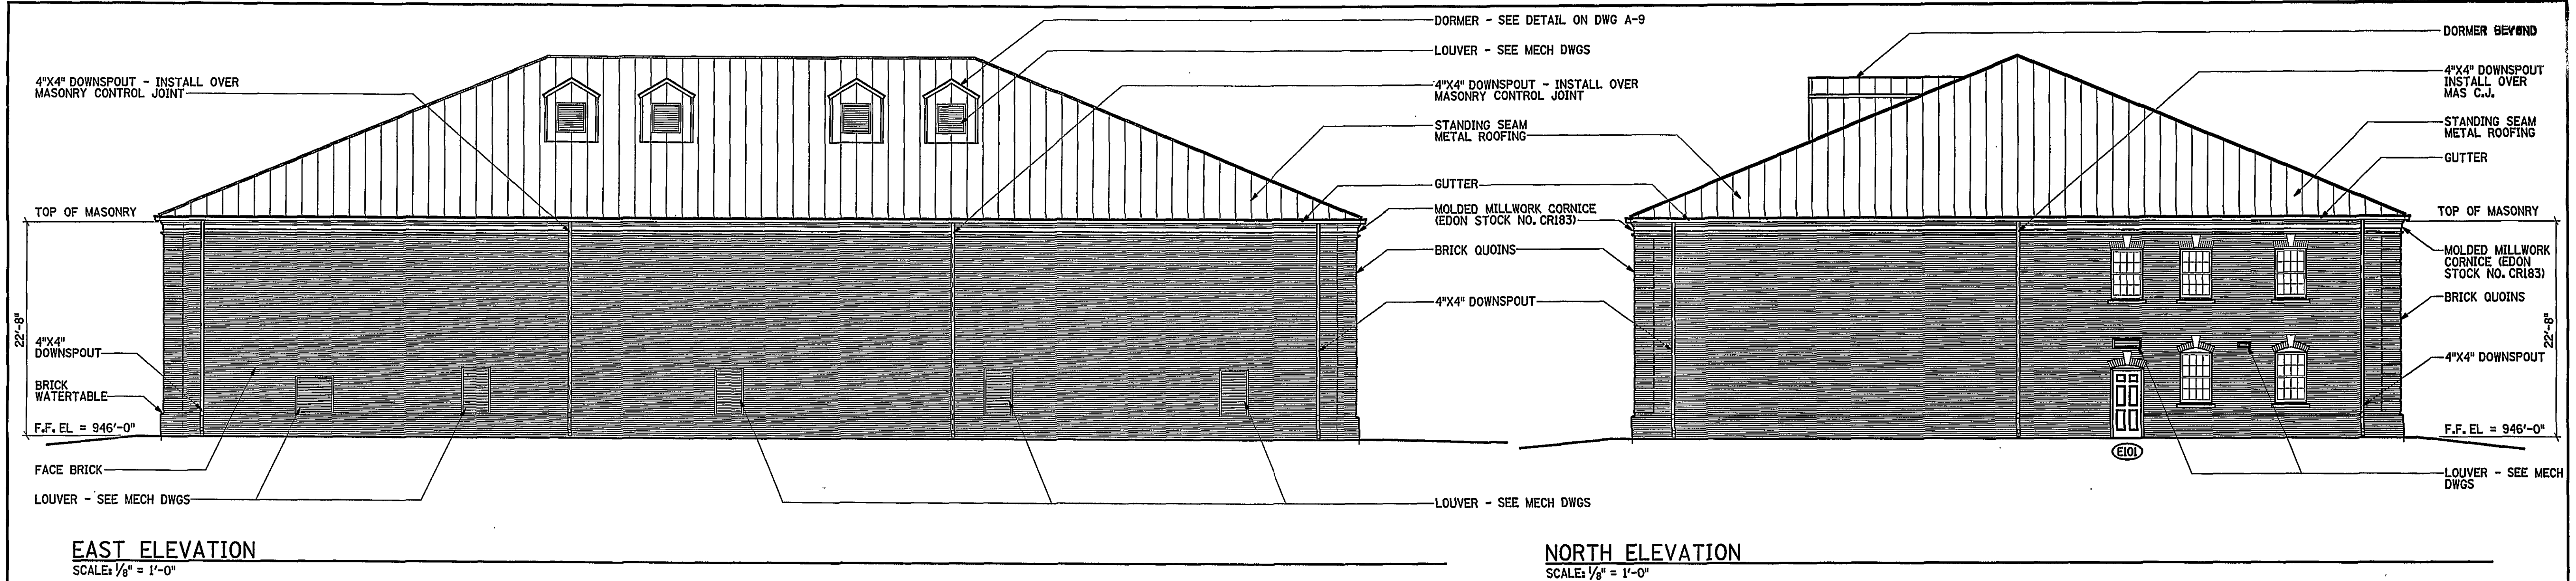

1	9/14/01	EJLB	MKJ	EAST ELEVATION ROOM 102 LOUVER HAS BEEN RELOCATED AND SIZE HAS BEEN INCREASED
	5-01-03	JLW	MKJ	RECORD DRAWING
REV.	DATE	BY	APP.	DESCRIPTION

RECORD DRAWING

DATE: MAY 1, 2003

Wiley & Wilson
ARCHITECTS ENGINEERS PLANNERS
An Employee-Owned Company

2310 LANGHORNE ROAD
LYNCHBURG, VIRGINIA
24501
(804) 947-1901

P.O. BOX 877
LYNCHBURG, VIRGINIA
24505-0877

IN ASSOCIATION WITH

HDR
HDR Engineering, Inc.
5700 LAKE WRIGHT DRIVE
NORFOLK, VIRGINIA 23502
757-222-1500

DESIGNED JRM	DRAWN EJLB	PROJECT CRYSTAL SPRING WATER TREATMENT PLANT FOR THE CITY OF ROANOKE, VIRGINIA
CHECKED MKJ	REVIEWED	ARCHITECTURAL
COMPL. NO. 200171.01	REFERENCE	
CADD NO. 200171A4.DGN	TITLE EAST AND NORTH ELEVATIONS	
DATE AUG 26, 2001	DWG. NO. A-4	SHEET NO. 15 OF 72
		REV. 0