



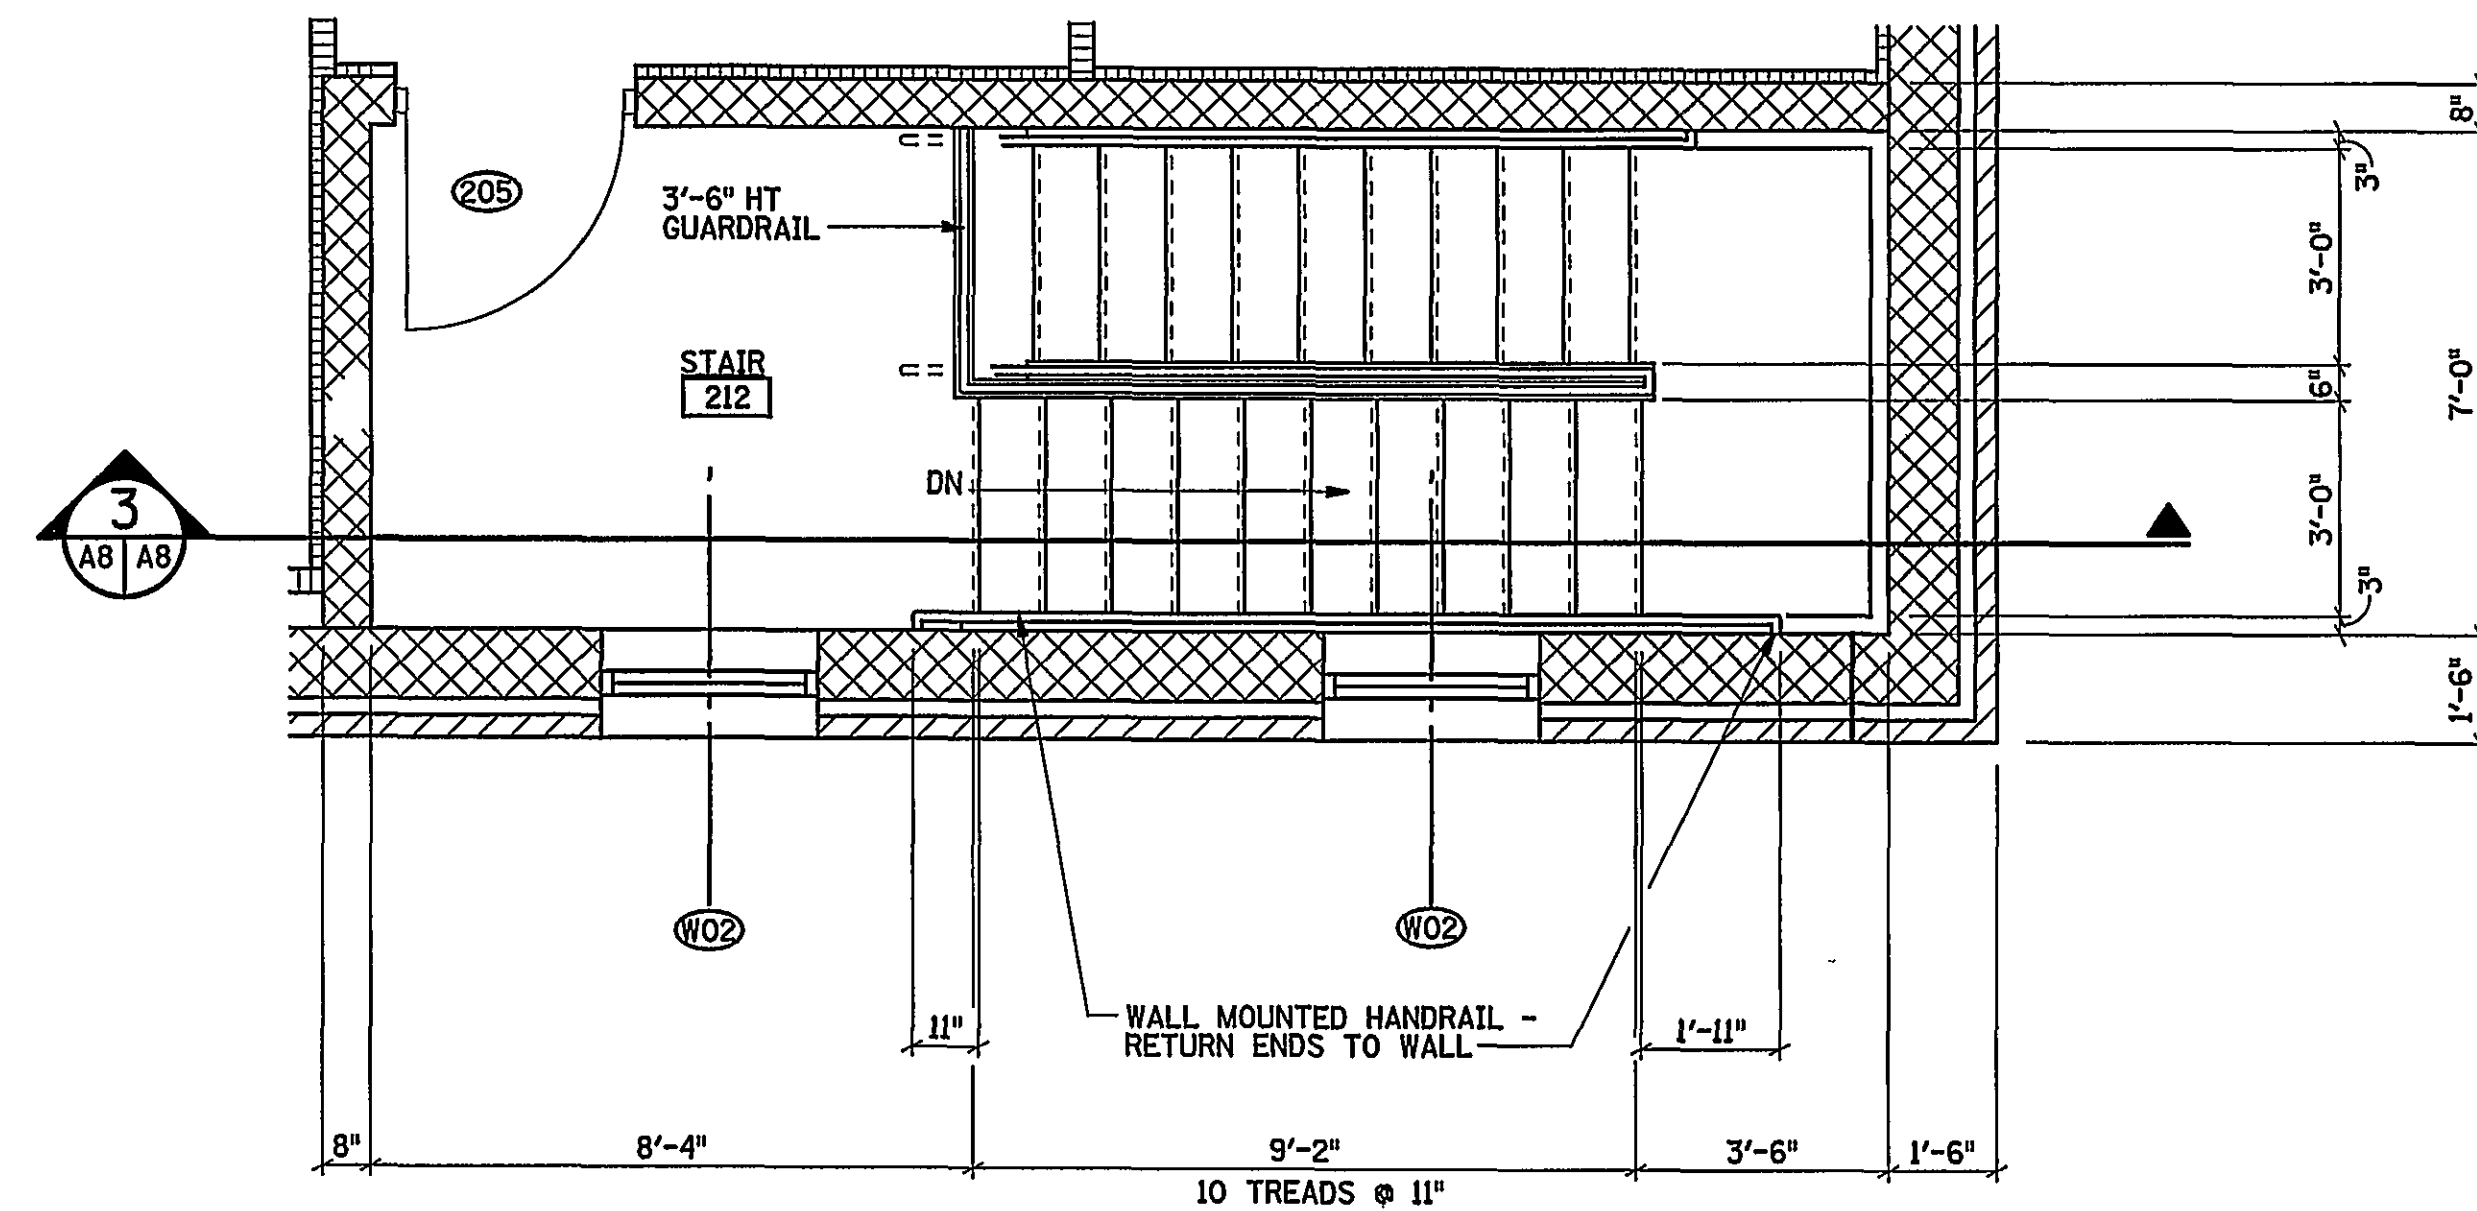

ENLARGED STAIR 212 - SECOND FLOOR PLAN

SCALE: 3/8" = 1'-0"


2
A2 AB

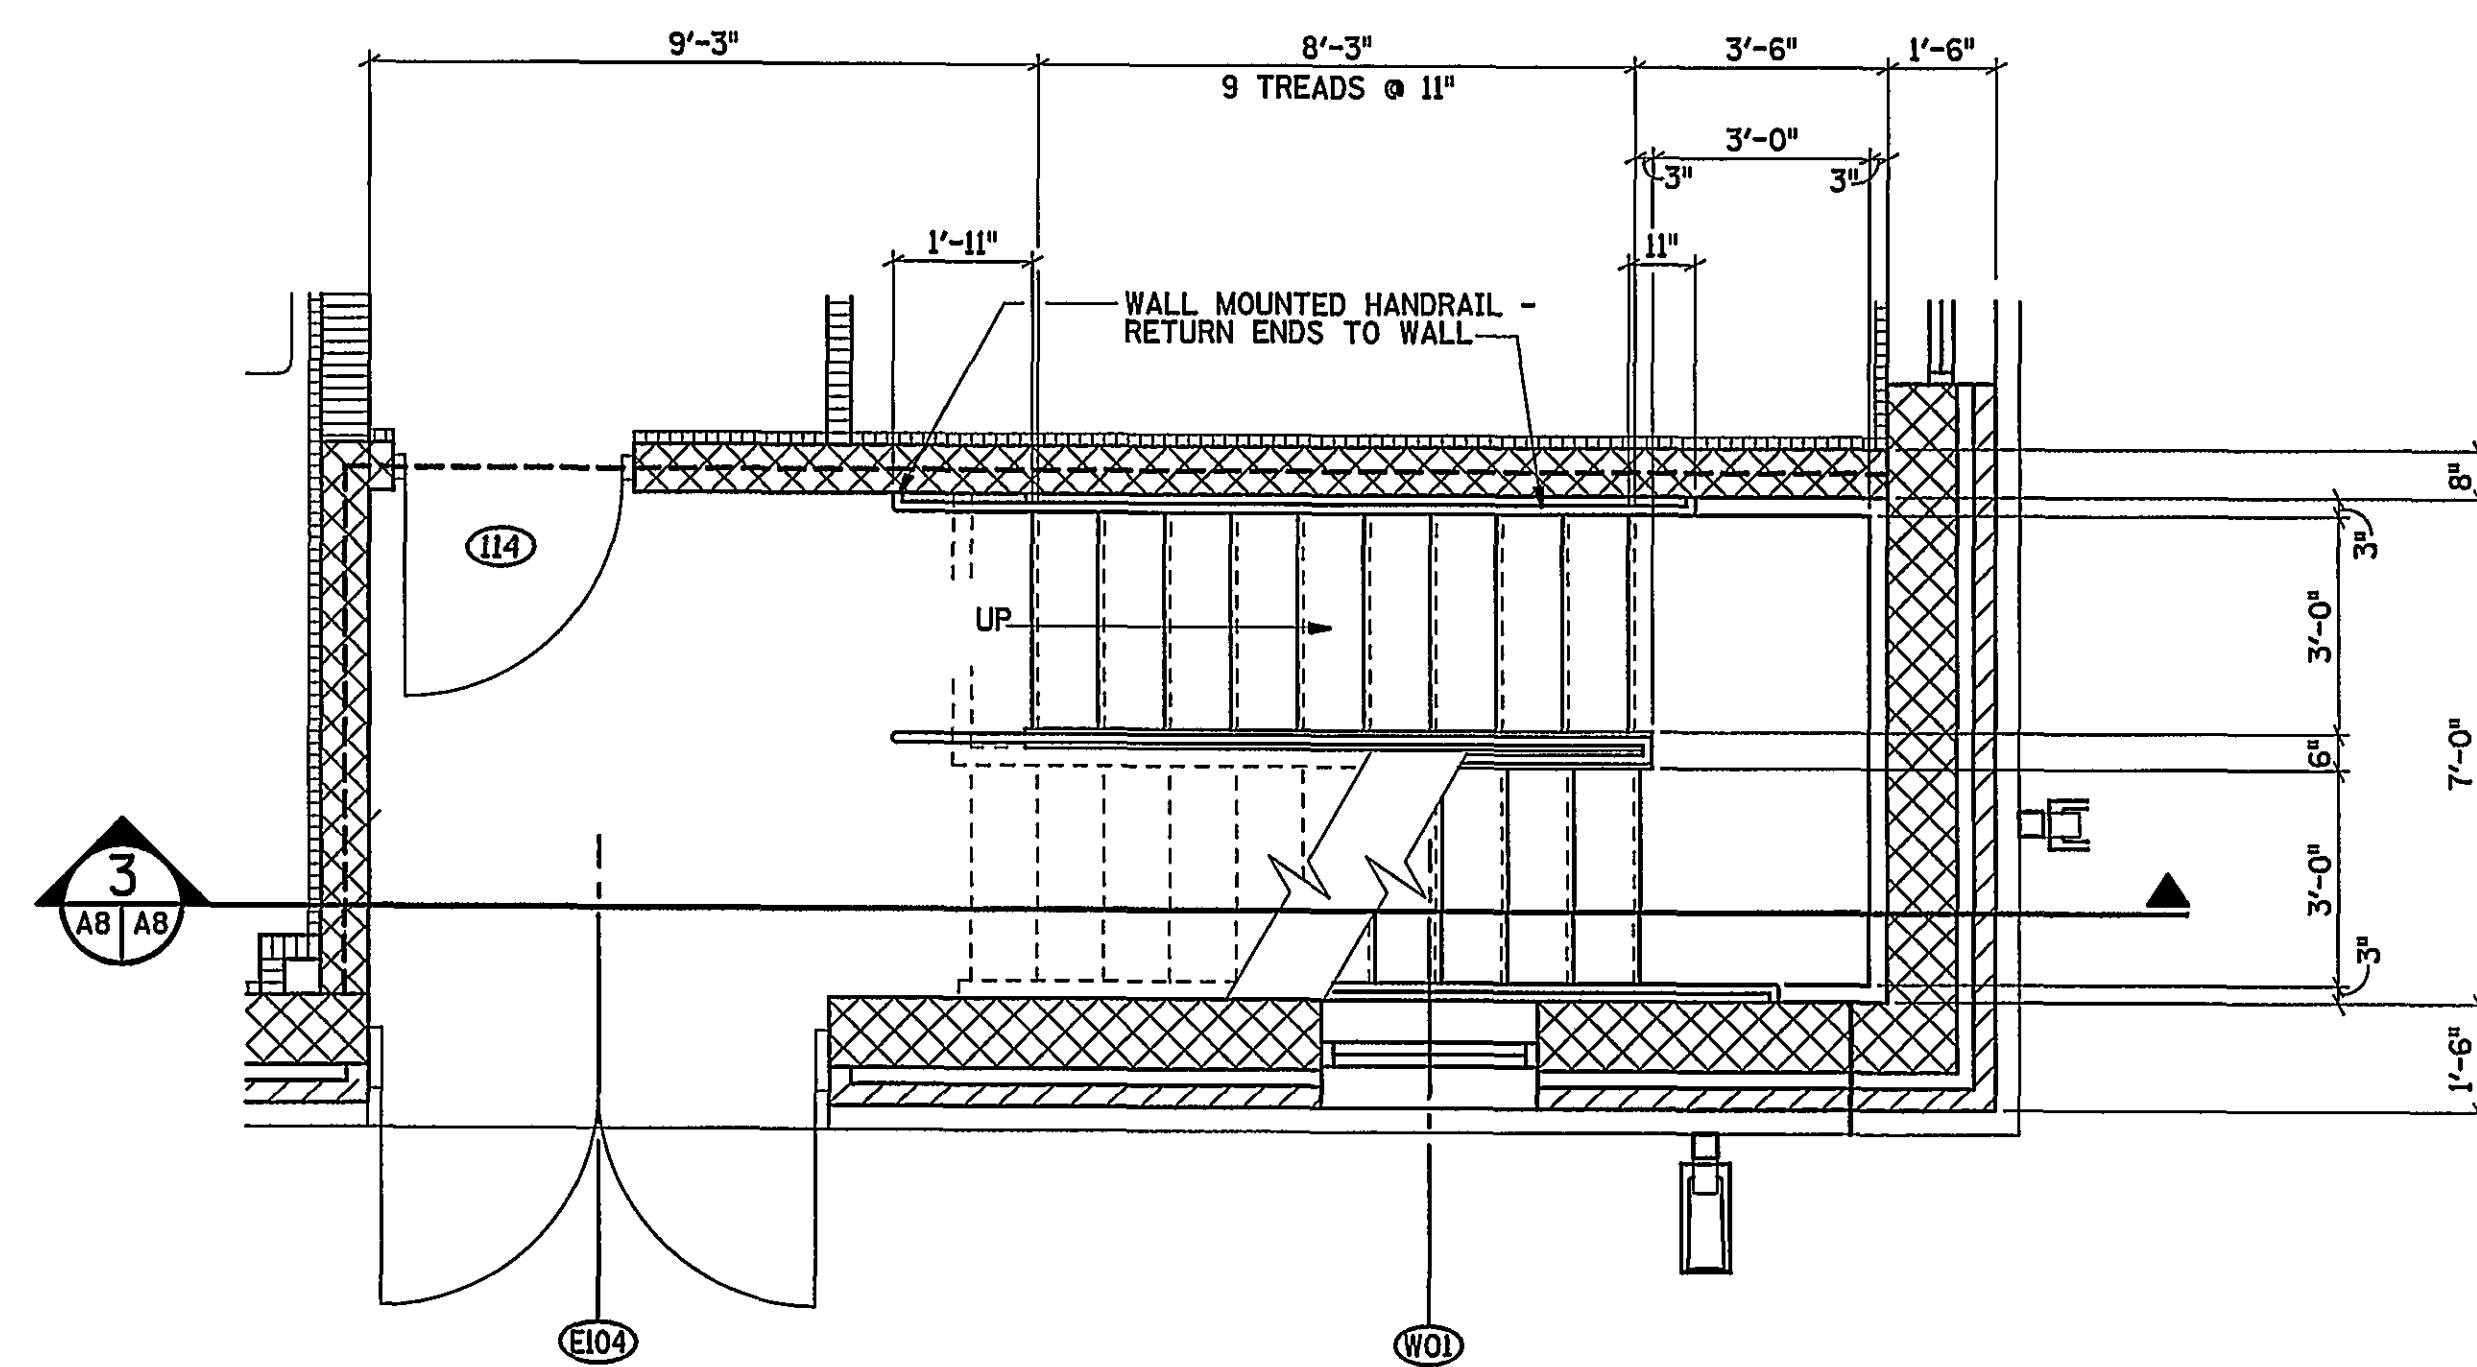

ENLARGED STAIR 119 - FIRST FLOOR PLAN

SCALE: 3/8" = 1'-0"


1
A1 AB

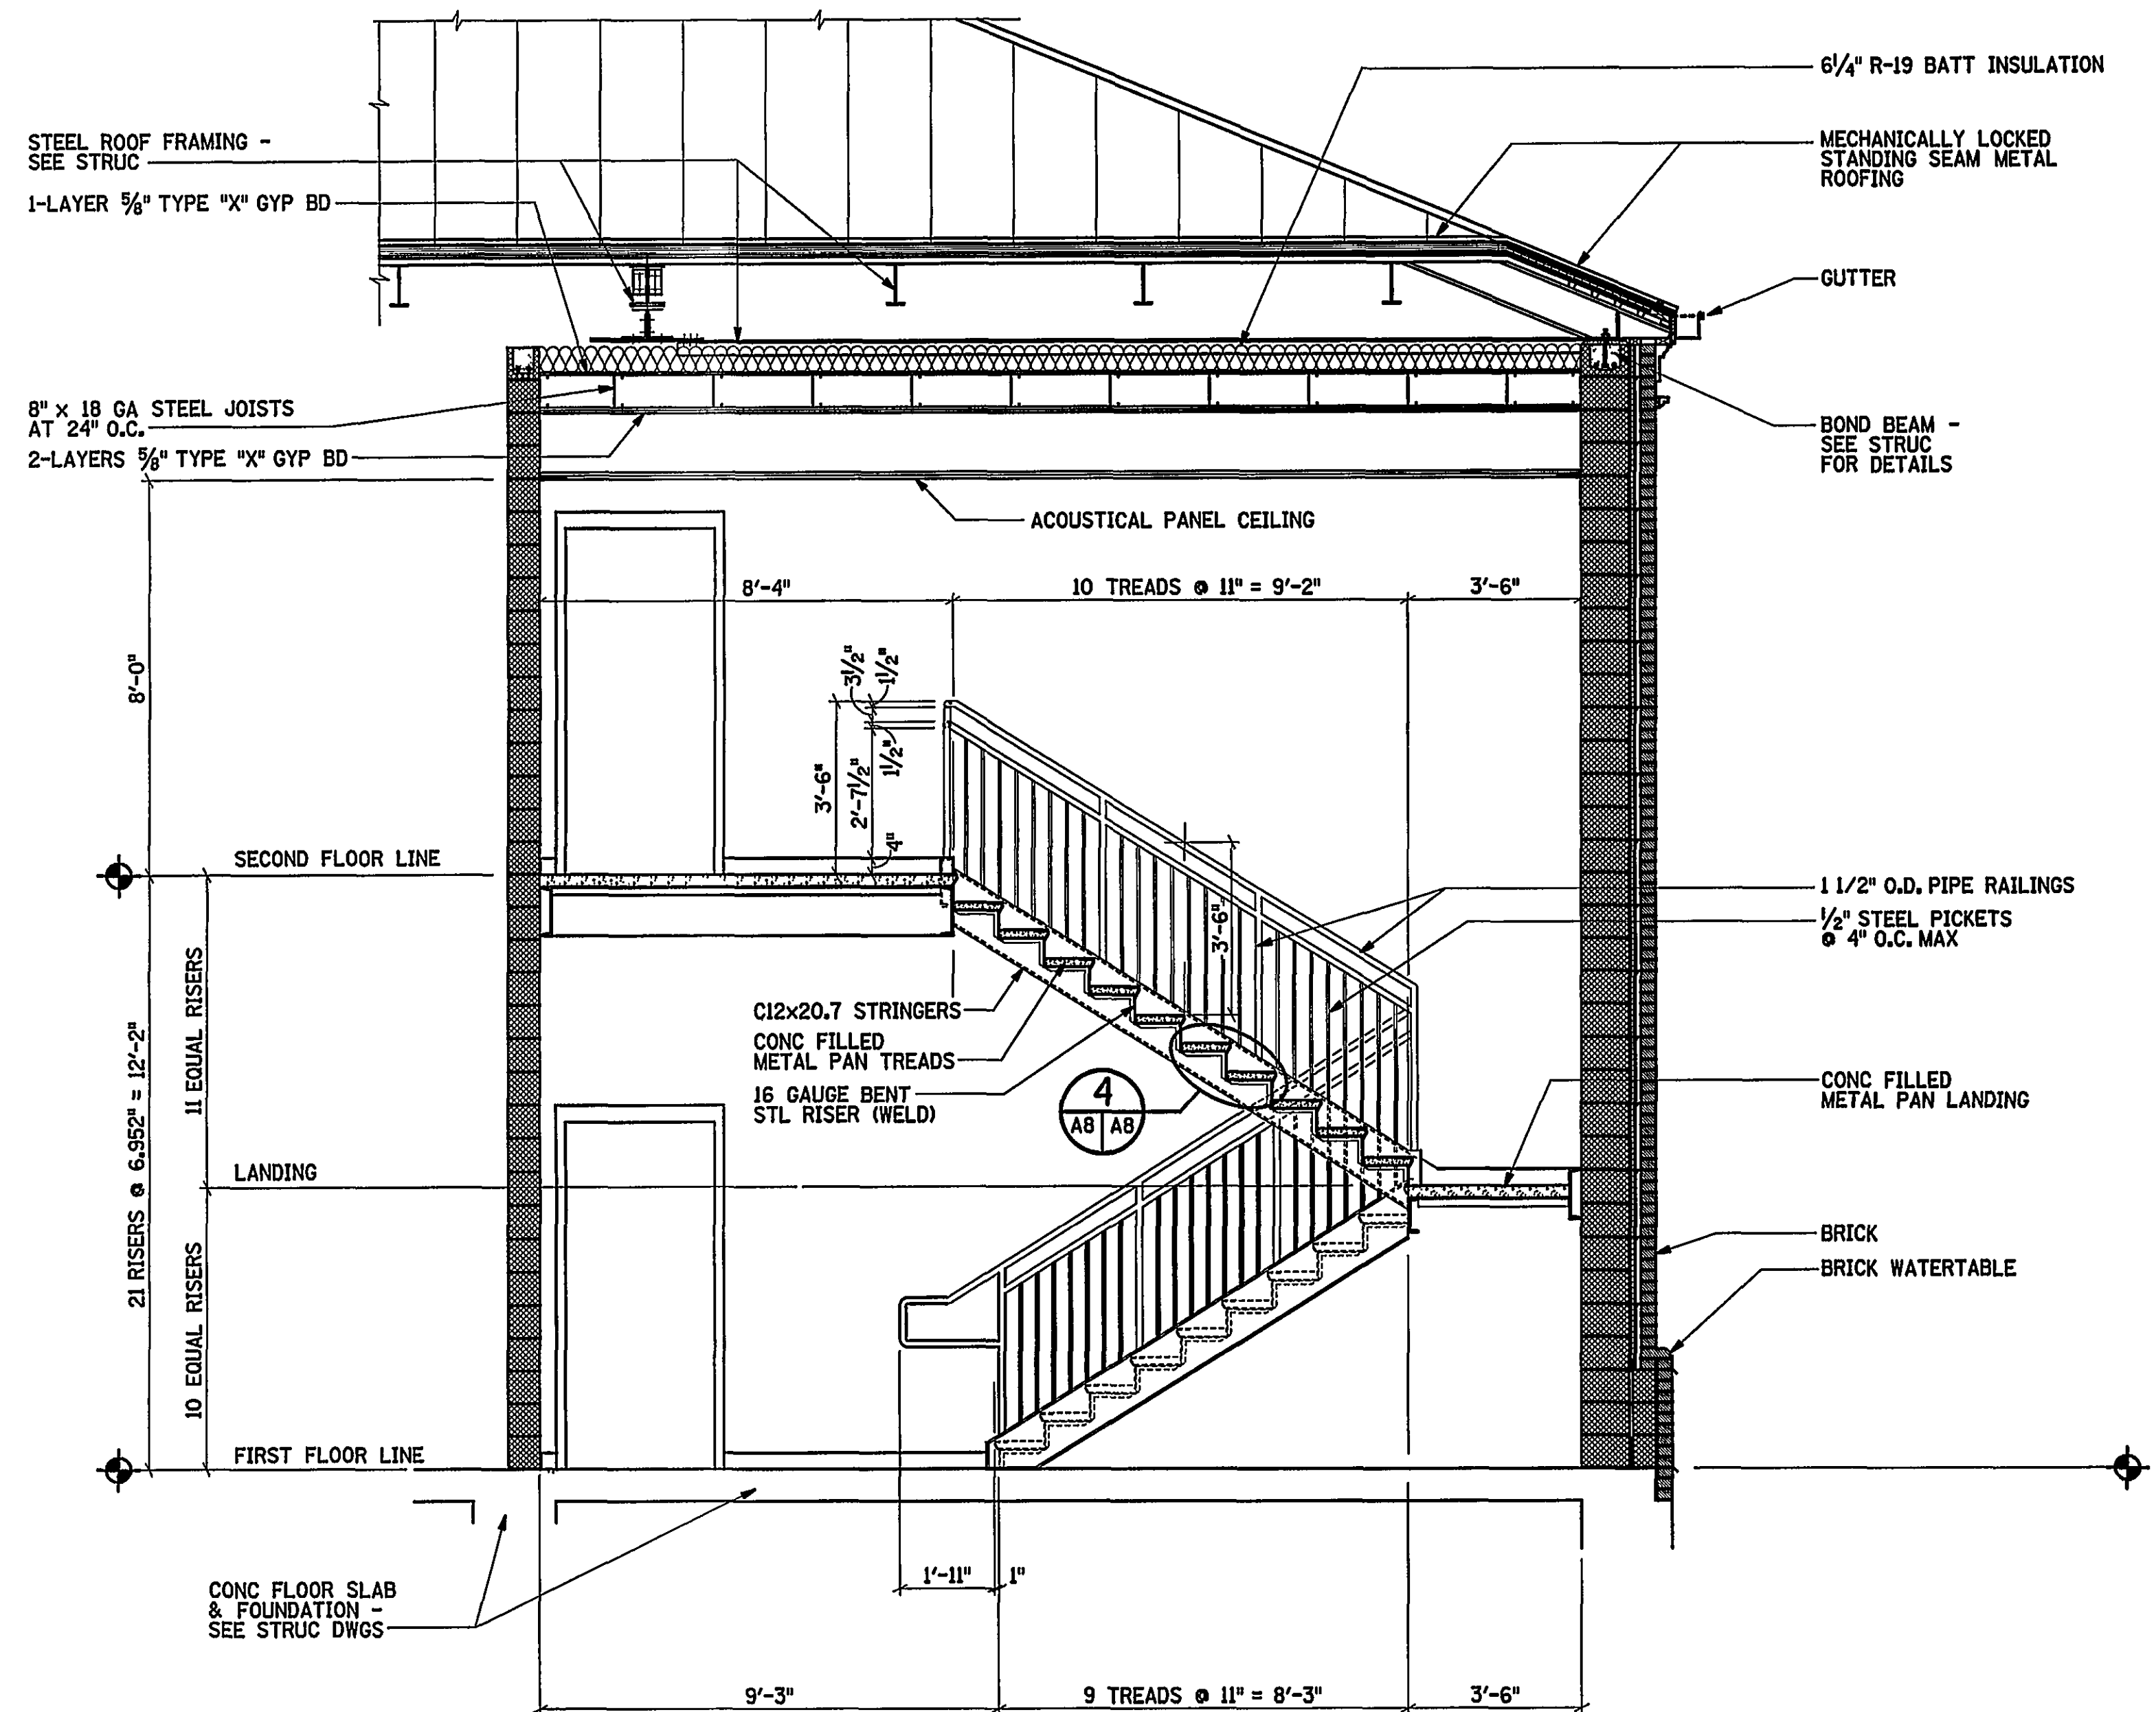

STAIR SECTION

SCALE: 3/8" = 1'-0"


3
A8 AB

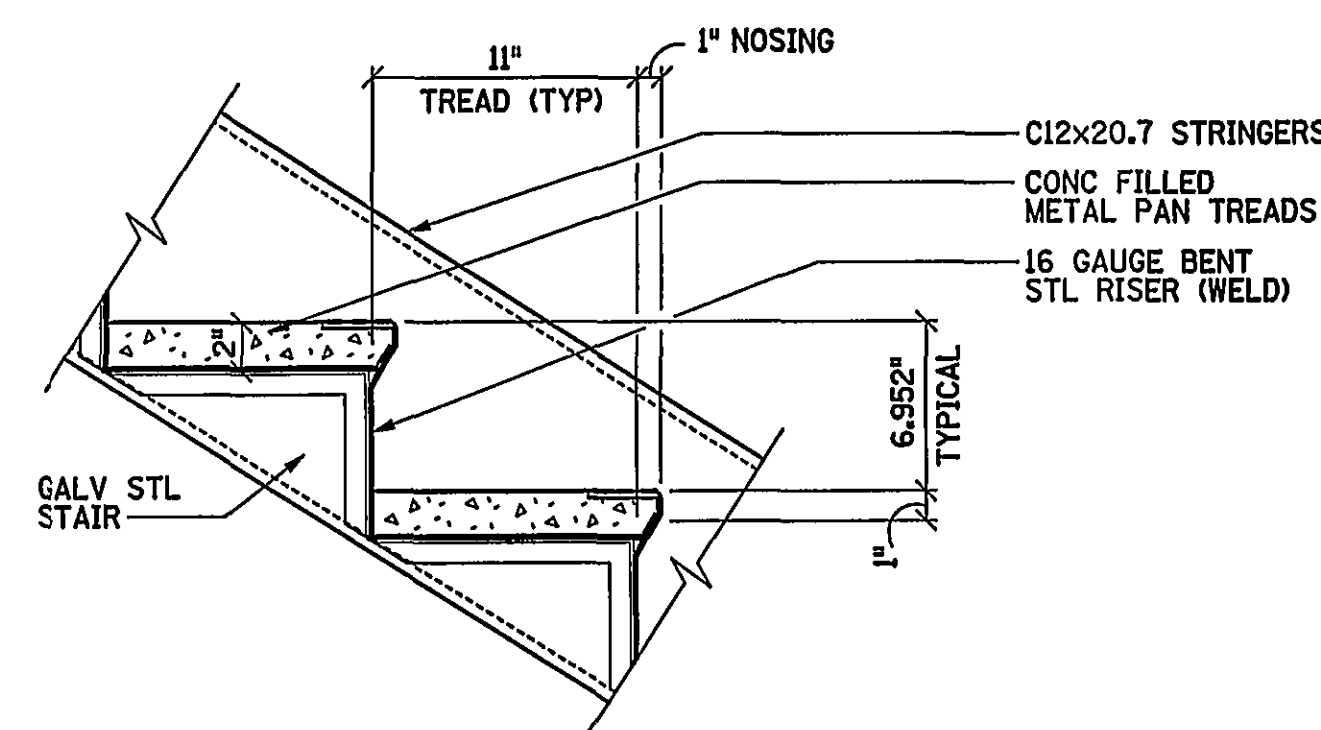

DETAIL

SCALE: 1 1/2" = 1'-0"

4
A8 AB

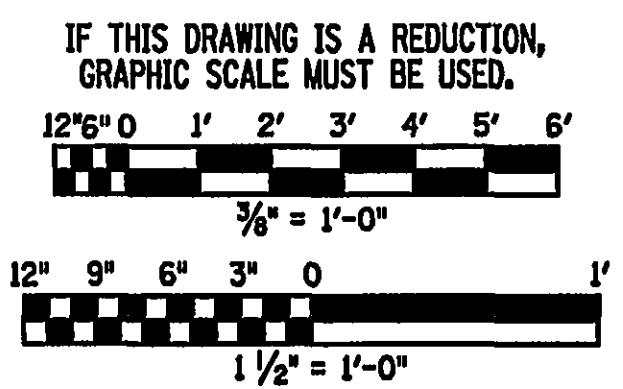

REV.	DATE	BY	APP.	DESCRIPTION
5-01-03	JLW	MKJ		RECORD DRAWING

RECORD DRAWING

DATE: MAY 1, 2003

Wiley & Wilson
ARCHITECTS ENGINEERS PLANNERS
An Employee-Owned Company

2310 LANGHORNE ROAD
LYNCHBURG, VIRGINIA
24501
(804) 947-1901

P.O. BOX 877
LYNCHBURG, VIRGINIA
24505-0877

HDR

HDR Engineering, Inc.
5700 LAKE WRIGHT DRIVE
NORFOLK, VIRGINIA 23502
757-222-1500

DESIGNED	DRAWN	PROJECT
JRM	AEL	CRYSTAL SPRING WATER TREATMENT PLANT FOR THE CITY OF ROANOKE, VIRGINIA
CHECKED	REVIEWED	REFERENCE
MKJ		ARCHITECTURAL
COMM. NO.	CADD NO.	TITLE
200171.01	200171A8.DGN	ENLARGED STAIR PLANS & DETAILS
DATE	DWG. NO.	SHEET NO.
AUG 26, 2001	A-8	19 OF 72

REV. 0