


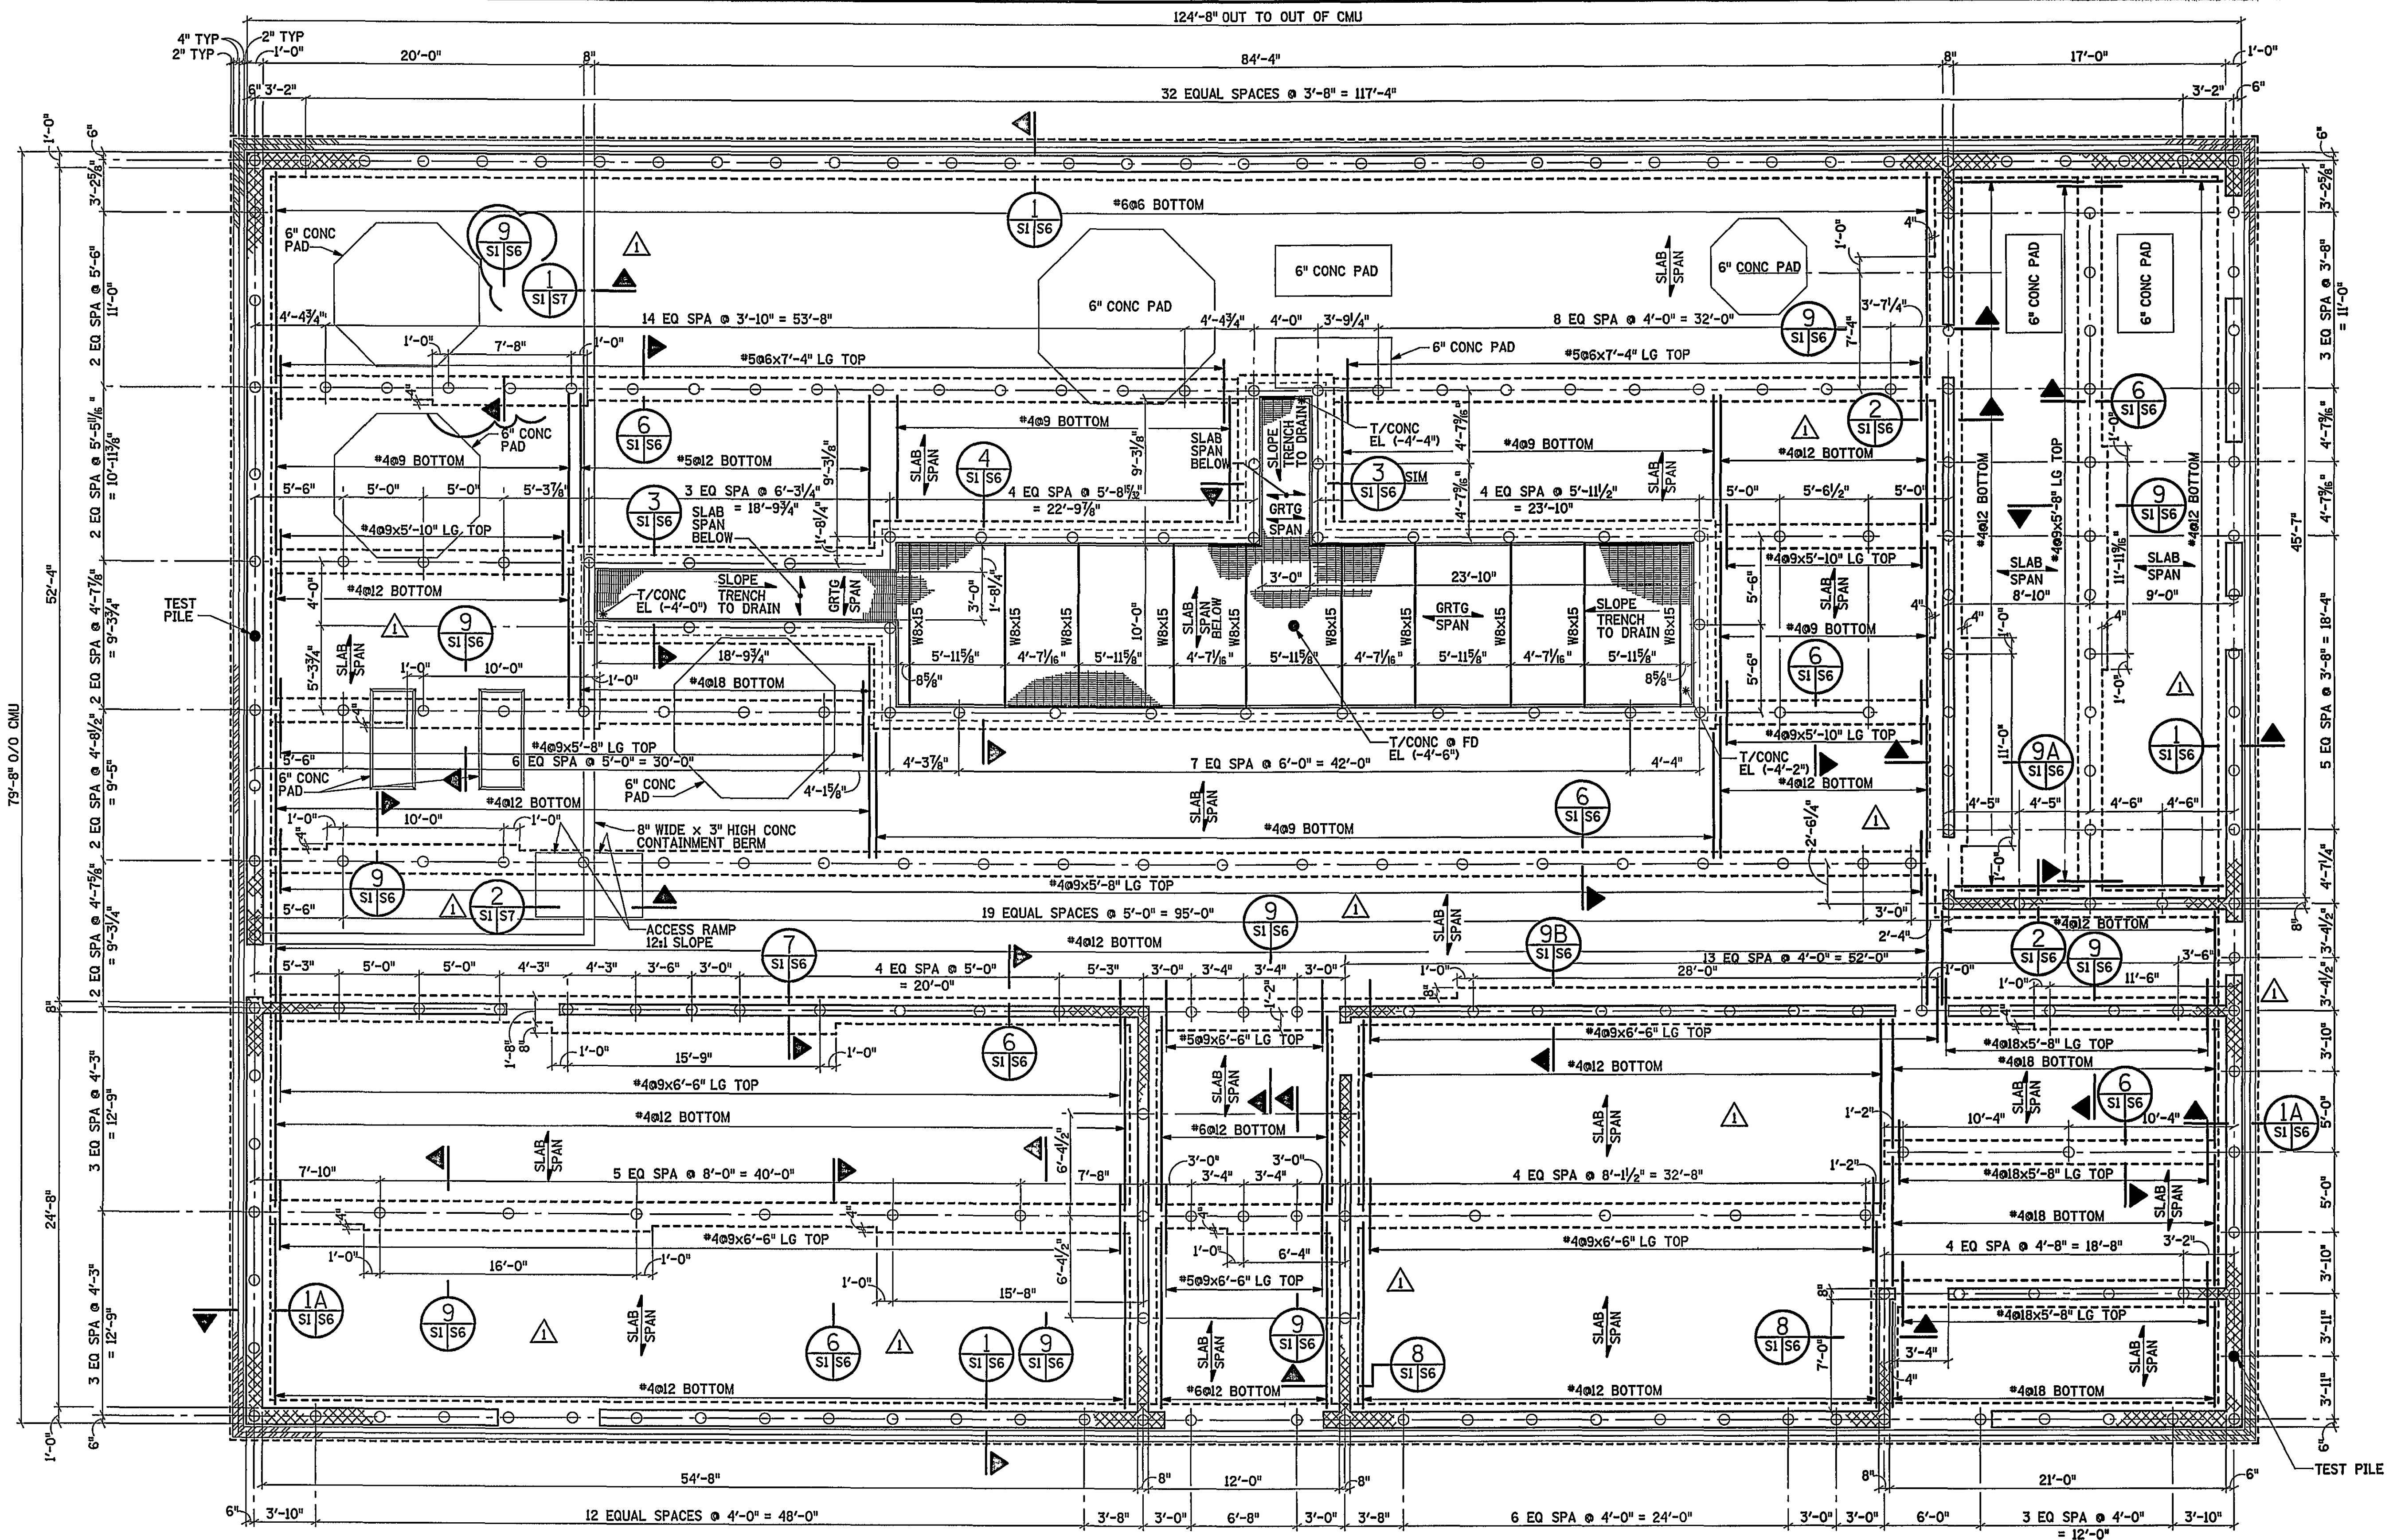


FOUNDATION PLAN

SCALE: 3/16" = 1'-0" NOTE: SLAB IS 10" THICK ON PILE SUPPORTED BEAMS, FINISH FLOOR EL 946.50'.



IF THIS DRAWING IS A REDUCTION, GRAPHIC SCALE MUST BE USED.

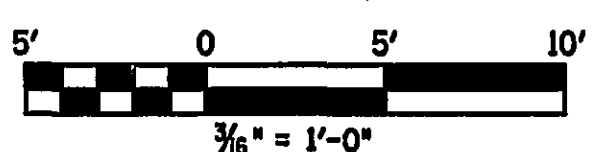

NOTE: FOR GENERAL NOTES, SEE DWG. S-7.

REV.	DATE	BY	APP.	DESCRIPTION
1	5-01-03	JLW	MKJ	RECORD DRAWING
2	2-13-02	JDI	NST	WIDENED BEAMS WHERE PILES PLACED OUT OF TOLERANCE

RECORD DRAWING

DATE: MAY 1, 2003

Wiley & Wilson
ARCHITECTS ENGINEERS PLANNERS
An Employee-Owned Company

2310 LANGHORNE ROAD
LYNCHBURG, VIRGINIA 24501
(804) 947-1901

HDR

HDR Engineering, Inc.
5700 LAKE WRIGHT DRIVE
NORFOLK, VIRGINIA 23502
757-222-1500

DESIGNED	DRAWN	PROJECT
JEH	JEH	CRYSTAL SPRING WATER TREATMENT PLANT FOR THE CITY OF ROANOKE, VIRGINIA
CHECKED	REVIEWED	REFERENCE
NST	VKA	STRUCTURAL
COMM. NO.	CADD NO.	TITLE
200171.01	200171S06.DGN	FOUNDATION PLAN
DATE	DWG. NO.	SHEET NO.
AUG 26, 2001	S-1	22 OF 72
		REV. 1