


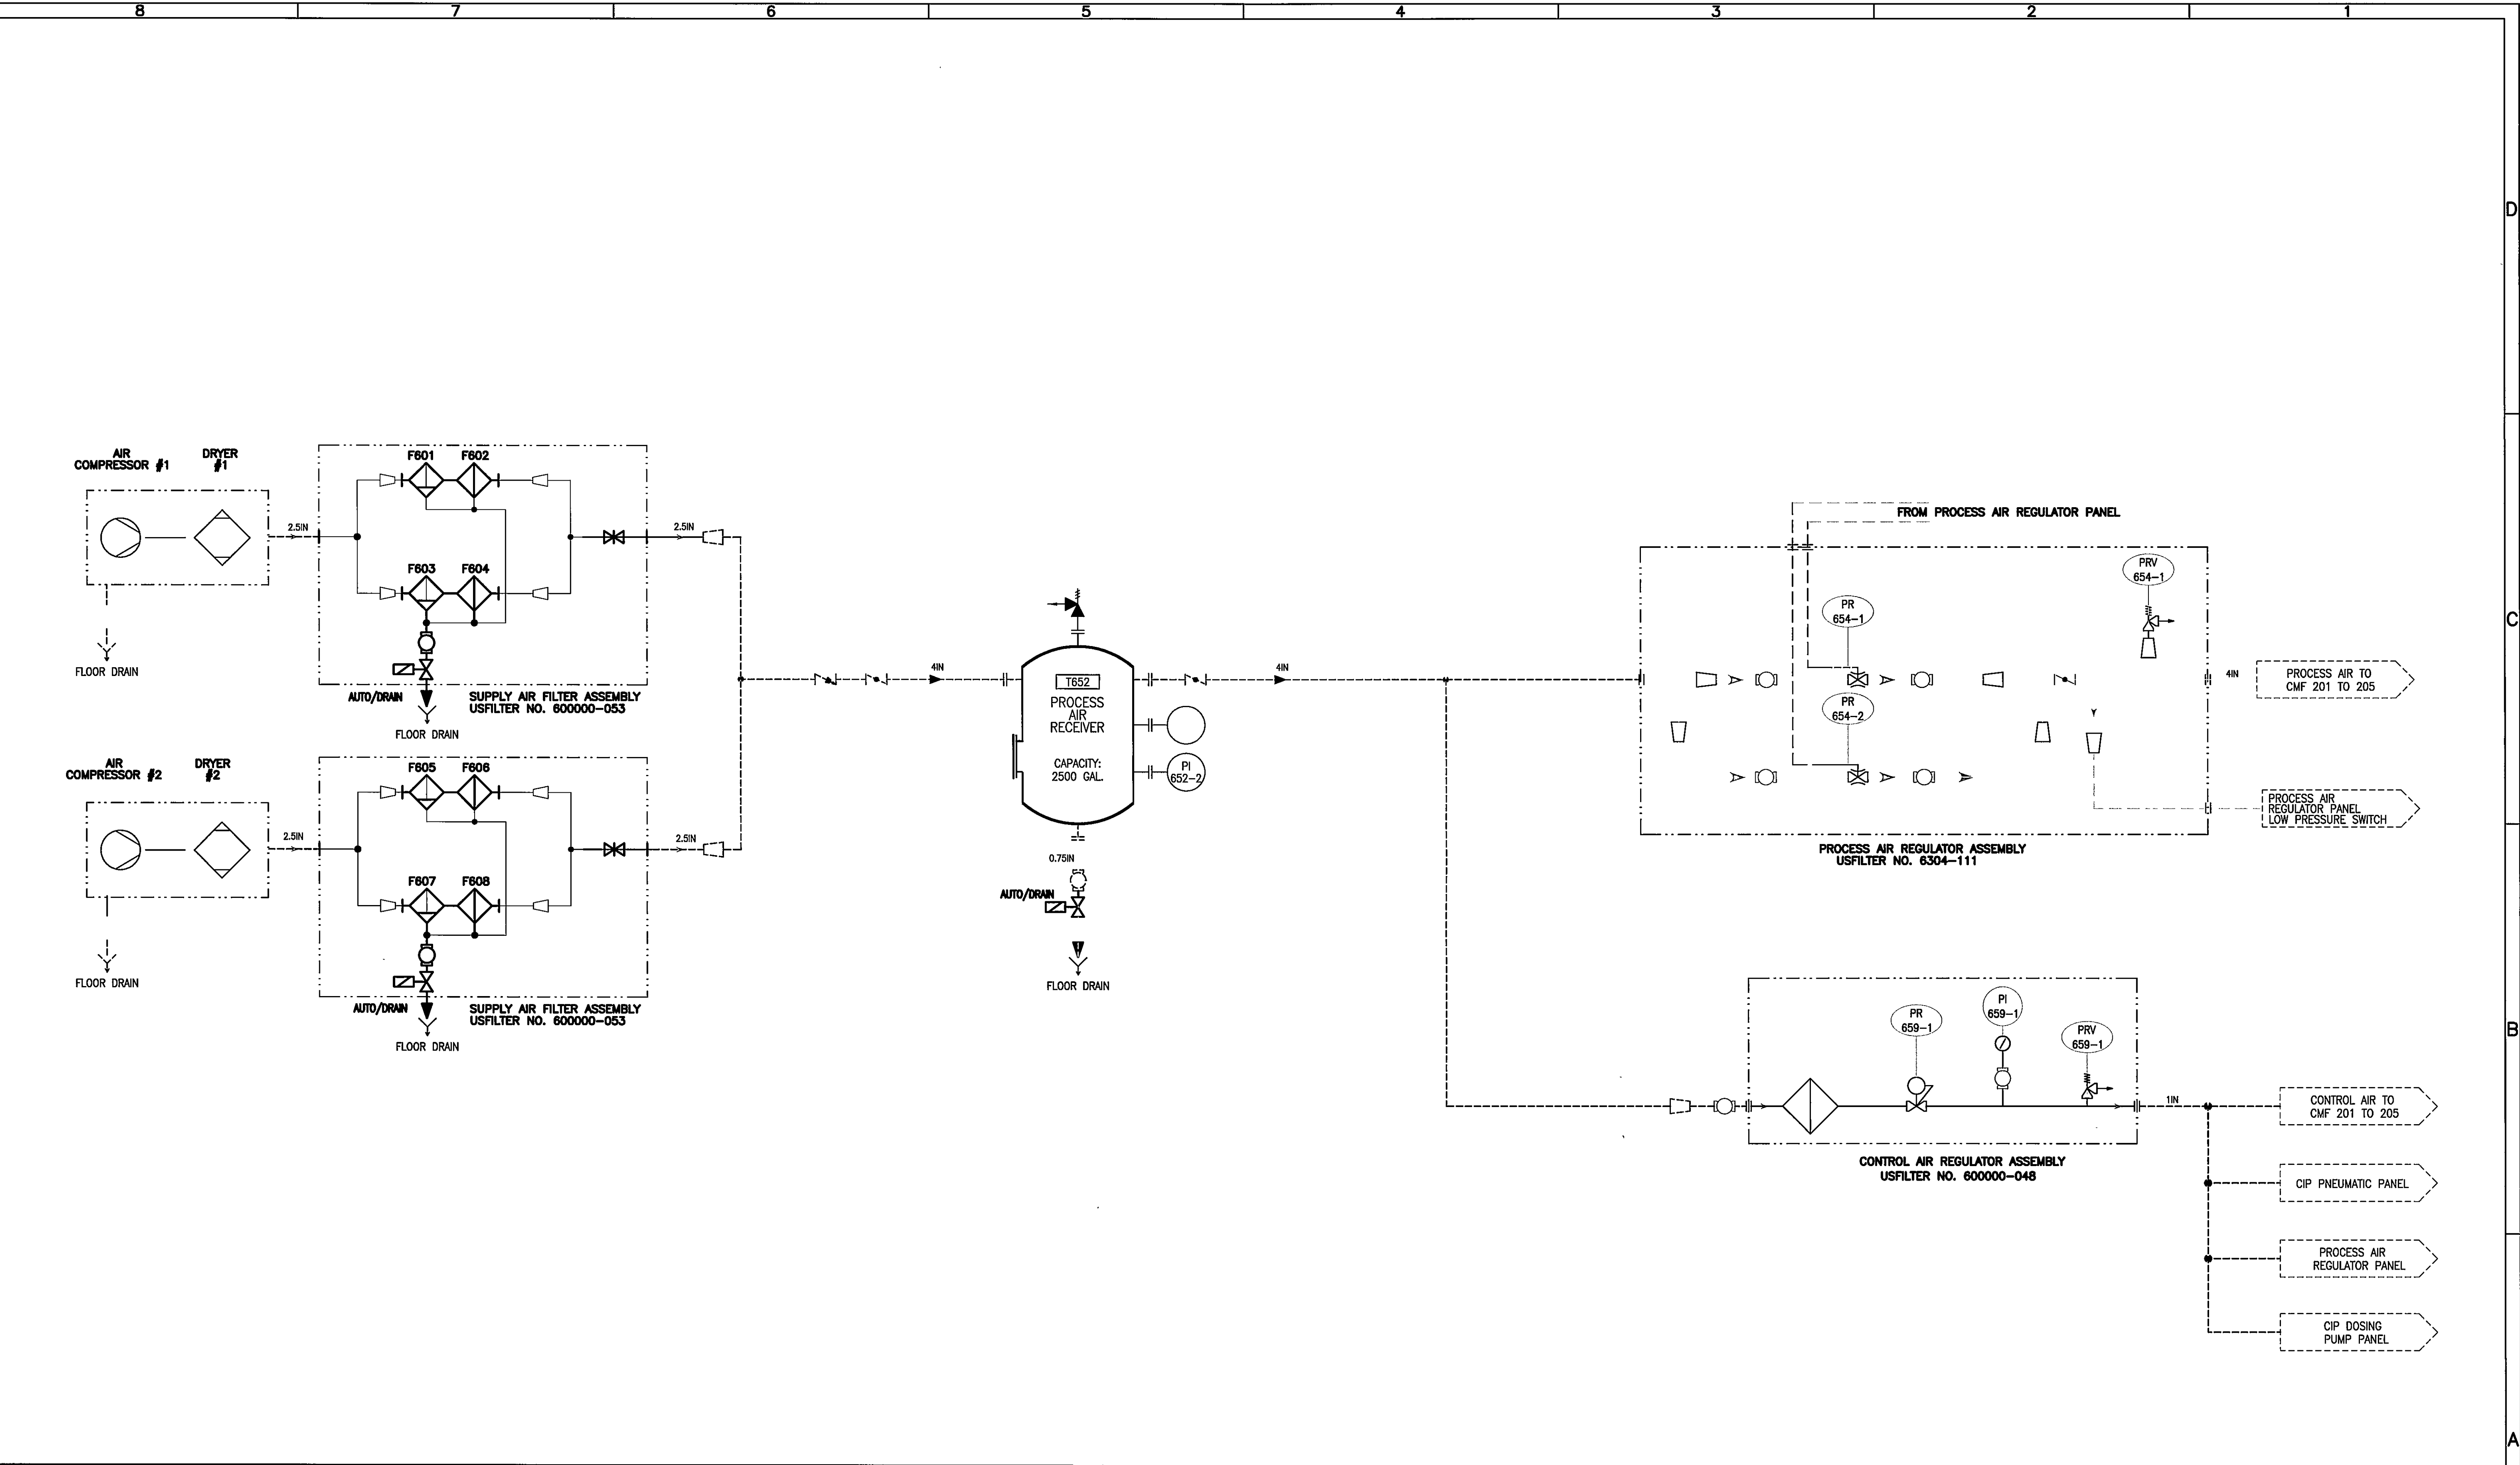

NOTES: 1. ALL MAIN HEADERS, EXCEPT CIP, TO HAVE FLUSHING POINTS 2. DRAIN POINTS TO BE INCLUDED AT APPROPRIATE POINTS, TO BE FINALIZED UPON COMPLETION OF GA's. 3. VENT POINTS TO BE INCLUDED AT APPROPRIATE POINTS, TO BE FINALIZED UPON COMPLETION OF GA's.	ITEMS DASHED ARE BY OTHERS.	RECORD DRAWING APRIL 28, 2003	COMPANY CONFIDENTIAL THIS DOCUMENT AND ALL INFORMATION CONTAINED HEREIN ARE THE PROPERTY OF THE USFILTER AND/OR ITS AFFILIATES ("USF"). THE DESIGN CONCEPTS AND INFORMATION CONTAINED HEREIN ARE PROPRIETARY TO USF AND ARE SUBMITTED IN CONFIDENCE. THEY ARE NOT TRANSFERABLE AND MUST BE USED ONLY FOR THE PURPOSE FOR WHICH THE DOCUMENT IS SUBMITTED. NO PART OF THIS DOCUMENT IS TO BE REPRODUCED, LOANED OR USED IN ANY OTHER MANNER WITHOUT THE EXPRESS WRITTEN CONSENT OF USF. IN NO EVENT SHALL THEY BE USED IN ANY MANNER EXTENDING TO THE INTEREST OF USF. ALL PATENT RIGHTS ARE RESERVED. UPON THE DEMAND OF USF, THIS DOCUMENT, ALONG WITH ALL COPIES AND EXTRACTS, MUST BE RETURNED TO USF OR DESTROYED, AS INSTRUCTED BY USF. ACCEPTANCE OF THE DELIVERY OF THIS DOCUMENT CONSTITUTES AGREEMENT TO THESE TERMS AND CONDITIONS.										DESIGNER	DATE	TITLE		
			KFOX	07/21/2000	P & ID PROCESS AND CONTROL AIR												
			CHECKER	DATE	CLIENT												
			ENGINEER	DATE	CRYSTAL SPRINGS WATER TREATMENT PLANT ROANOKE, VIRGINIA												
			MANAGER	DATE	USFilter 2118 GREENSPRING DRIVE TIMONIUM, MD 21093 USA TEL: 1-800-MEMCOR4												
0	PRULIMINARY ISSUE	8/10/01	MOC	----	----	----	----	----	----	----	FILE: 260056-0003-5	SCALE: NOT TO SCALE	PROJECT 260056	CODE	DRAWING P-29	SHEET OF	REV 0
STD: 2-0799-22x340	INTERNAL REF NO:	BAR = 1" AT PLOT SCALE		REV	DESCRIPTION		DATE	DWN	CHKD	APVD	ECN						