


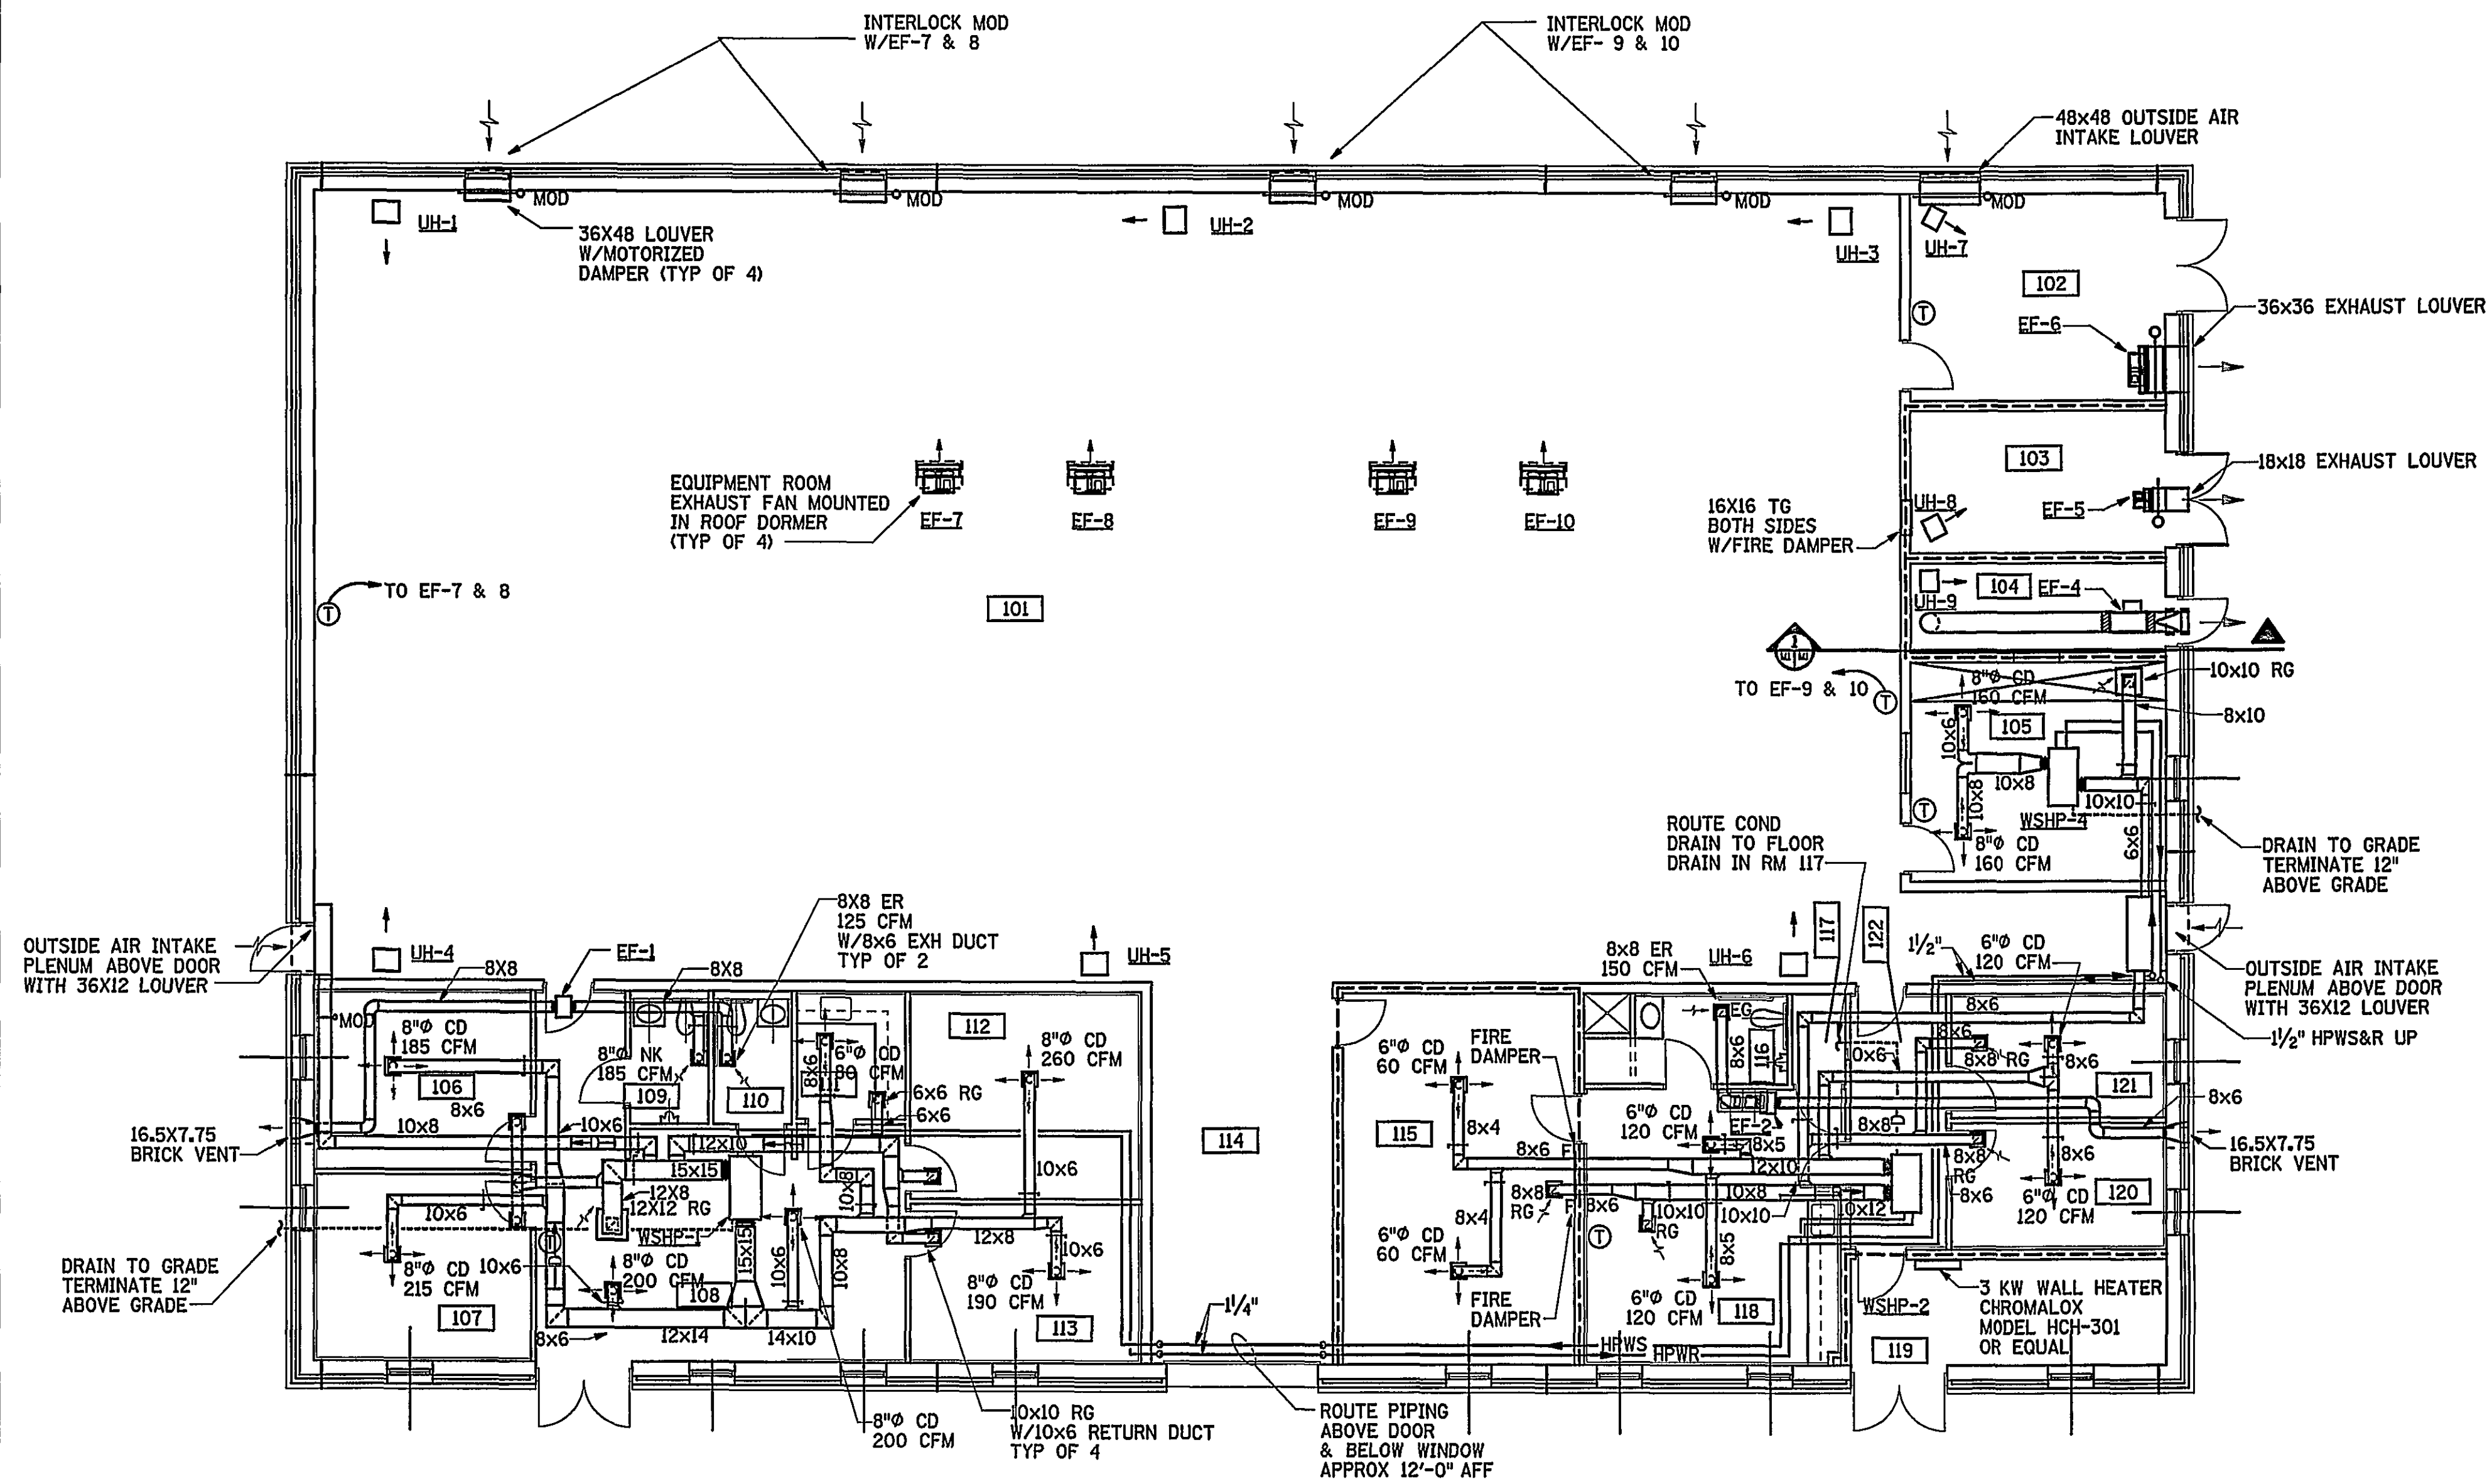


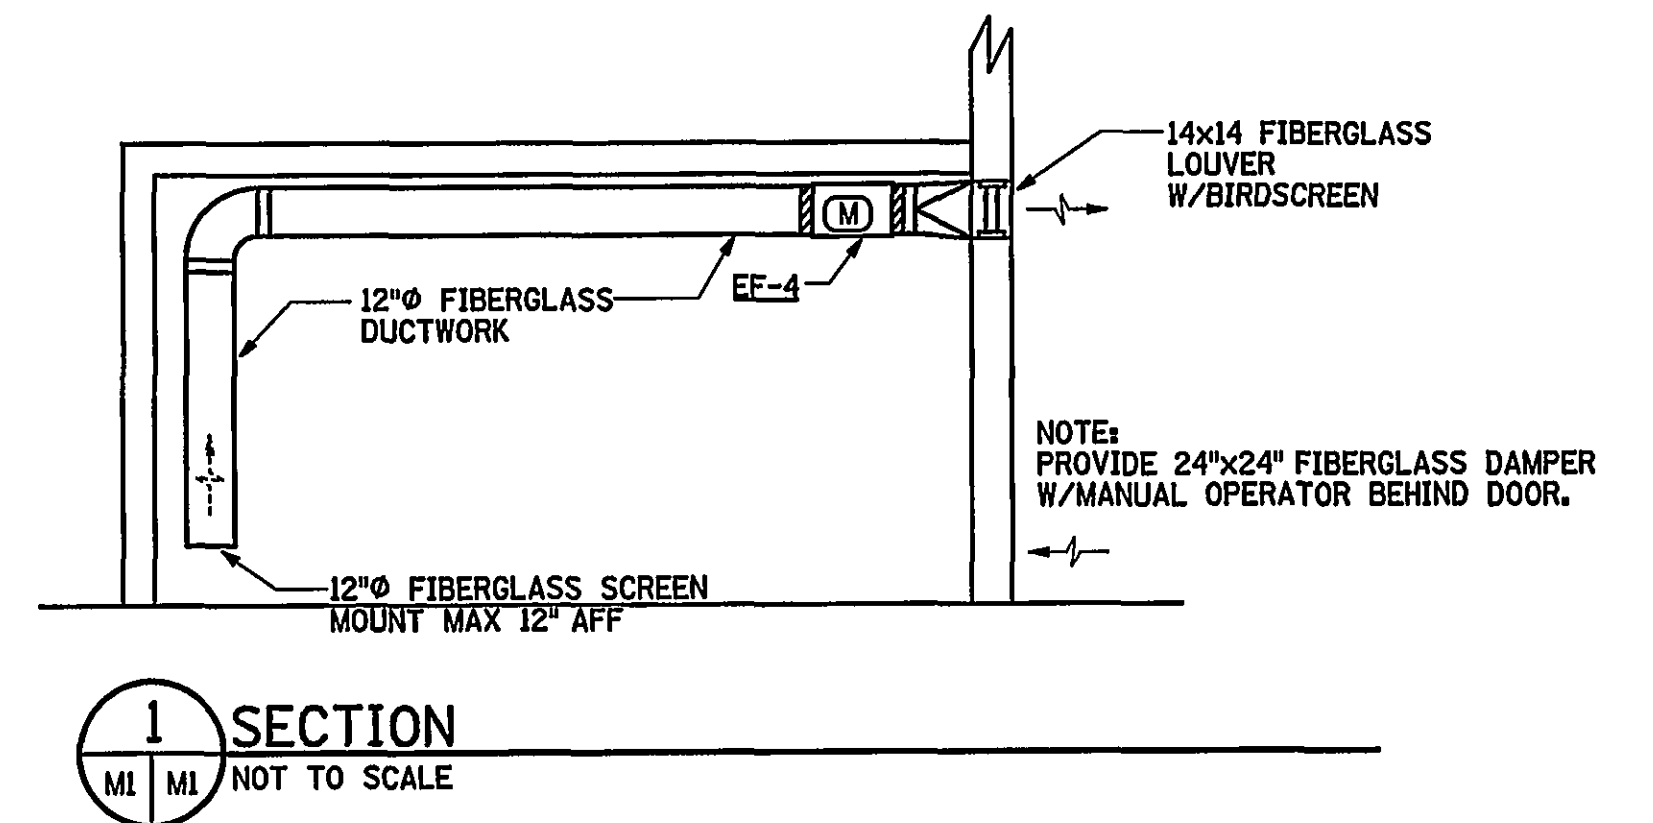

MAIN FLOOR PLAN
SCALE: 1/8" = 1'-0"

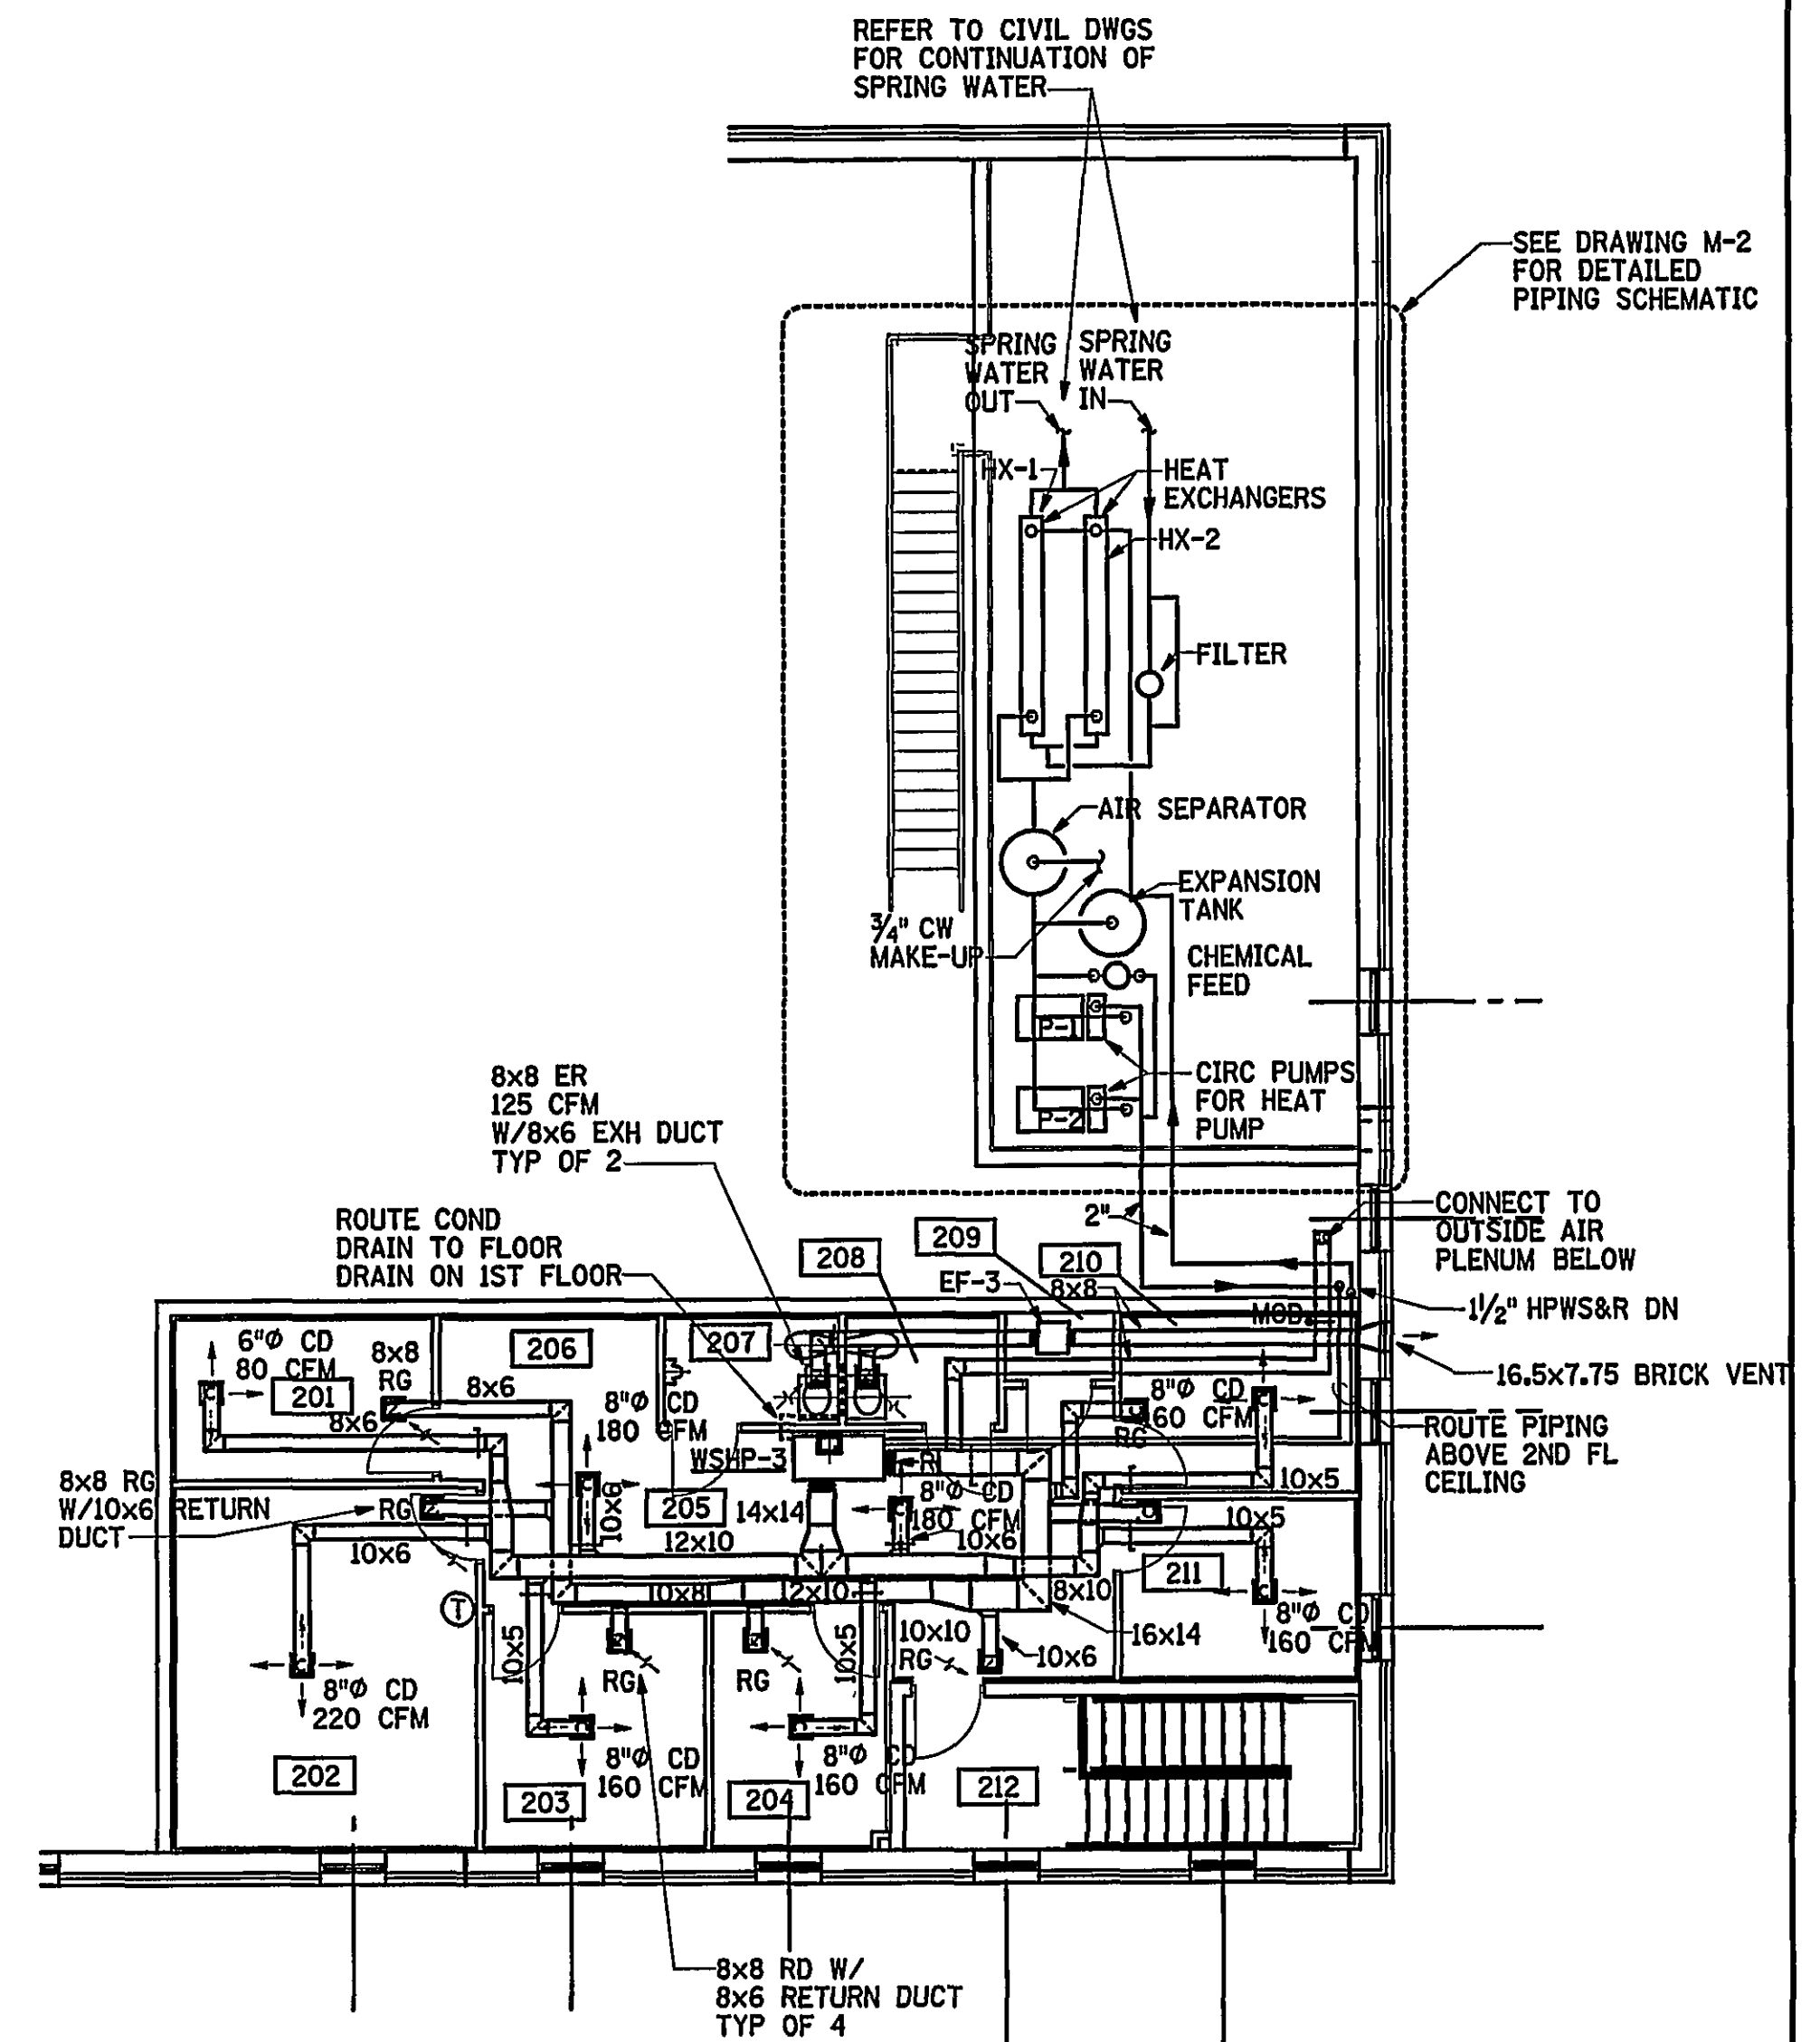

PARTIAL SECOND FLOOR PLAN
SCALE: 1/8" = 1'-0"

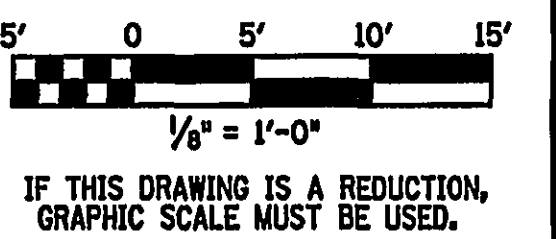

1	9/14/01	DAN	MKJ	FAN EF-6 & ASSOCIATED EXHAUST & INTAKE LOUVERS INCREASED IN SIZE; ADDED MOD TO INTAKE LOUVER
	5-01-03	JLW	MKJ	RECORD DRAWING
REV.	DATE	BY	APP.	DESCRIPTION

RECORD DRAWING

DATE: MAY 1, 2003

Wiley & Wilson
ARCHITECTS ENGINEERS PLANNERS
An Employee-Owned Company

2310 LANGHORNE ROAD
LYNCHBURG, VIRGINIA 24501
(804) 947-1901

P.O. BOX 877
LYNCHBURG, VIRGINIA 24505-0877

HDR

HDR Engineering, Inc.
5700 LAKE WRIGHT DRIVE
NORFOLK, VIRGINIA 23502
757-222-1500

IN ASSOCIATION WITH

DESIGNED DAN	DRAWN DAN	PROJECT CRYSTAL SPRING WATER TREATMENT PLANT FOR THE CITY OF ROANOKE, VIRGINIA
CHECKED MJK	REVIEWED	REFERENCE MECHANICAL
COMM. NO. 200171.01		
CADD NO. 200171M.DGN	TITLE HVAC PLAN - 1ST & 2ND FL	
DATE AUG 26, 2001	DWG. NO. M-1	SHEET NO. 57 OF 72
		REV. 0