




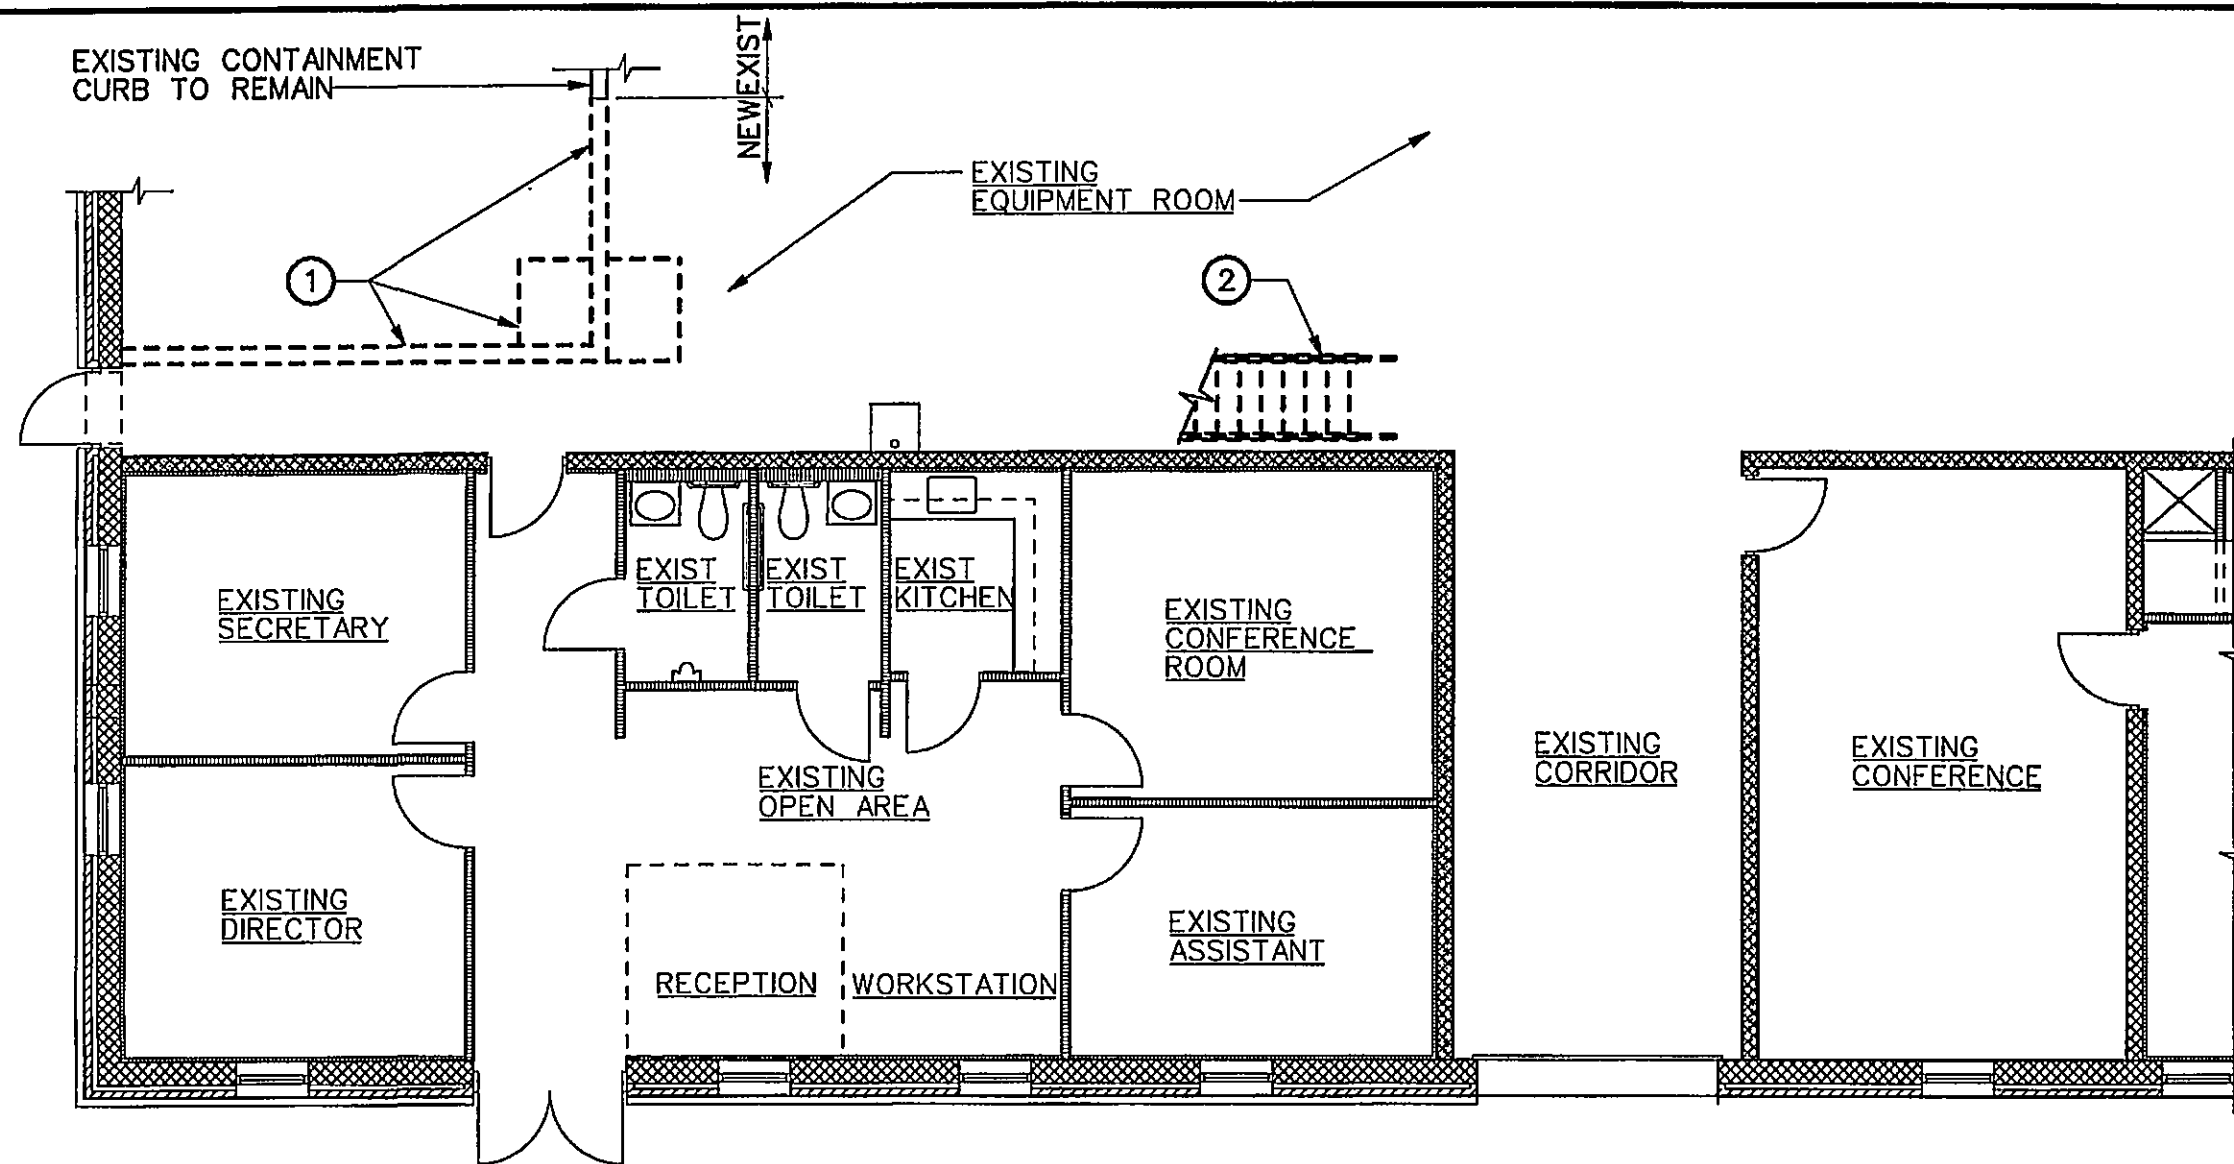


DEMOLITION - FIRST FLOOR PLAN
SCALE: 1/8" = 1'-0"

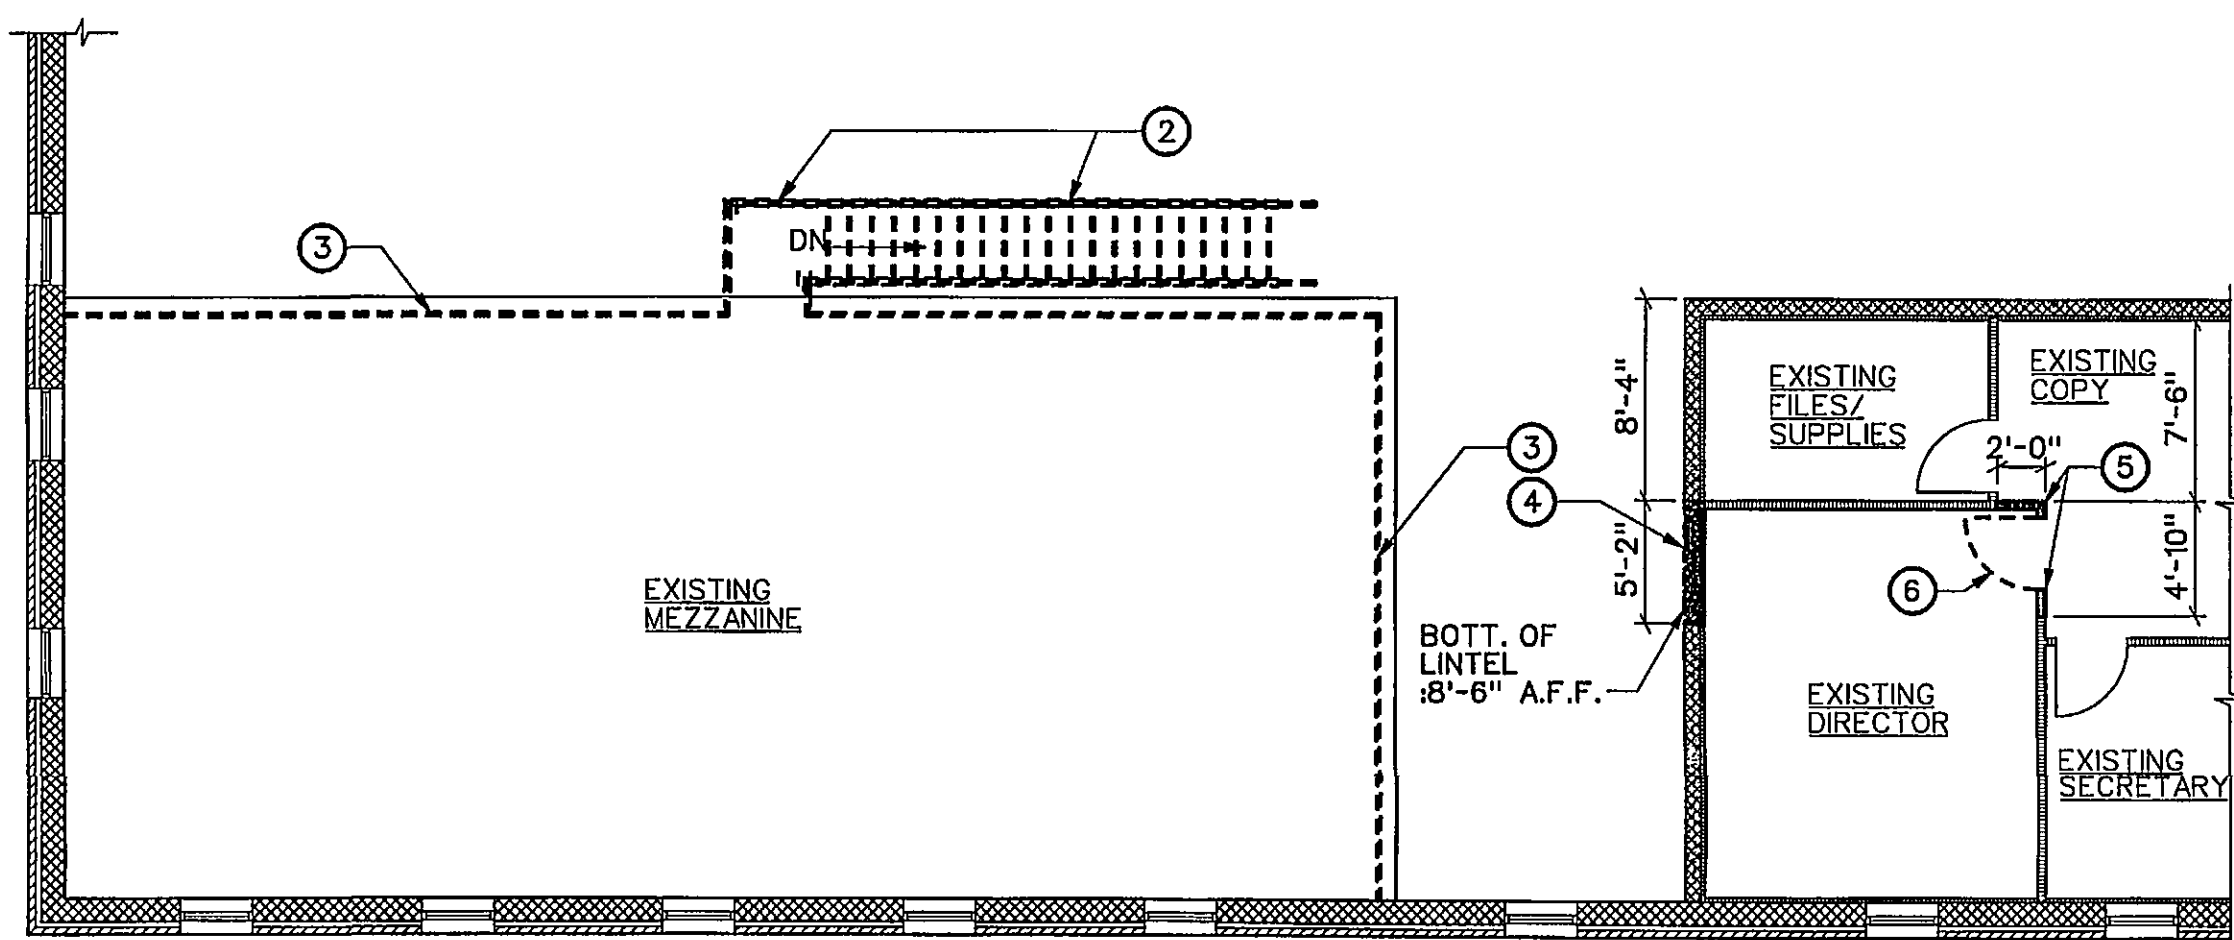

DEMOLITION - SECOND FLOOR PLAN
SCALE: 1/8" = 1'-0"

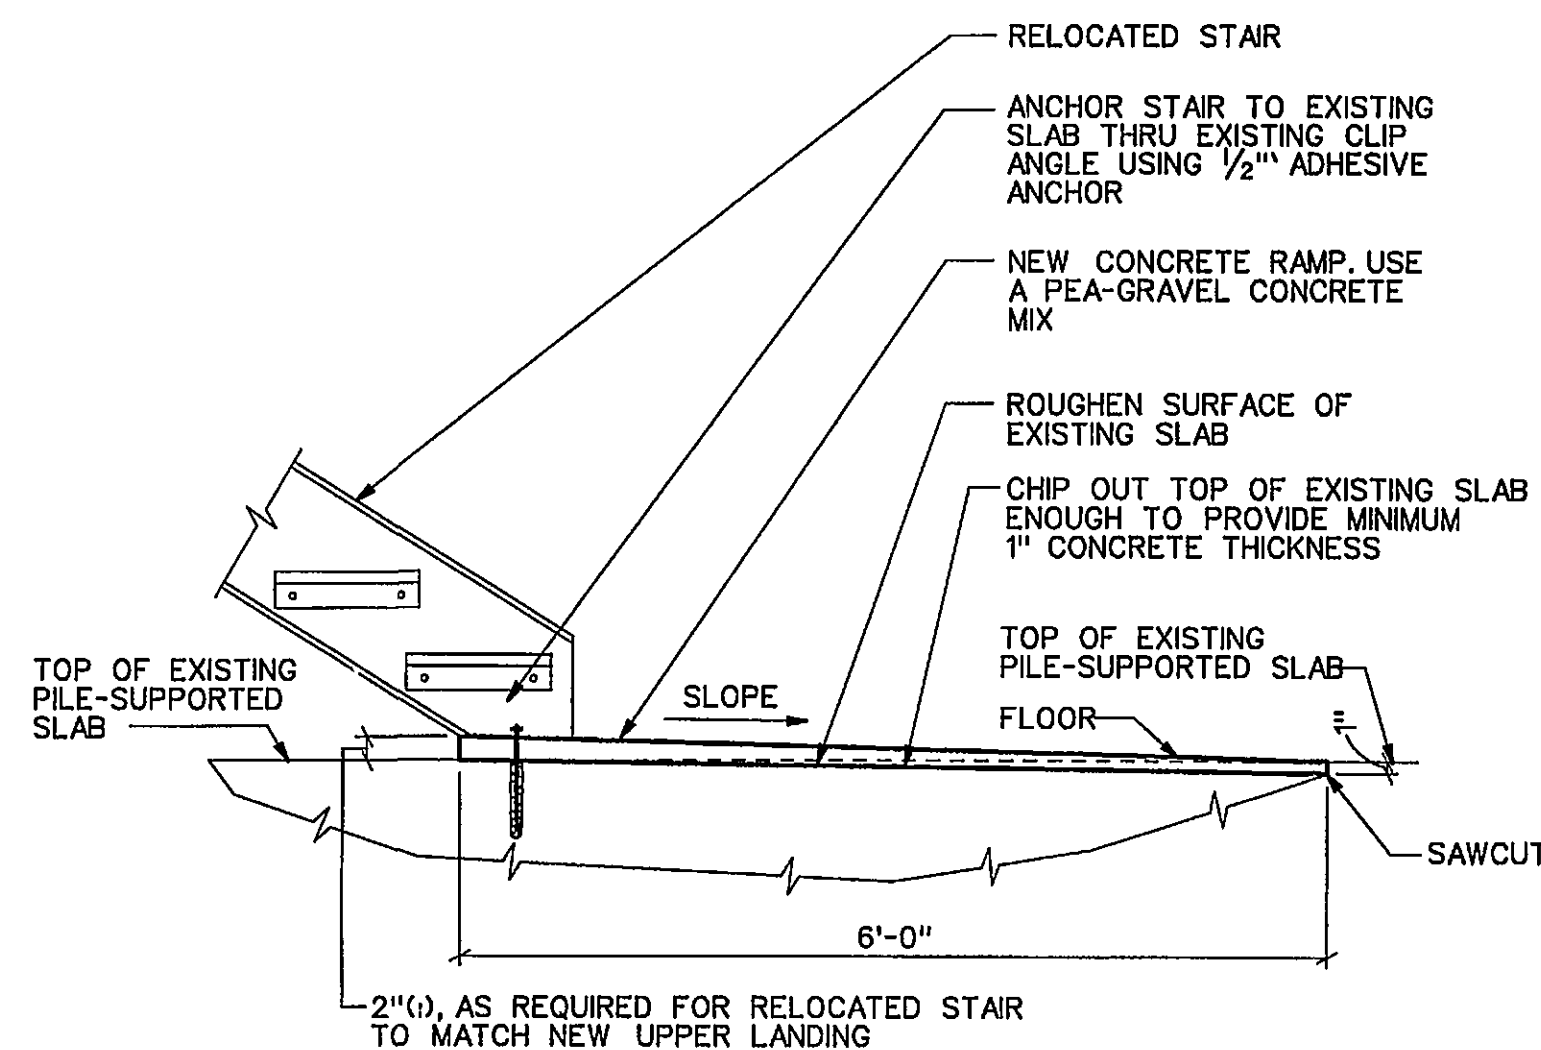


SECTION
SCALE: 3/4" = 1'-0"

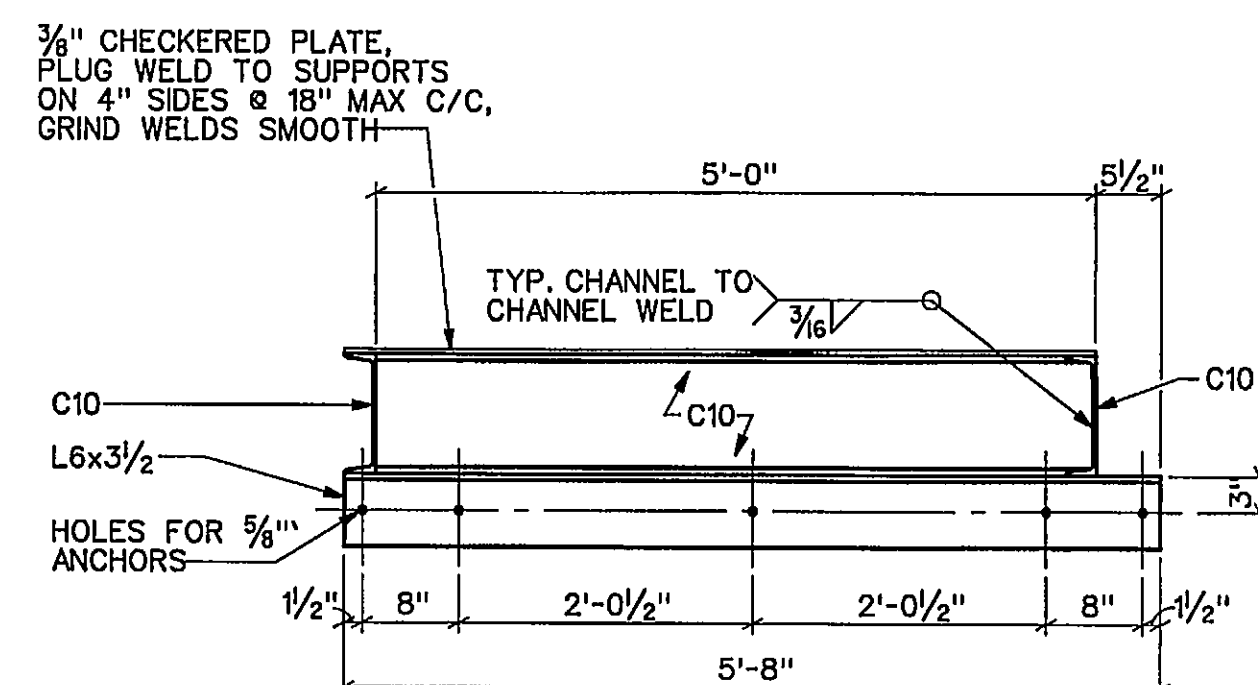


SECTION
SCALE: 3/4" = 1'-0"

DEMOLITION NOTES:


- 1 REMOVE EXISTING 3"x8"W. CONCRETE CURB AND RAMP FLUSH WITH FINISH FLOOR.
- 2 REMOVE EXISTING STAIR AND UPPER LANDING. CUT STRINGERS AT LANDING AND REUSE STRINGERS, TREADS, AND HANDRAILS IN NEW STAIR ARRANGEMENT SHOWN ON NEW WORK PLAN. REMOVE THE OLD LANDING.
- 3 REMOVE EXISTING STEEL PIPE GUARDRAIL COMPLETE.
- 4 REMOVE ENOUGH CMU TO INSTALL NEW 8"x8" REINF. CMU LINTEL OVER NEW OPENING. REINF. W/8" BEARING EACH END. WHEN LINTEL IS CURED, REMOVE 8" CMU BELOW, REMOVE EXISTING 1/2" FURRING & 1/2" GYPSUM WALLBOARD AS NECESSARY FOR NEW CONSTRUCTION LAYOUT.
- 5 REMOVE EXISTING 4" METAL STUD WALL W/ 1/2" GYPSUM WALLBOARD BOTH SIDES WHERE INDICATED ON THIS DRAWING.
- 6 REMOVE EXISTING H.M. DOOR & FRAME COMPLETE. EXISTING DOOR & FRAME SHALL BE REUSED IN NEW CONSTRUCTION AT NEW DIRECTOR'S OFFICE 206

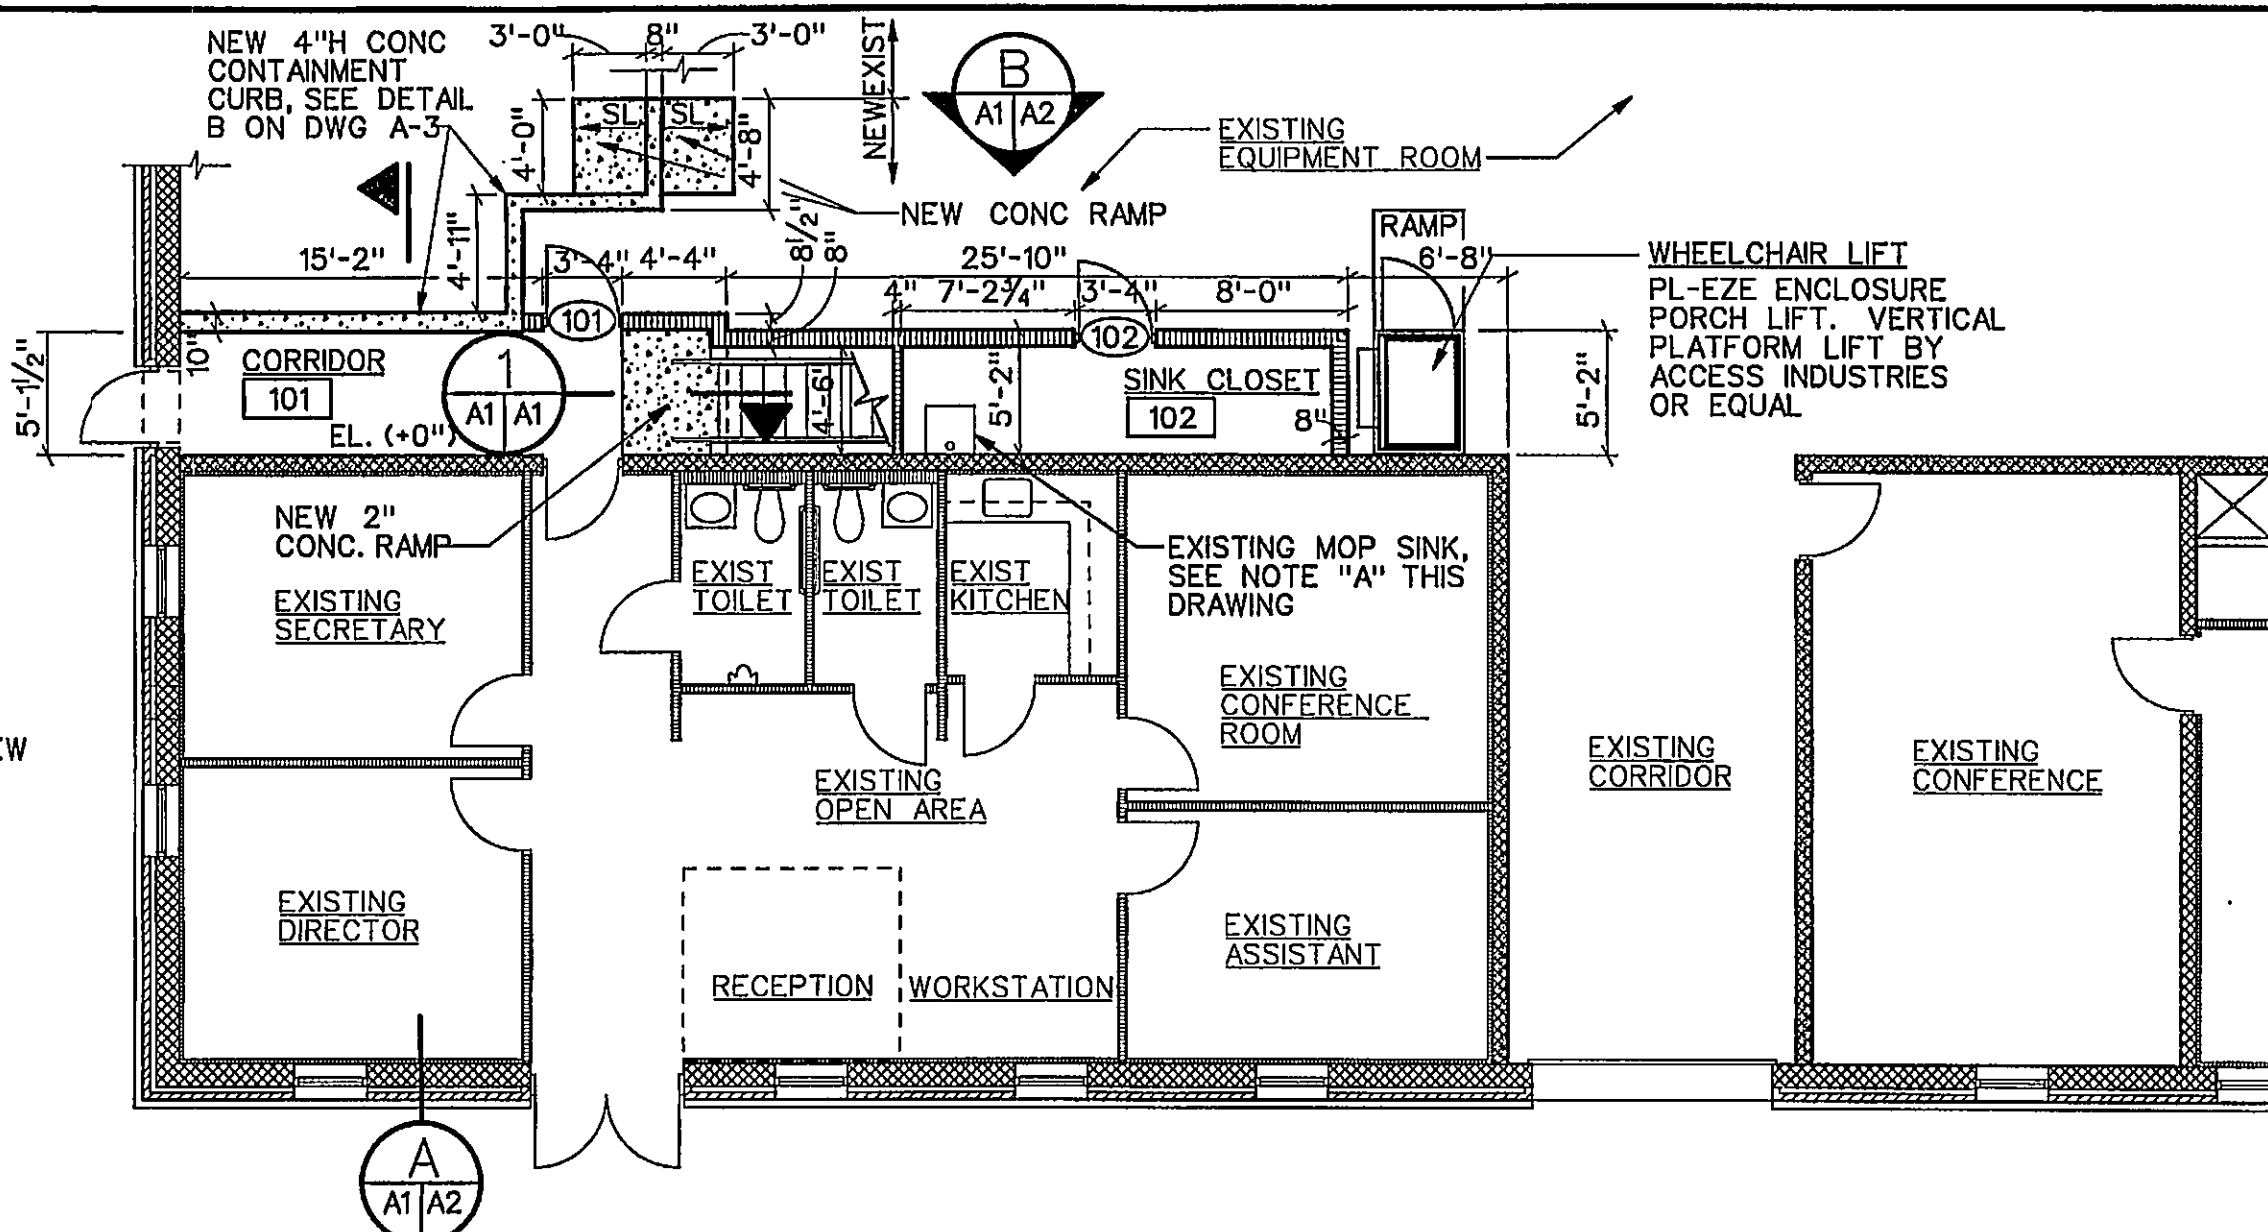


NEW WORK - FIRST FLOOR PLAN
SCALE: 1/8" = 1'-0"

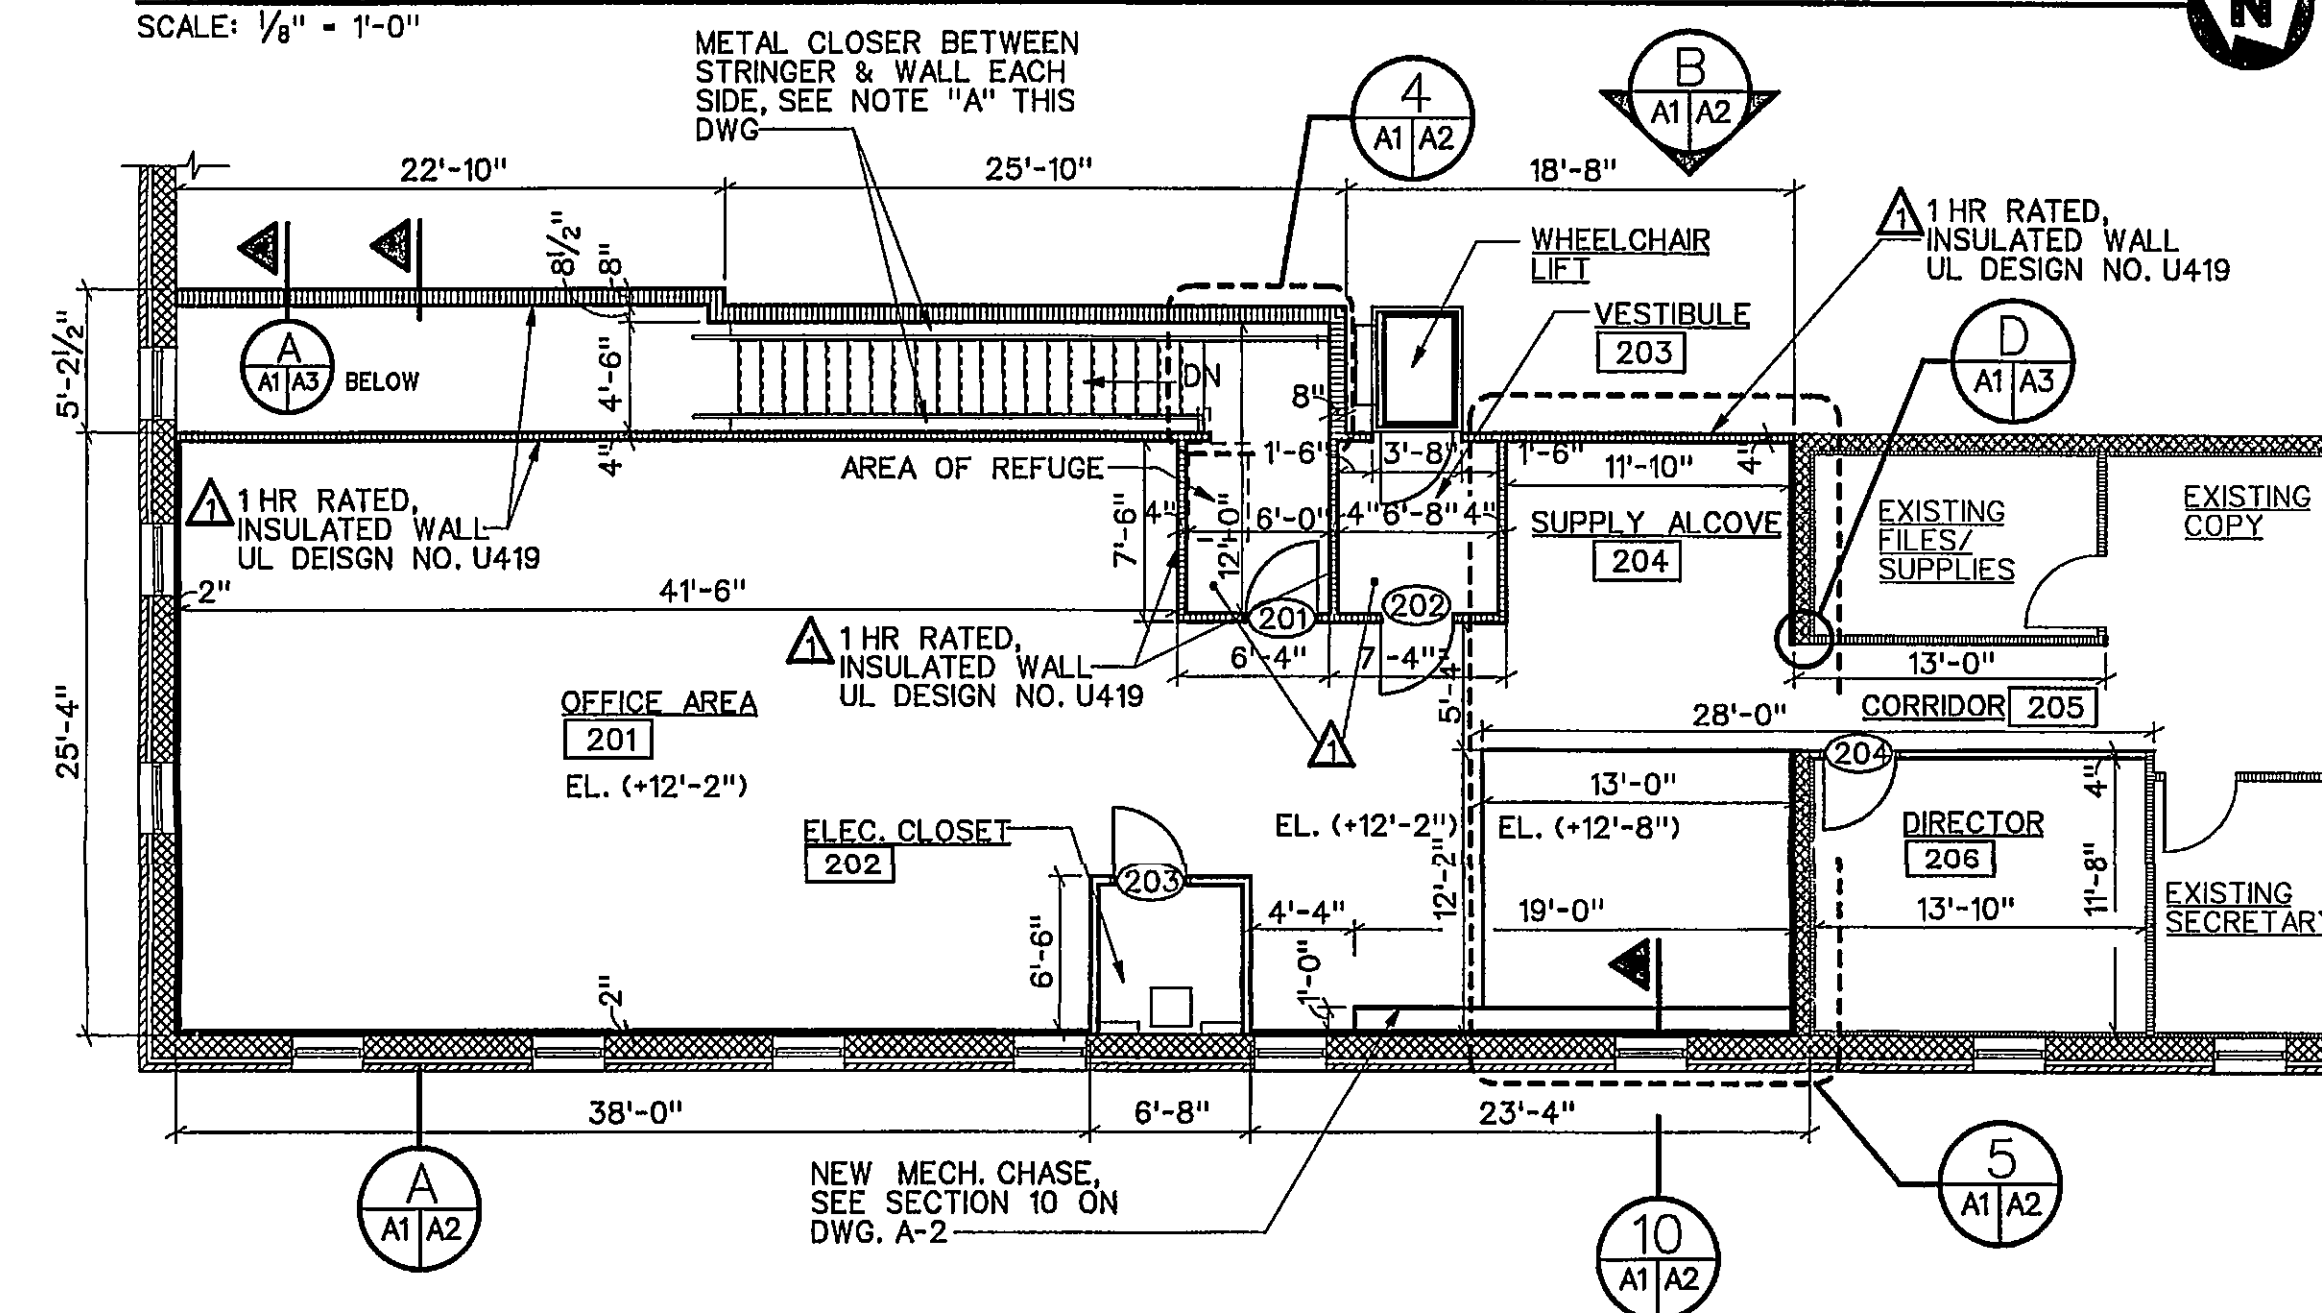

NEW WORK - SECOND FLOOR PLAN
SCALE: 1/8" = 1'-0"

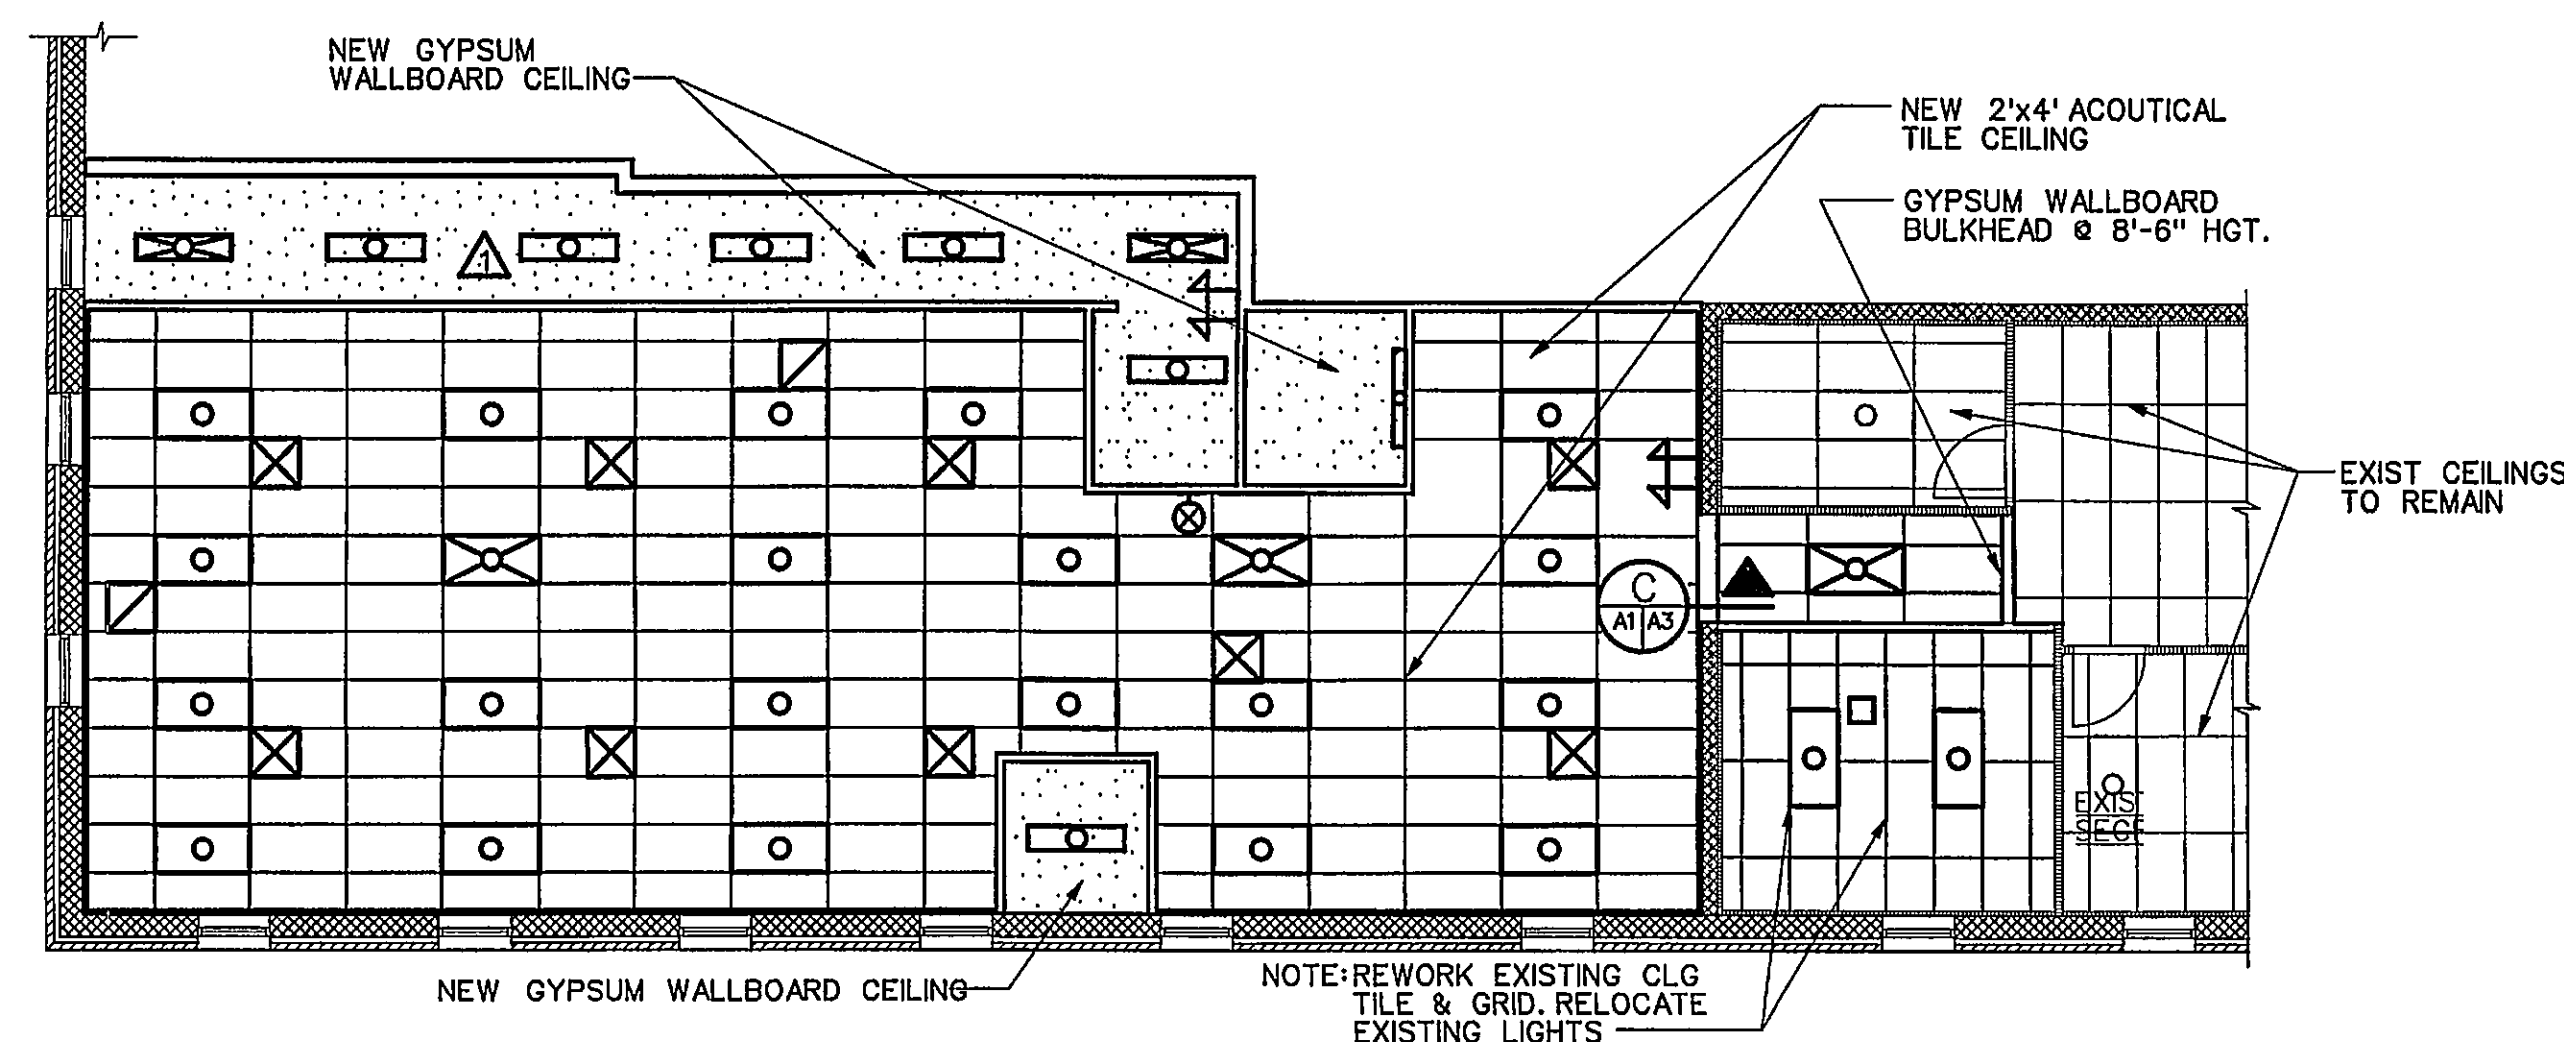


NEW WORK - SECOND FLOOR REFLECTED CEILING PLAN
SCALE: 1/8" = 1'-0"

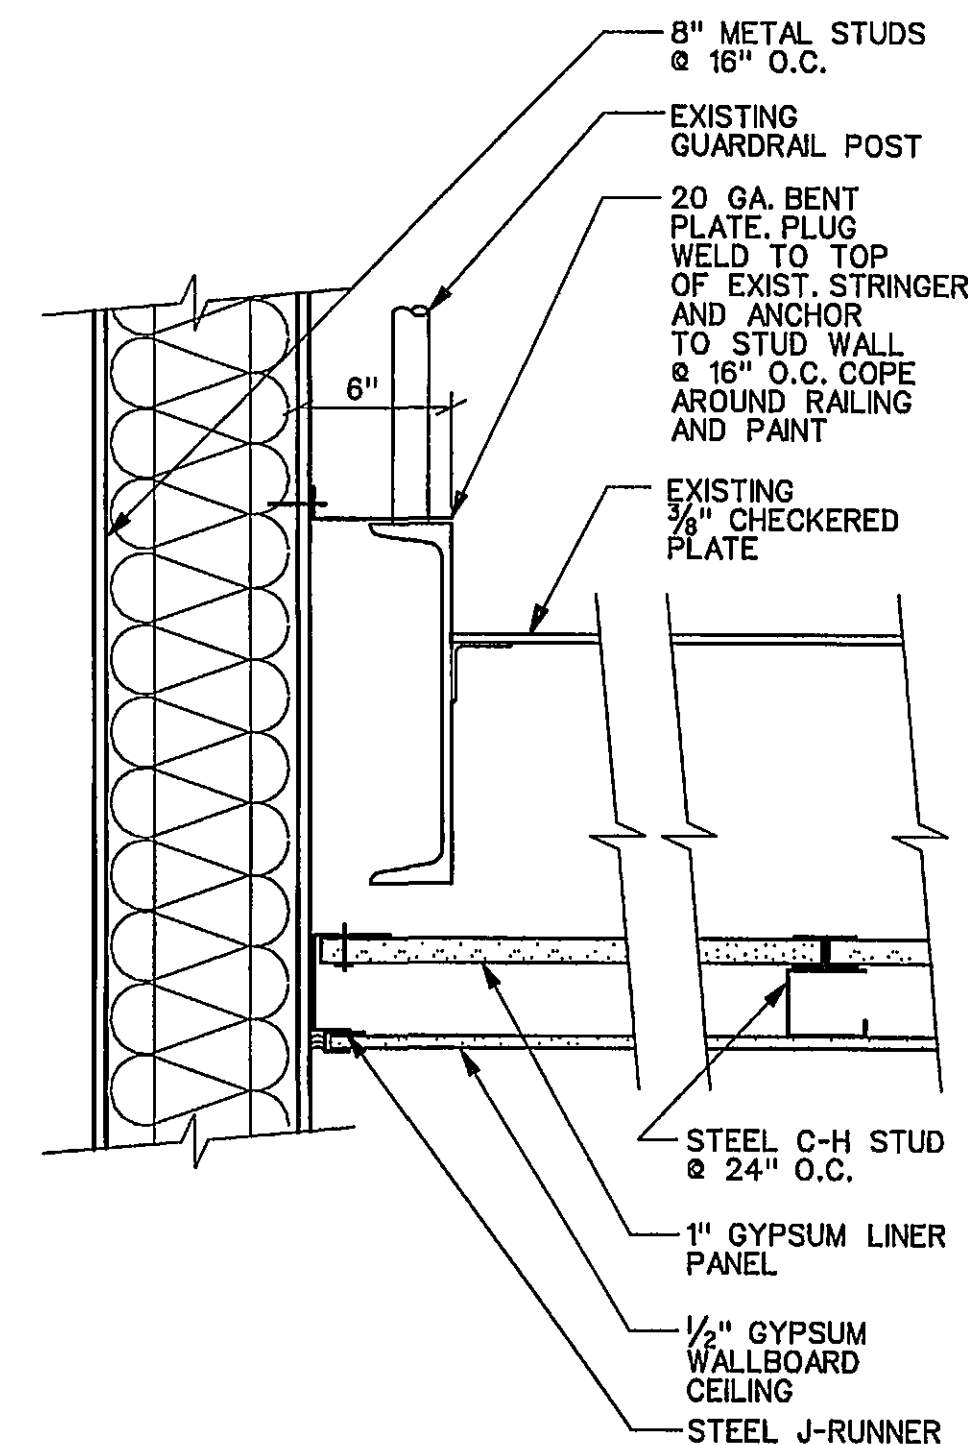


NOTE "A"
STAIR IS RATED FOR 1 HOUR. SEPARATE STAIR FROM SINK CLOSET BELOW BY USING A 1-HOUR HORIZONTAL SHAFT WALL. HORIZONTAL SHAFT WALL SPANS WALL TO WALL AND SLOPES WITH STAIR CREATING A 1-HOUR SEPARATION BETWEEN THE SINK CLOSET AND THE STAIR ENCLOSURE ABOVE.
HORIZONTAL SHAFT WALL SHALL MEET THE REQUIREMENTS OF WHI-495 PSH 0154/0167 AND NATIONAL EVALUATION SERVICE COMMITTEE REPORT NO. NER-258

LEGEND:

- 2'X4' FLUORESCENT LIGHTING FIXTURE
- 2' X 4' FLUORESCENT LIGHTING FIXTURE ON WATCHMAN'S CIRCUIT
- 1'X4' FLUORESCENT LIGHTING FIXTURE
- 6"X4' WALL MOUNTED FLUORESCENT LIGHTING FIXTURE
- H.I.D. LIGHTING FIXTURE
- RETURN DUCT SECTION
- SUPPLY DUCT SECTION

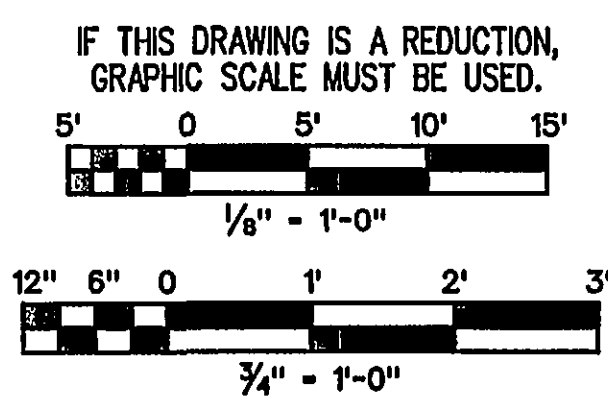

1	07/14/04	JLL	RDD	ADDED UL NUMBERS, INCREASED AREA OF REFUGE AND INCREASED ELEVATOR FOYER
REV.	DATE	BY	APP.	DESCRIPTION

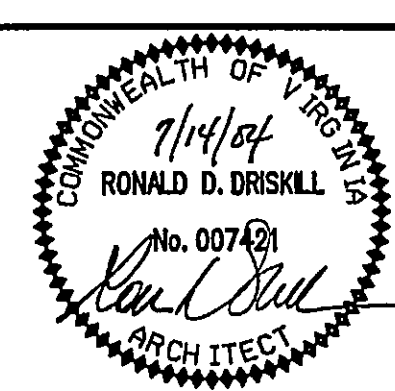

Wiley & Wilson
ARCHITECTS ENGINEERS PLANNERS
An Employee-Owned Company

2310 LANGHORNE ROAD
LYNCHBURG, VIRGINIA 24501
(804) 947-1901

DESIGNED JRM
CHECKED JRM
COMM. NO. 204079.00
GADD NO. 204079A1.DGN
DATE JULY 14, 2004

DRAWN CSE
REVIEWED NST
PROJECT CRYSTAL SPRING WATER TREATMENT PLANT BUILDING MODIFICATION DESIGN CITY OF ROANOKE, VIRGINIA
REFERENCE ARCHITECTURAL
TITLE DEMOLITION / NEW WORK PLANS
DWG. NO. A-1
SHEET NO. 2 OF 10
REV.