


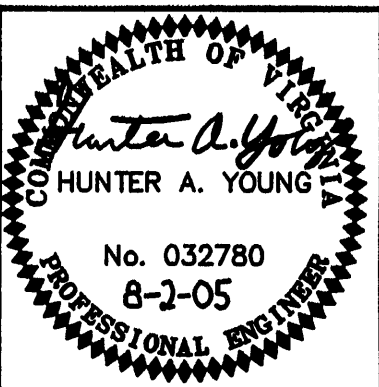

Date	8/2/05
Revisions	1. ADD GRAVITY SEWER BYPASS, ADJUST FENCE, LAGOON BERM INFO & OTHER ITEMS FOR REBID

Issue Date:	APRIL, 2005
Drawn By:	CLZ
Designed By:	HAY
Checked By:	SWH
Date:	

MATERN & CRAIG, INC.
CONSULTING ENGINEERS • SURVEYORS
701 FIRST STREET, S.W.
ROANOKE, VIRGINIA 24016
(940) 945-9342
FAX (940) 345-7891




FINCASTLE WASTEWATER TREATMENT PLANT
UTILITY/FENCE
DEMOLITION PLAN
BOTETOURT COUNTY, VIRGINIA

Vertical Scale:	N/A
Horizontal Scale:	AS SHOWN
Commission Number:	

Sheet No.:

4

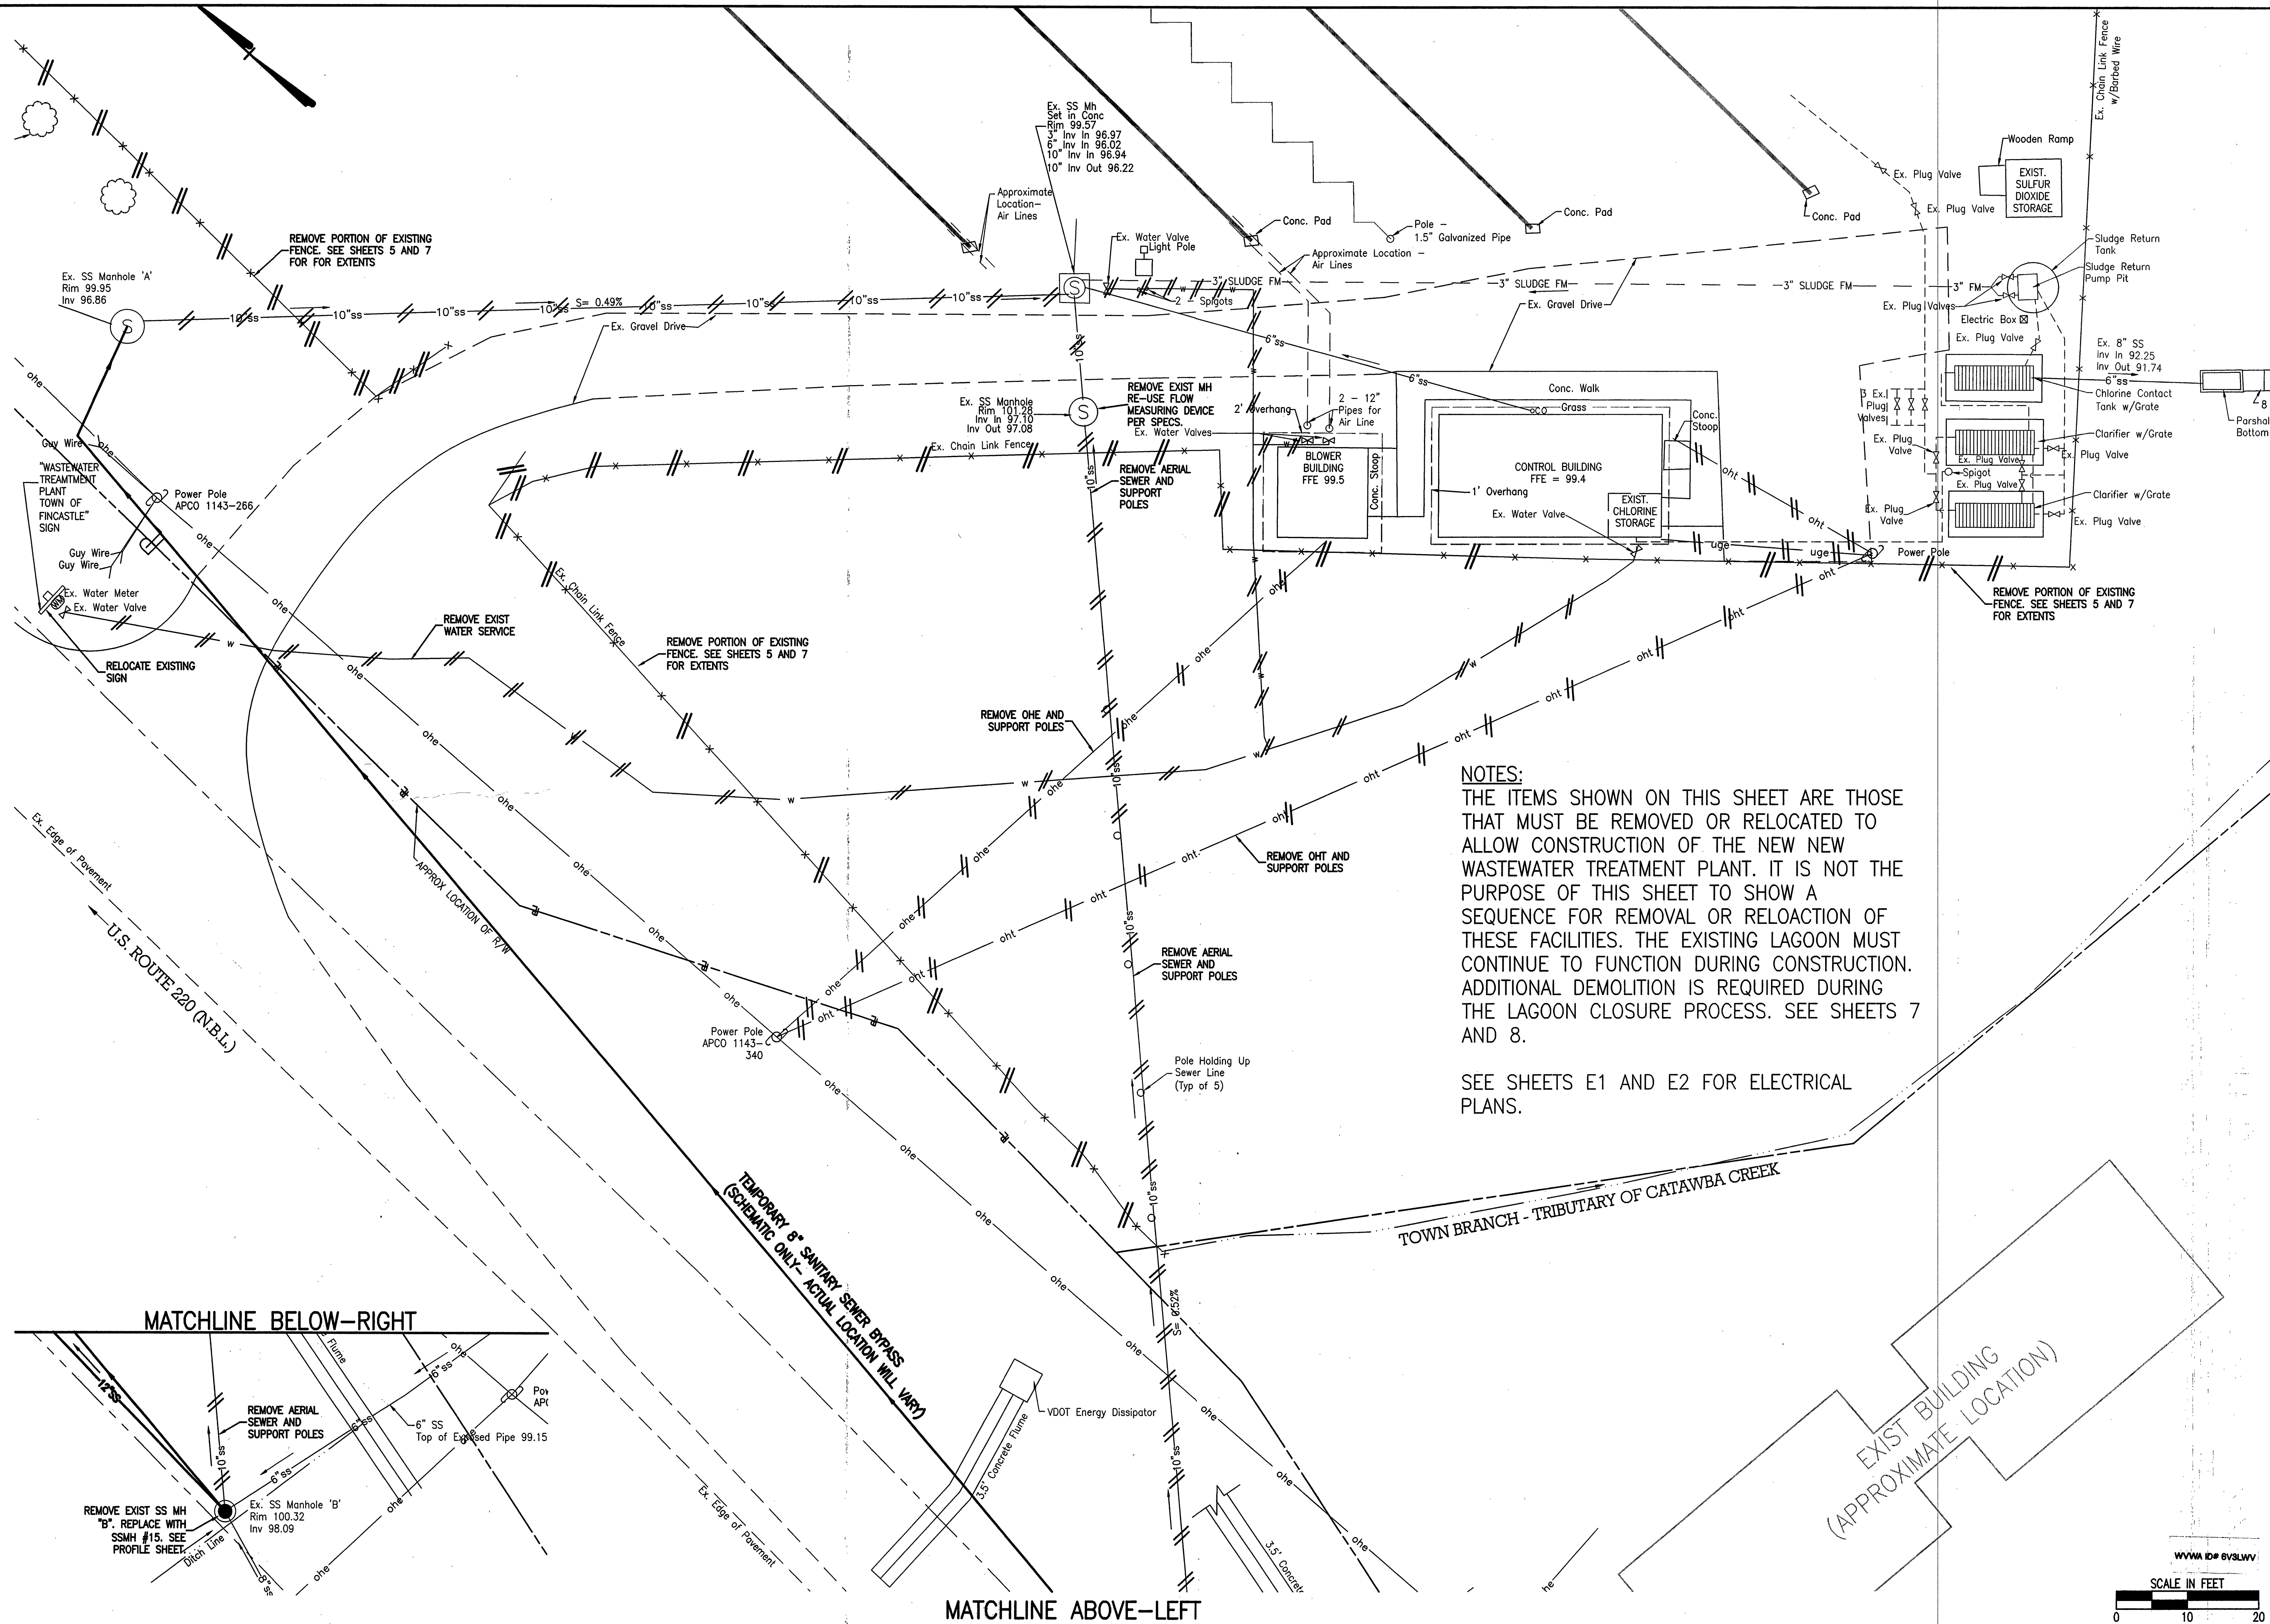

NOTES:
THE ITEMS SHOWN ON THIS SHEET ARE THOSE THAT MUST BE REMOVED OR RELOCATED TO ALLOW CONSTRUCTION OF THE NEW NEW WASTEWATER TREATMENT PLANT. IT IS NOT THE PURPOSE OF THIS SHEET TO SHOW A SEQUENCE FOR REMOVAL OR RELOCATION OF THESE FACILITIES. THE EXISTING LAGOON MUST CONTINUE TO FUNCTION DURING CONSTRUCTION. ADDITIONAL DEMOLITION IS REQUIRED DURING THE LAGOON CLOSURE PROCESS. SEE SHEETS 7 AND 8.

SEE SHEETS E1 AND E2 FOR ELECTRICAL PLANS.

MATCHLINE BELOW-RIGHT

MATCHLINE ABOVE-LEFT

EXIST BUILDING
(APPROXIMATE LOCATION)

