


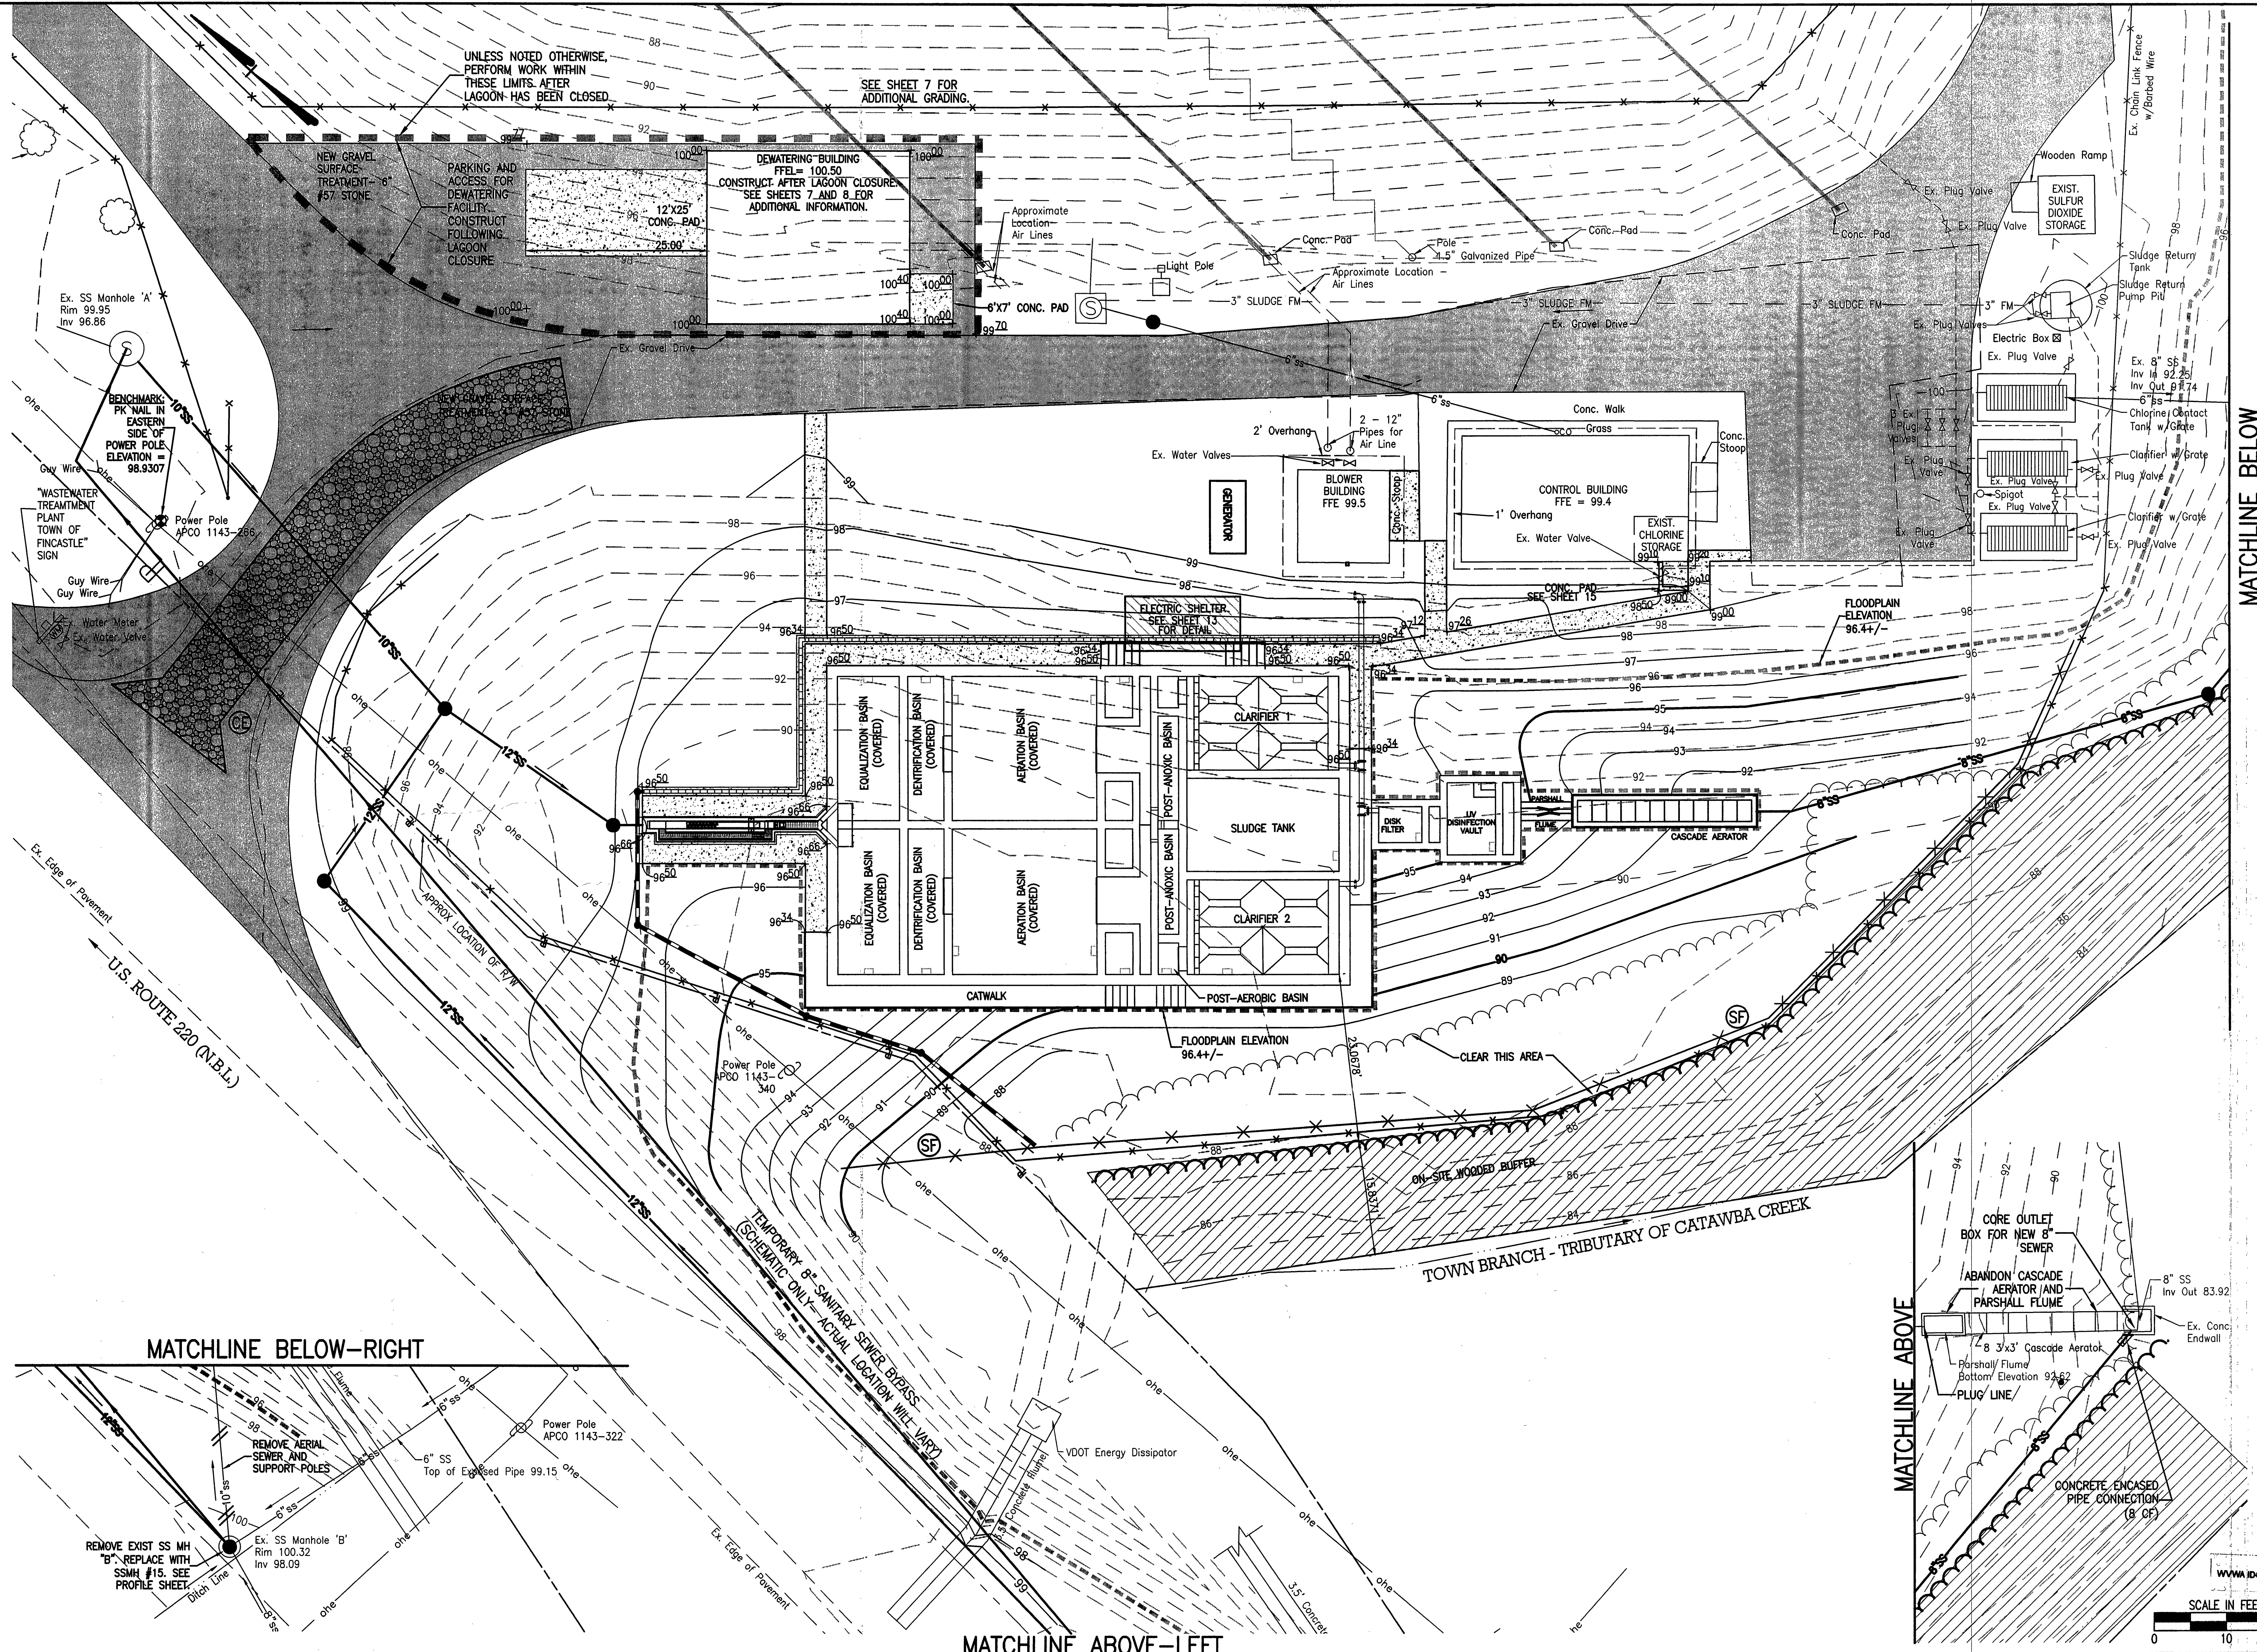

Professional Engineer
No. 032780
8-2-05
HUNTER A. YOUNG

Revisions	Date
1	8/2/05
ADD GRAVITY SEWER BYPASS, ADJUST FENCE, LAGOON BERM INFO & OTHER ITEMS FOR REBID	

Issue Date:	APRIL, 2005
Drawn By:	CLZ
Designed By:	HAY
Checked By:	SWH
Date:	

MATTIERN & CRAIG, INC.
CONSULTING ENGINEERS • SURVEYORS
701 FIRST STREET, S.W.
ROANOKE, VIRGINIA 24016
(540) 345-9342
FAX (540) 345-7691

FINCASTLE WASTEWATER TREATMENT PLANT
GRADING PLAN
BOTETOURT COUNTY, VIRGINIA

Vertical Scale:	N/A
Horizontal Scale:	AS SHOWN
Commission Number:	
Sheet No.:	6