

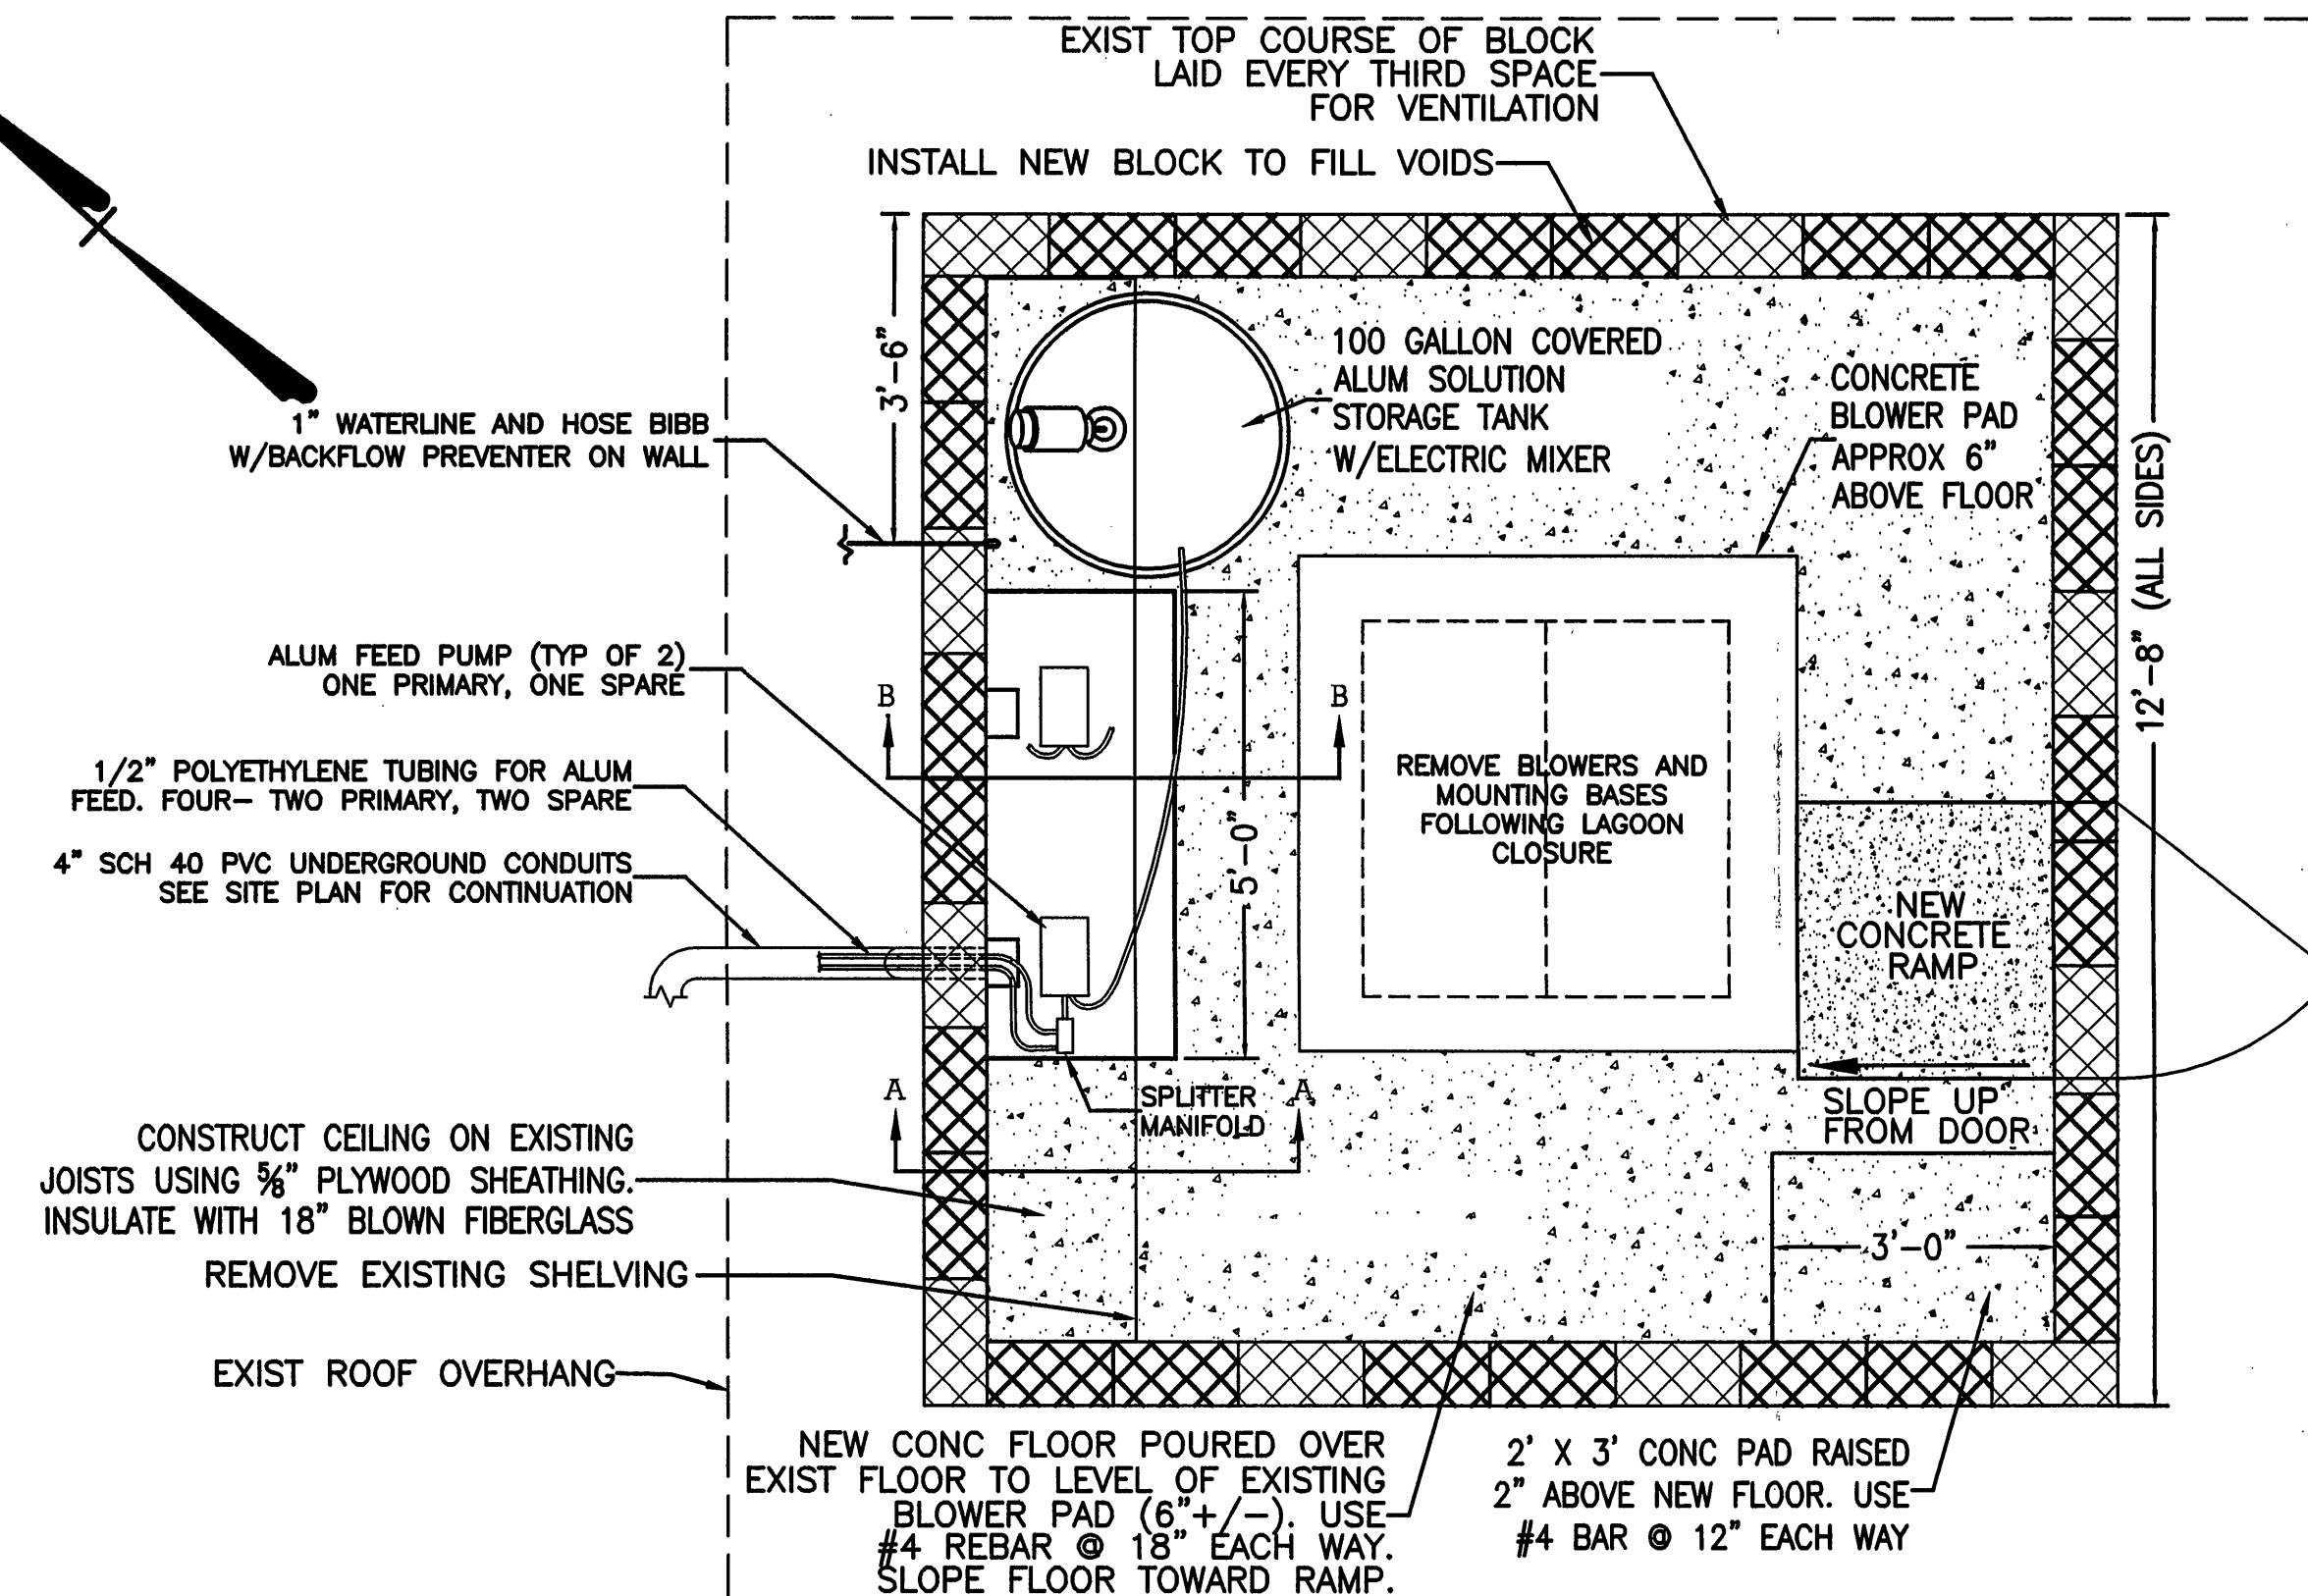
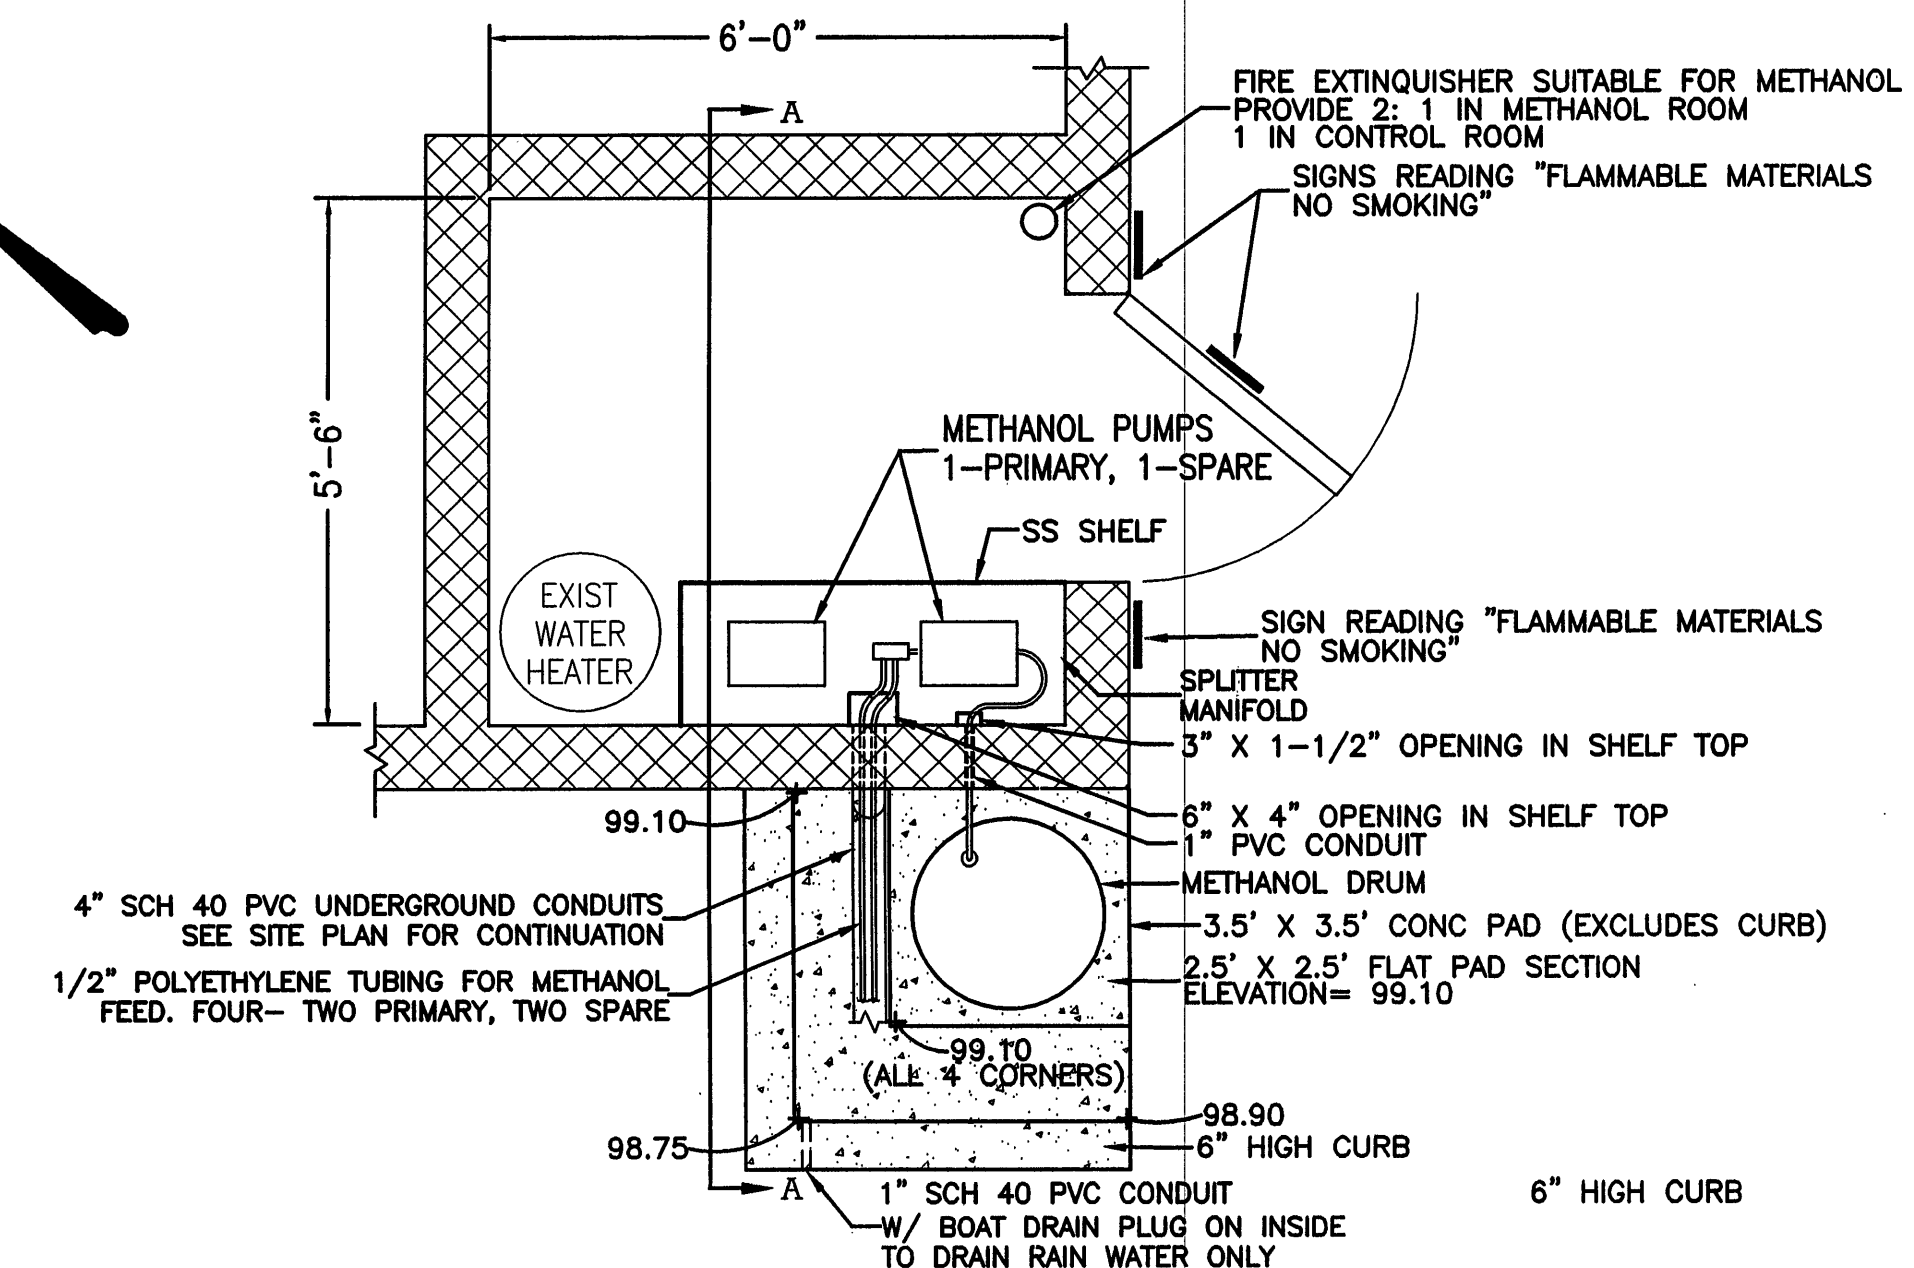


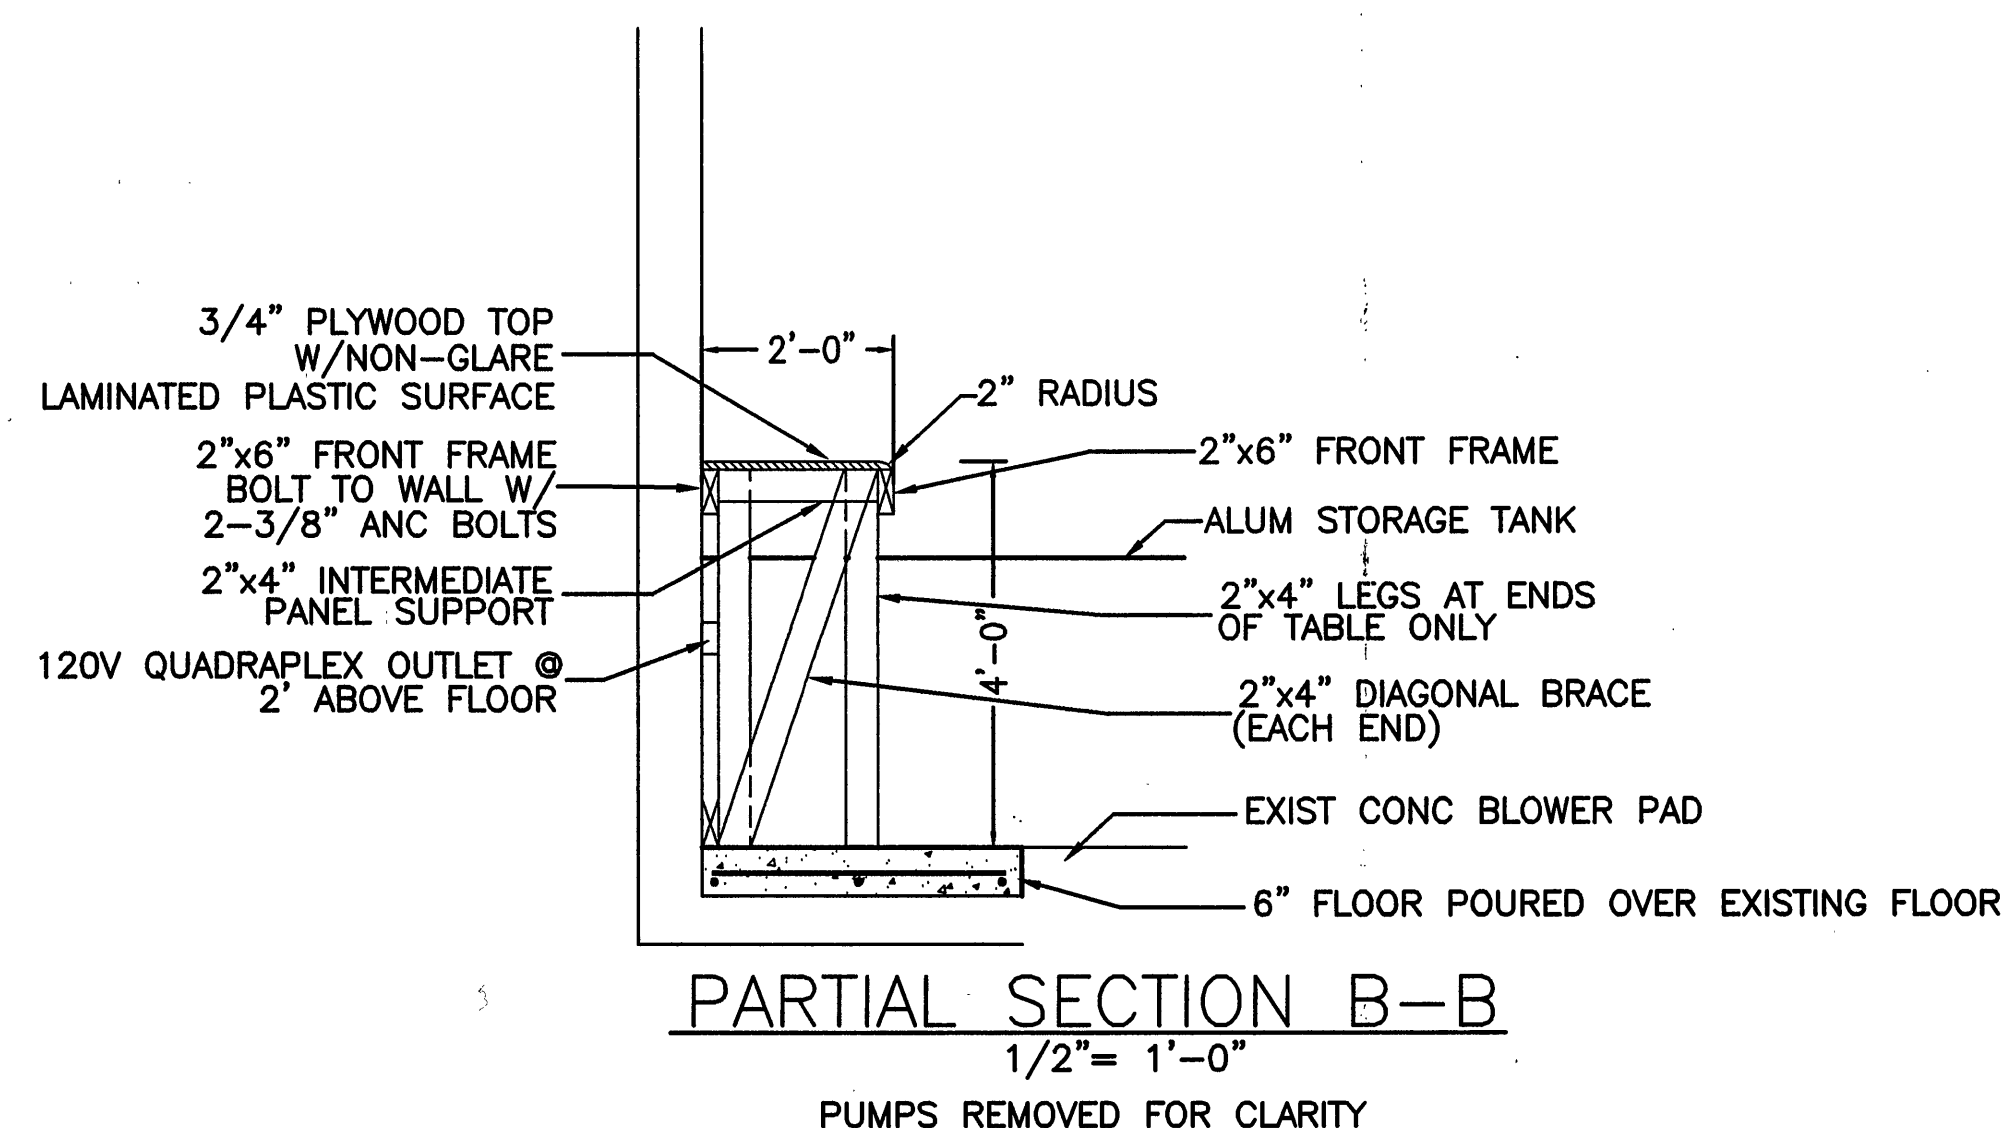


NOTES:
1. SEE ELECTRICAL/MECHANICAL PLANS FOR ADDITIONAL WORK.

EXISTING BLOWER BUILDING
RETROFIT PLAN
1/2" = 1'-0"

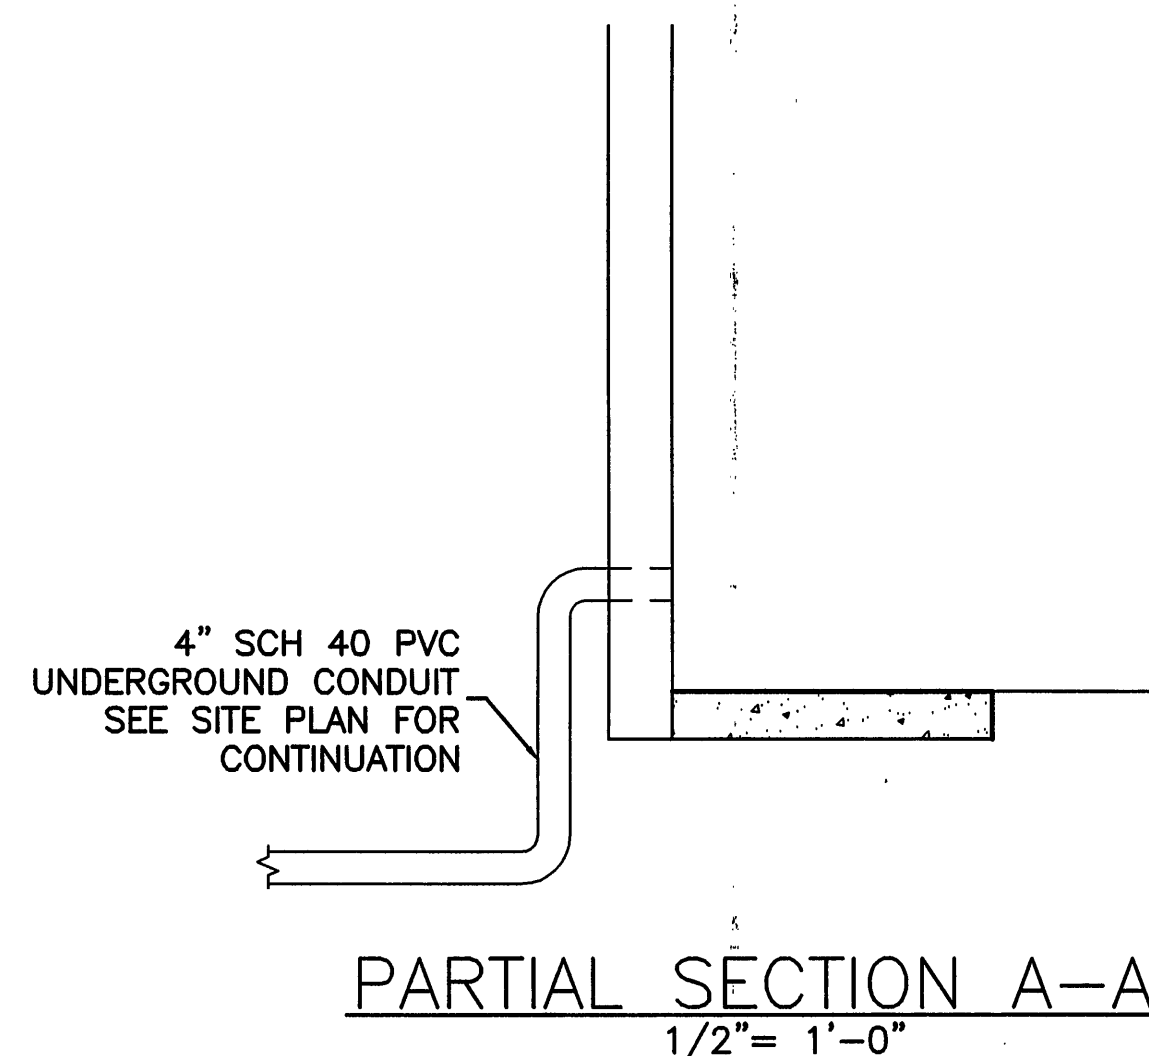


NOTES:
1. REMOVE EXISTING CHLORINATION EQUIPMENT AFTER LAGOON LAGOON CLOSURE.
2. SEE ELECTRICAL/MECHANICAL PLANS FOR ADDITIONAL WORK.
3. THE PURPOSE OF THE CURB AROUND THE PAD IS TO CONTAIN ACCIDENTAL METHANOL SPILLS. THE 1" DRAIN IS TO DRAIN RAIN WATER ONLY. THE FLAT PAD SECTION PROVIDES A STABLE PLATFORM FOR THE DRUM AND THE REMAINDER OF THE PAD IS SLOPED TO THE 1" DRAIN.

EXISTING CHLORINE ROOM IN CONTROL BUILDING
RETROFIT PLAN FOR METHANOL ROOM
1/2" = 1'-0"

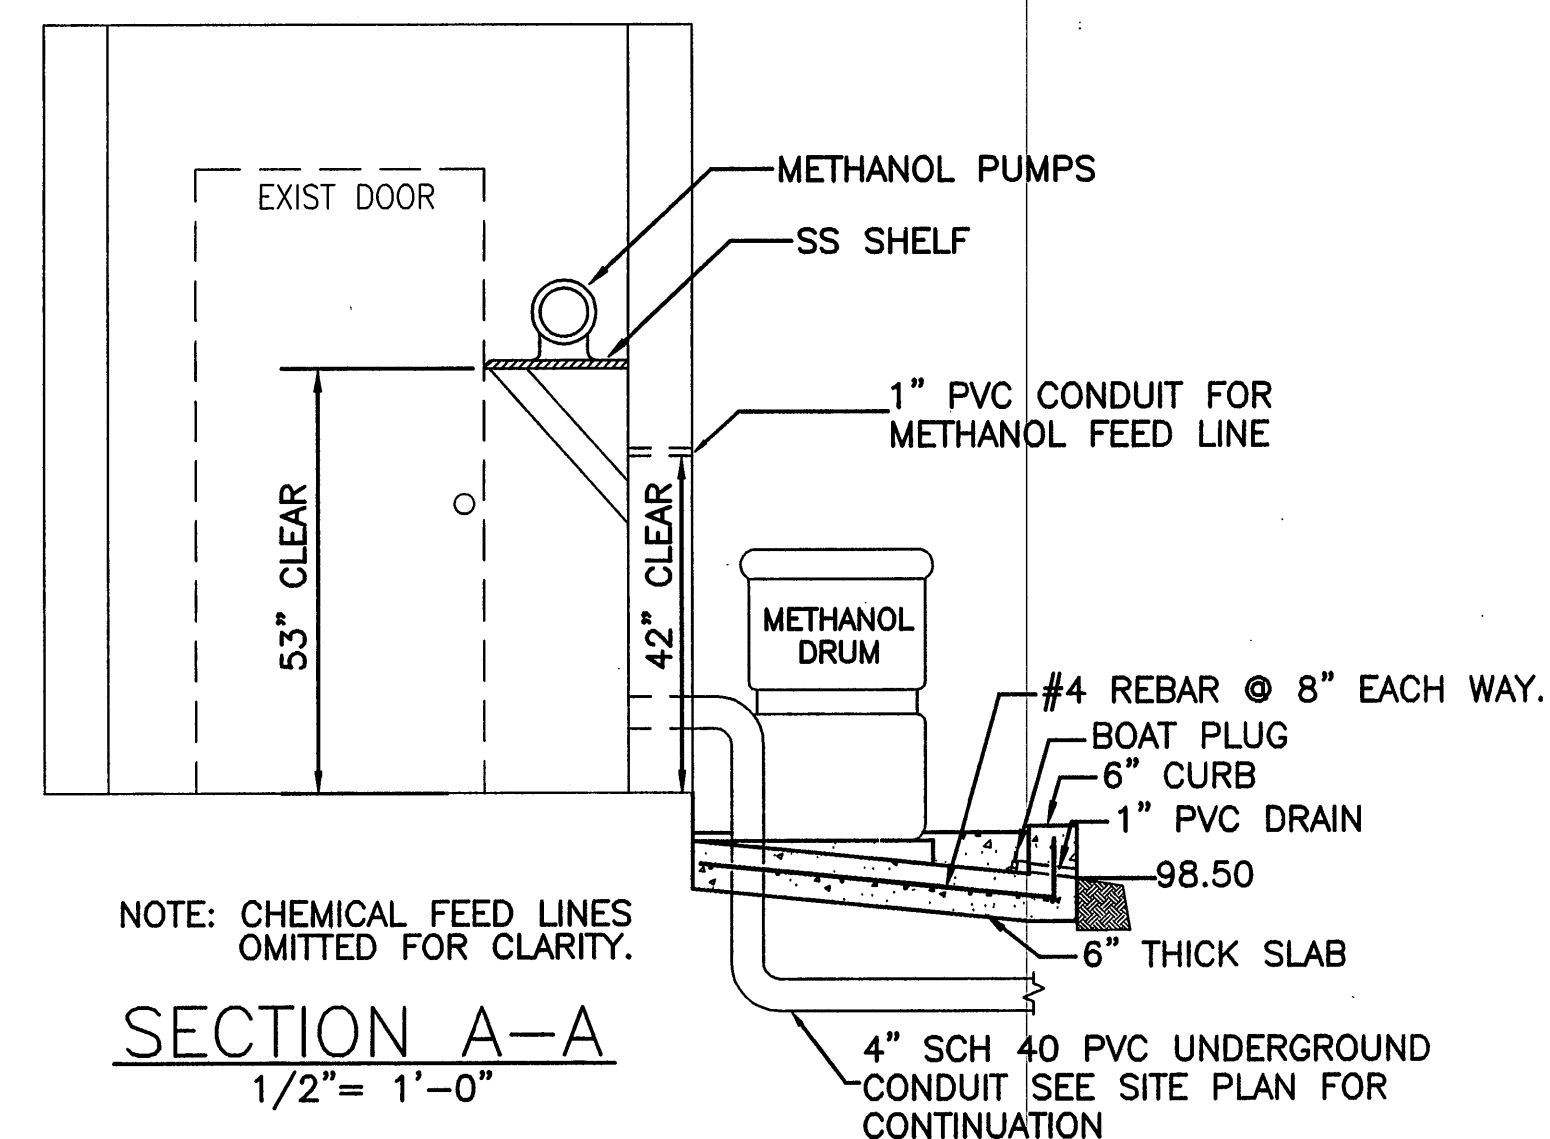

NOTE: CHEMICAL FEED LINES OMITTED FOR CLARITY.

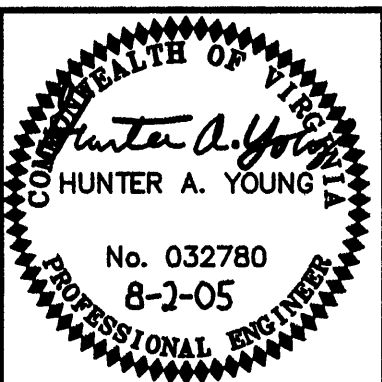

Revisions	Date
1. ADD GRAVITY SEWER BYPASS, ADJUST FENCE, LAGOON BERM INFO & OTHER ITEMS FOR REBID	8/2/05

Issue Date:	APRIL, 2005
Drawn By:	CLZ
Designed By:	HAY
Checked By:	SWH
Date:	

MATTEN & CRAIG, INC.
CONSULTING ENGINEERS • SURVEYORS
701 FIRST STREET, S.W.
ROANOKE, VIRGINIA 24016
(800) 346-5342
FAX (540) 346-7851

FINCASLE WASTEWATER TREATMENT PLANT
BLOWER AND CONTROL BUILDINGS RETROFIT PLANS
BOTETOURT COUNTY, VIRGINIA

Vertical Scale:	N/A
Horizontal Scale:	1/2" = 1'
Commission Number:	
Sheet No.:	