



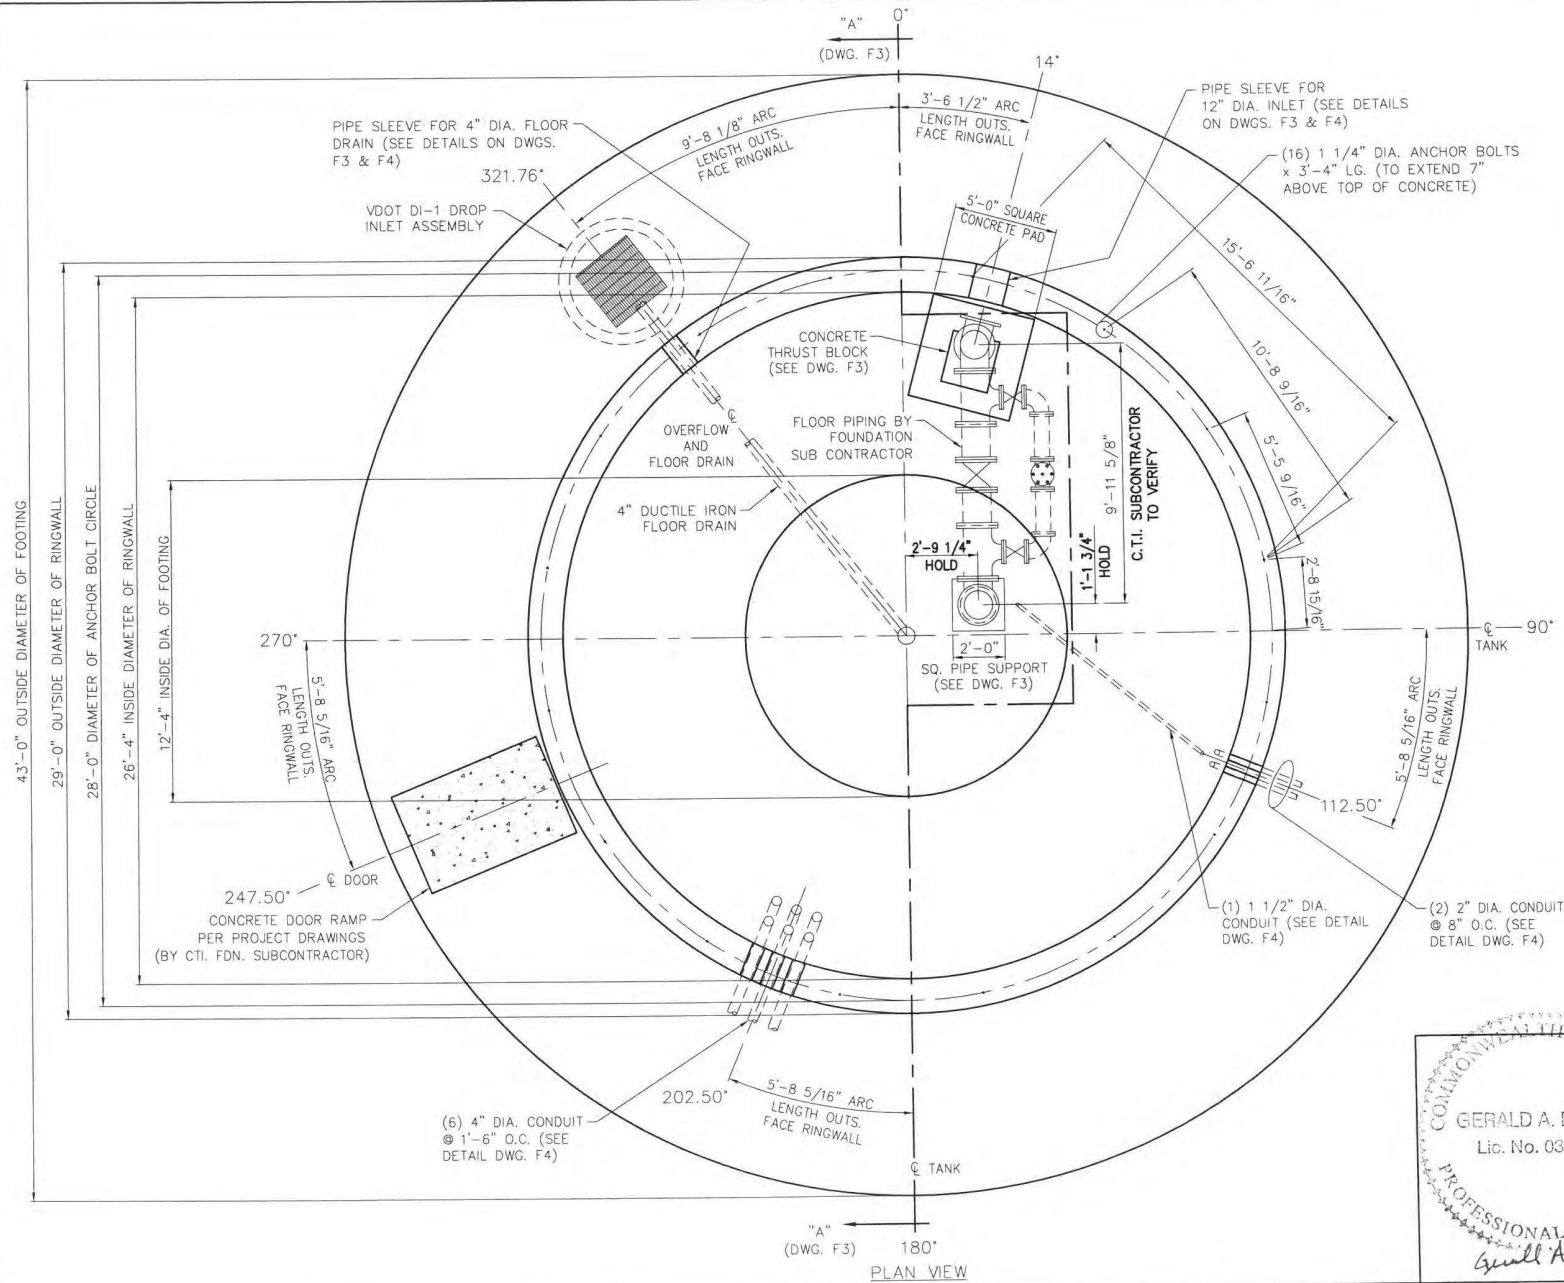

AS-BUILT

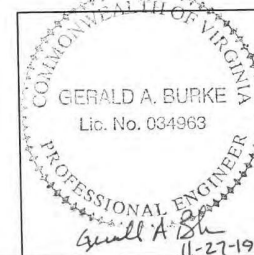

REV.	BY:	DATE	REMARKS
CALDWELL Since 1887 Water • Energy • Industrial			
FRANKLIN COUNTY, VIRGINIA 500,000 GALLON PEDESHERE			
BY: TSY/LAB	TITLE: RING FOUNDATION PLAN VIEW		
DATE: 11/15/19	DRAWING NO.: E-8884 F2 OF 4		