




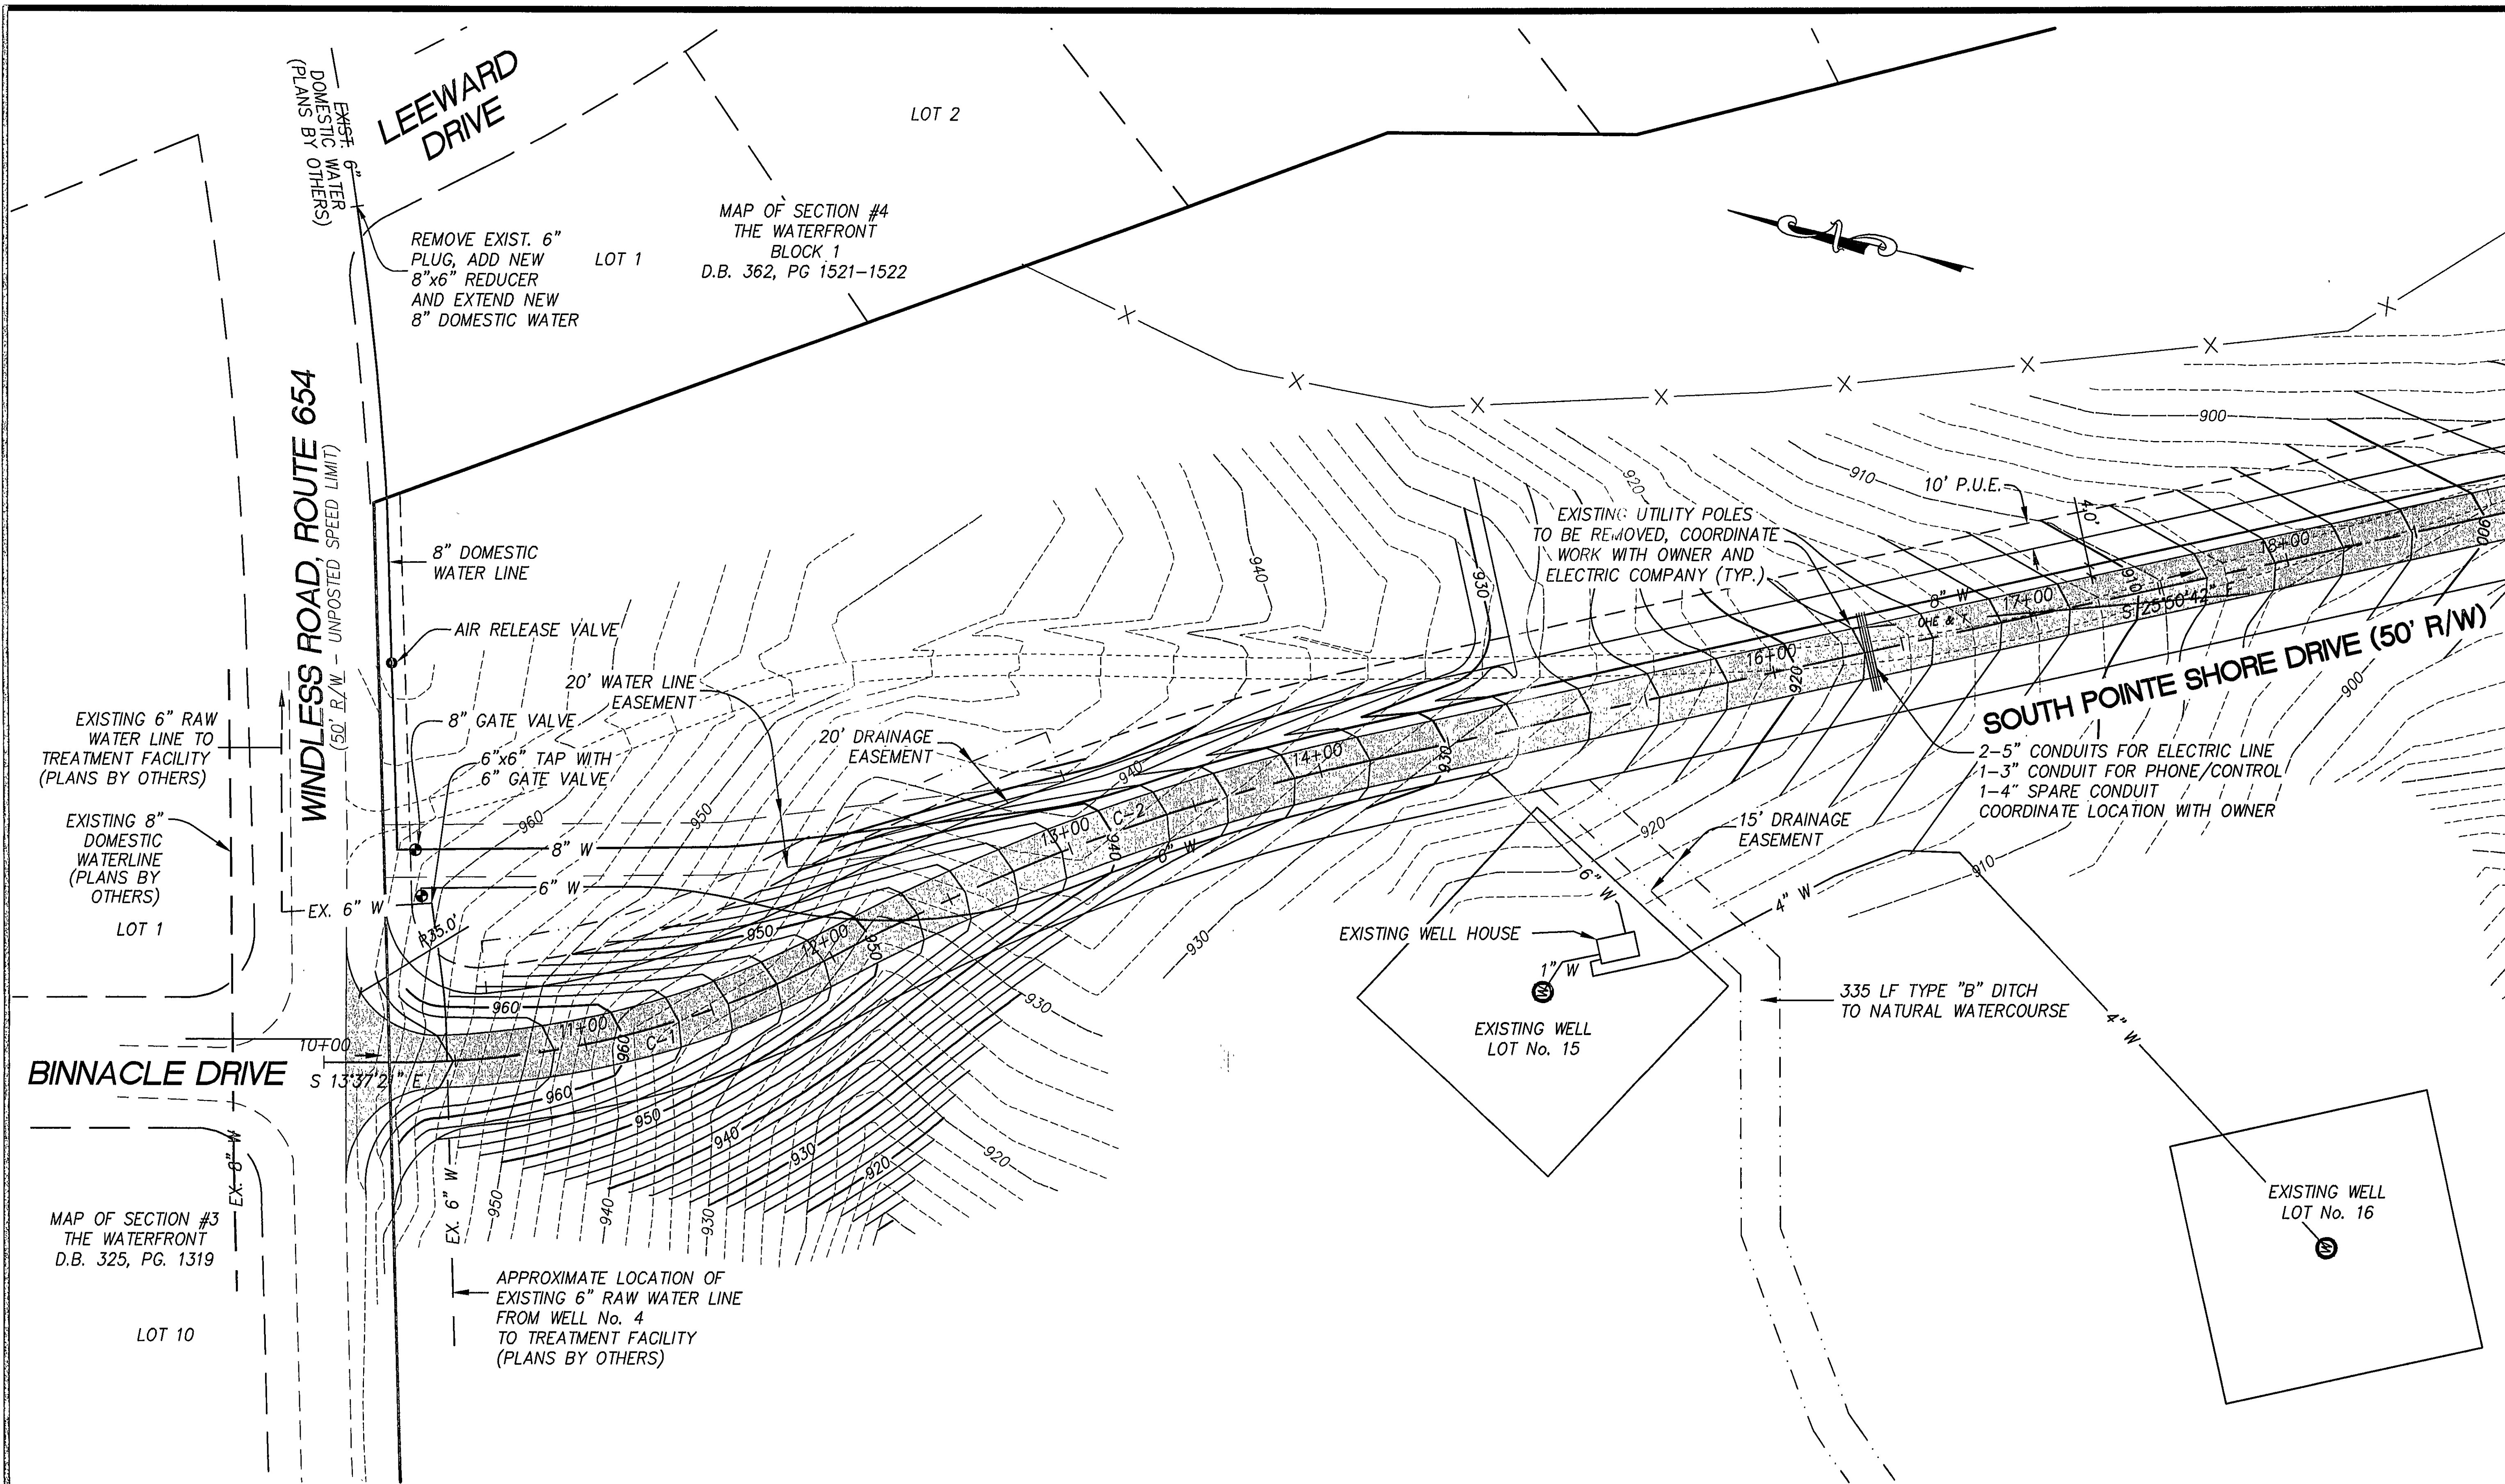

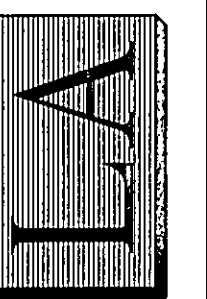

LUMSDEN ASSOCIATES, P.C.
ENGINEERS-SURVEYORS-PLANNERS
ROANOKE, VIRGINIA

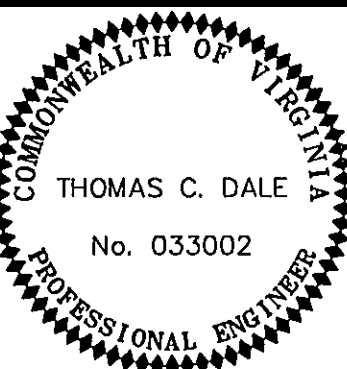

THOMAS C. DALE
No. 033002
PROFESSIONAL ENGINEER

SITE PLAN

**EXPANSION OF WATER SYSTEM
WATERFRONT-WELLS #15 & #16**
PREPARED FOR
WATERFRONT WATERWORKS, INC
GILLS CREEK MAGISTERIAL DISTRICT
FRANKLIN COUNTY, VIRGINIA

NO.	DATE	REVISIONS DESCRIPTION
1		
2		
3		
4		
5		

DATE: **APRIL 16, 2007**

SCALE: **1" = 30'**

COMMISSION NO: **2002-308**

24320 FILE
F:\2002\023308\ENG\02308COMP.DWG

SHEET 2 OF 3