




**ACS** PUMP STATION GENERATOR BASE  
DESIGN WWW.ACSDESIGNLLC.COM ■ ENGINEERING ■ SURVEYING ■ LANDSCAPE ARCHITECTURE ■ CONSTRUCTION MANAGEMENT

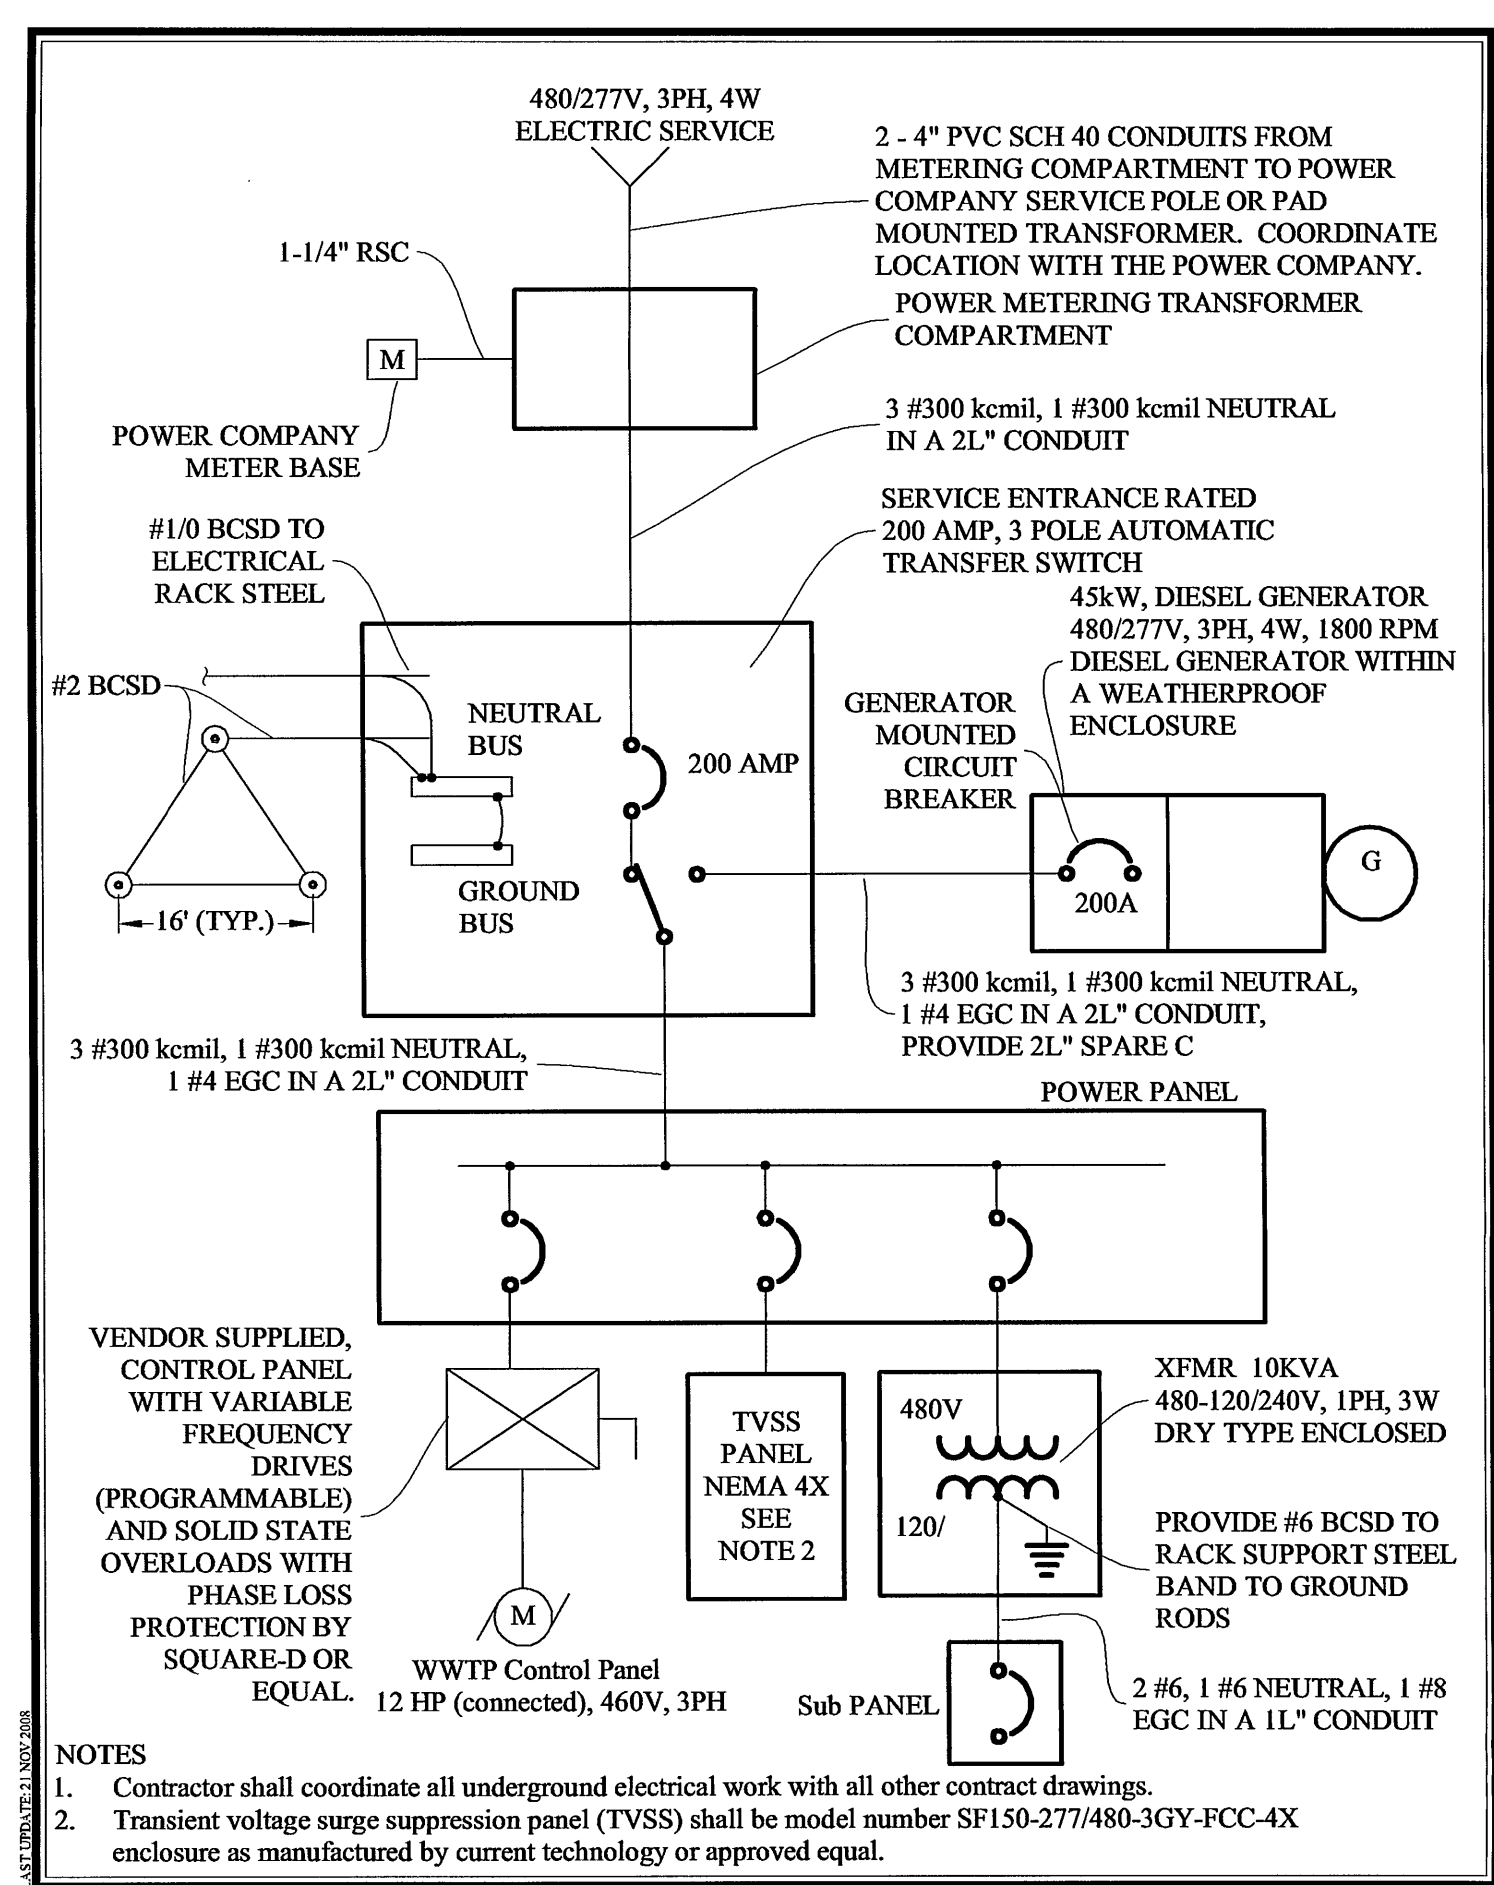


**ACS** ELECTRICAL SERVICE - ONE LINE DIAGRAM  
DESIGN WWW.ACSDESIGNLLC.COM ■ ENGINEERING ■ SURVEYING ■ LANDSCAPE ARCHITECTURE ■ CONSTRUCTION MANAGEMENT

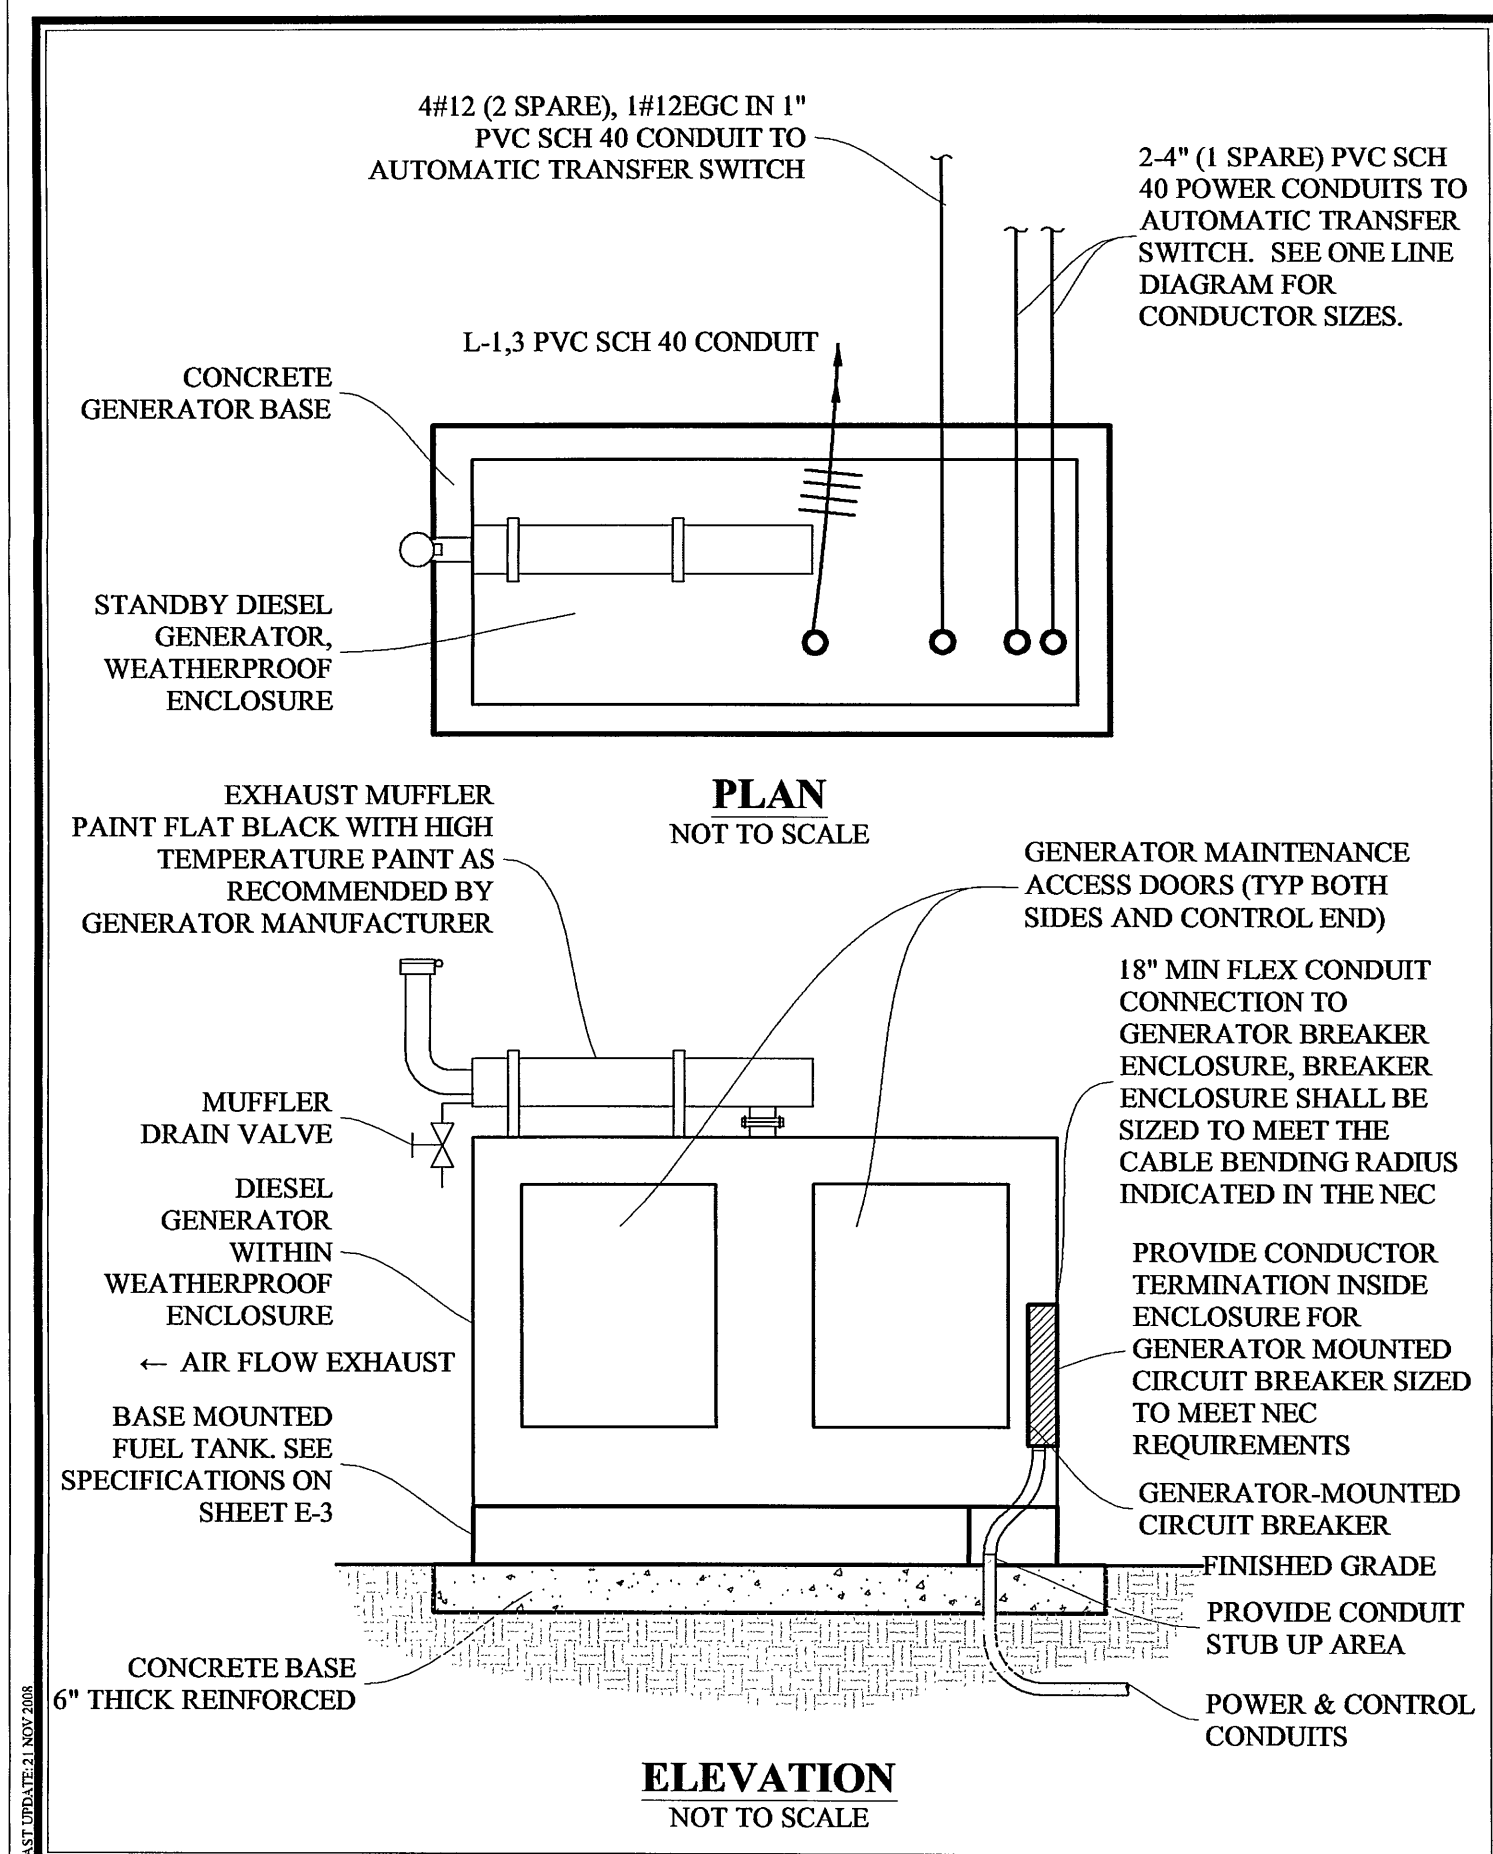


**ACS** PUMP STATION GENERATOR  
DESIGN WWW.ACSDESIGNLLC.COM ■ ENGINEERING ■ SURVEYING ■ LANDSCAPE ARCHITECTURE ■ CONSTRUCTION MANAGEMENT

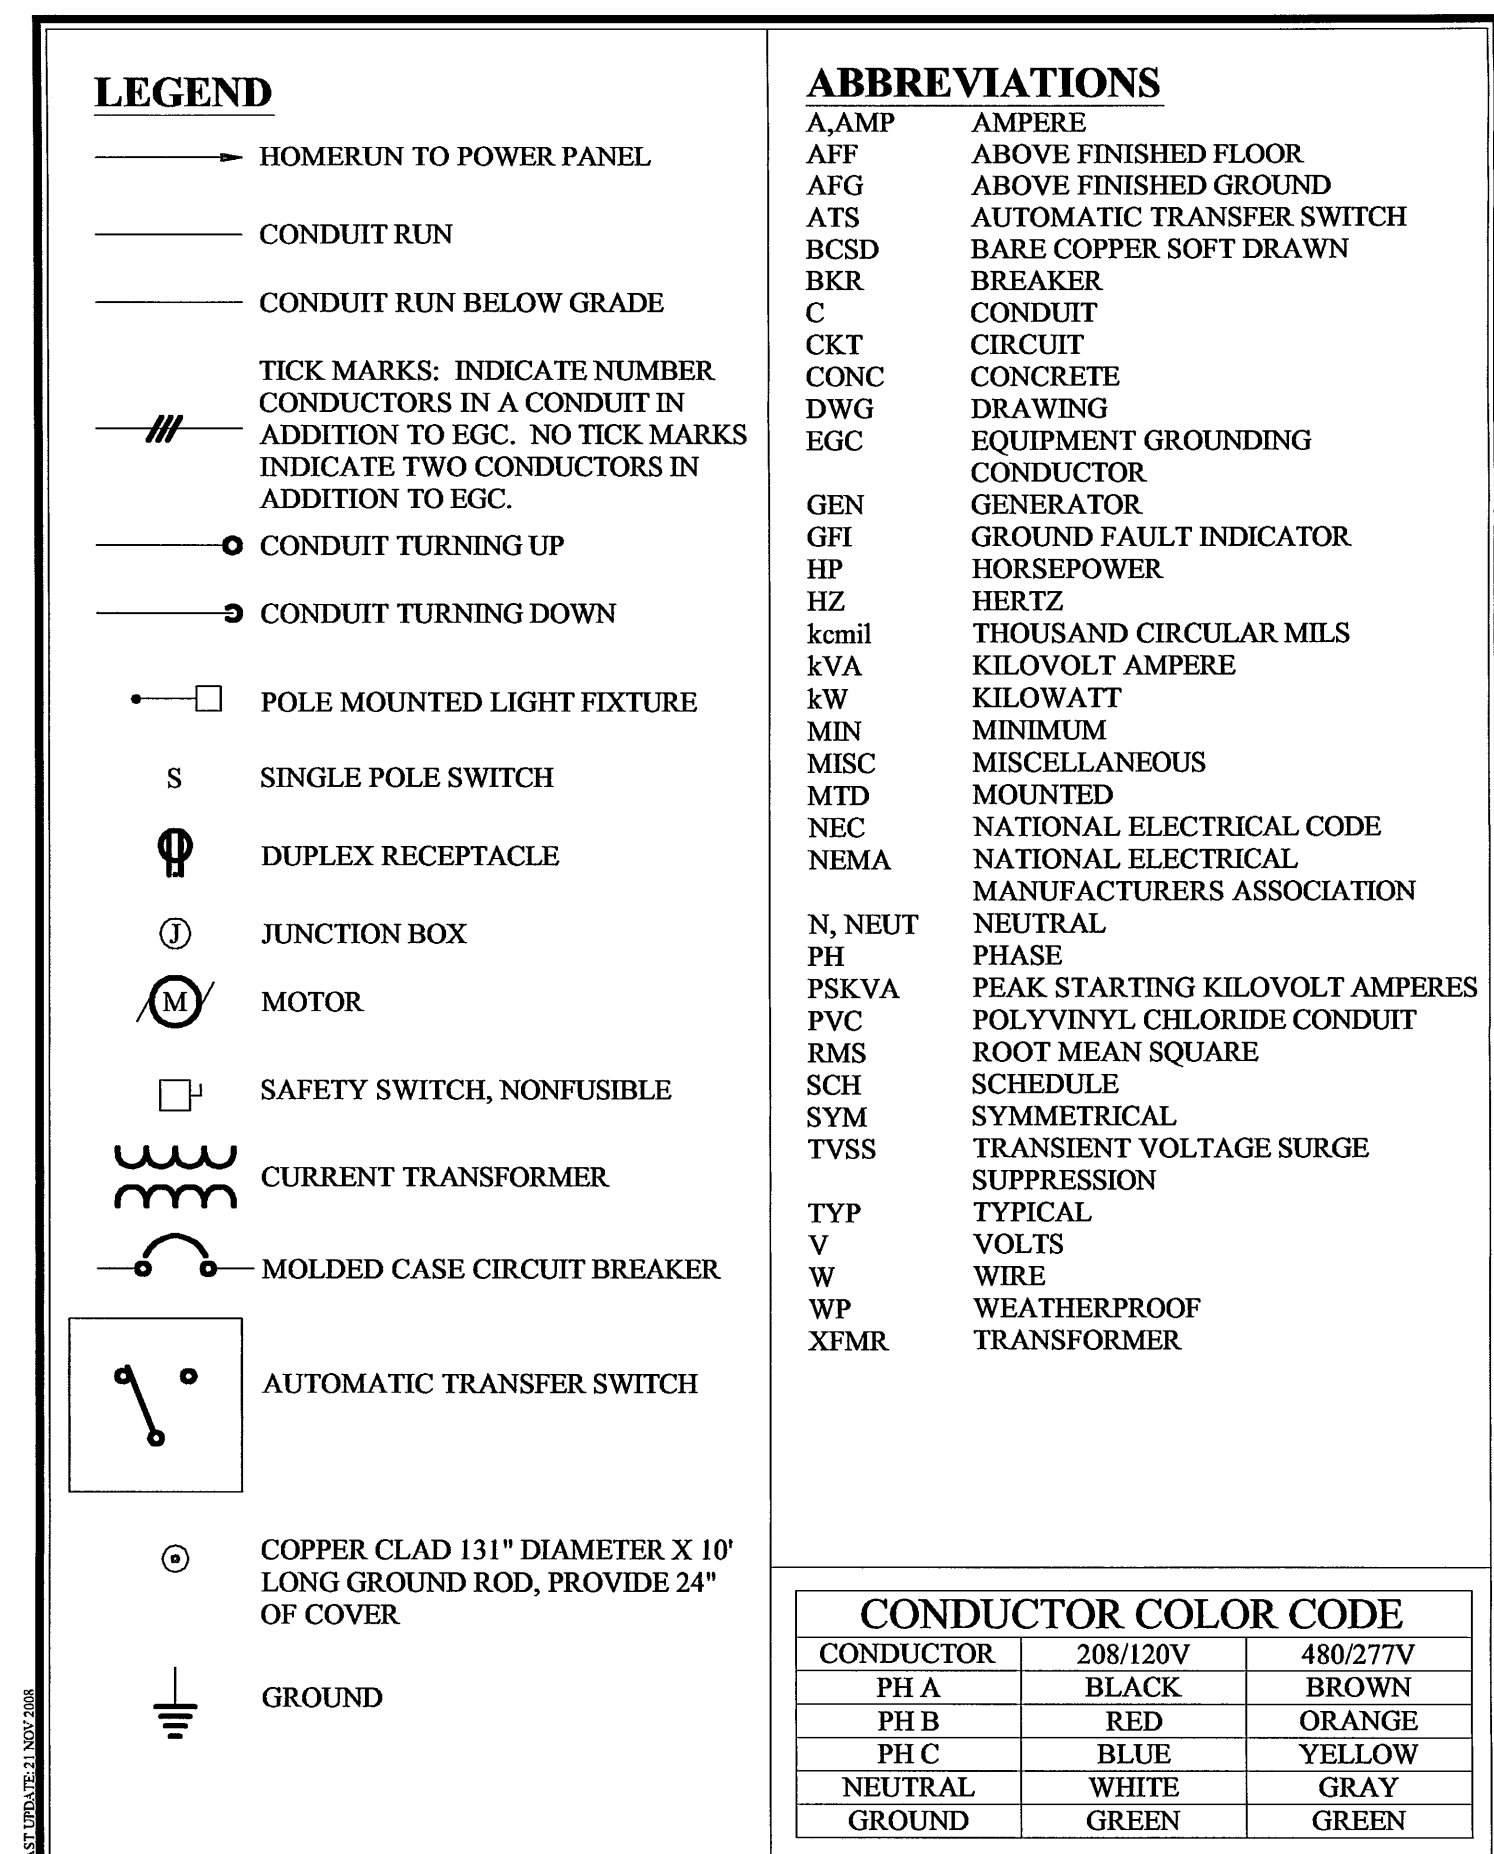


**ACS** ELECTRICAL DIAGRAM LEGEND AND ABBREVIATIONS  
DESIGN WWW.ACSDESIGNLLC.COM ■ ENGINEERING ■ SURVEYING ■ LANDSCAPE ARCHITECTURE ■ CONSTRUCTION MANAGEMENT

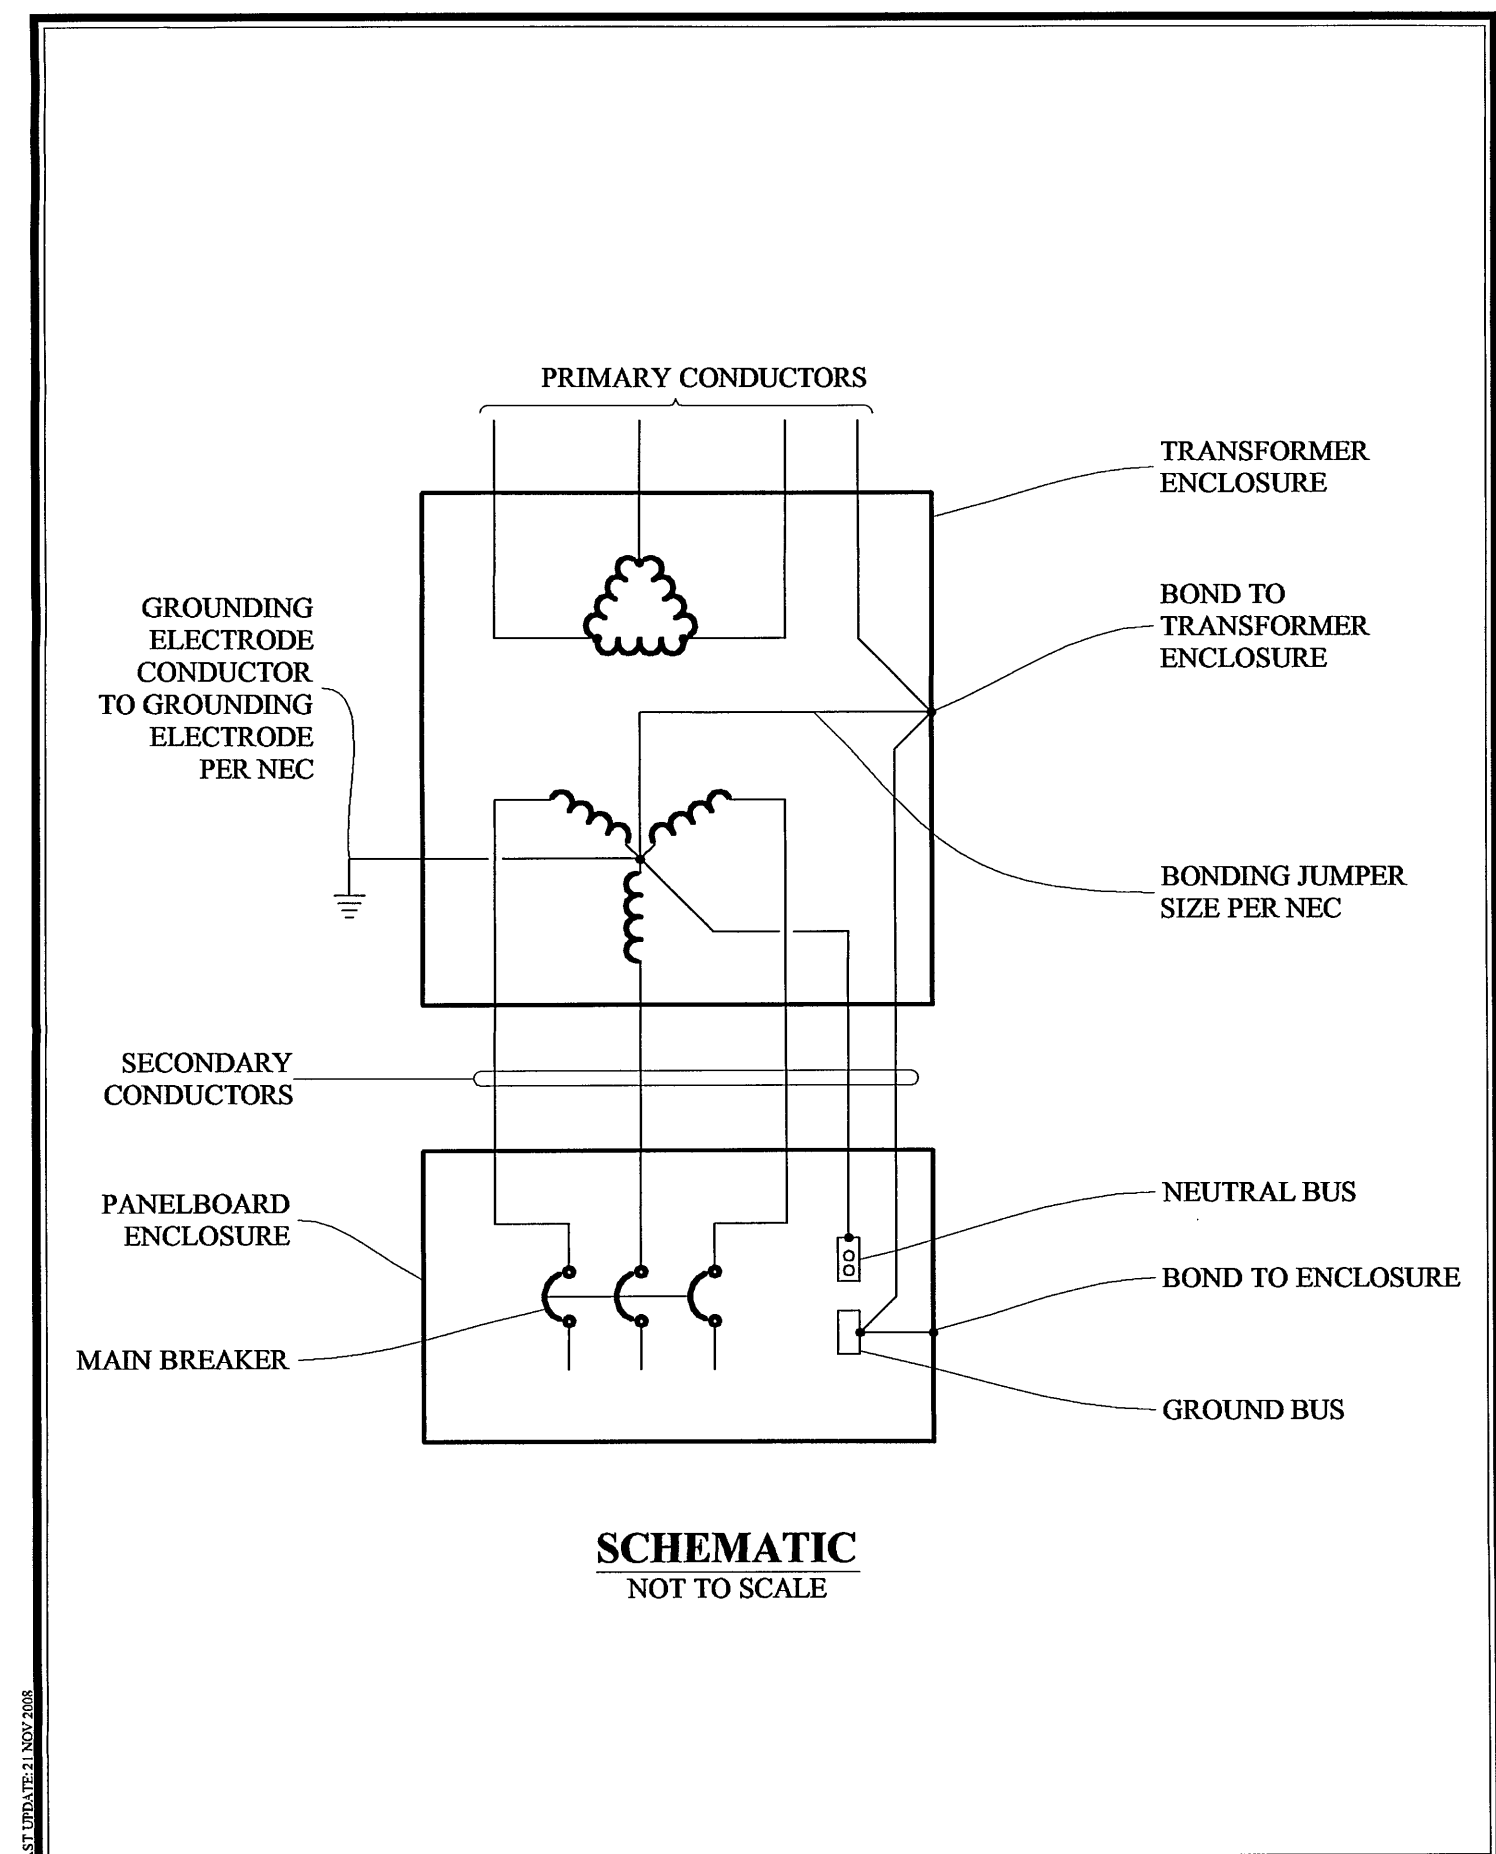

**ACS** DRY TYPE TRANSFORMER WIRING DIAGRAM  
DESIGN WWW.ACSDESIGNLLC.COM ■ ENGINEERING ■ SURVEYING ■ LANDSCAPE ARCHITECTURE ■ CONSTRUCTION MANAGEMENT

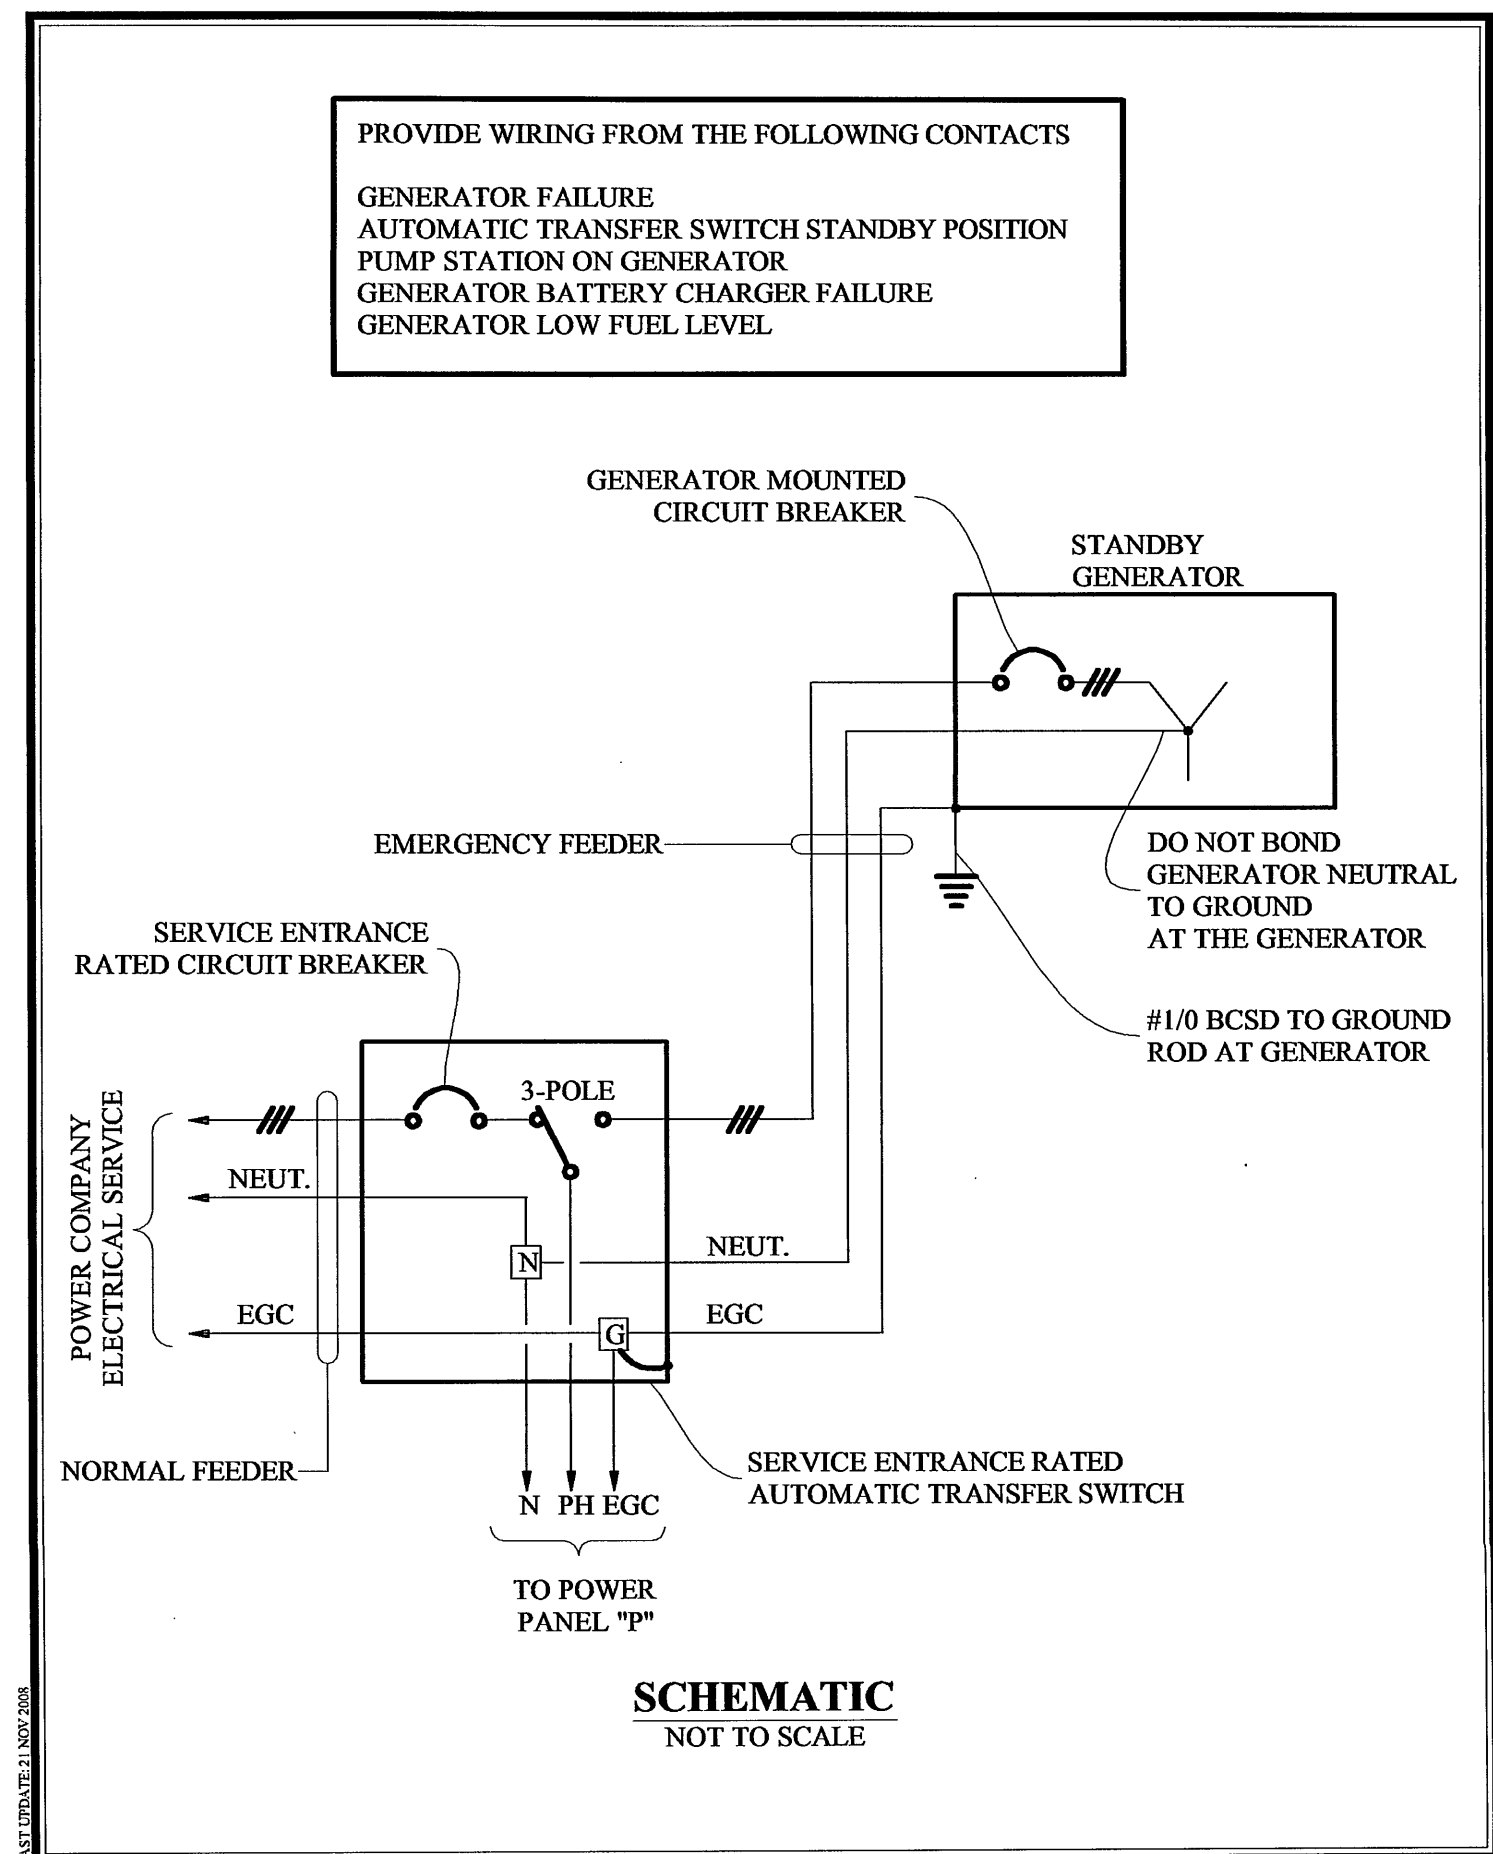

**ACS** CONNECTION DIAGRAM - NEUTRAL & GROUND CONDUCTORS  
DESIGN WWW.ACSDESIGNLLC.COM ■ ENGINEERING ■ SURVEYING ■ LANDSCAPE ARCHITECTURE ■ CONSTRUCTION MANAGEMENT

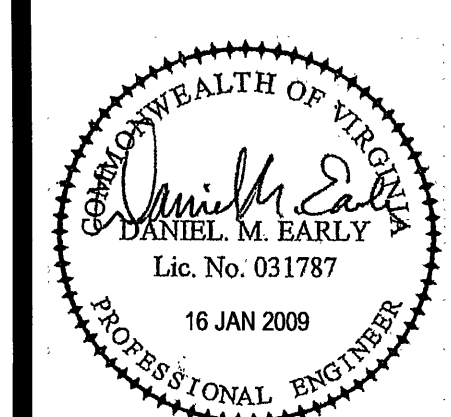

**ACS  
DESIGN**

ENGINEERING • SURVEYING  
LANDSCAPE ARCHITECTURE  
CONSTRUCTION MANAGEMENT

2203 PETERS CREEK ROAD  
ROANOKE, VIRGINIA 24017  
P 540.562.2345 F 562.2344  
INFO@ACSDESIGNLLC.COM  
WWW.ACSDESIGNLLC.COM

**WIRTZ SERVICES, LLC**  
**WIRTZ CENTRAL SEWER SYSTEM**  
**FRANKLIN COUNTY, VIRGINIA**

© ACS DESIGN, LLC - Material included herein  
is covered by copyright. Use of this work in whole  
or in part is strictly forbidden without the  
expressed written consent of ACS DESIGN, LLC.

DRAWN BY: JUD.WTW  
DESIGNED BY: DME  
CHECKED BY: DES  
DATE: 16 JAN 2009  
JOB NUMBER: 05353A

REVISIONS:

No. 1	
No. 2	
No. 3	
No. 4	
No. 5	

SHEET NO.:  
**C6.4**

PUMP STATION  
ELEC. DIAGRAMS  
AND DETAILS