

RECEIVED
MAR 19 1999

HIGHWAY 220
1423 SUMMIT LANE
ROANOKE, VIRGINIA 24011
RO-1-429-A
EXISTING WATER TANK

Betzwood
Associates® PC
— ARCHITECTS & ENGINEERS —
Robin J. Kohn, AIA Regis W. Kubie, PE
301 Gay Street
Phoenixville PA 19460
Tel (610) 917-8831 Fax 917-8836

SEAL BLOCK

I CERTIFY THAT THESE DOCUMENTS HAVE BEEN PREPARED OR
APPROVED BY ME AND THAT I AM A DULY INCORPORATED ARCHITECT
UNDER THE LAWS OF THE COMMUNIST PARTY OF THE UNITED STATES OF AMERICA

COMMUNIST PARTY OF THE UNITED STATES OF AMERICA

ROBIN J. KOHN

No. 010566

R. Kohn
ARCHITECT


ROBIN J. KOHN AIA - VA. 010566 12.31.90

TRITON PCS
Incorporated

9211 Abotetum Parkway, Suite 200
Richmond, Virginia 23236-3469
Tel: (804) 323-9500 FAX: (804) 323-1560

VICINITY MAP

T-1	TITLE SHEET
SP-1	SITE PLAN & NOTES
Z-1	ZONING EXHIBIT
S-1	SITE COMPOUND PLAN, DETAILS & GENERAL NOTES
S-2	WATER TOWER ELEVATION AND ANTENNA SUPPORT STRUCTURE
S-3	SITE CONSTRUCTION DETAILS
E-1	ELECTRICAL PLAN, RISER, NOTES AND DETAILS
E-2	GROUNDING RISER DIAGRAM WITH DETAILS AND SCHEDULE

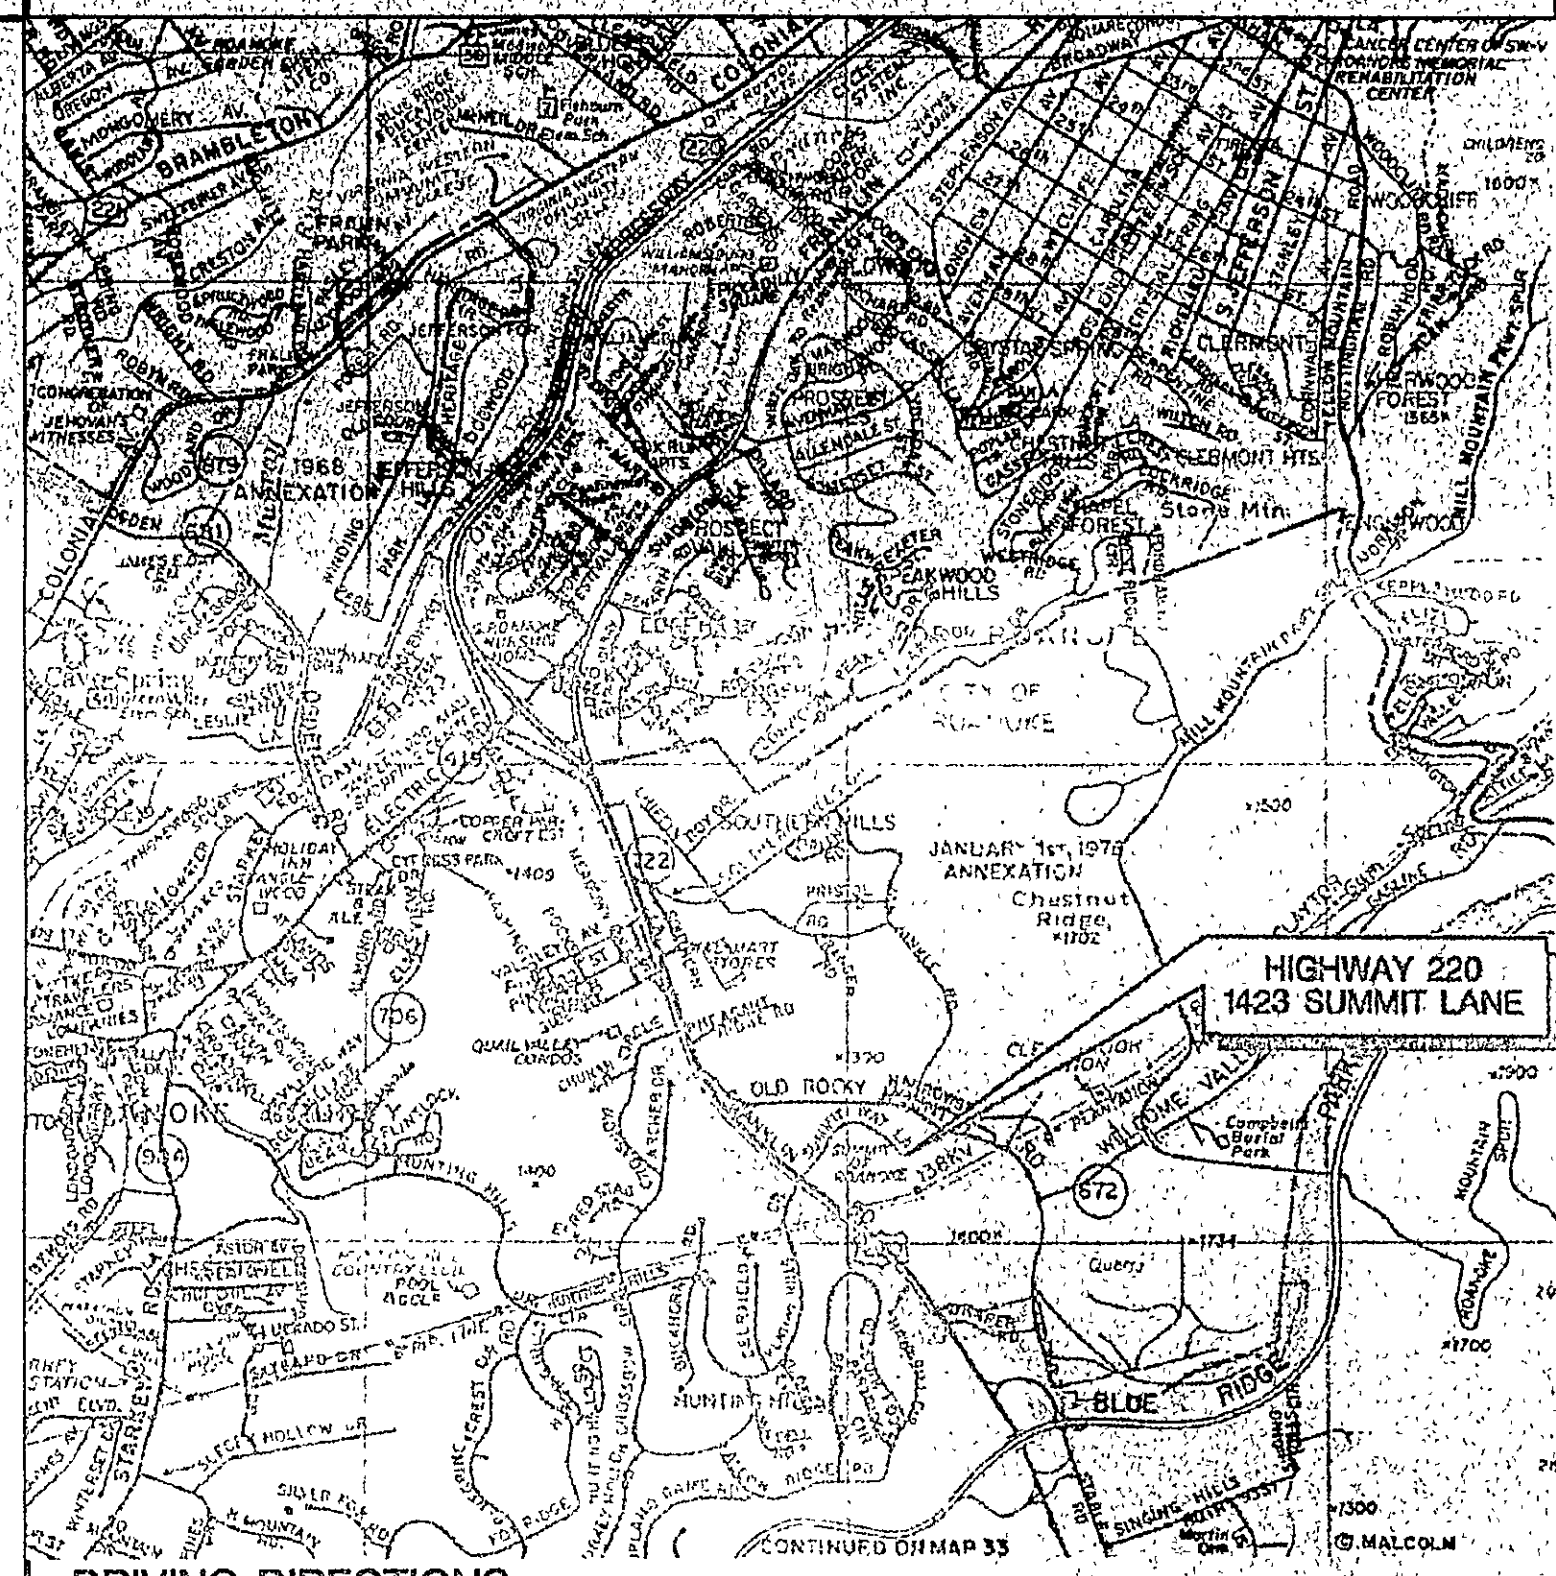

DRIVING DIRECTIONS:
AT THE INTERSECTION OF INTERSTATE 581 AND INTERSTATE 81, PROCEED SOUTH ON I-581 TOWARD ROANOKE. I-581 WILL BECOME RTE. 220. PROCEED TO SUMMIT APARTMENTS AND TURN LEFT ONTO SUMMIT WAY. SITE IS LOCATED AT END OF SUMMIT WAY AND WATER TANK IS DIRECTLY IN FRONT OF ROAD.


APPROVALS

Triton PCS		
LANDLORD		
LEASING		
R.F.		
ZONING		
CONSTRUCTION		
PROJECT NO.	DRAWN BY	CHECK BY
TR-005	EMH	RJK

SUBMITTALS

NO.	DATE	ISS JE
0	06-05-97	TVV DATE
1	06-25-97	ISSUED FOR REVIEW (ZONING)
2	07-17-98	ISSUED FOR REVIEW (CONST.)
3	07-24-98	ISSUED FOR CONSTRUCTION
4	08-04-98	REISSUED FOR CONSTRUCTION
5	09-18-98	REVISED ANTENNA HEIGHT
6	10-08-98	FINAL CONSTRUCTION REVISIONS
7	10-23-98	OWNER REVISIONS
8	12-10-98	REVISED CHANGES
9	3-16-99	AS BUILT DESCRIPTION

GRAPHIC SCALE

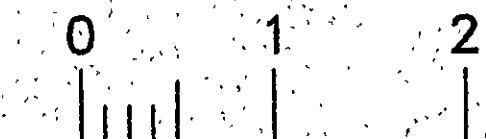

PROJECT

**HIGHWAY 220
RO-1-429-A**
ROANOKE CITY PUBLIC WORKS
1423 SUMMIT LANE
ROANOKE, VA 24011
AS - BUILT COPY

PROJECT SUMMARY

SITE NUMBER:	RO-I-429-A	PROPERTY OWNER:	ROANOKE CITY PUBLIC WORKS
SITE NAME:	HIGHWAY 220		215 CHURCH STREET, RM. 354
SITE ADDRESS:	ROANOKE CITY PUBLIC WORKS		ROANOKE, VIRGINIA 24011
	1423 SUMMIT LANE	APPLICANT:	TRITON PCS, Incorporated
	ROANOKE, VIRGINIA 24011		9211 ARBORETUM PARKWAY, SUITE 200
DEED BOOK-PAGE:	DB 1545 - P 00468		RICHMOND, VIRGINIA 23236
TAX ID NUMBER:	#5380121	CONTACT PERSON:	JESSE H. PERDUE (Public Works Manager)
TRACT NUMBER:	#2		(540) 853 - 2601
CURRENT ZONING:	(C-I) OFFICE DISTRICT	JURISDICTION:	CITY OF ROANOKE

SITE DATA:
LATITUDE: N 37-13'-04" (USGS)
LONGITUDE: W 79-57'-35" (USGS)
ELEVATION: 1450.00± AMSL @ BASE
USGS MAP: GARDEN CITY, VA
REF. MAP: MALCOM'S MAP CITY OF ROANOKE
PAGE / GRID: #25 / S-15
BTS EQUIP: ERICSSON RBS 884 / 16CH / SCCS

T.T.V. PARTICIPANTS

TTY REP:	NAME	COMPANY	TEL. NO.
R.F. ENG.	ALBERT LAI	W.F.I.	804 323-9500
A & E REP.	JOHN CLAUSEN	BETZWOOD	610 917-8831
S.A.Q. REP.	KEVIN ARNOLD	ENTEL	540 520-1912
CONST. REP.	JIM MOORE	ENTEL	804 323-9500
OWNER REP:			
CONSULT. ENG.	McCOY FARMER	ENTEL	804 323-9500
OTHER			

OWNER APPROVAL:

OWNER REPRESENTATIVE:	DATE:
-----------------------	-------

SHEET TITLE

TITLE SHEET

SHEET NUMBER.

T-1