




LIMIT OF CONTRACT
12" MJ PLUG
STA. 13+73.83,
17.9' RT. 1/2" C"

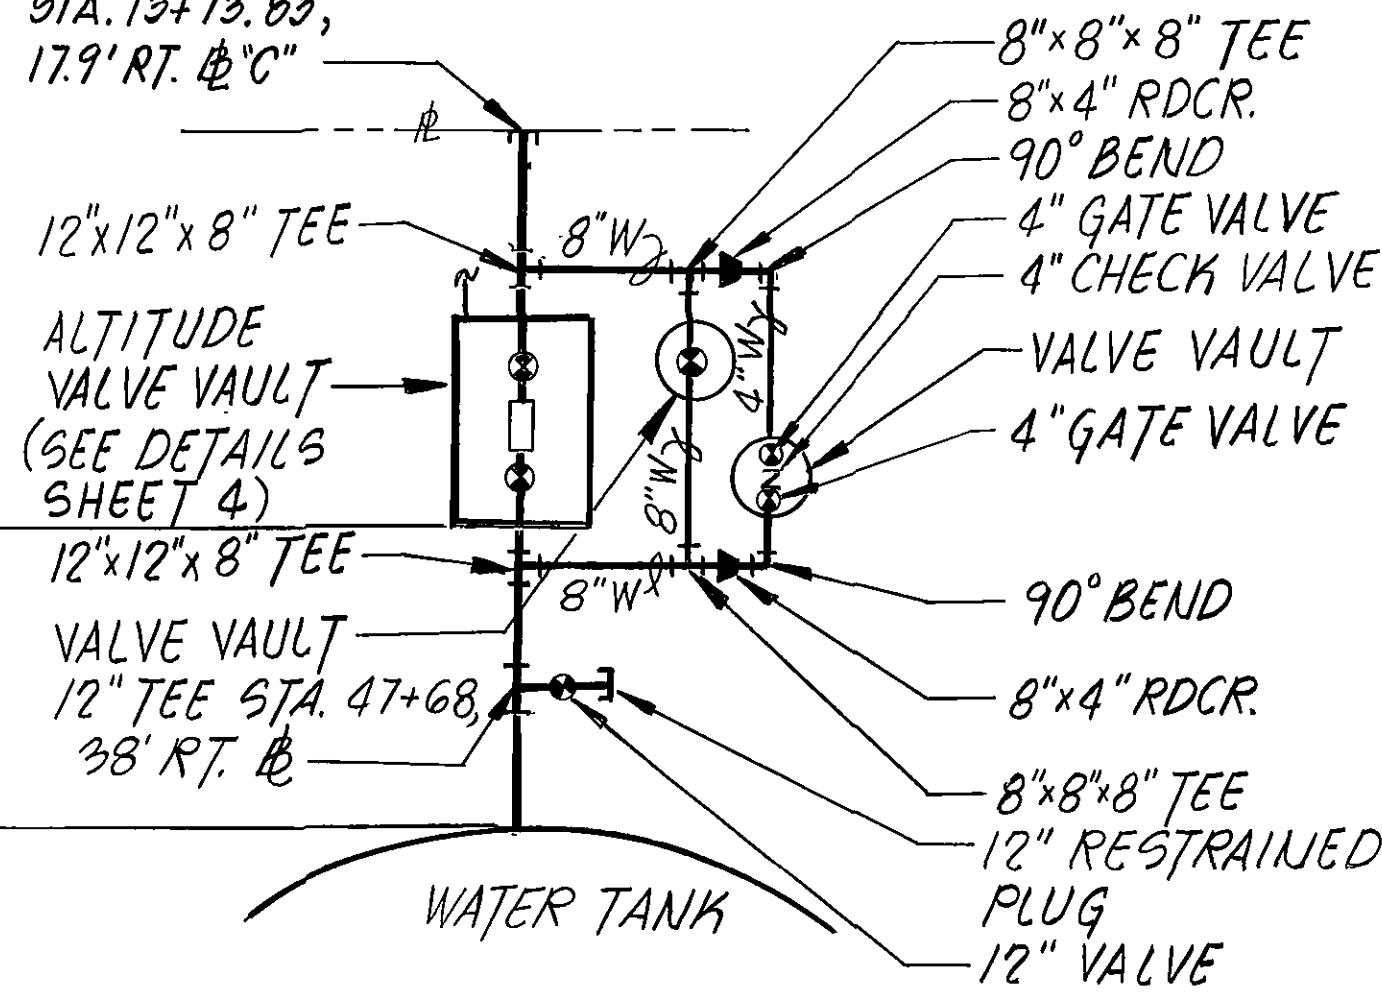

DETAIL A
NO SCALE

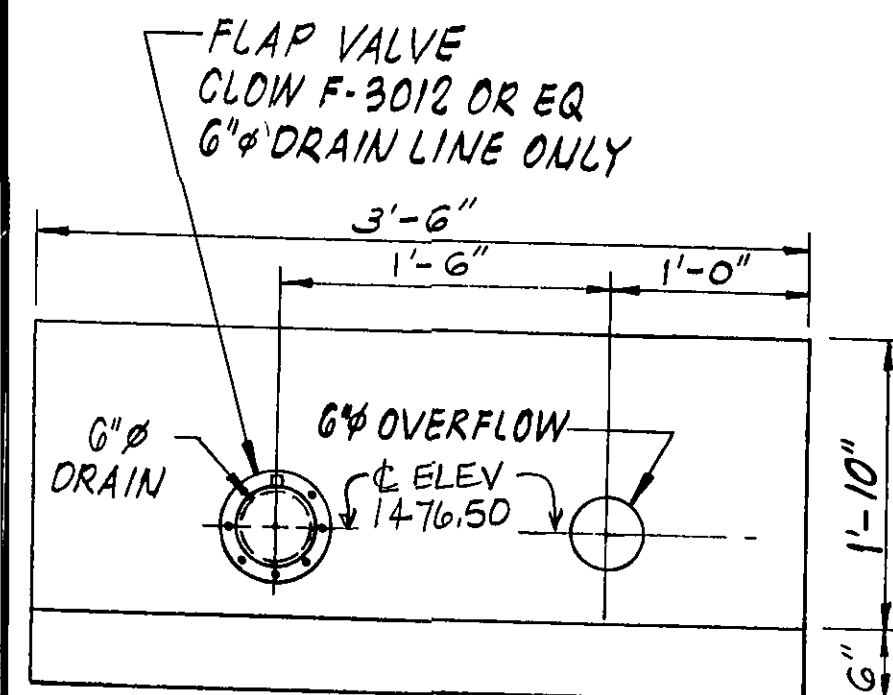


FRONT ELEVATION


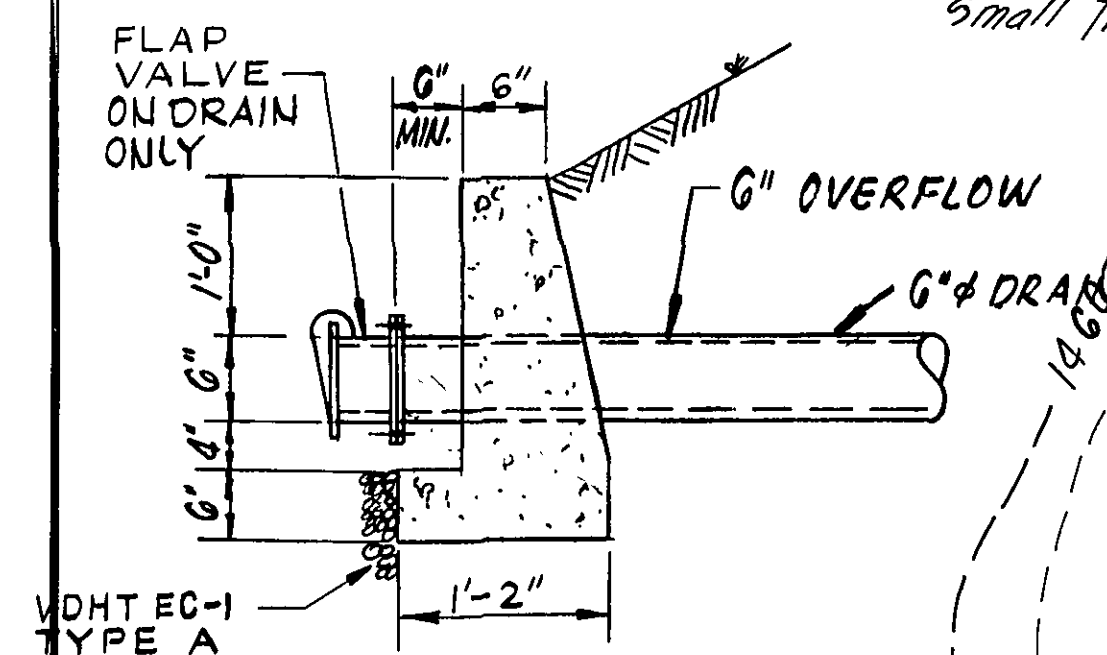


END ELEVATION

ENDWALL
NO SCALE

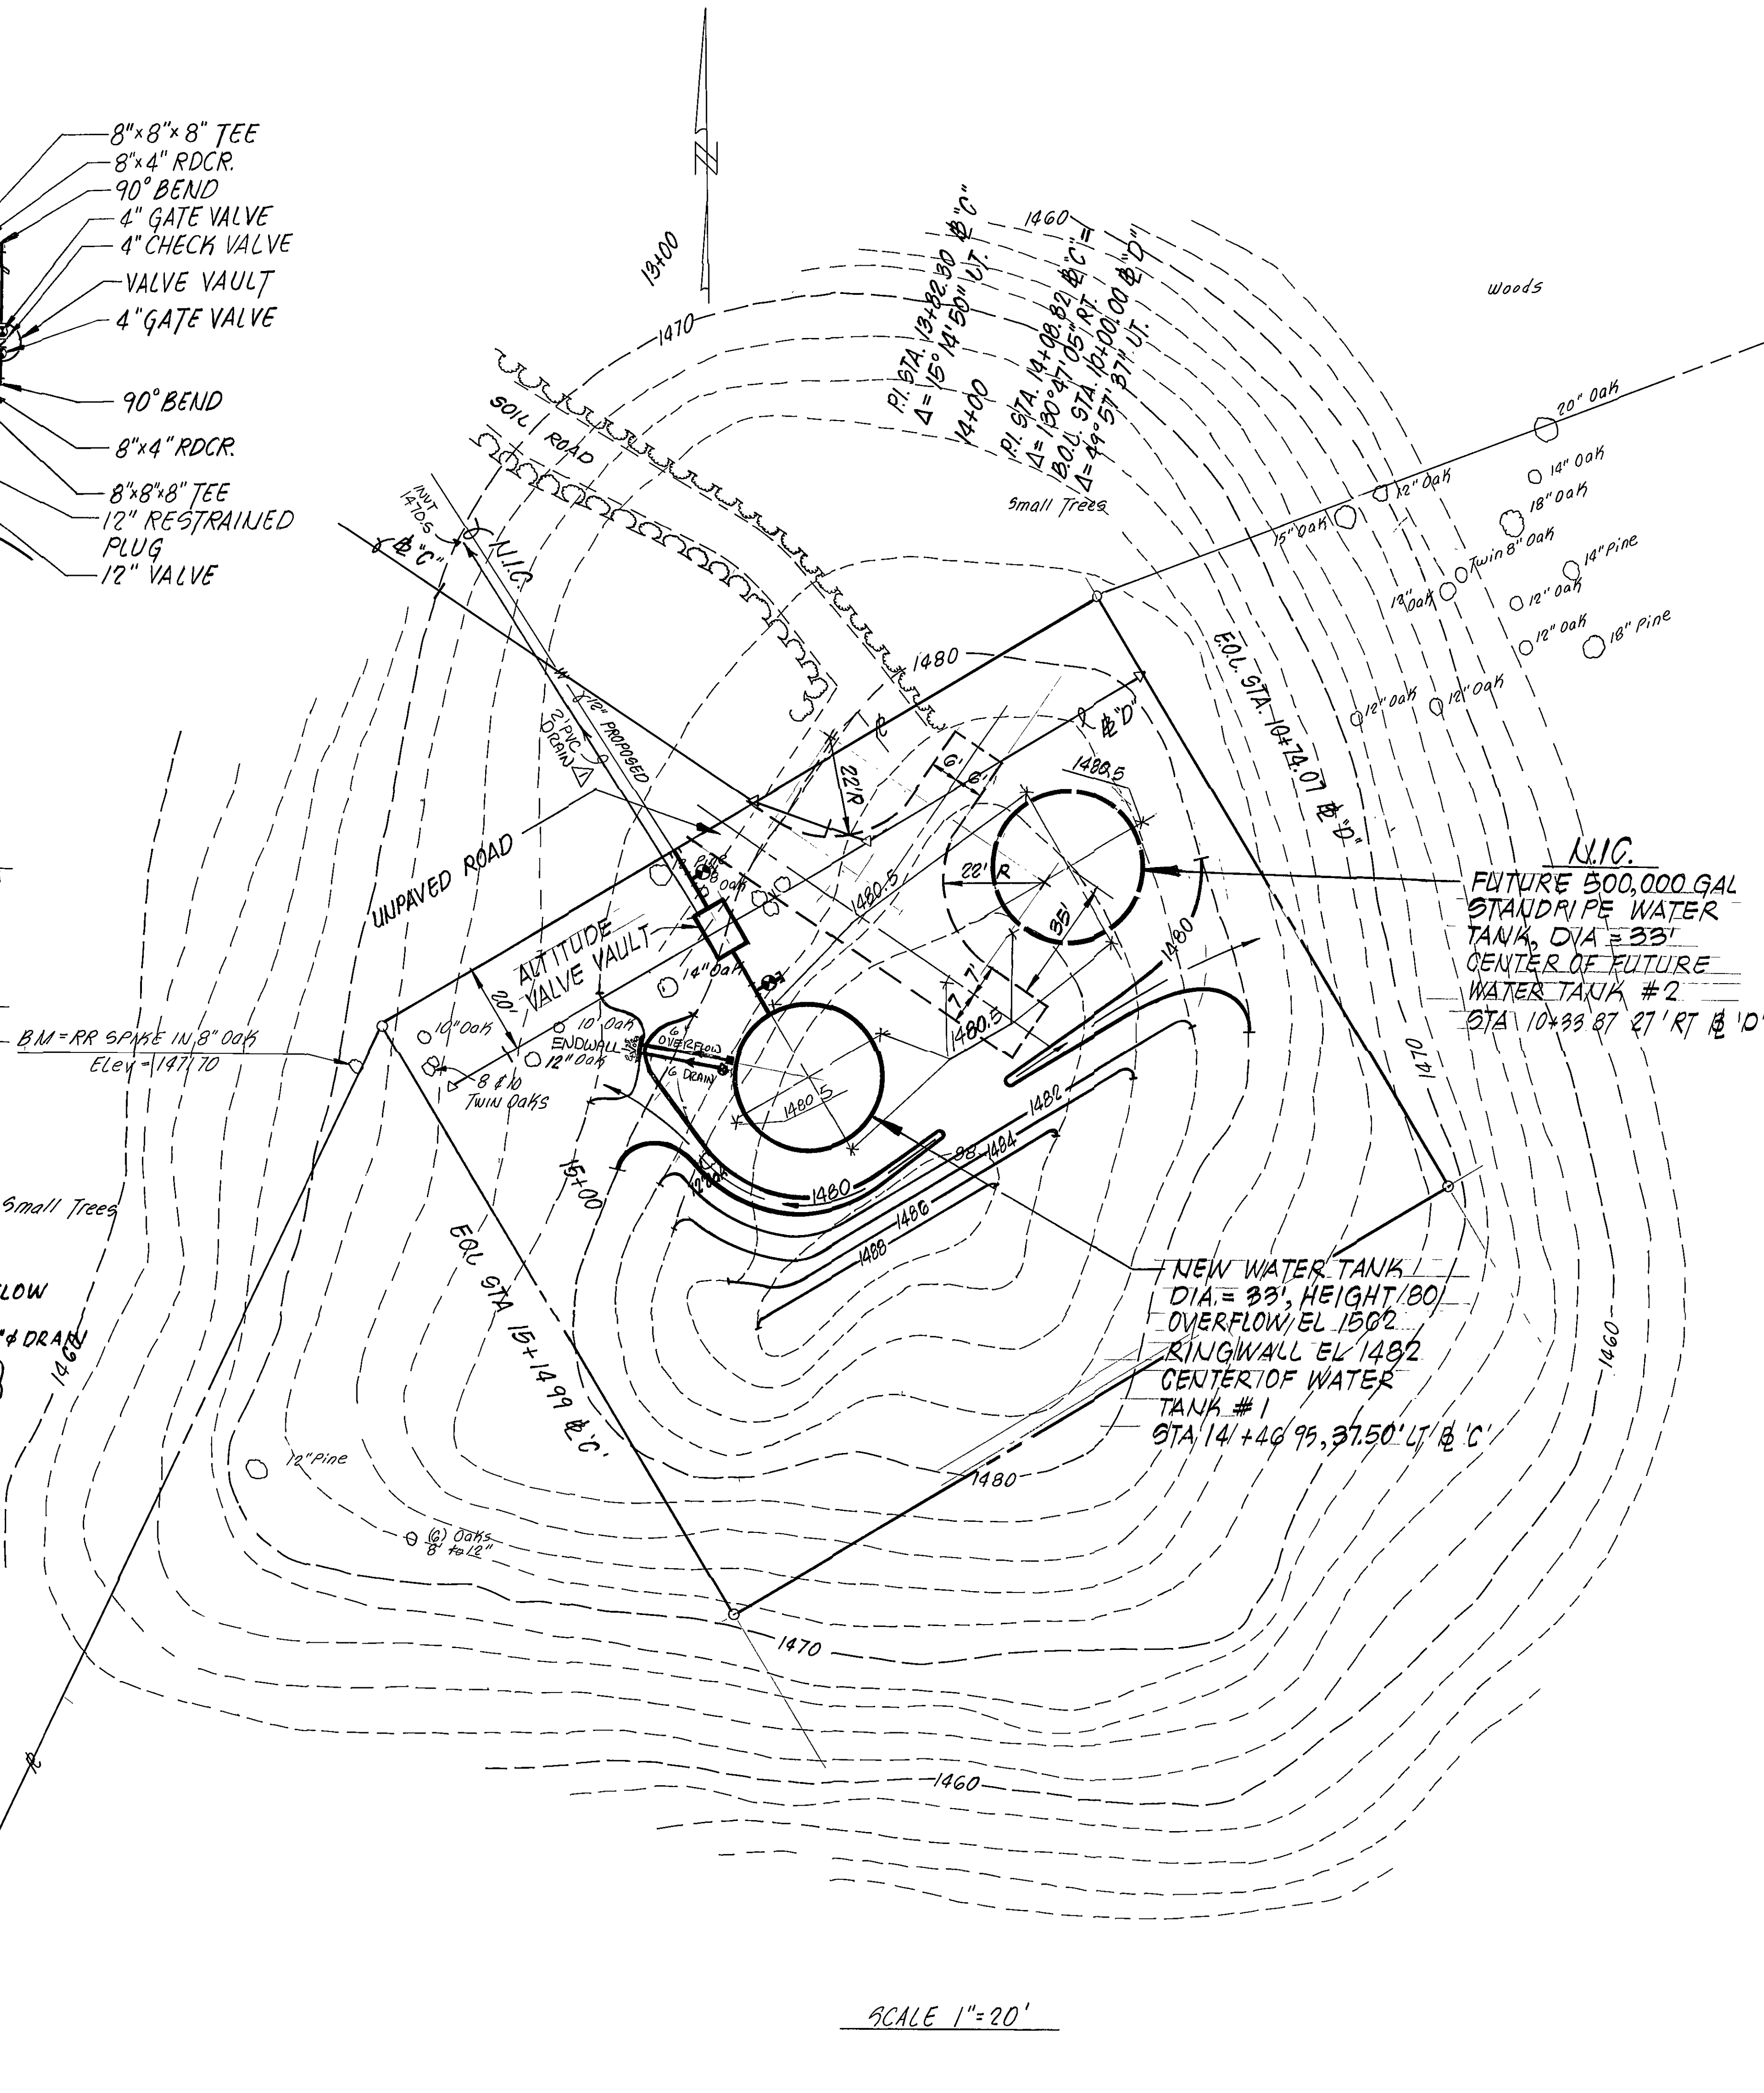

SCALE 1"=20'

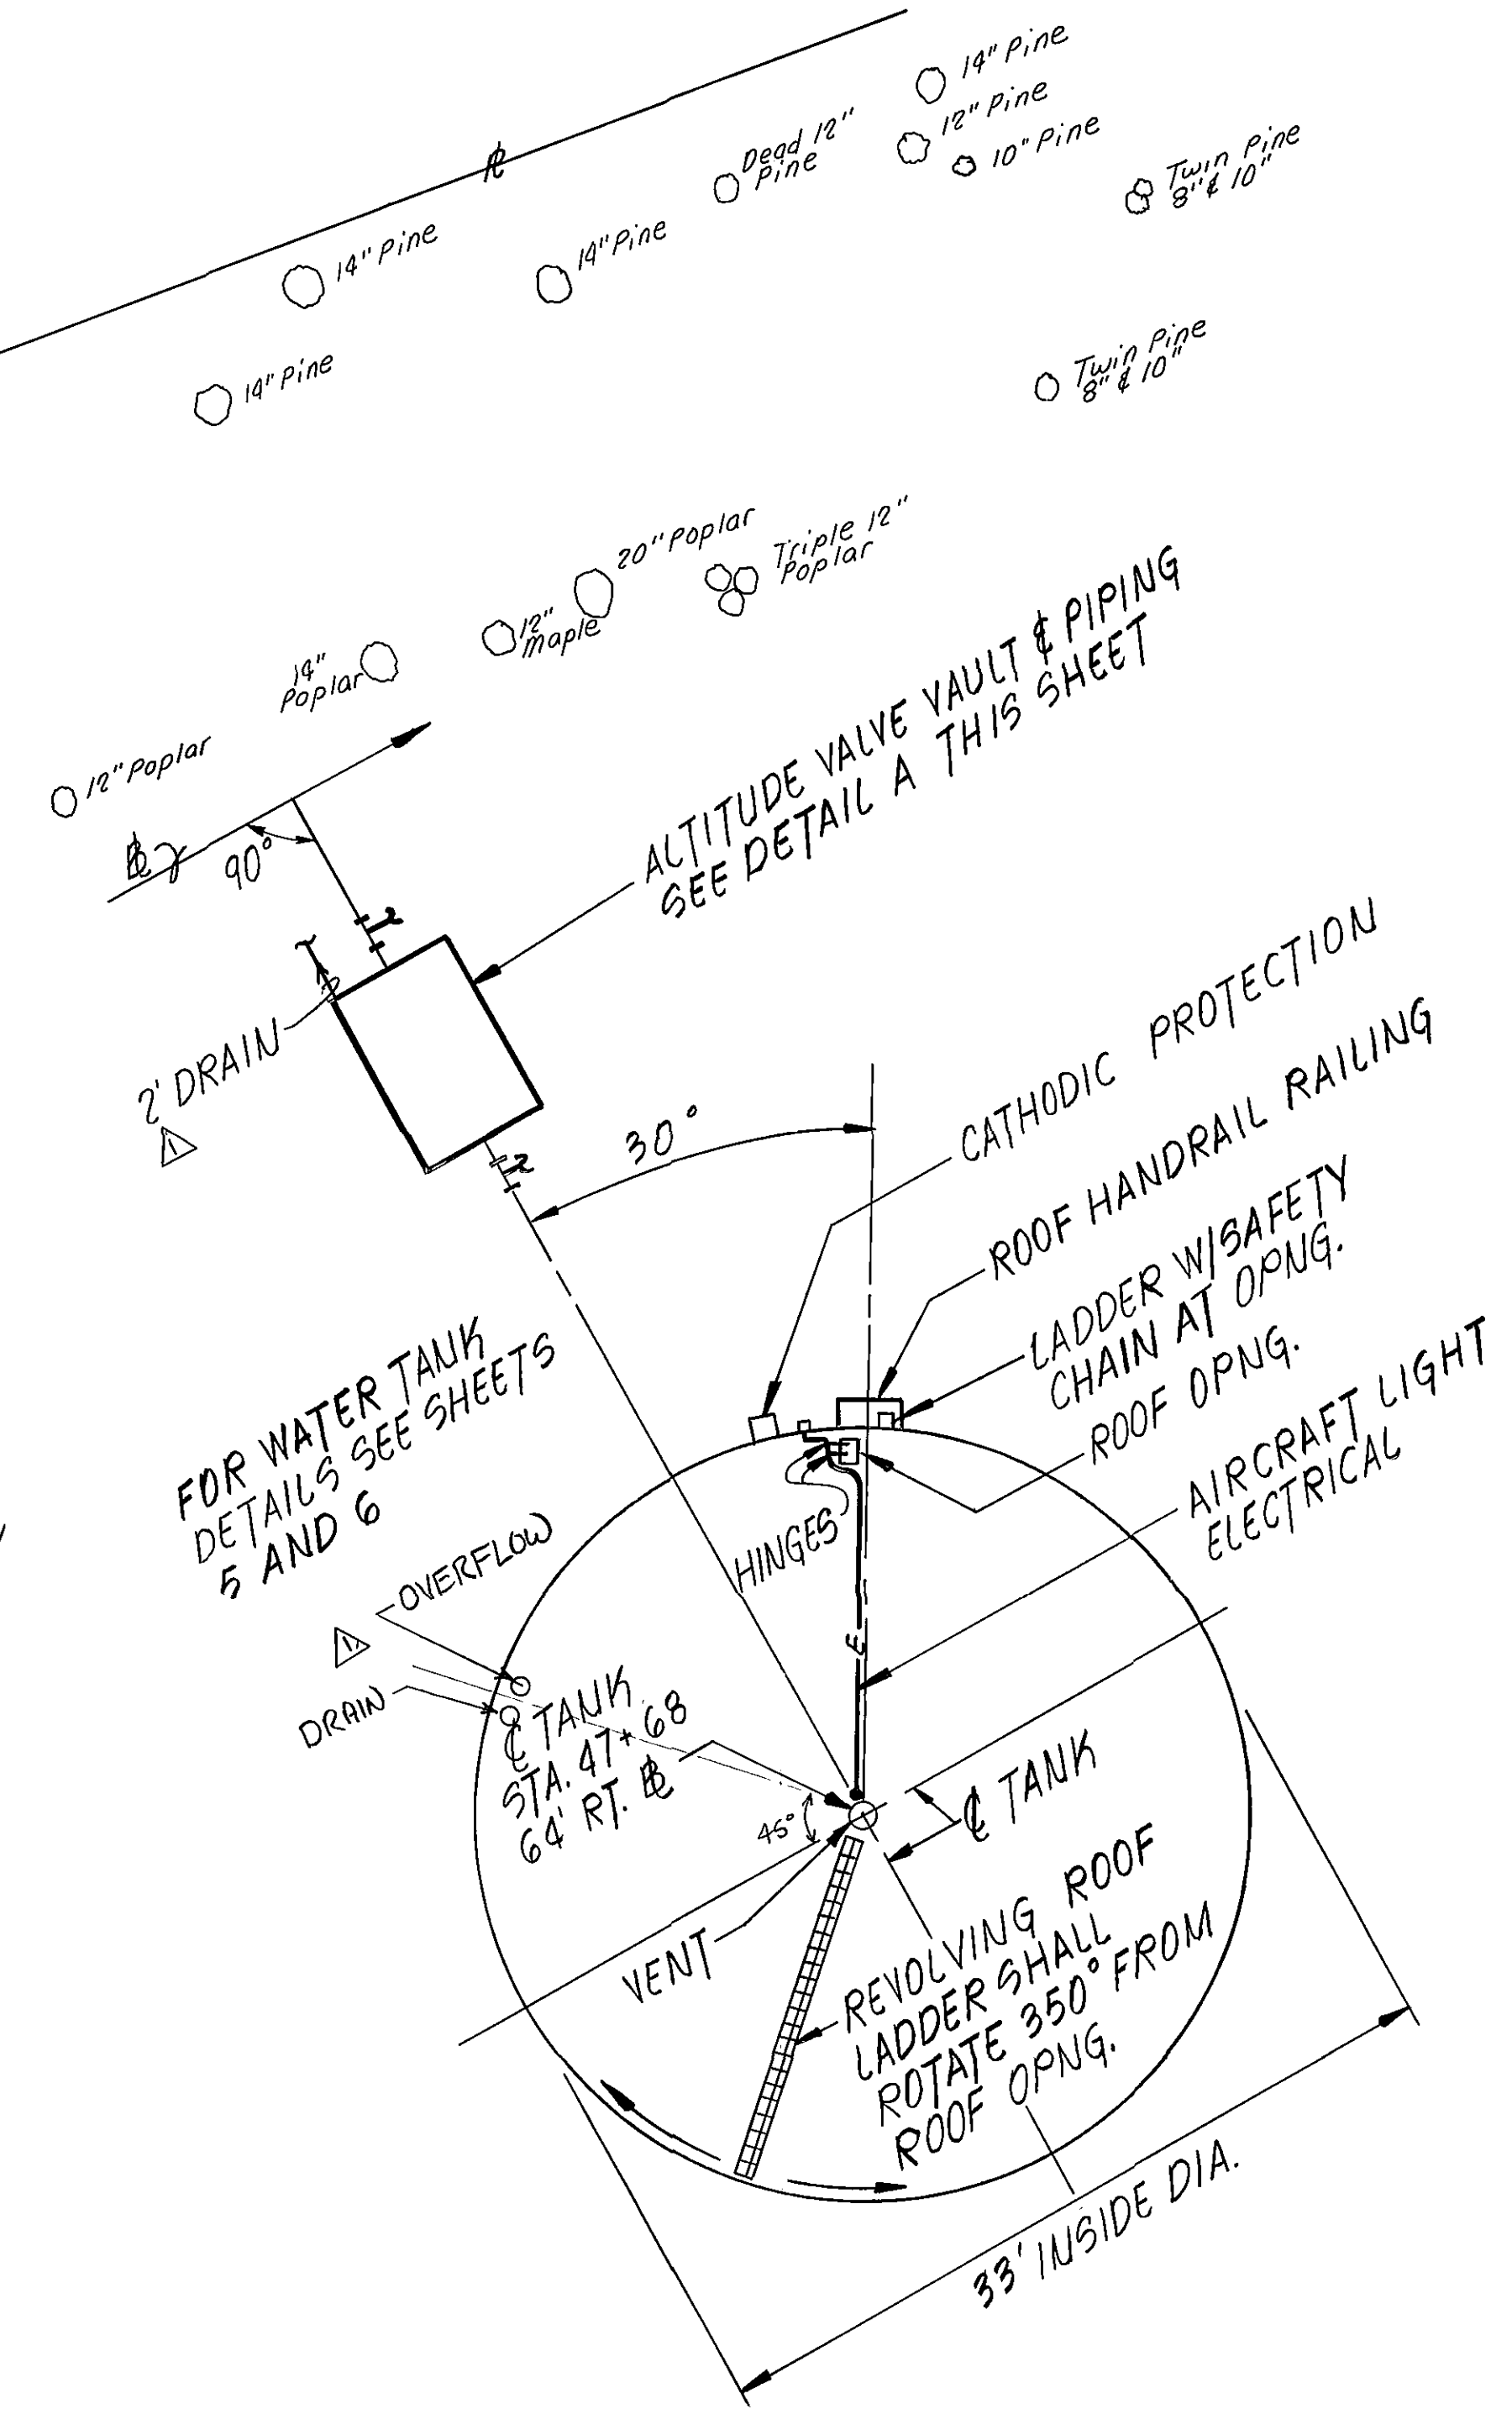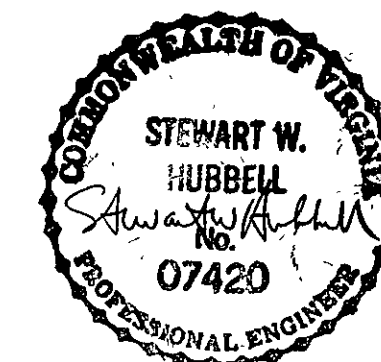

WATER TANK ROOF PLAN
NO SCALE

RECORD DRAWING

REVISION	DATE	DESCRIPTION	BY	APP
1	4/28/86	REV PER SDH COMMENTS		SWH
DESIGNED RM, SWH				
DRAWN RM				
CHECKED SWH				
APPROVED				
SUBMITTED				
FRANKLIN ROAD WATER TANK			564	
PLAN AND DETAILS			3	
Mattern & Craig CONSULTING ENGINEERS			SCALE NOTED	DATE NOV 1985