


PROJECT LOCATION MAP

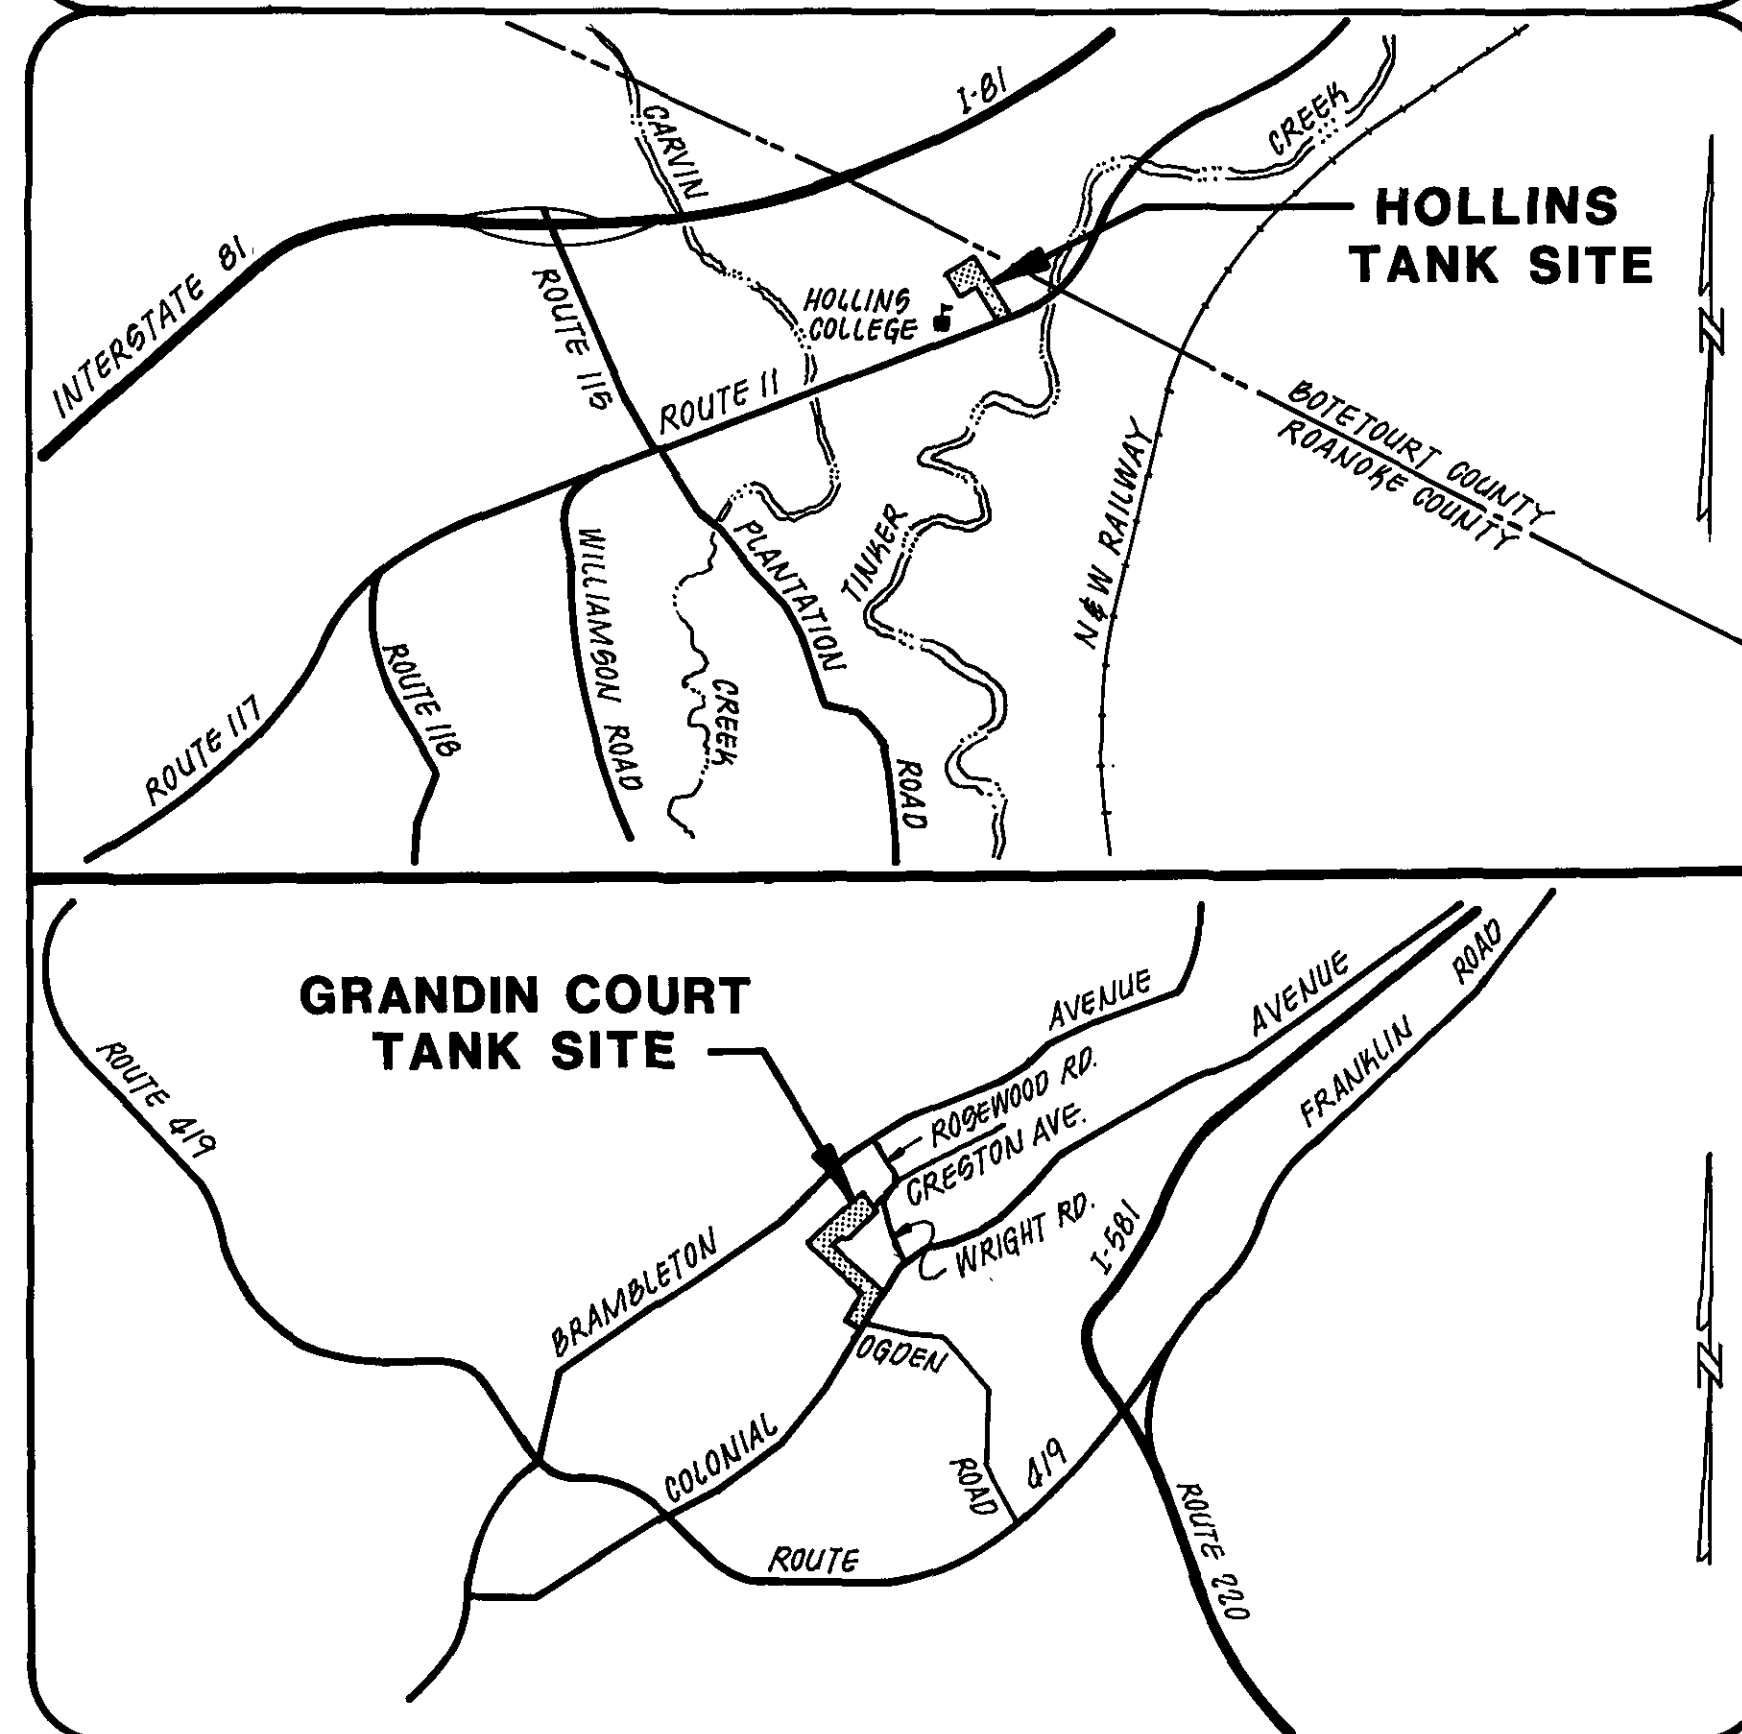

OFFICE OF CITY ENGINEER
ROOM 350
MUNICIPAL BUILDING
215 CHURCH AVENUE, S.W.
ROANOKE, VIRGINIA 24011


INDEX OF SHEETS

- SHEET 1 TITLE SHEET
- SHEET 2 ABBREVIATIONS, LEGEND AND GENERAL NOTES
- SHEET 3 GRANDIN COURT WATER TANK #3
PLAN AND PROFILE
- SHEET 4 GRANDIN COURT WATER TANK #3
PLAN AND PROFILE
- SHEET 5 GRANDIN COURT WATER TANK #3
PLAN AND PROFILE
- SHEET 6 GRANDIN COURT WATER TANK #3
PLAN AND PROFILE
- SHEET 7 HOLLINS WATER TANK
PLAN
- SHEET 8 HOLLINS WATER TANK
PROFILE AND DETAILS
- SHEET 9 GRANDIN COURT WATER TANK #3
AND HOLLINS WATER TANK
DETAILS
- SHEET 10 STRUCTURAL DETAILS

CONSULTING ENGINEERS

MATTERN AND CRAIG
CONSULTING ENGINEERS
ROANOKE, VIRGINIA

COMMISSION NUMBER: **468 & 470**

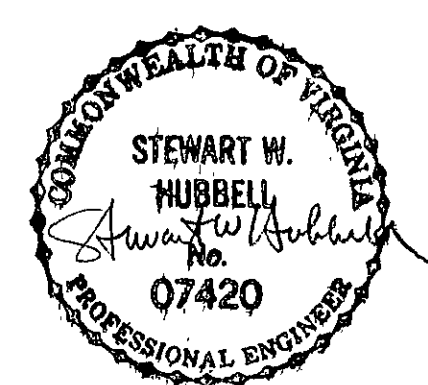

PROJECT NAME

**GRANDIN COURT WATER TANK #3
AND
HOLLINS WATER TANK REPLACEMENT**

PROJECT NO. 84-06 & 84-07
COMM. NO. 470 & 468

PROJECT NUMBER: **84-06 & 84-07**

REVISION	BY	DESCRIPTION:	DATE
REVISION	BY	DESCRIPTION:	DATE
REVISION	BY	DESCRIPTION:	DATE
REVISION	BY	DESCRIPTION:	DATE

APPROVED FOR CONSTRUCTION

<i>Robert B. Brown</i> ROANOKE CITY ENGINEER	<u>10 MAY 84</u> DATE
<i>William M. Mullin, Jr.</i> DIRECTOR OF PUBLIC WORKS	<u>5/9/84</u> DATE
<i>Kit B. Lin</i> DIRECTOR OF UTILITIES AND OPERATIONS	<u>5/10/84</u> DATE
	DATE
	DATE

ADVERTISED DATE: **MAY 13, 1984**

SET NUMBER

SHEET NUMBER **1** OF **10**