




PROFILE					
	SURVEYED _____			BY _____	DATE _____
	PLOTTED _____				
	GRADES CHECKED _____ B. M.'s NOTED _____				
NOTE BOOK					

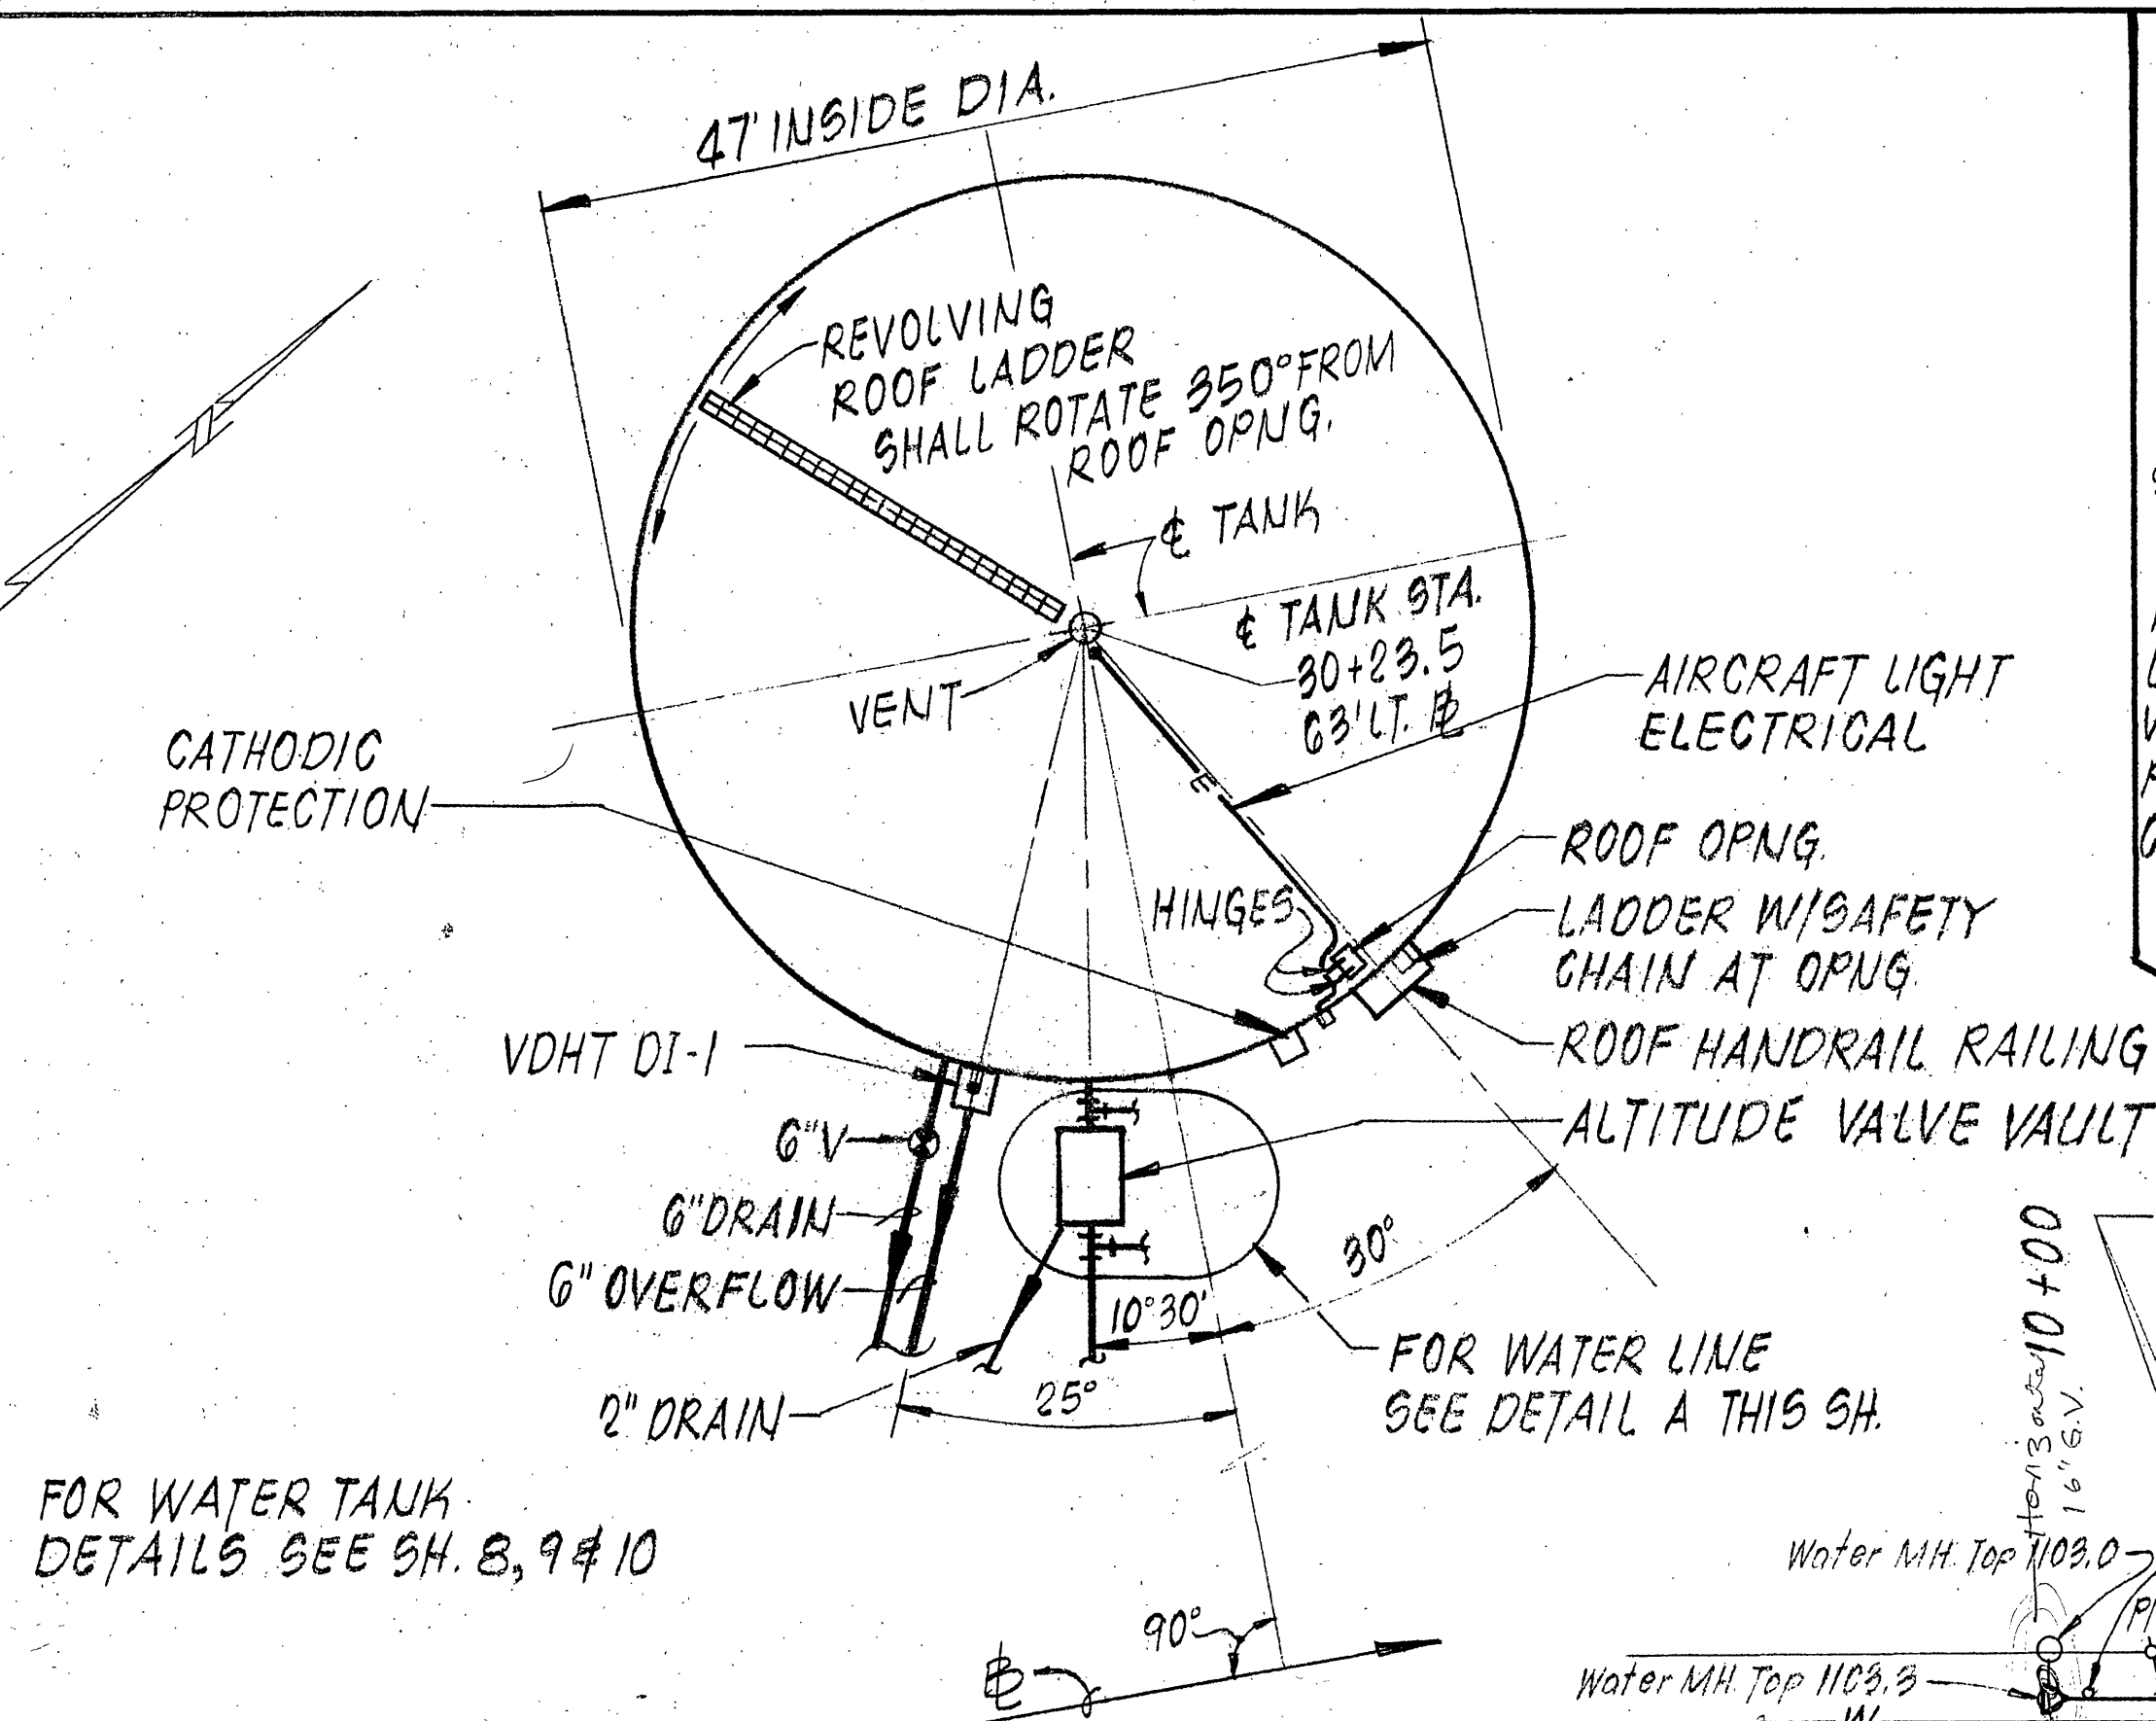


WATER TANK ROOF PLAN
NO SCALE

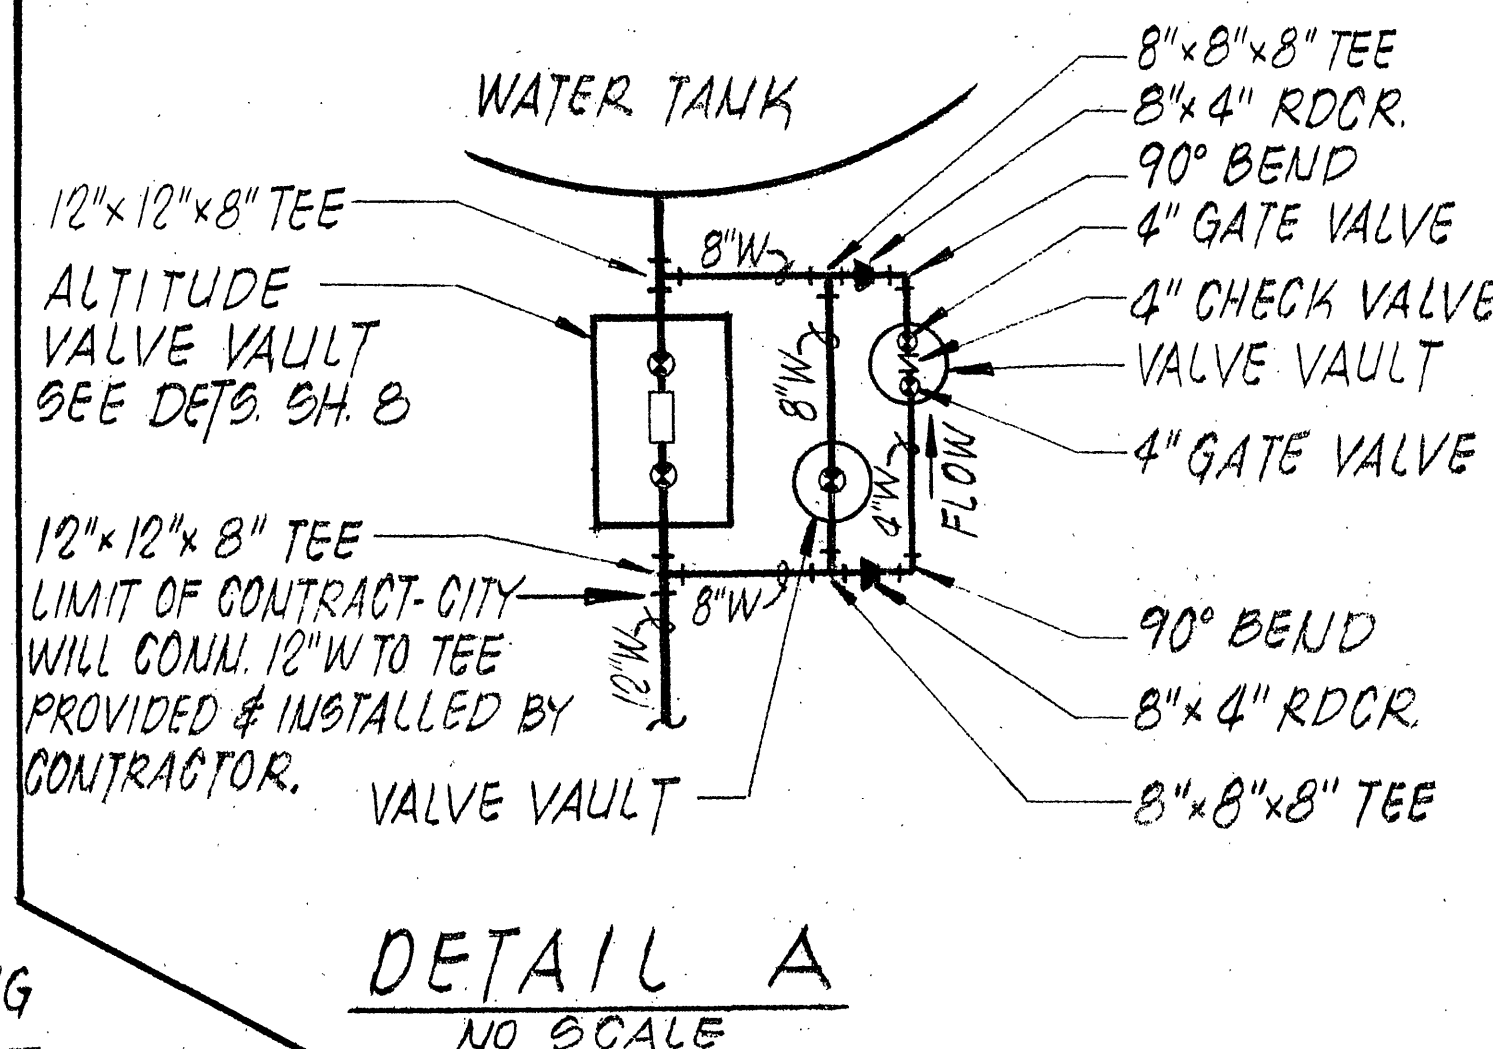


DETAIL A
NO SCALE

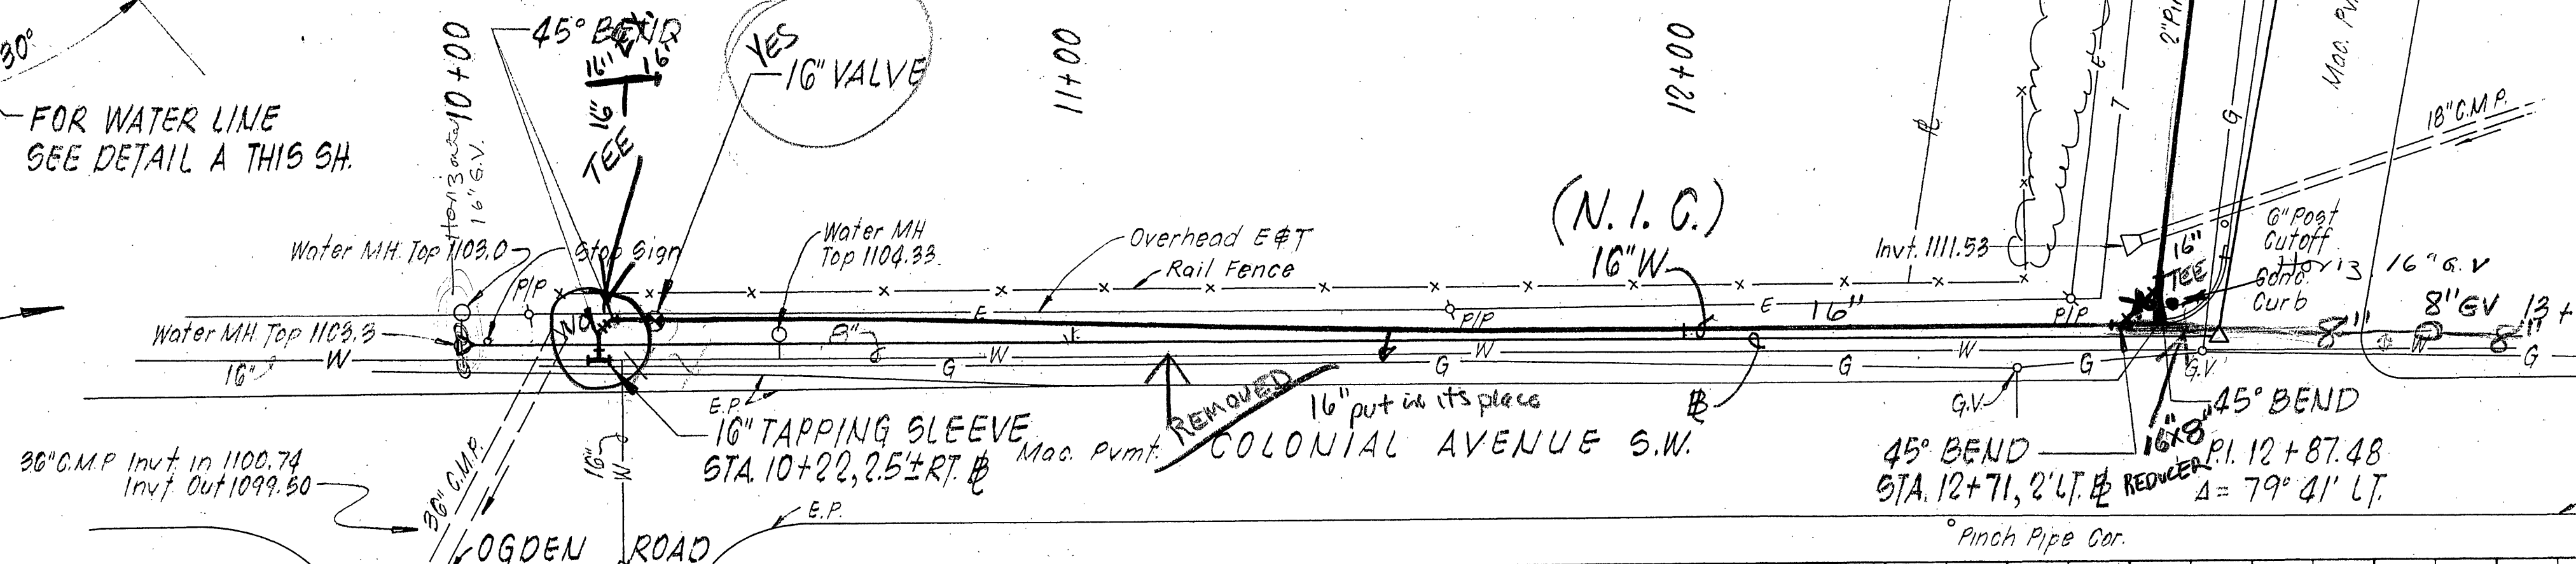

W.L. LOCATION CHART	
STA.	OFFSET
11+00	3 L.T. 4
11+62	1.5' L.T. 4
12+00	1.5' L.T. 4
13+50	15' L.T. 4

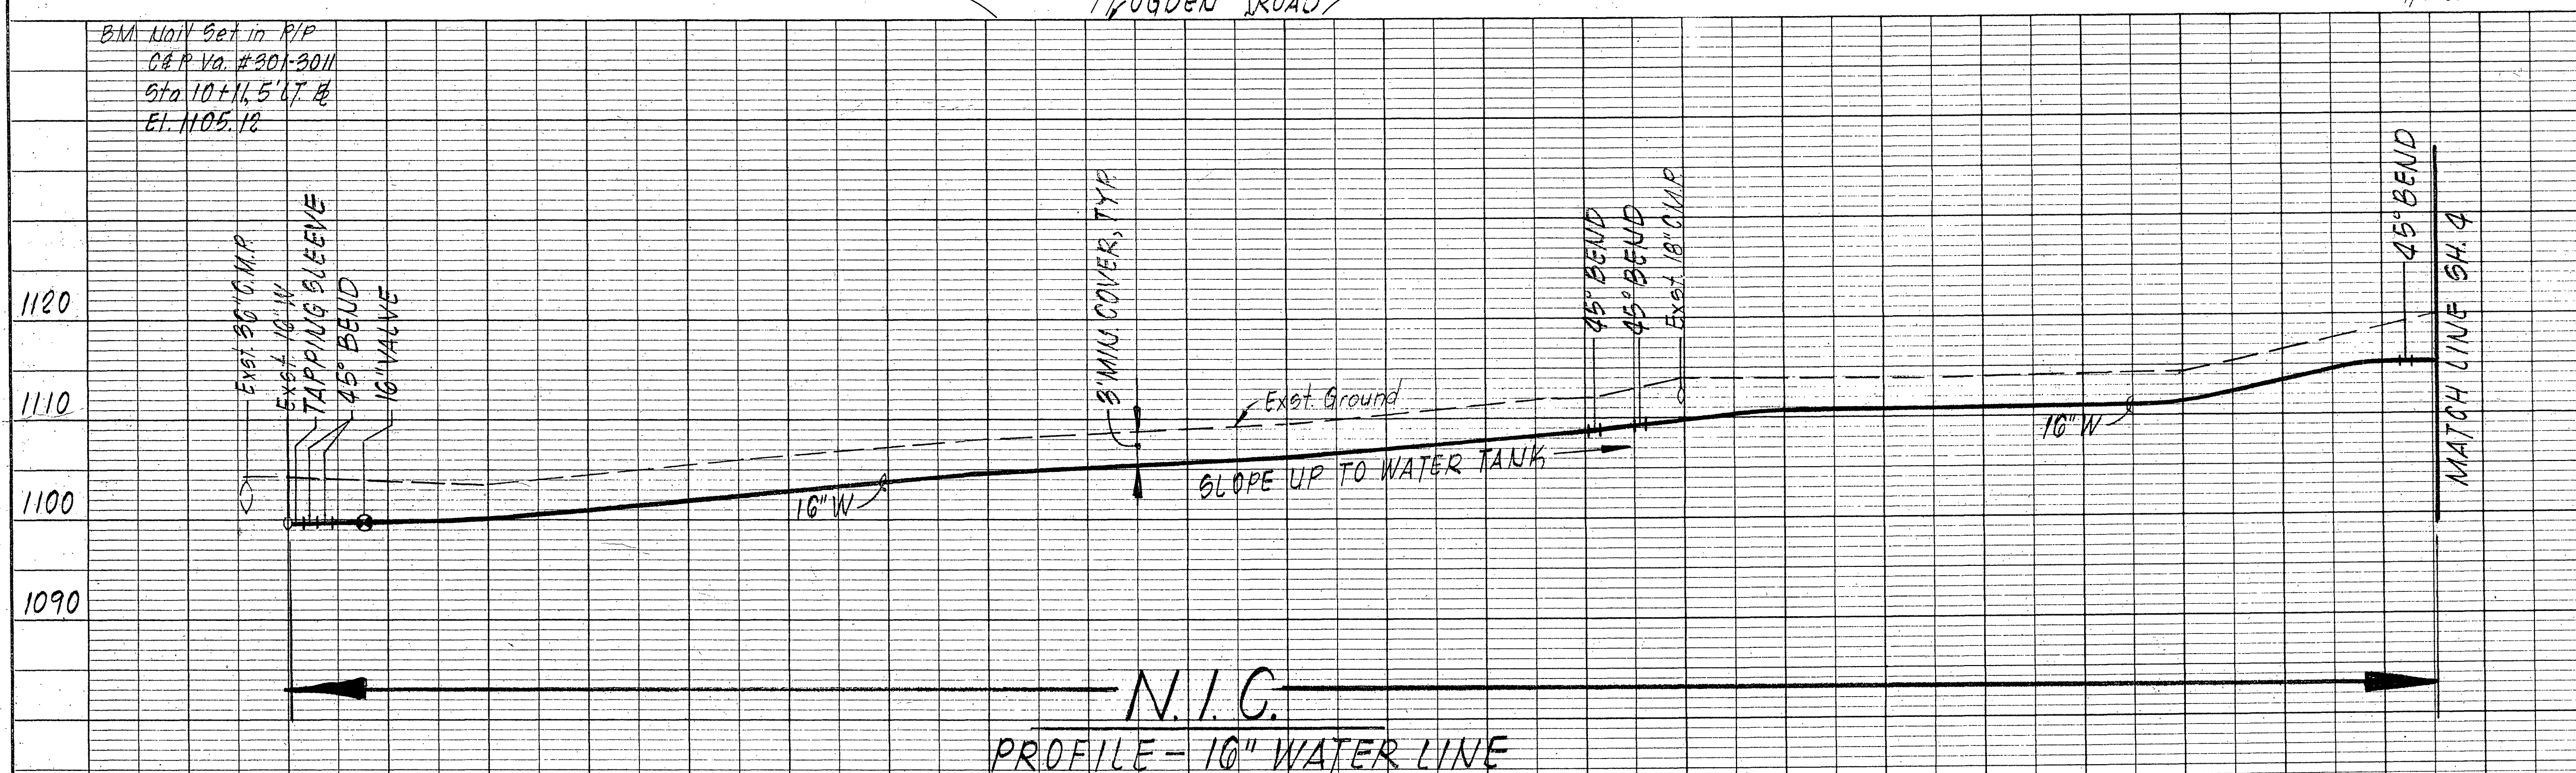

NOTE: WATER LINE BET STA 10+00 & 14+50 N.I.C.

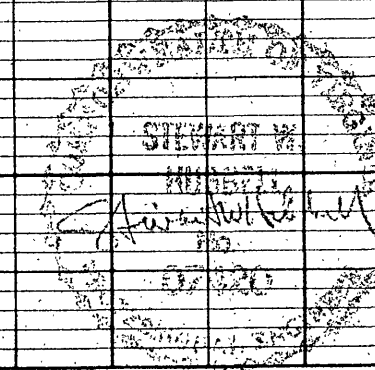

Scale: Horz. 1" = 20'
Vert. 1" = 10'

REVISION	DATE	DESCRIPTION	BY	APPROVED
DESIGNED	PSM	GRANDIN COURT WATER TANK #3		
DRAWN	PSM			
CHECKED	SWH			
APPROVED				
SUBMITTED	SWH			
		PLAN AND PROFILE		
Mattern and Craig		SCALE: NOTED	COMM. NO.	470
CONSULTING ENGINEERS		DATE: MAY 1984	SHEET	3
ROANOKE, VIRGINIA				