





NOTE: LEVELS TO BE ESTABLISHED BY CITY ENGINEERS OFFICE. EXISTING GRADES SHOWN HEREON ARE FROM CITY ENGINEERS PLAN No. 4059.

Floor Elev. 1247.0
PLAN 1"=20'-0"


LEGEND
EXISTING CONTOURS 100'
FINISHED CONTOURS 120'
EXISTING GRADES 120'
FINISHED GRADES 120'

FLOOR PLAN 1/4"=1'-0"


NOTE: SEE SHEET P-1 FOR COMPRESSOR SUPPORT CHANNELS FURNISHED BY PLUMBING CONTRACT & SET BY G.C.

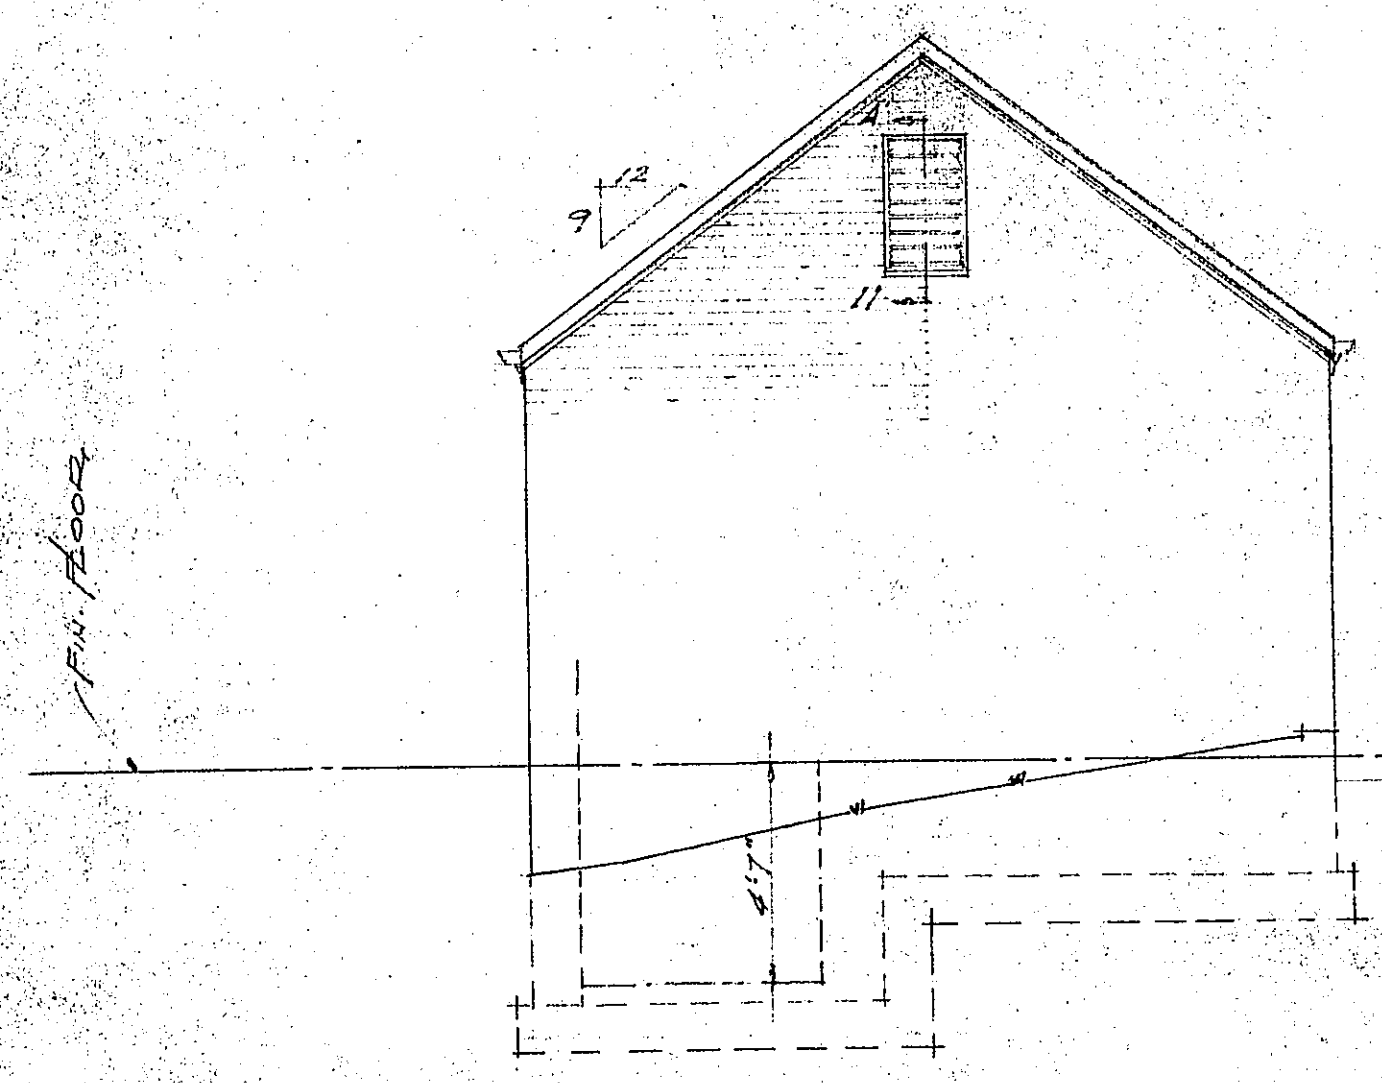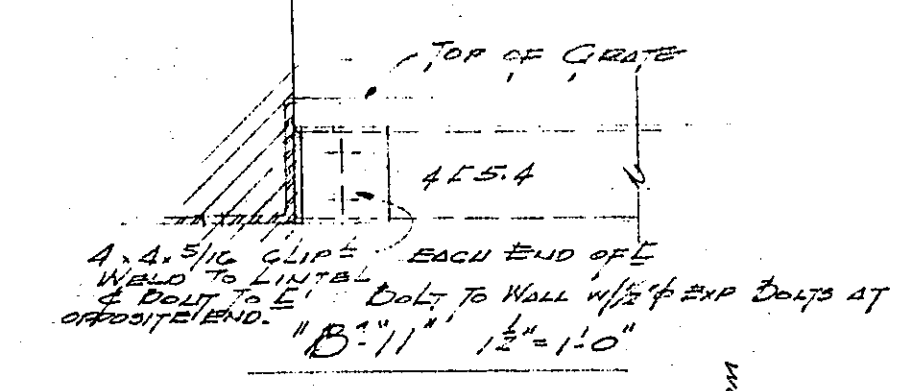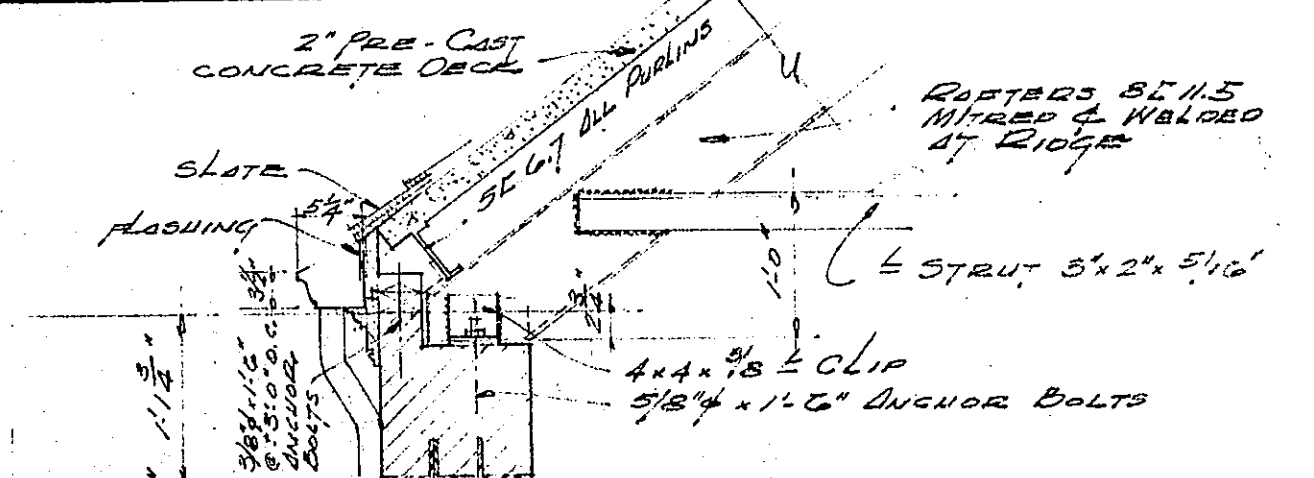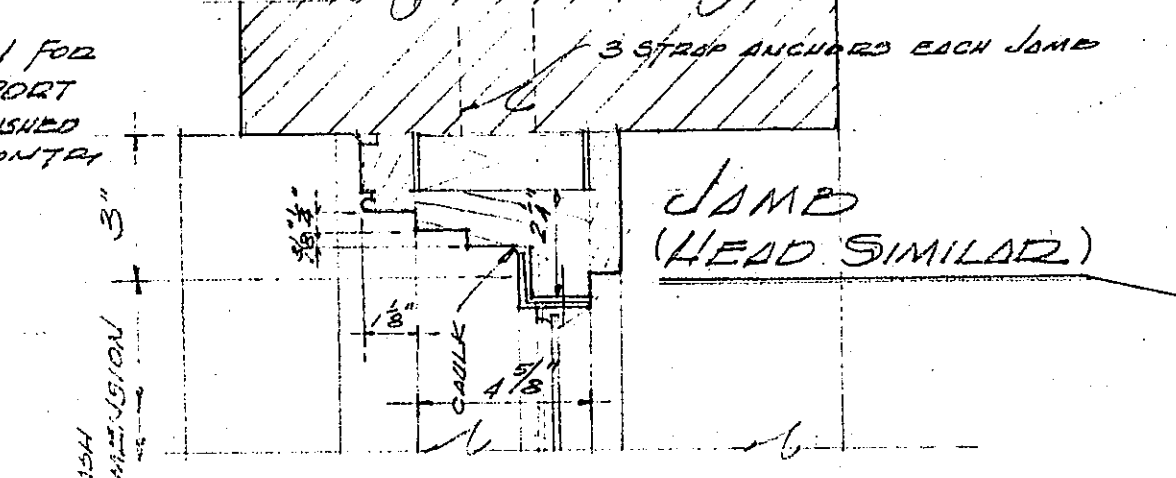


LEFT END

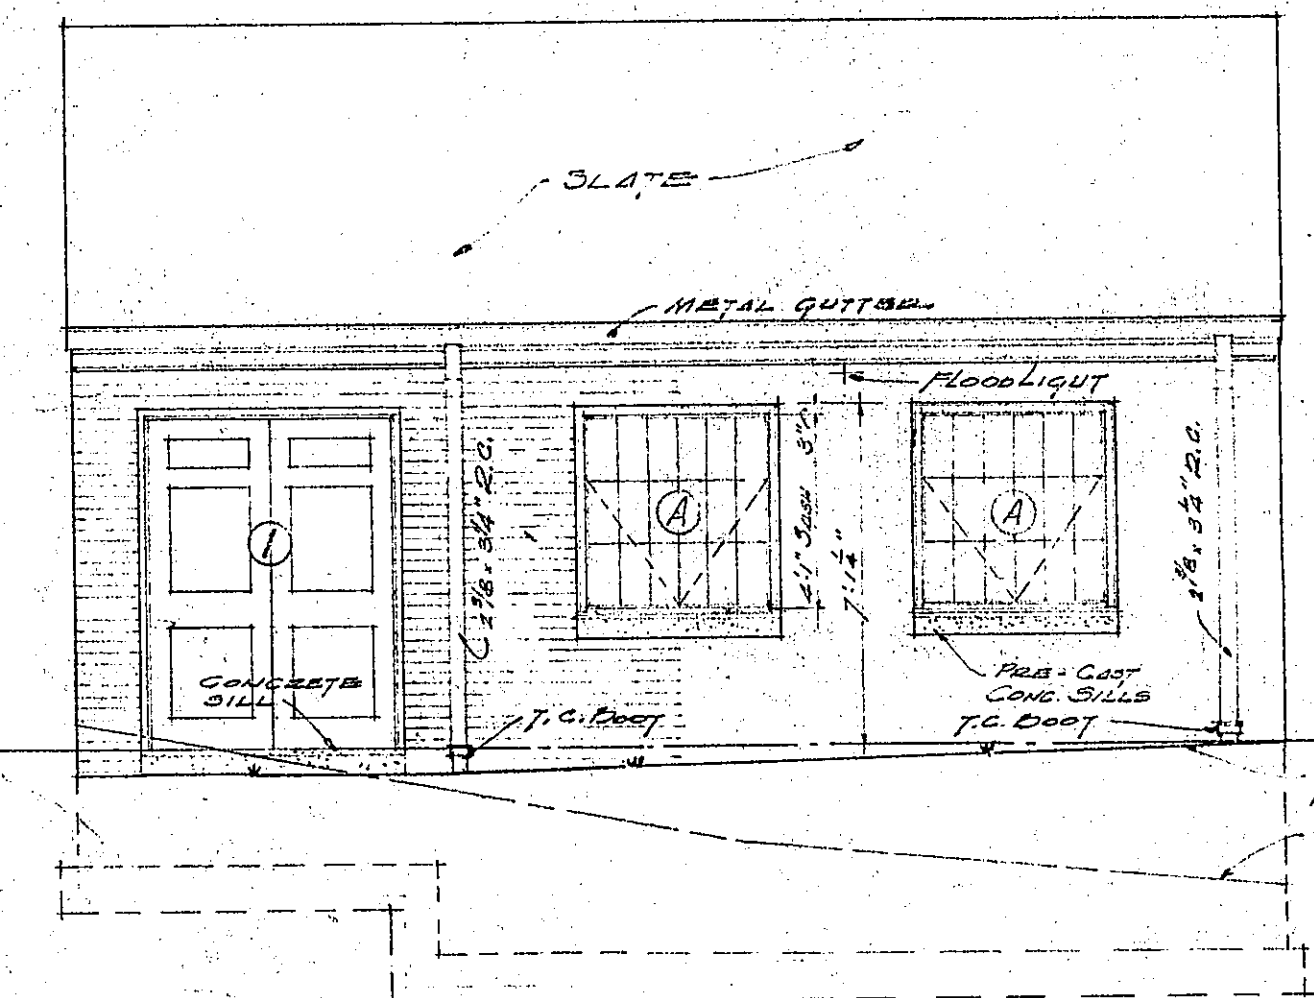


FRONT

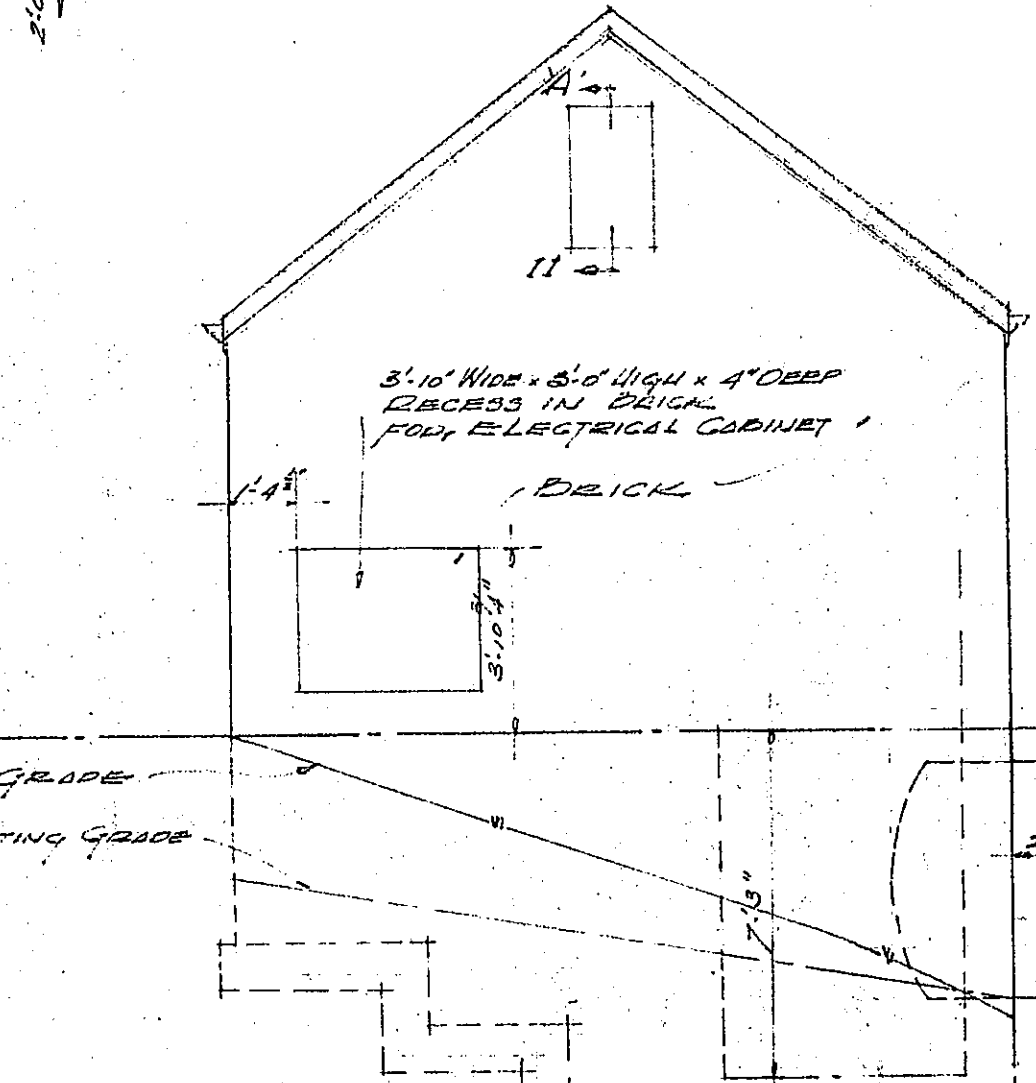


RIGHT END

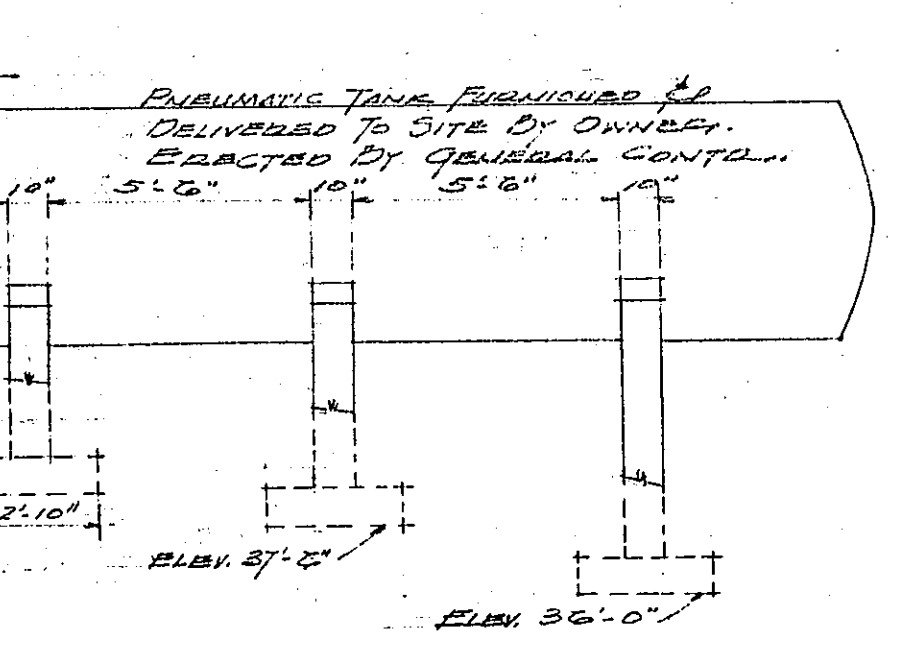


TYPICAL WALL SECTION 3/4"=1'-0"

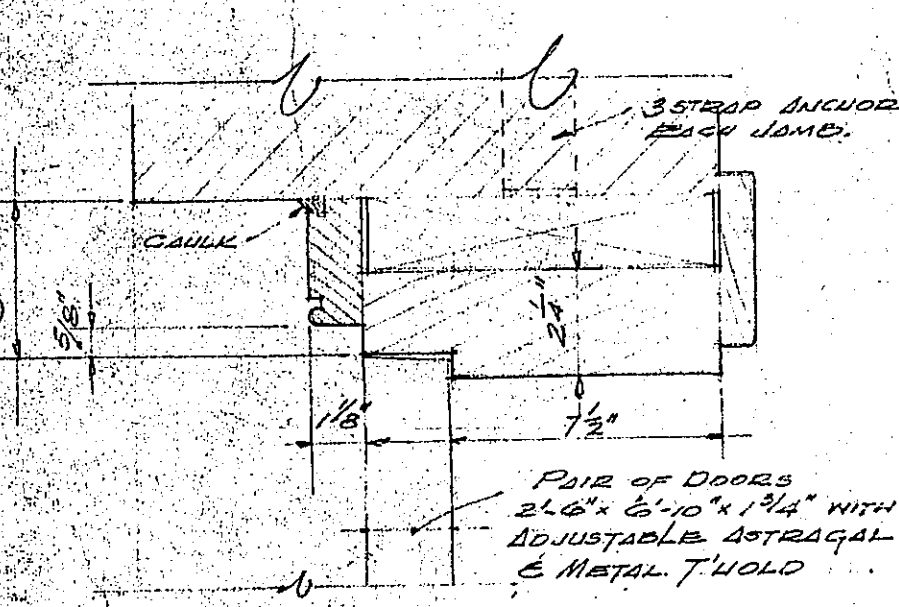

NOTE: RIGHT HAND DOOR OF PAIR IS ACTIVE
DTL. FRAME DOOR NO. 1 3"=1'-0"

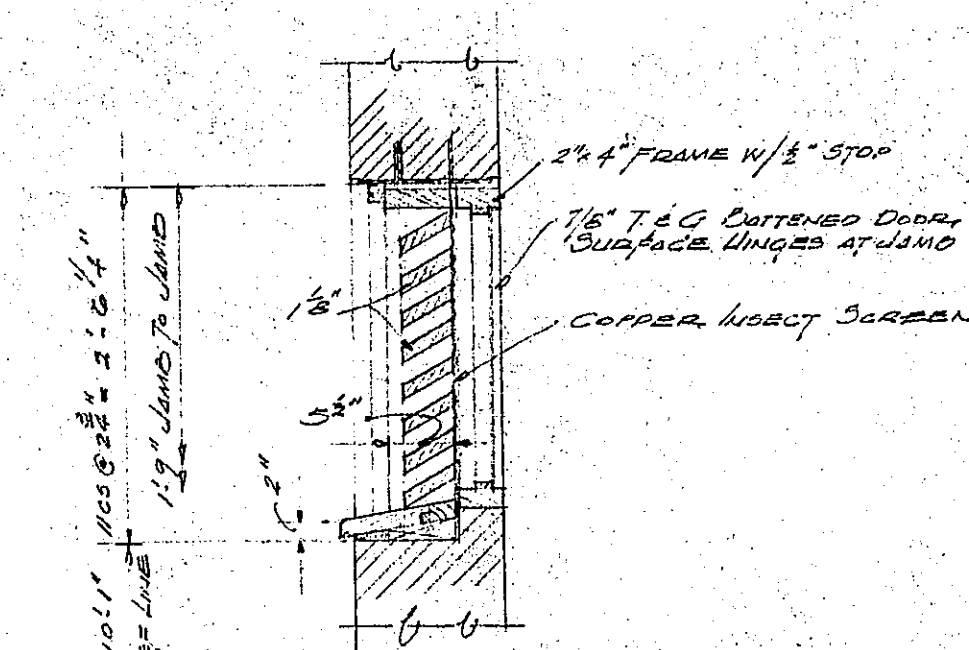


SECTION A-A 3/4"=1'-0"

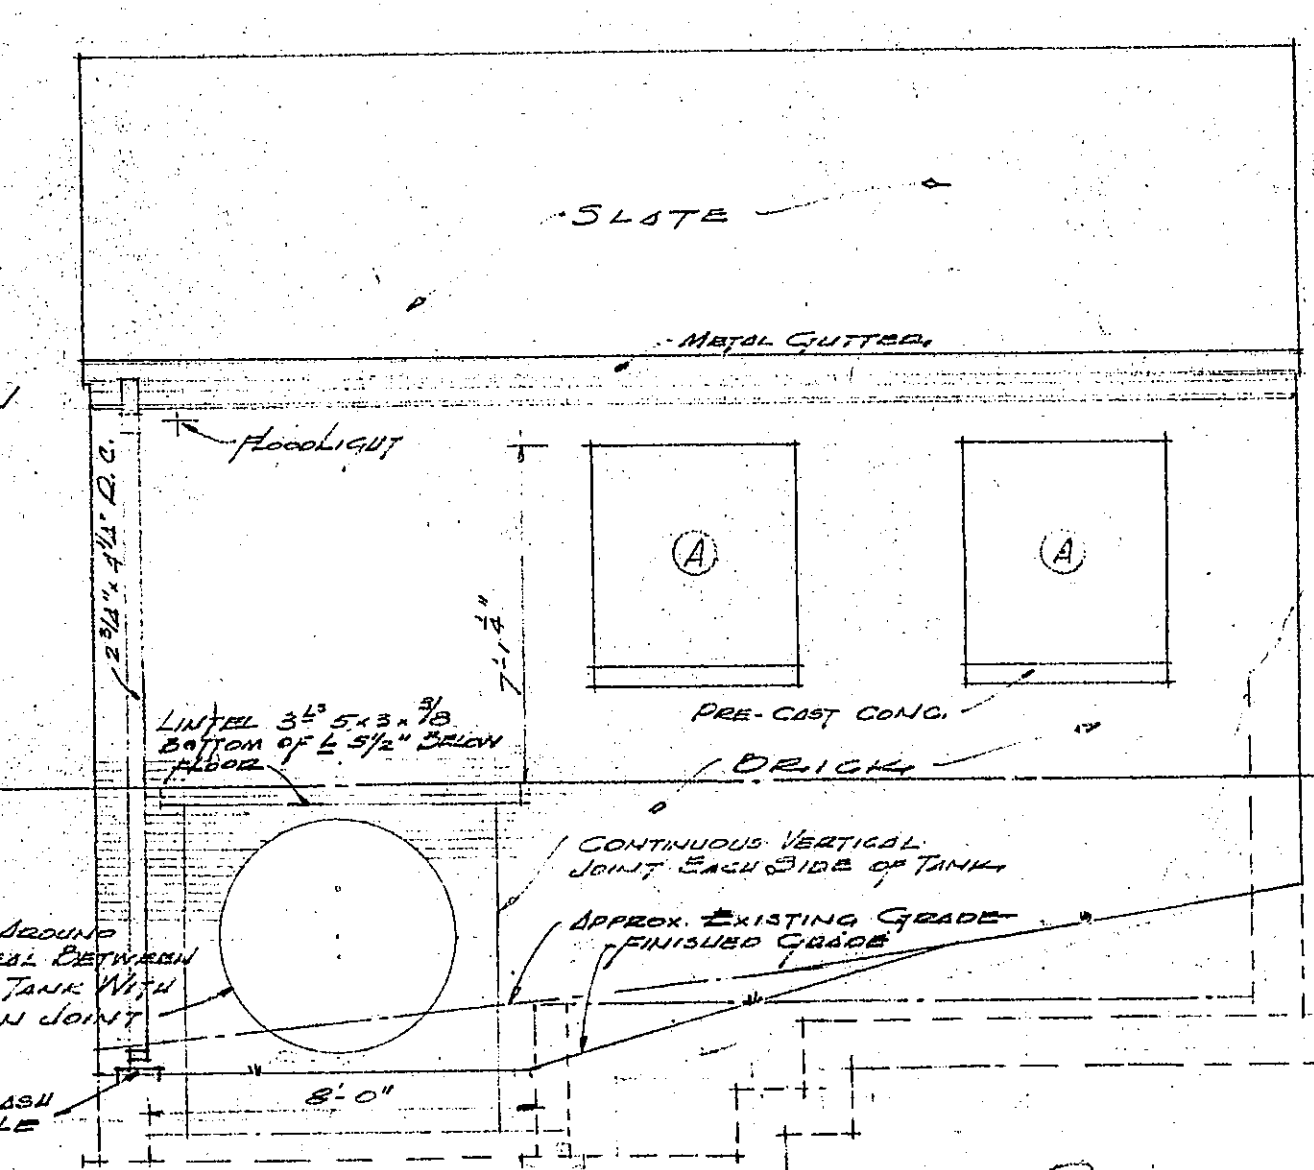


REAR


ELEVATIONS 1/4"=1'-0"

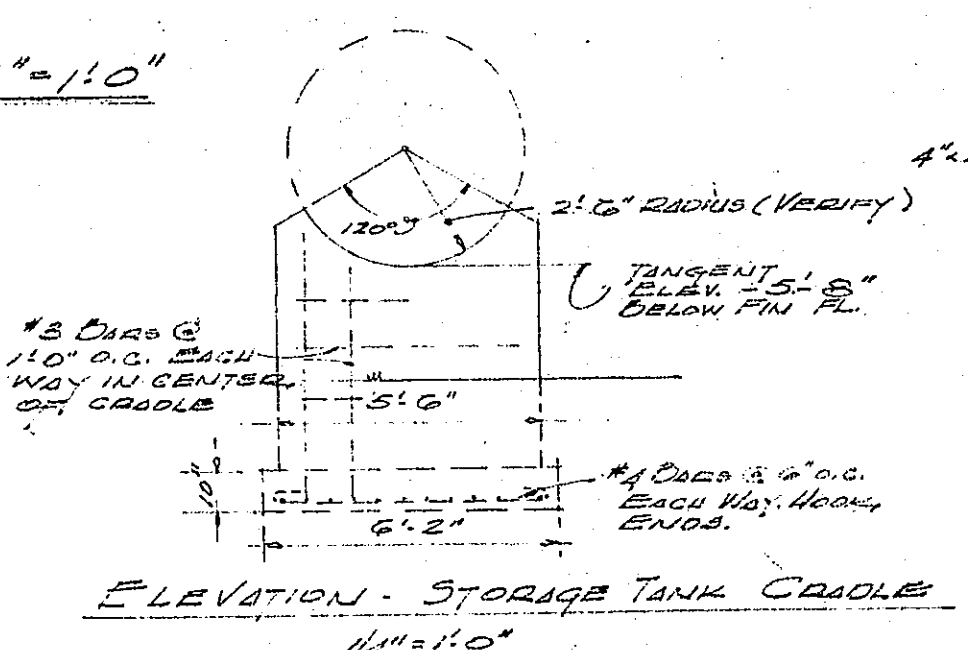

ELEVATION - STORAGE TANK CRADLE 1/4"=1'-0"

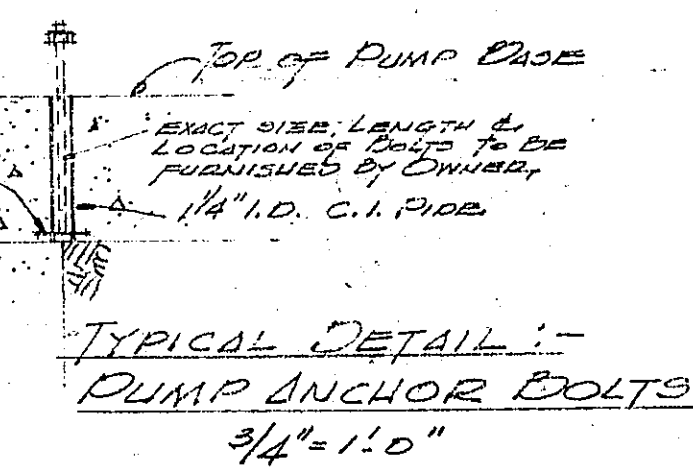

TYPICAL DETAIL - PUMP ANCHOR BOLTS 3/4"=1'-0"

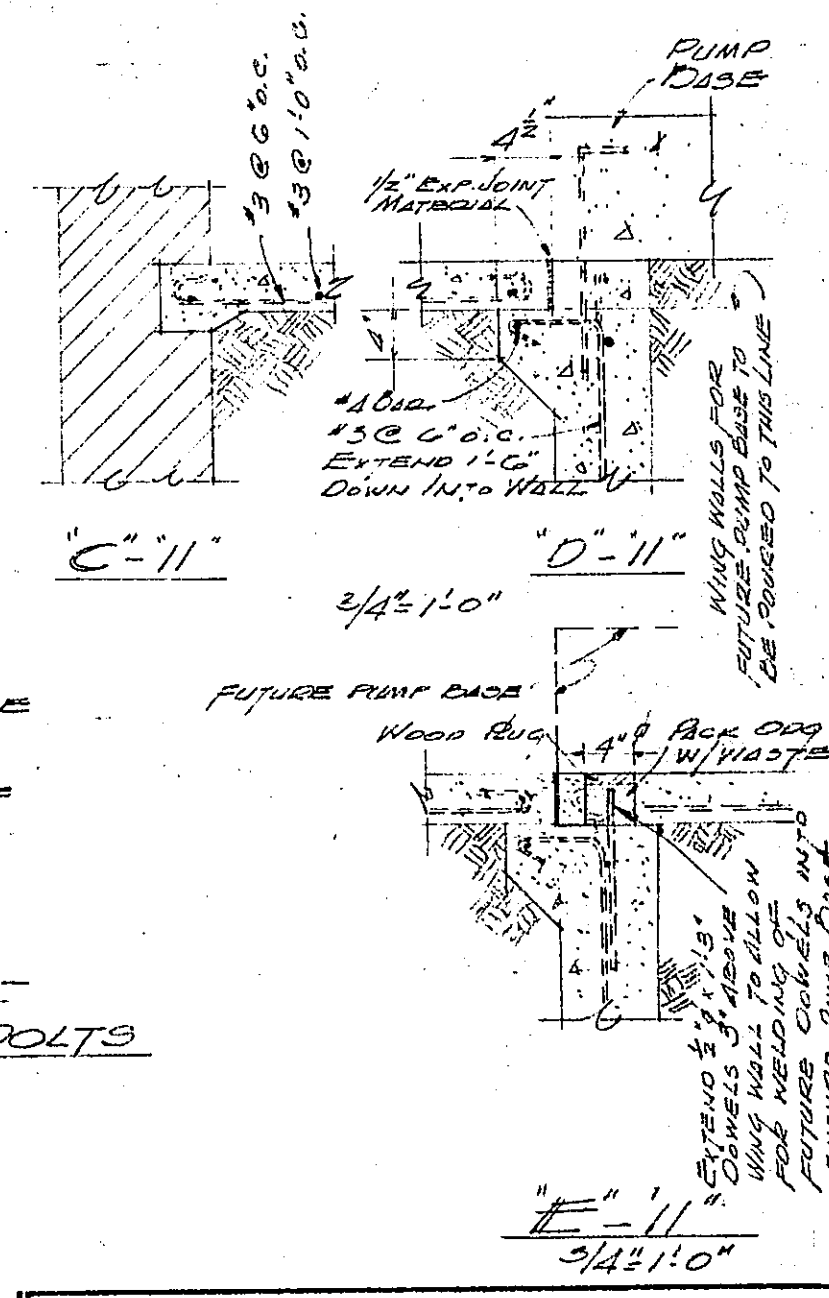

"E" 11" 3/4"=1'-0"

STRUCTURAL NOTES
1. ALL OPENINGS, NOT OTHERWISE NOTED, TO HAVE ANGLE LINTELS, 1/2" x 3/4" x 1/4" FOR EACH 2" OF MASONRY.
2. FOOTINGS ARE TO BE AT LEAST 3'-0" BELOW EXISTING GRADE & 2'-0" BELOW GRADE WHERE FULL OCCURS & IN ALL CASES ON FIRM BEARING.
LEGEND & MATERIAL SYMBOLS
CONCRETE
EARTH
BRICK

PEAKWOOD DRIVE BOOSTER PUMP STATION FOR CITY OF ROANOKE WATER DEPT. ROANOKE, VIRGINIA

SHEET NO. **1** ARCHITECTS AND ENGINEERS **SMITHEY & BOYNTON** ROANOKE, VIRGINIA
REVISION DATES
DATE **OCT 20, '54**