
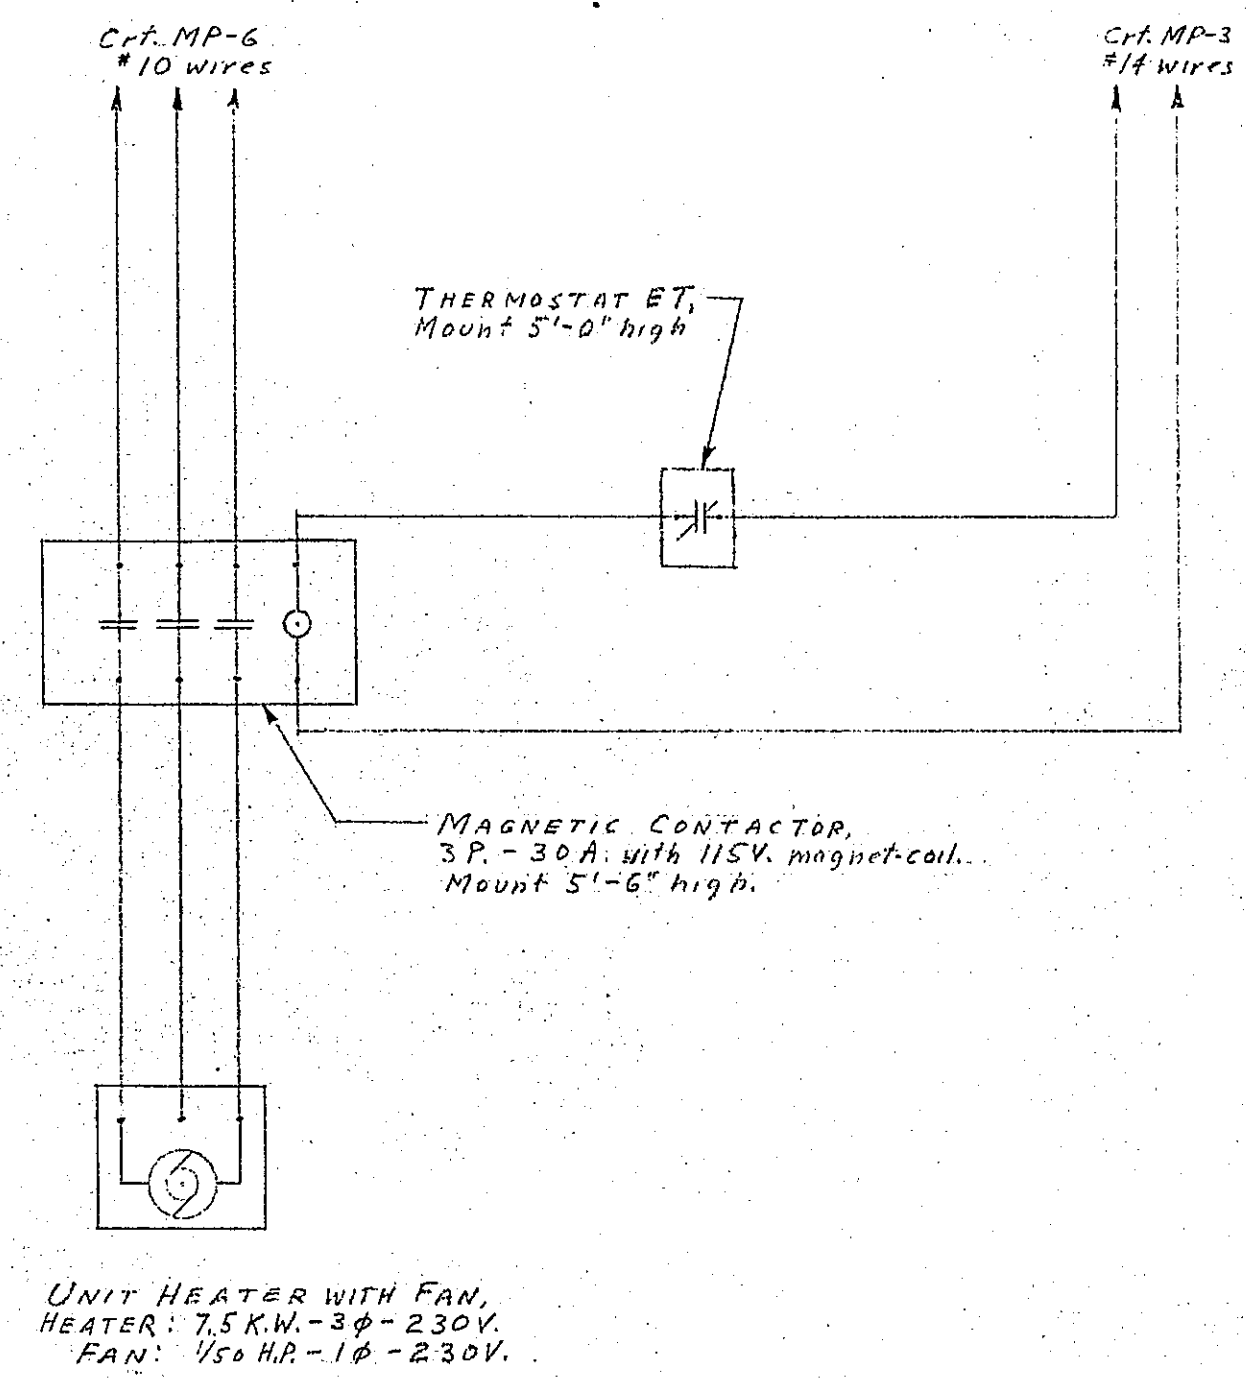
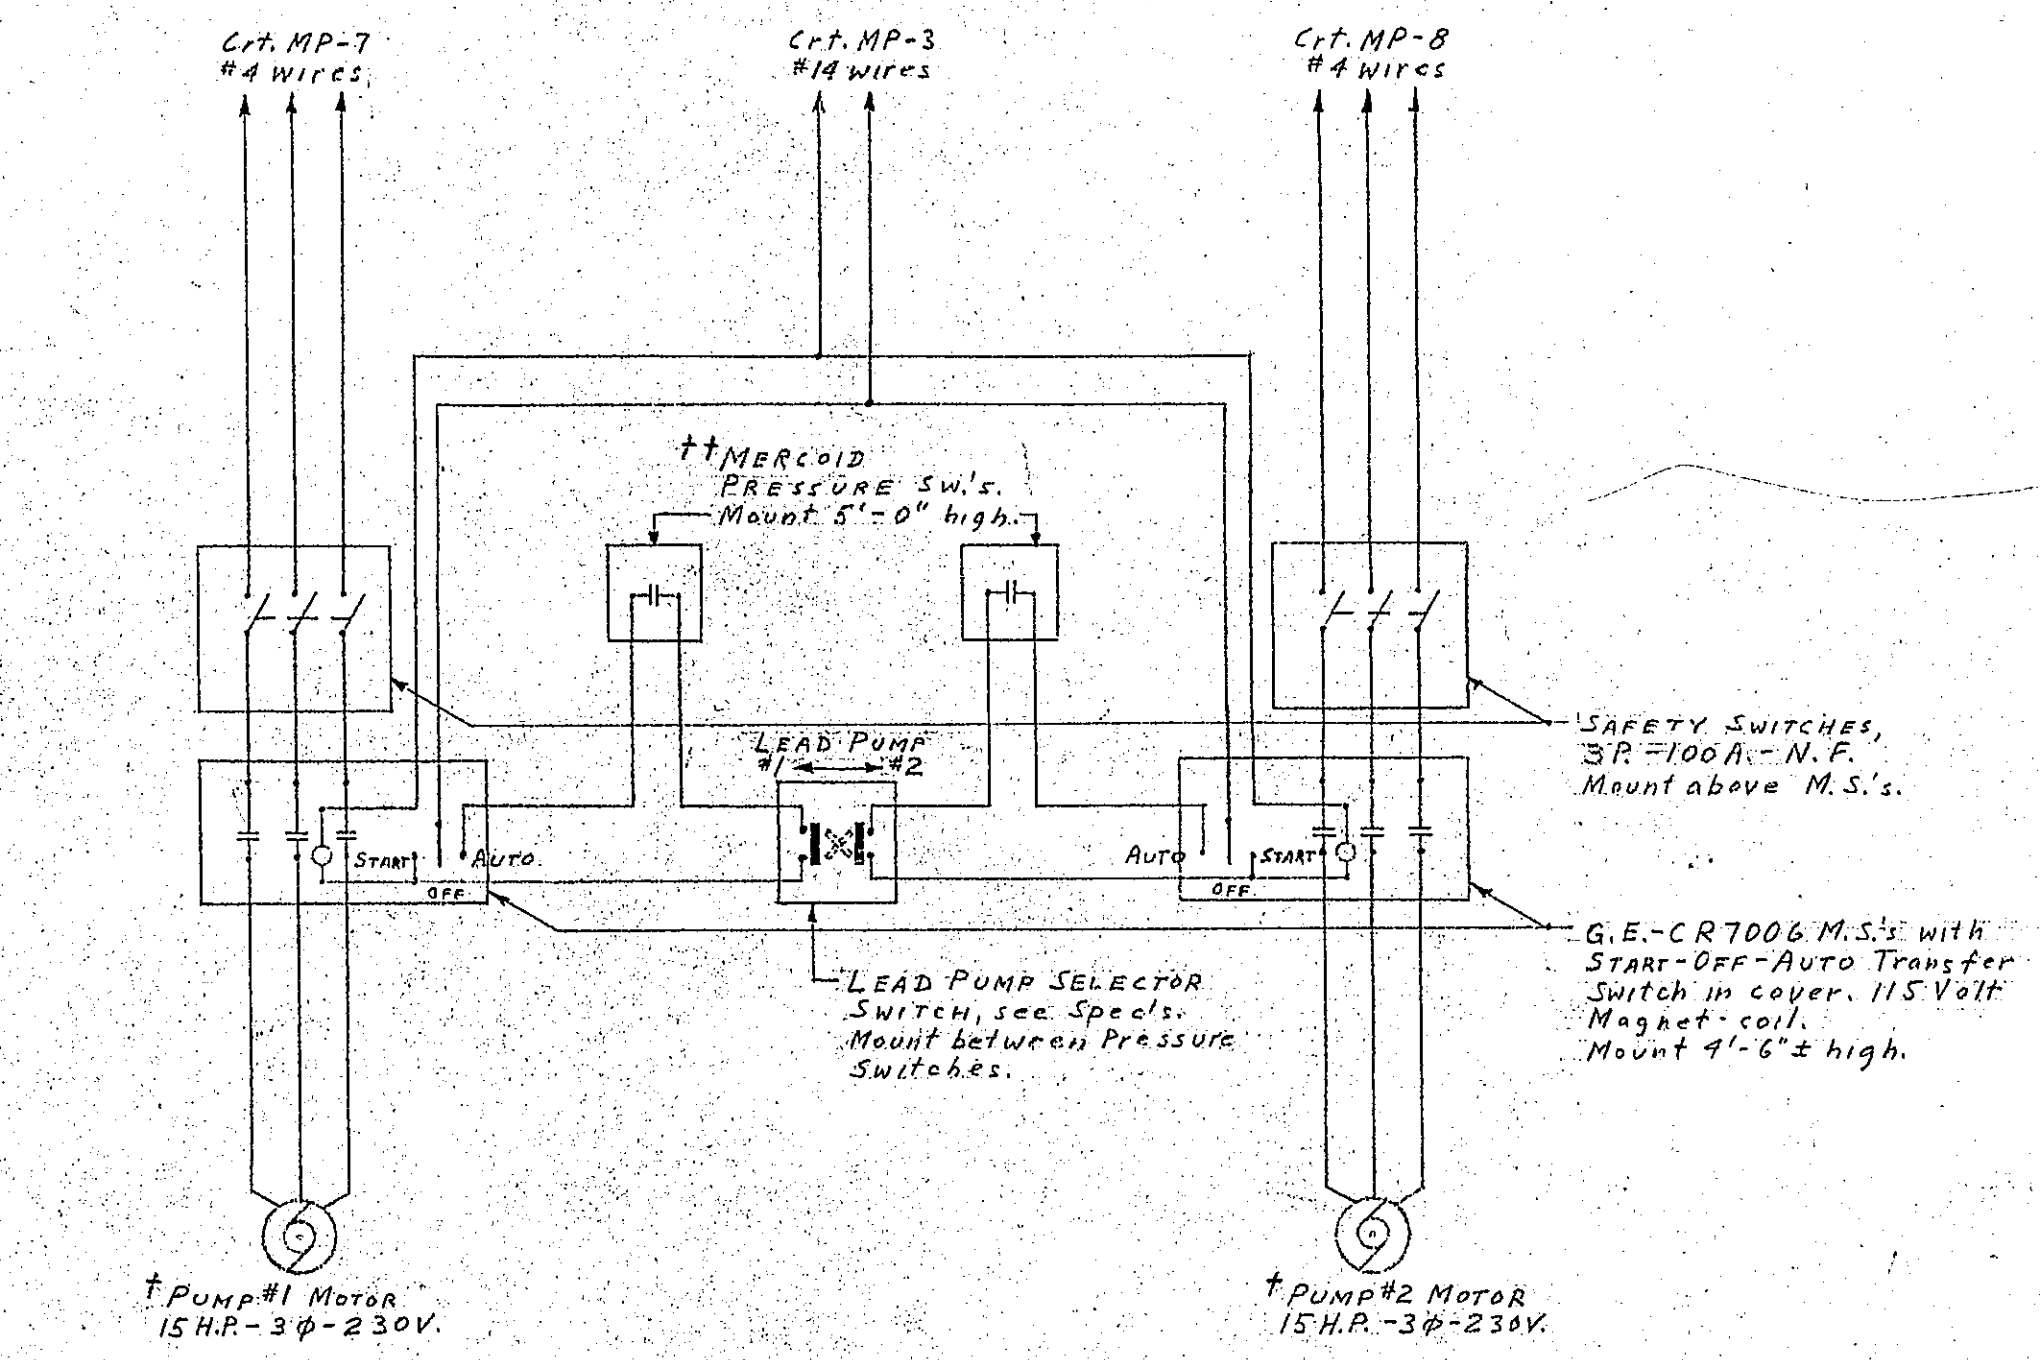
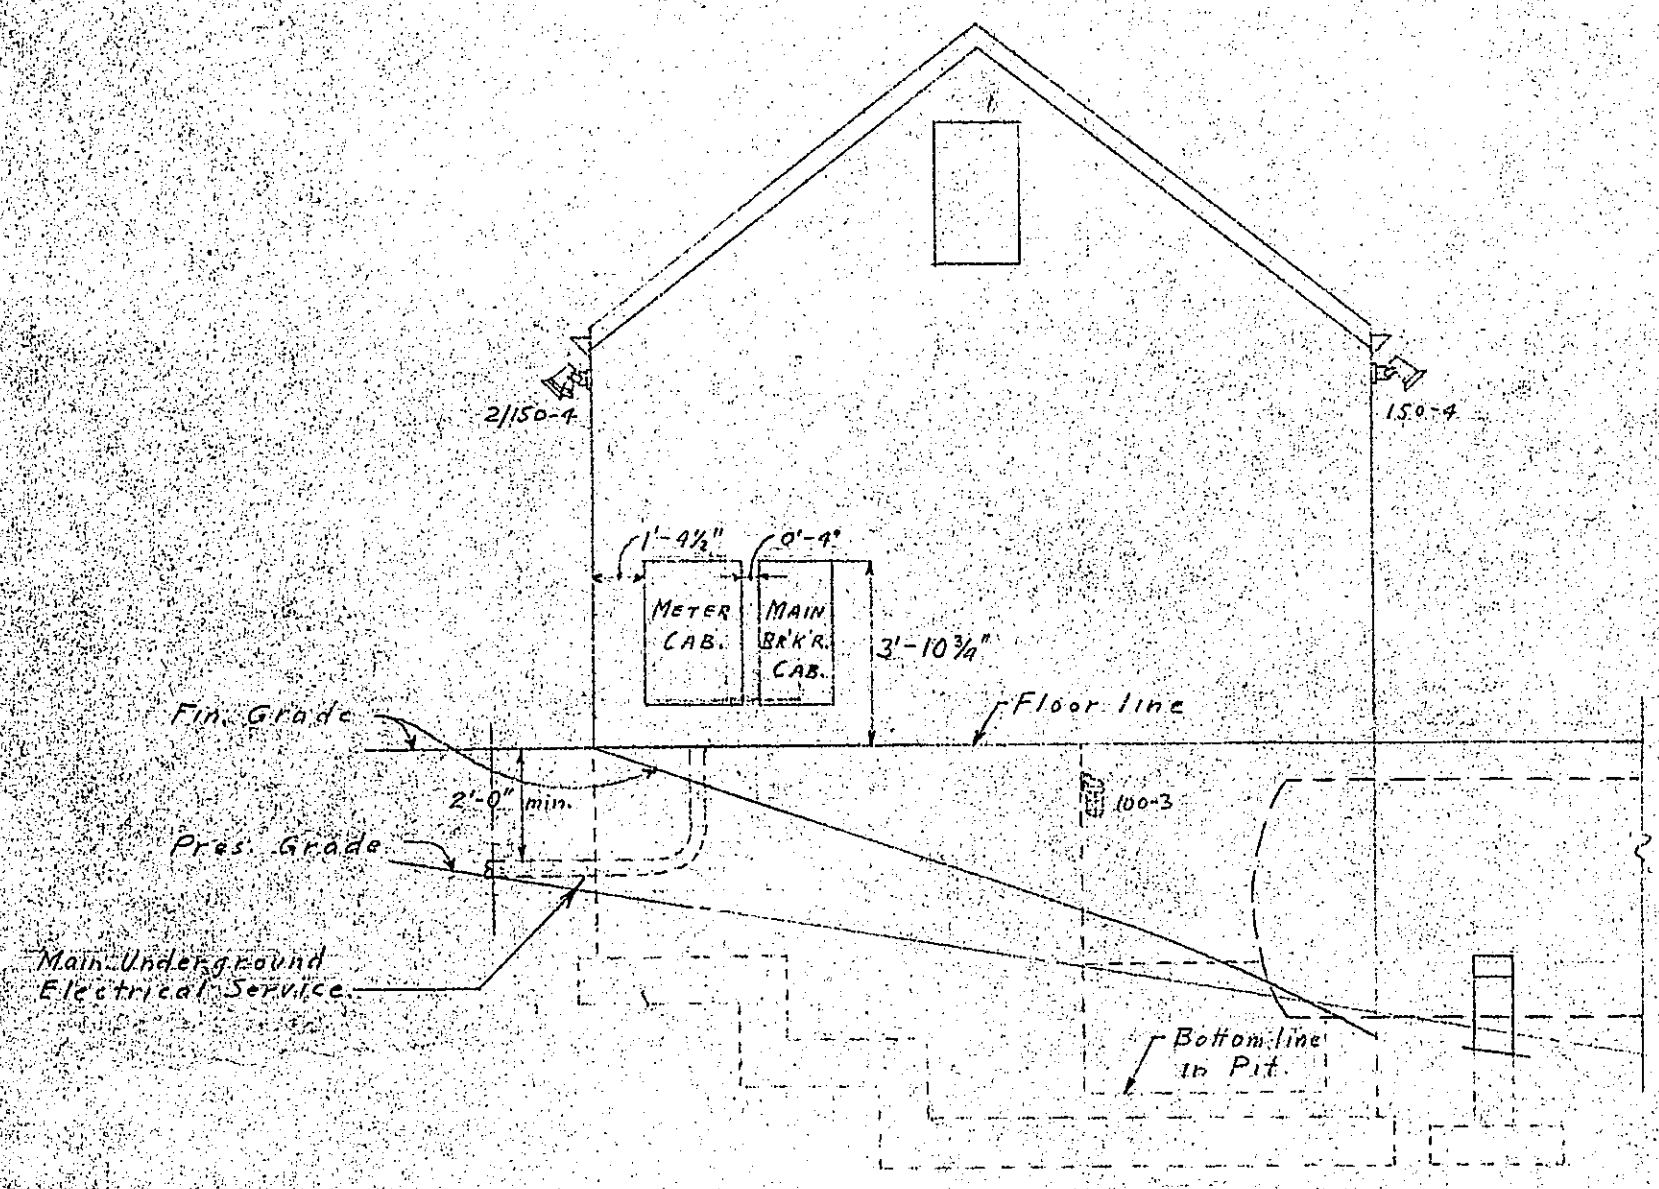
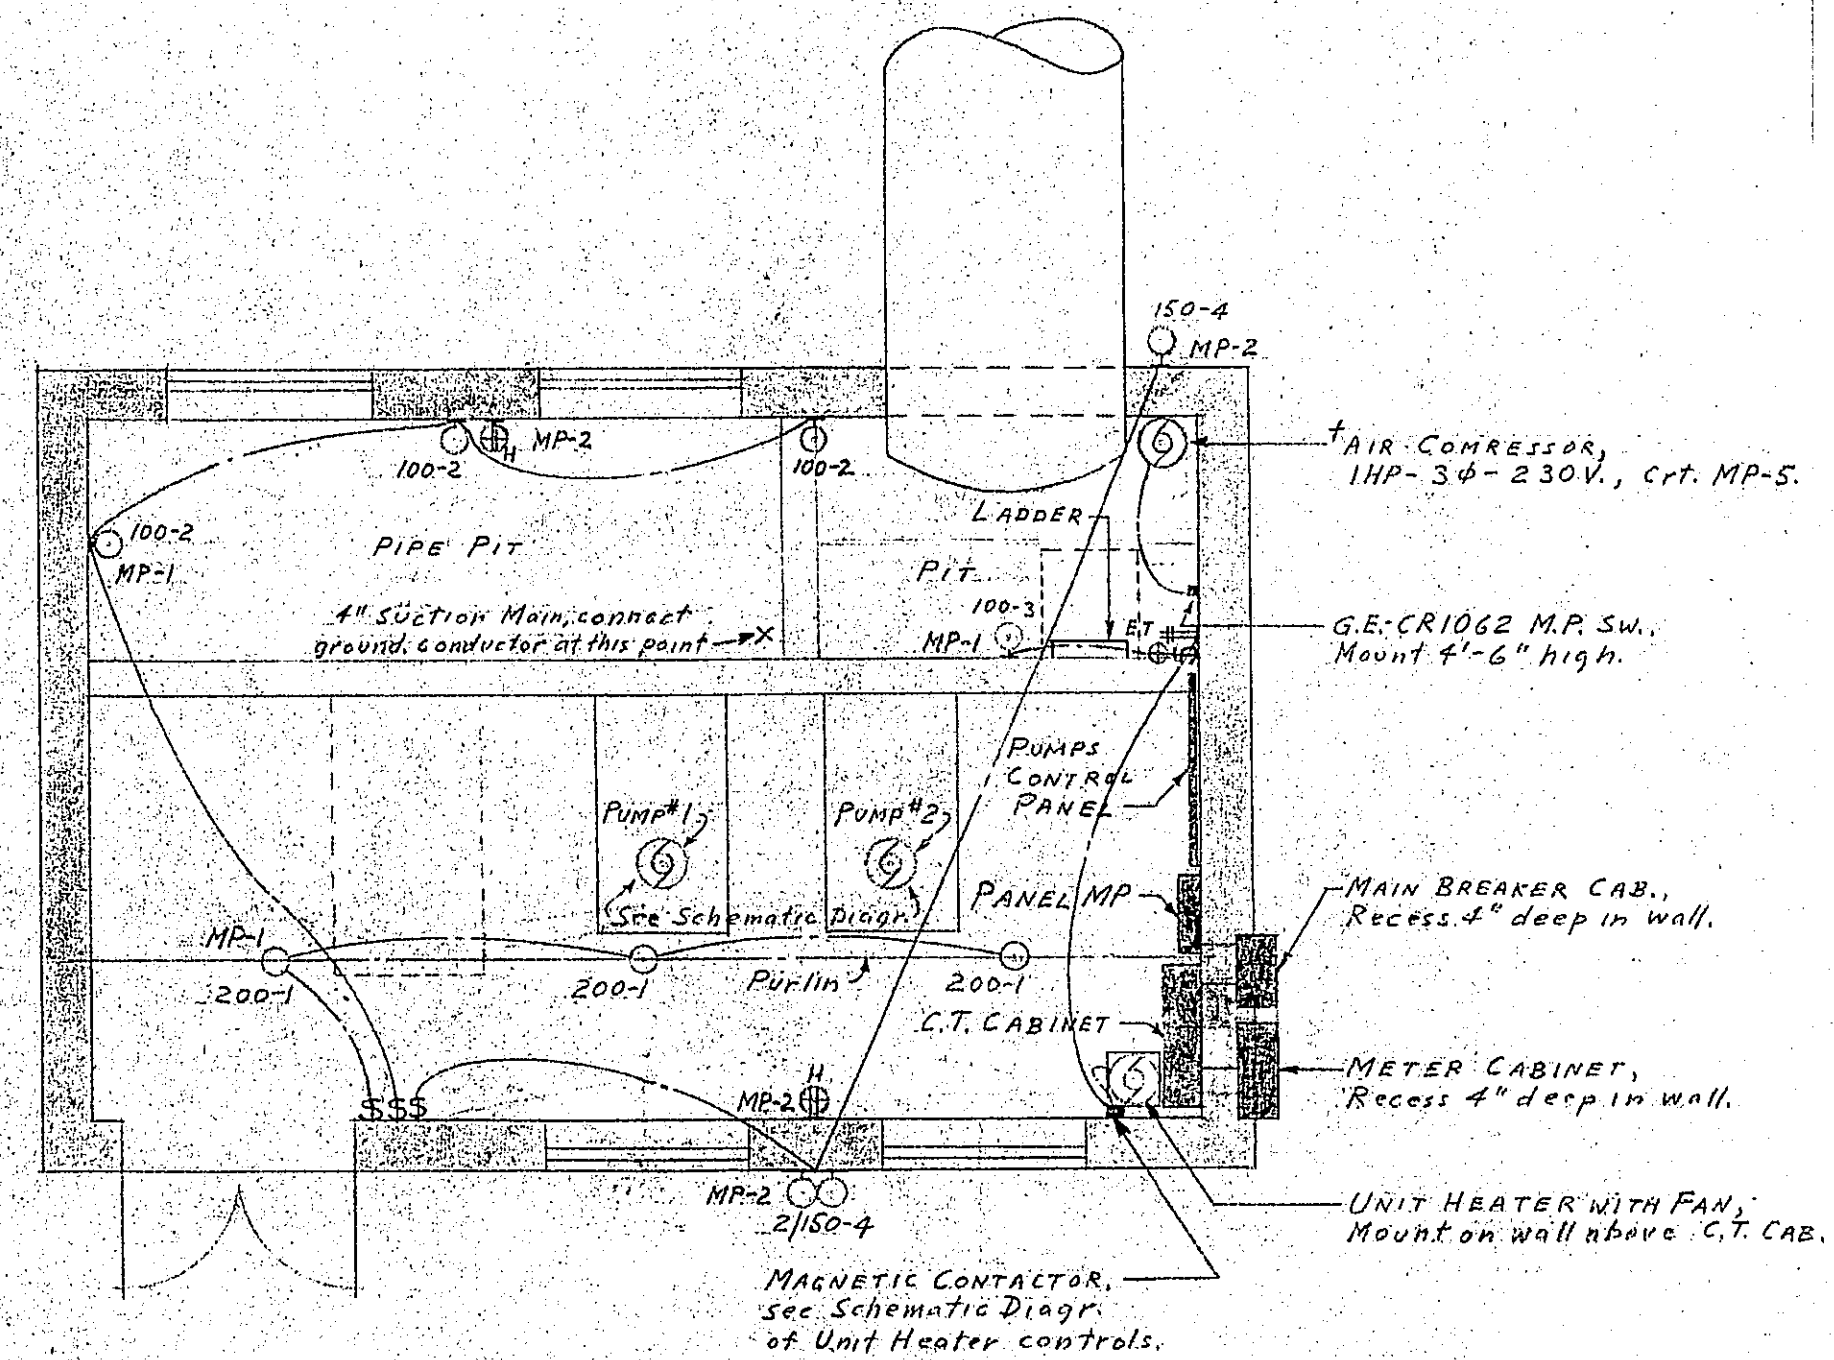


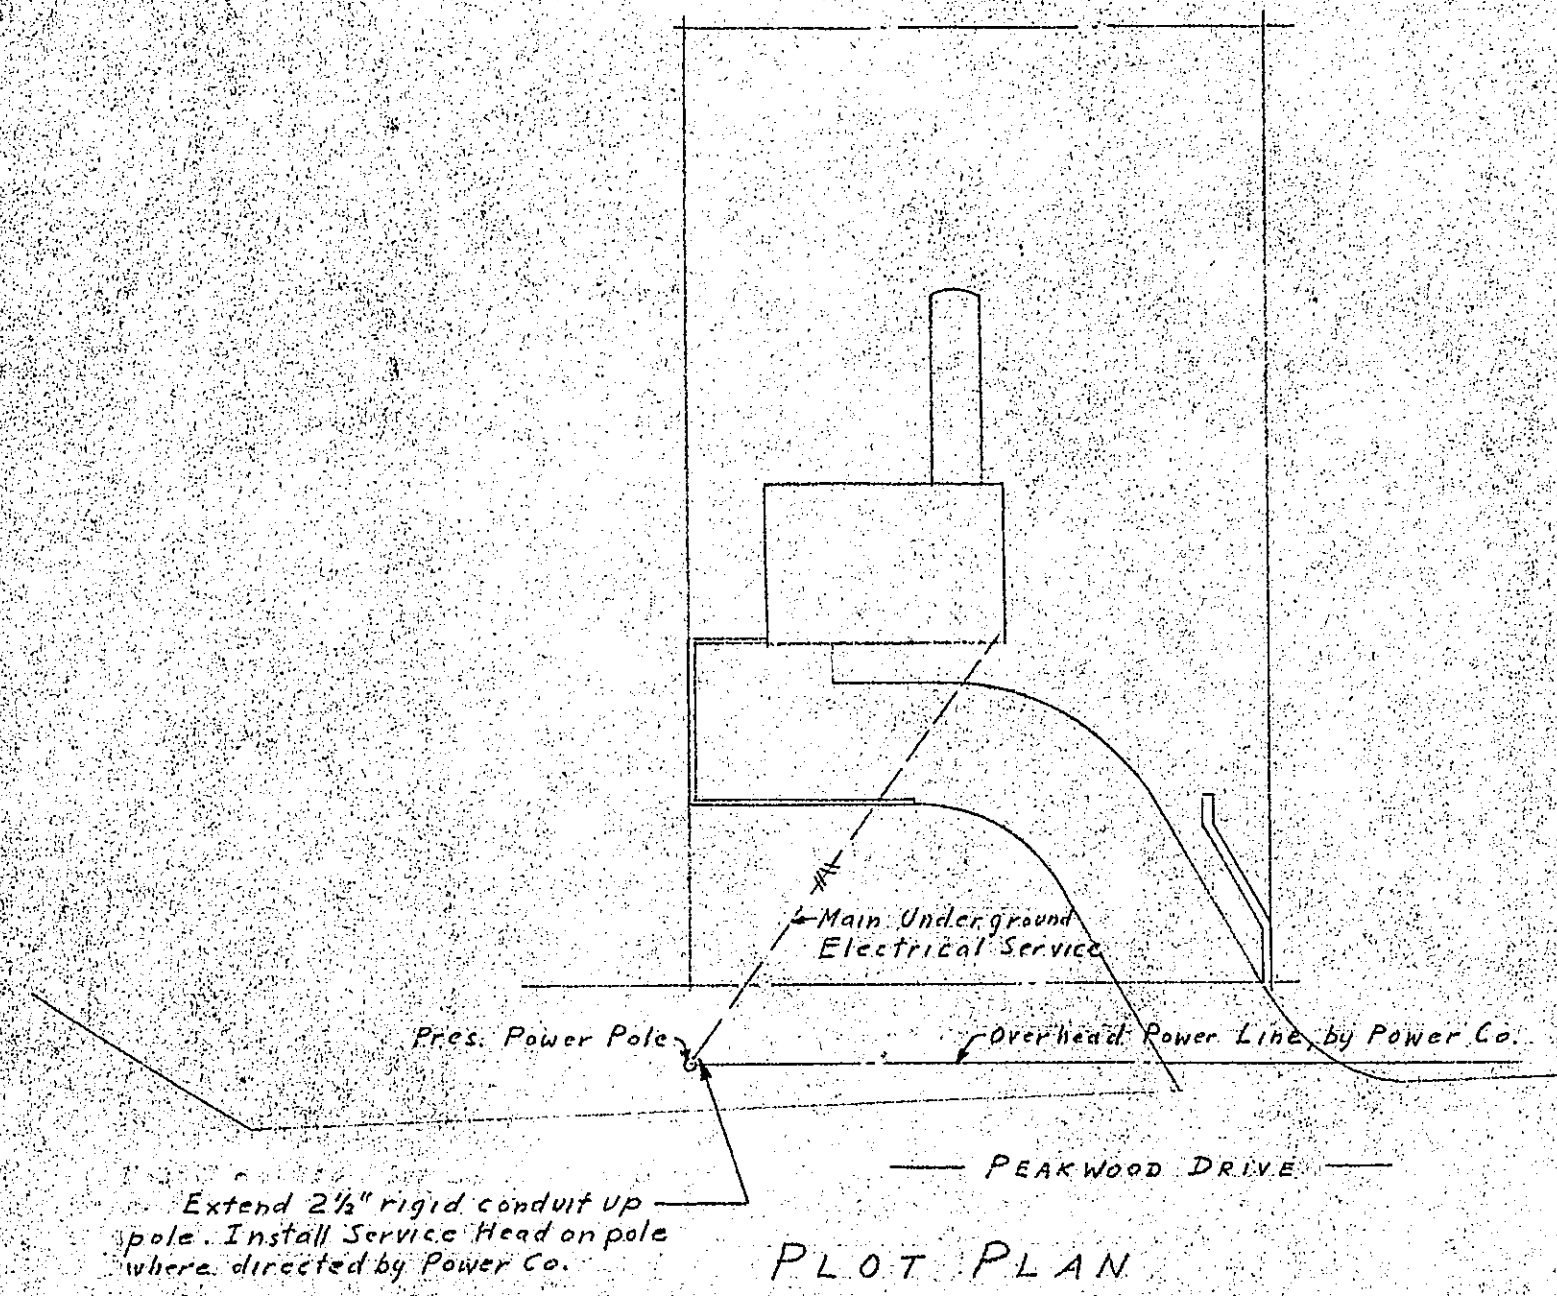

NOTES:
+ — By Others
++ — f.o.b. by Others
Mount all Controls for pumps on Pumps Control Panel (see Specs.).

ELECTRICAL WORK FLOOR PLAN		
PEAKWOOD DRIVE BOOSTER PUMPING STATION FOR CITY OF ROANOKE WATER DEPT. ROANOKE, VIRGINIA		
SHEET NO.	SMITHEY & BOYNTON ARCHITECTS AND ENGINEERS ROANOKE, VIRGINIA	COMM. NO.
E-1		1049
REVISION DATES		DATE
		OCT. 20, 1954