



TYPICAL WALL SECTION
SCALE 1" = 1'

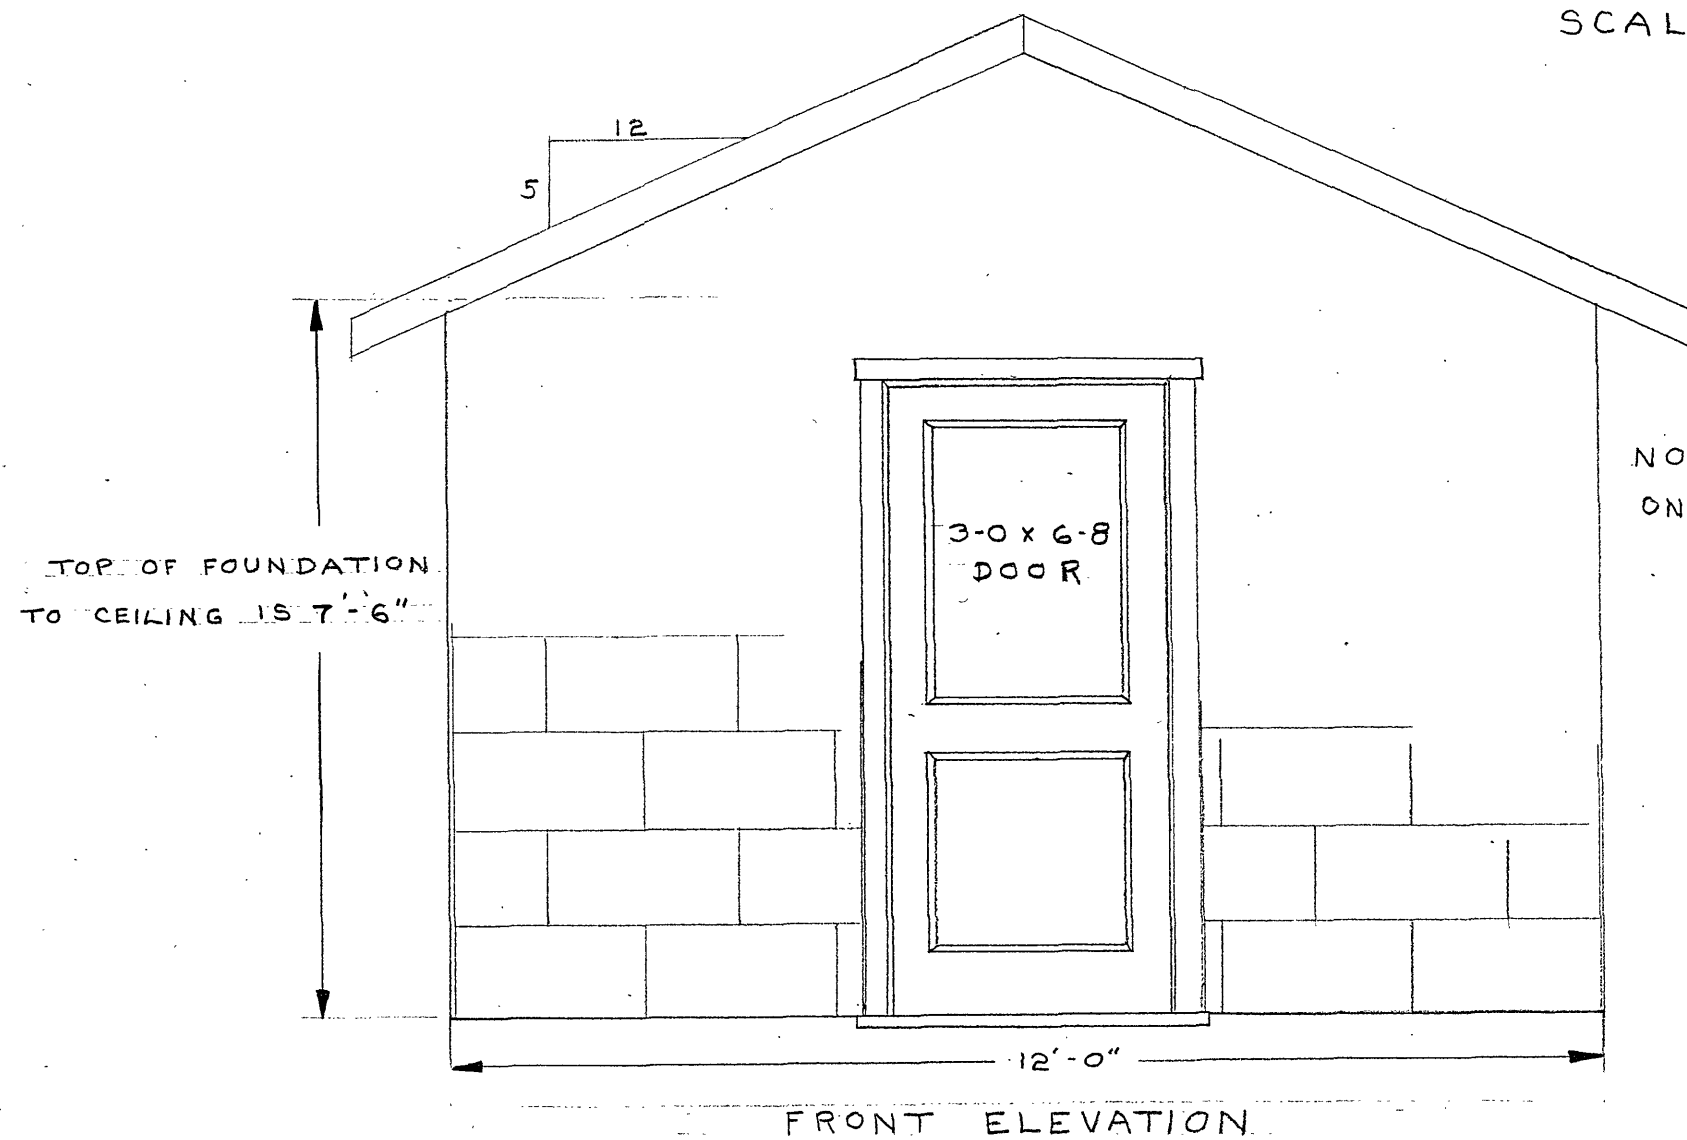

NOTE: NO WINDOW OR DOOR
ON REAR OF BUILDING

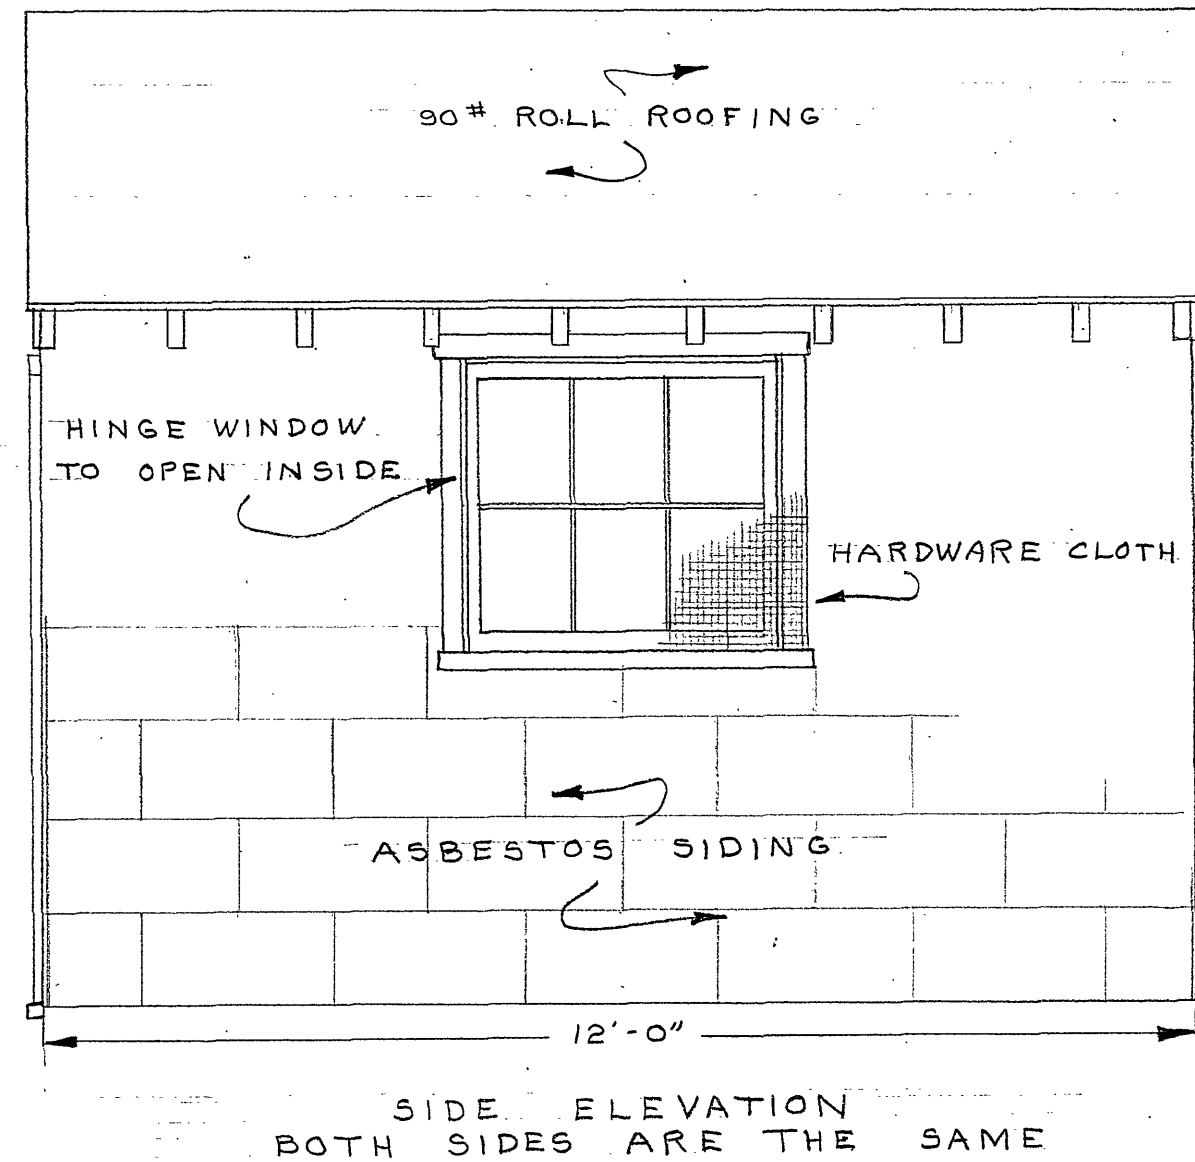

PROPOSED PUMPING STATION
JULY 10, 1958
DRAWN BY: N.H.C.

SCALE - 1/2" = 1 FOOT