


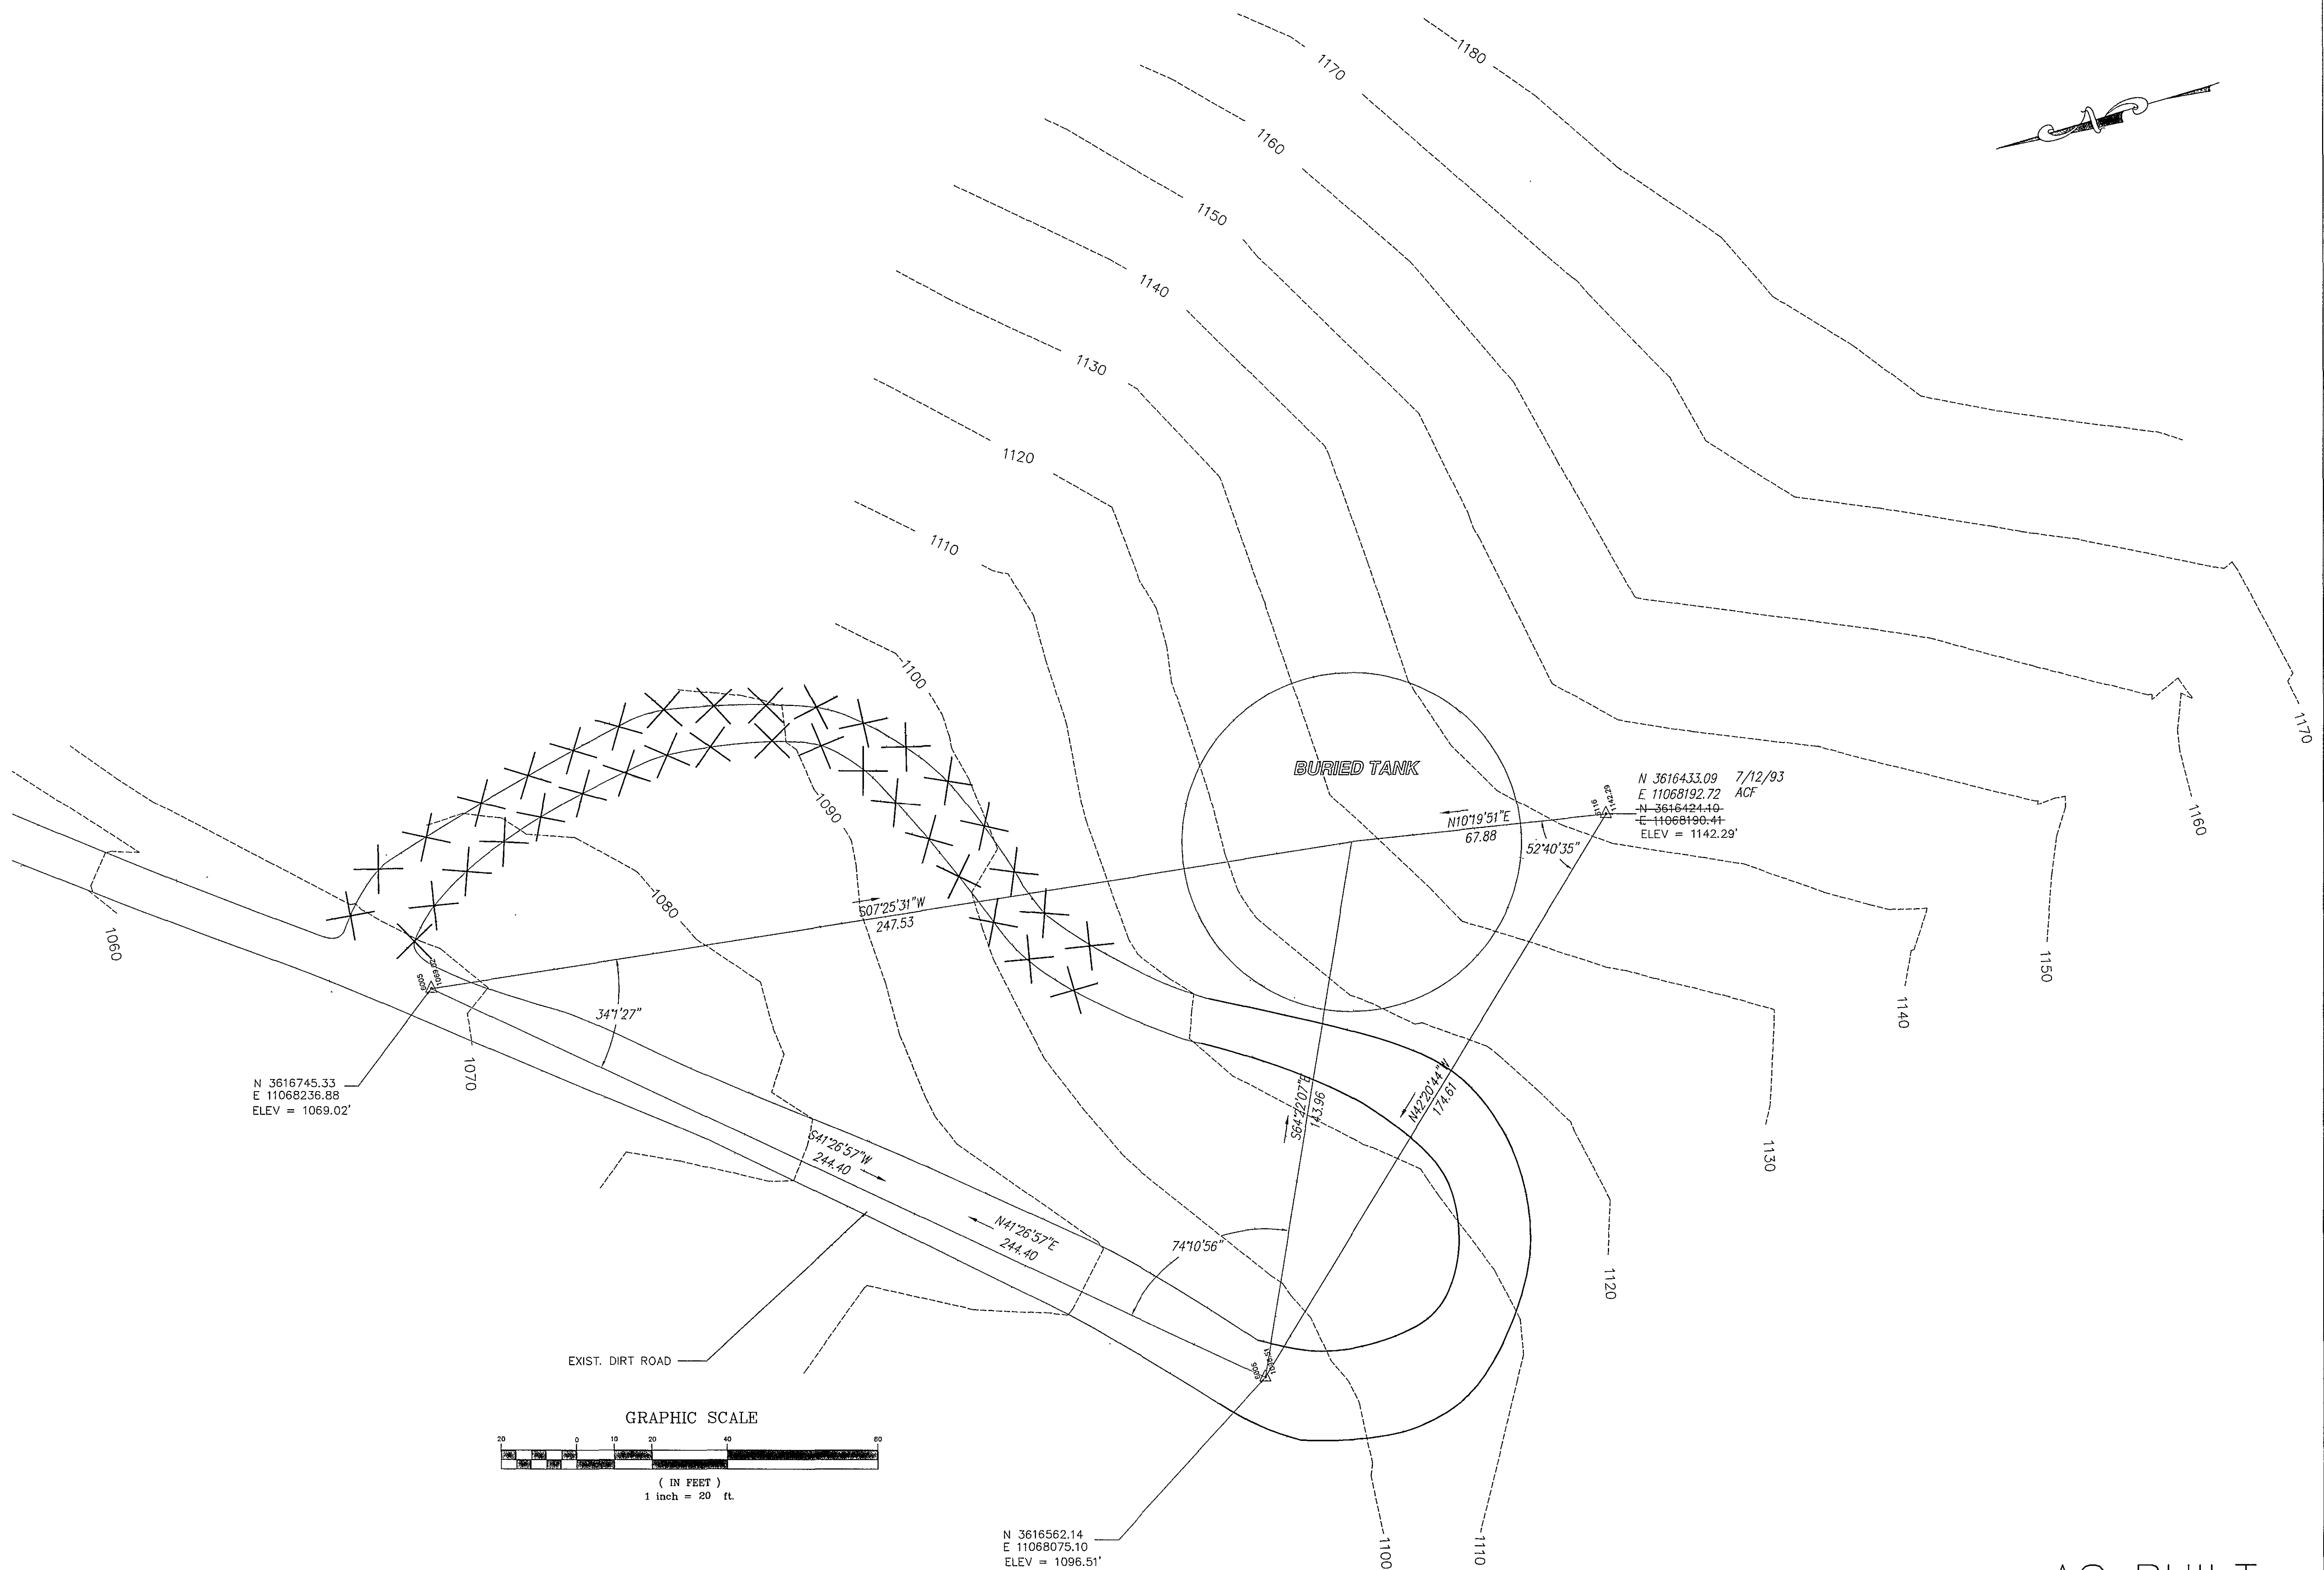

AS BUILT

WATER DEP'T. #93-25

Architects
Engineers
Planners
Surveyors

Dewberry & Davis

5238 Valleypointe Parkway, Suite One-B
Roanoke, Virginia 24019
☎ 703 962-7725

Carvins Cove, Phase II
City of Roanoke
Roanoke, Virginia

CONTRACT "C2"
MILL MOUNTAIN
GROUND STORAGE TANK
SITE PLAN

Drawn By ACF

Designed By RBS

Checked By SEH

Date
MARCH 93

Scale
1" = 20'

Plan Number
TESTMMTS

Zoned
NONE

Sheet
19 of 25

File Number
C1160