




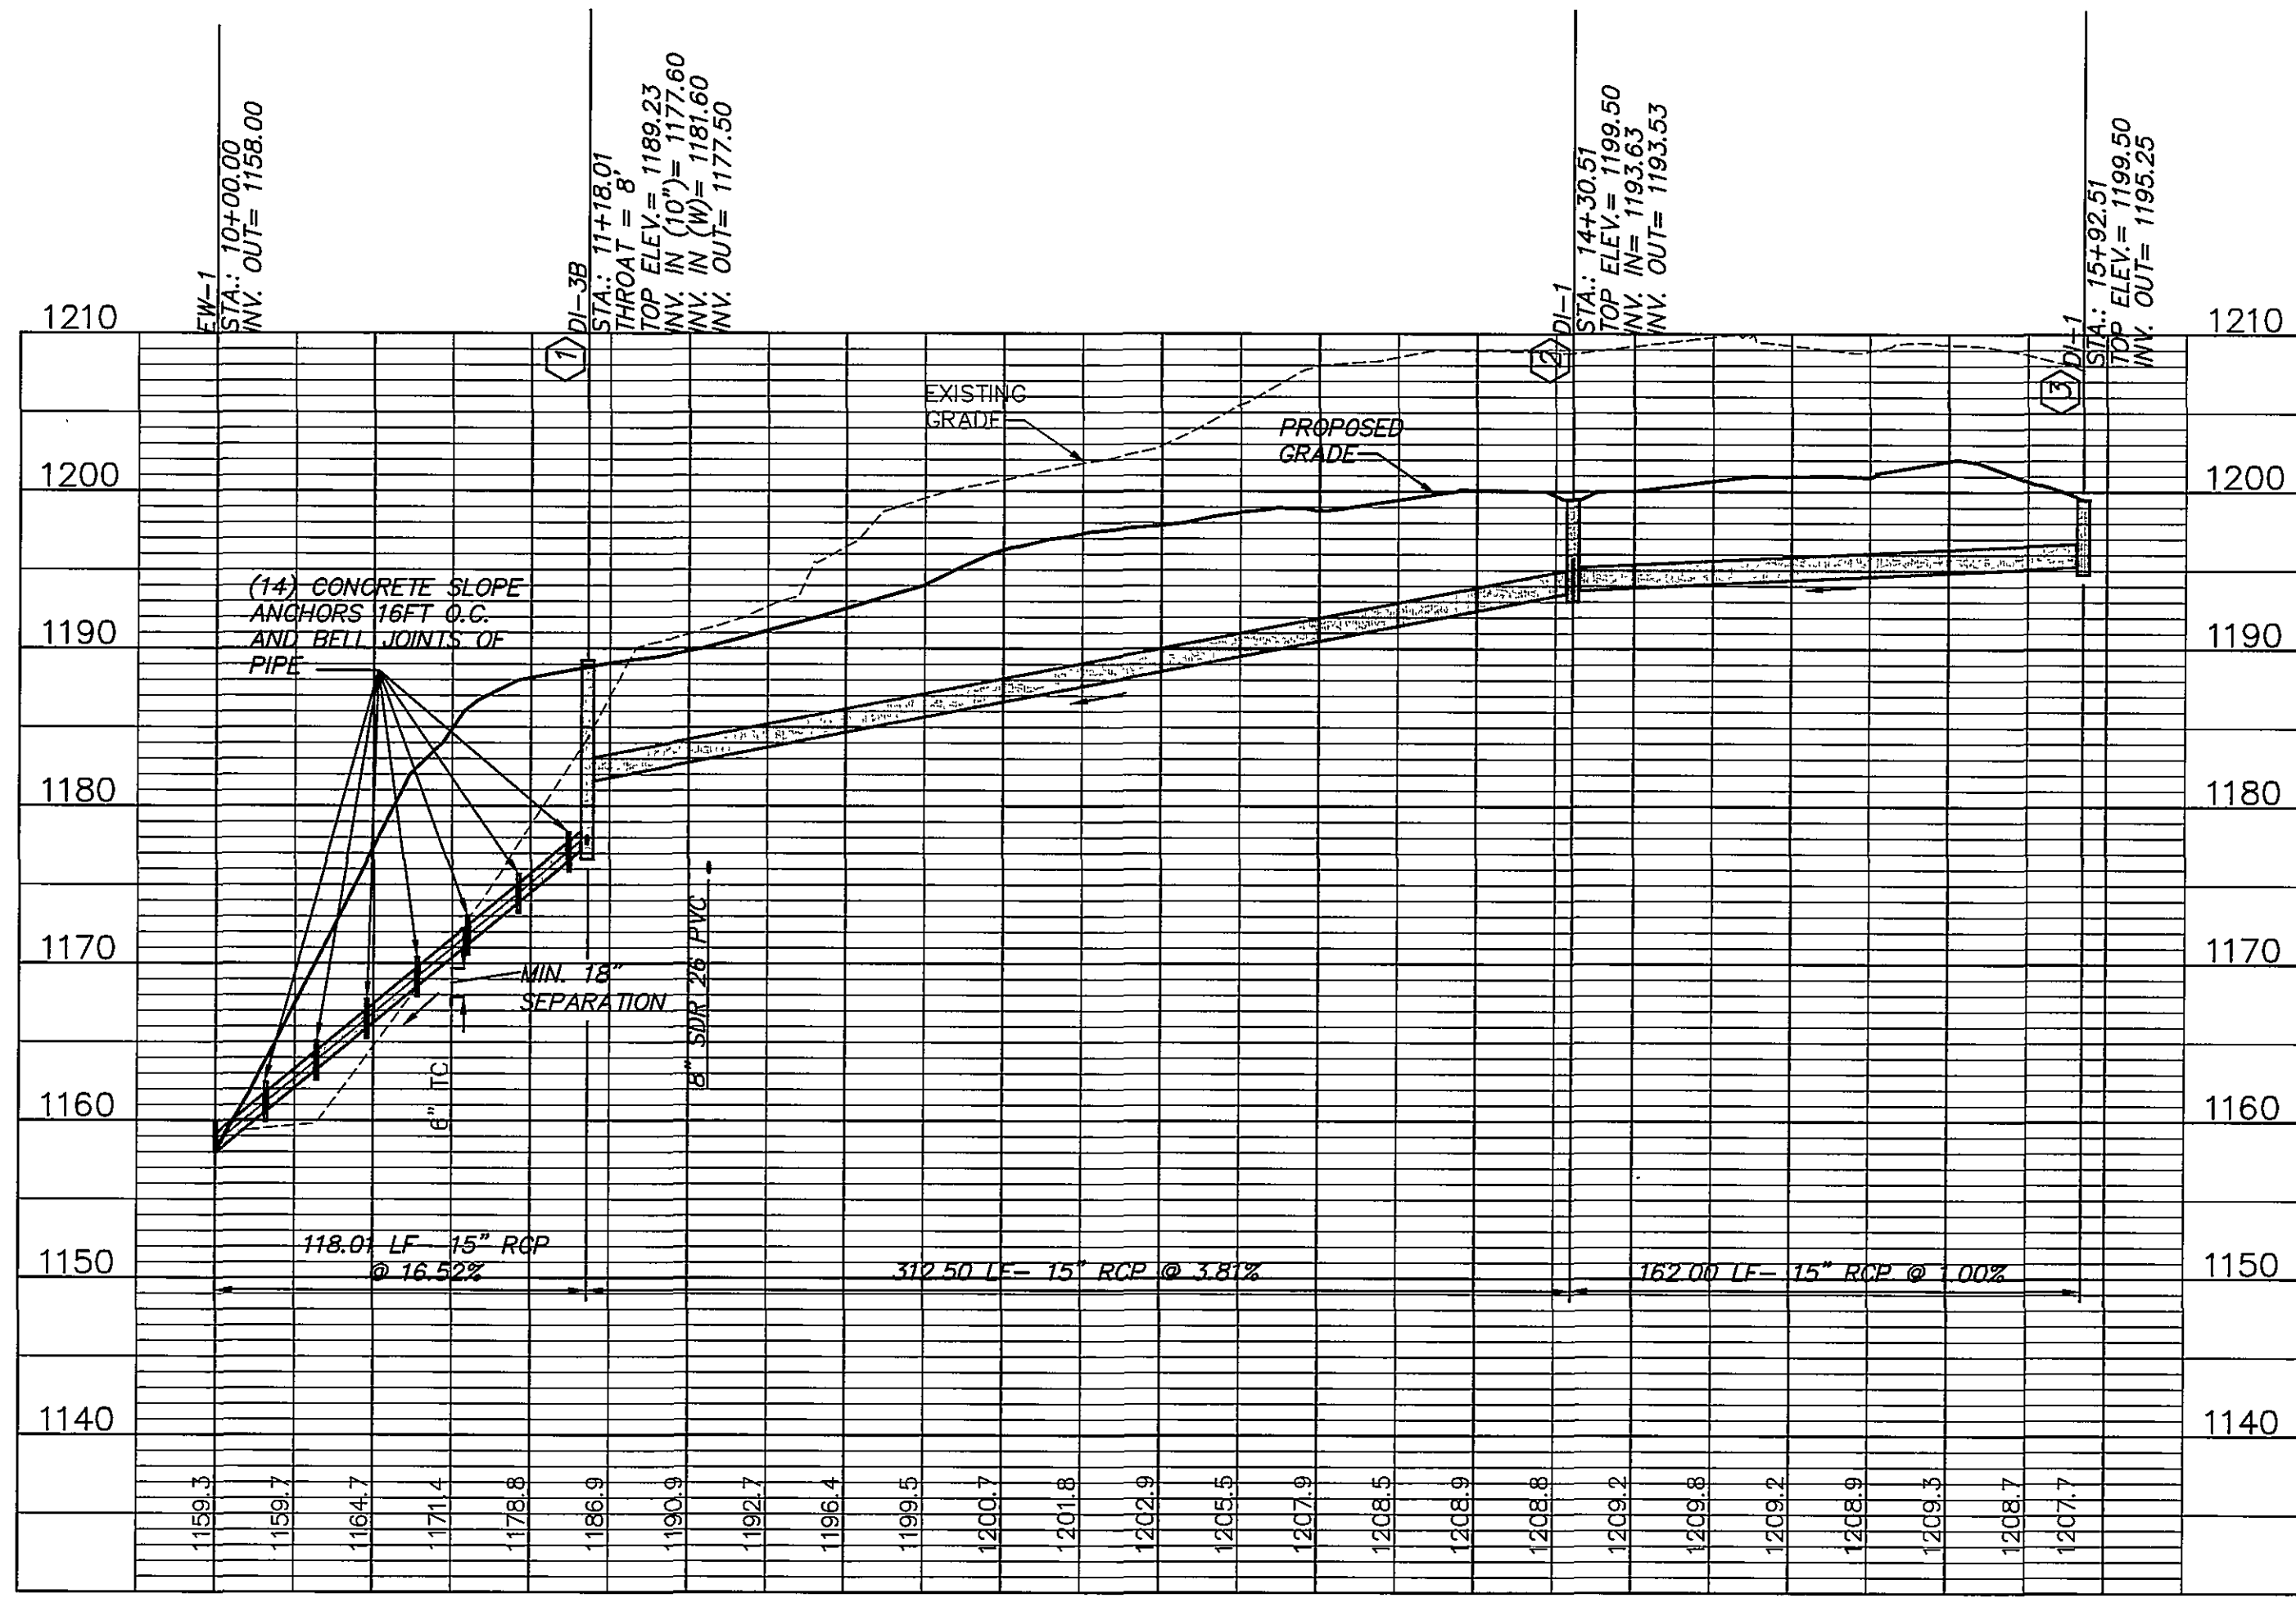


STORM WATER LINE A

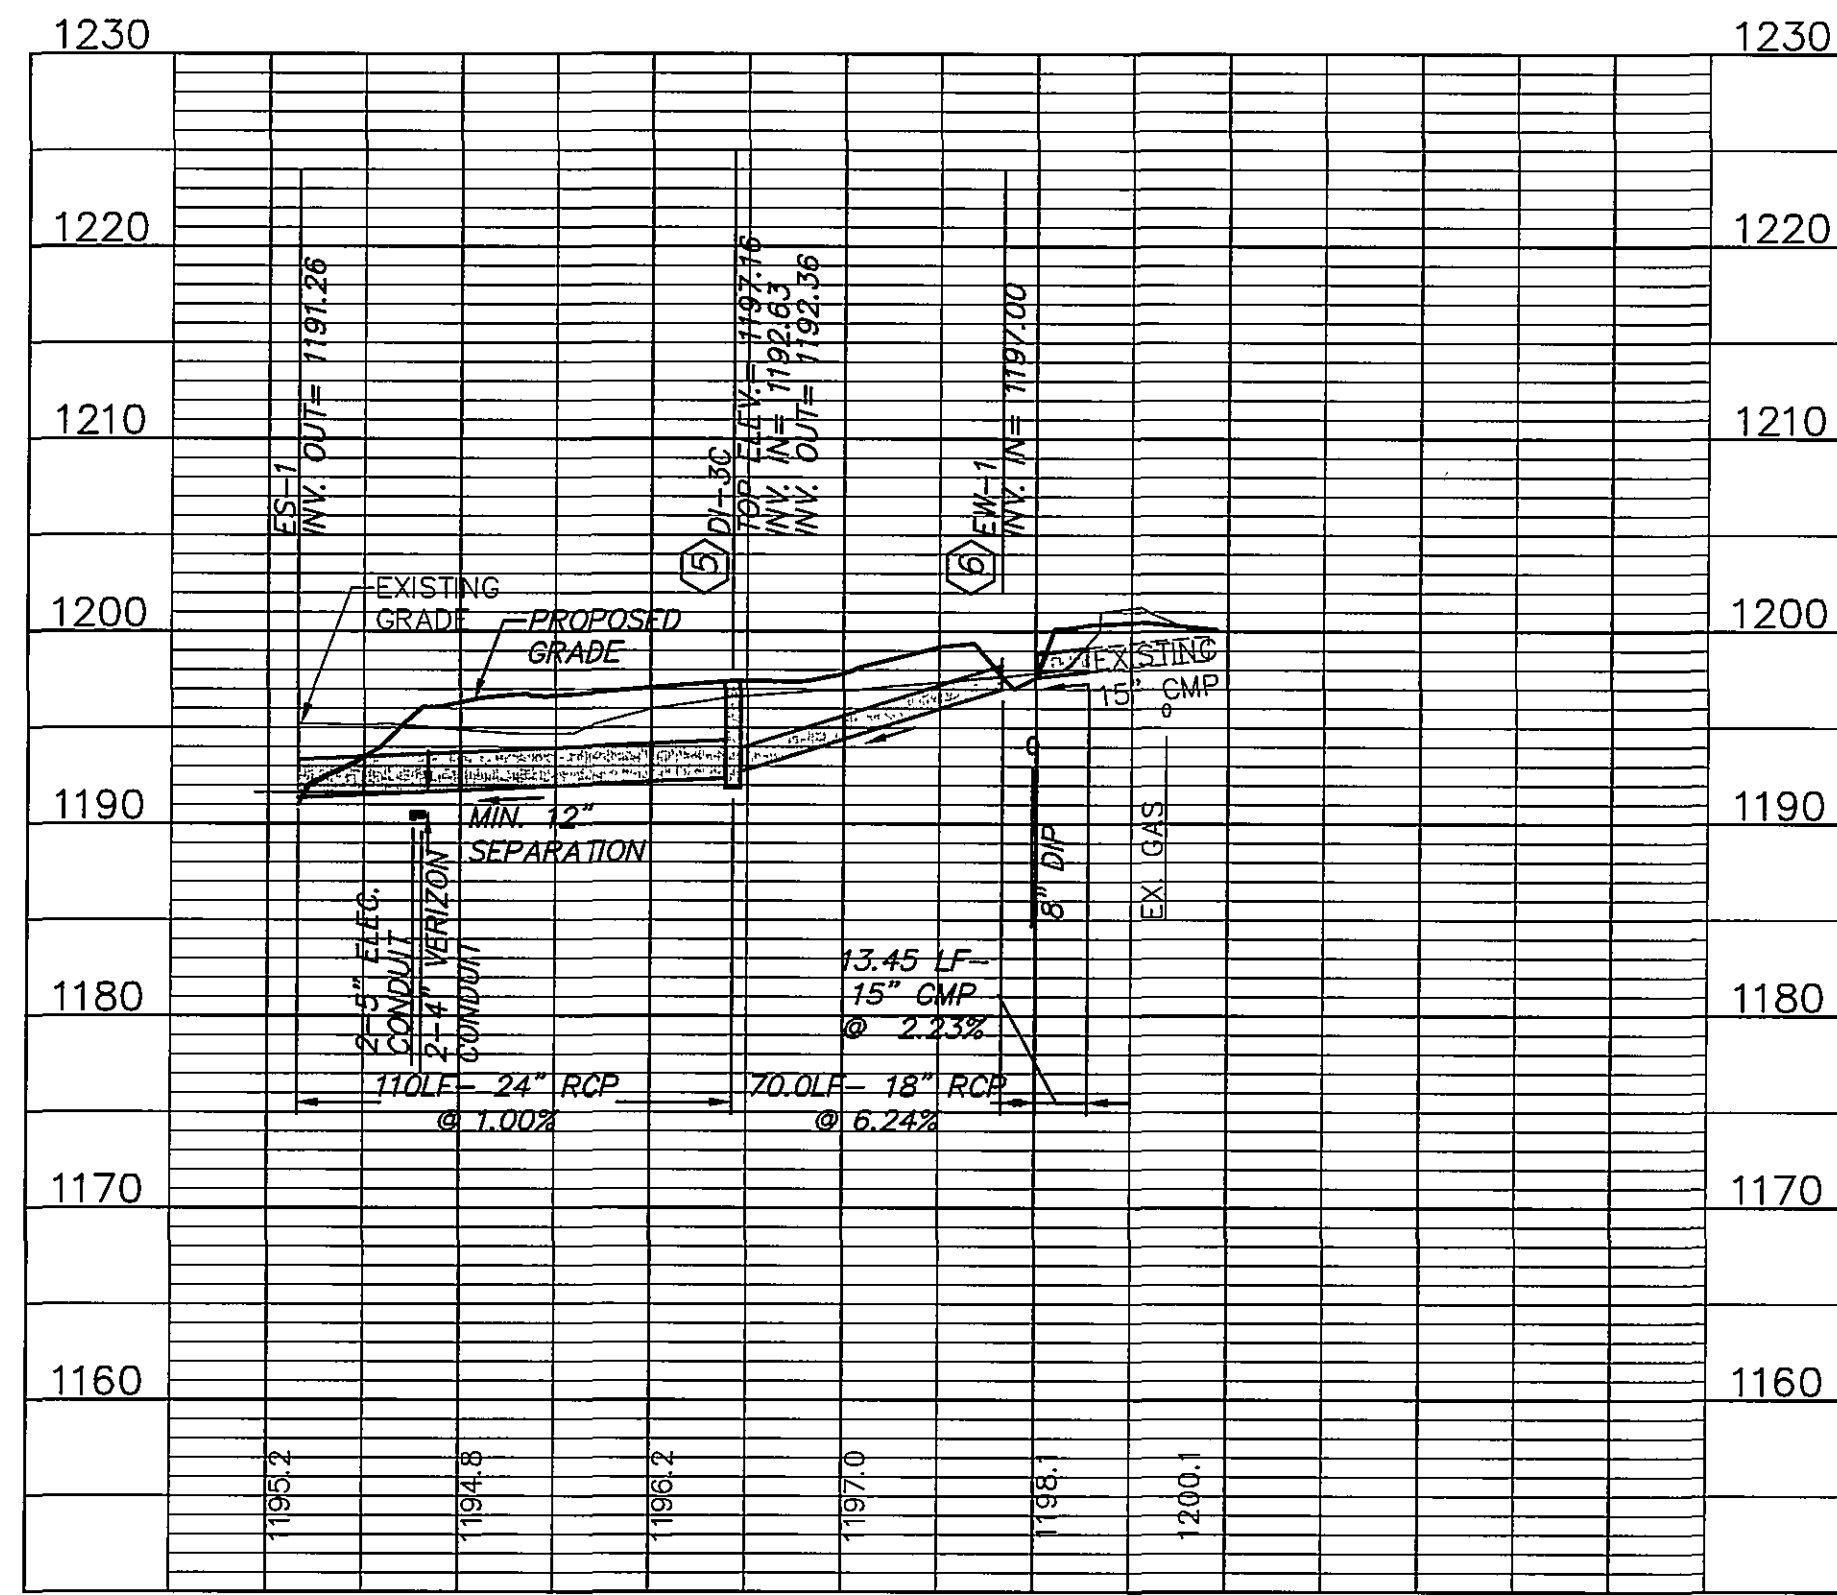


STORM WATER LINE B

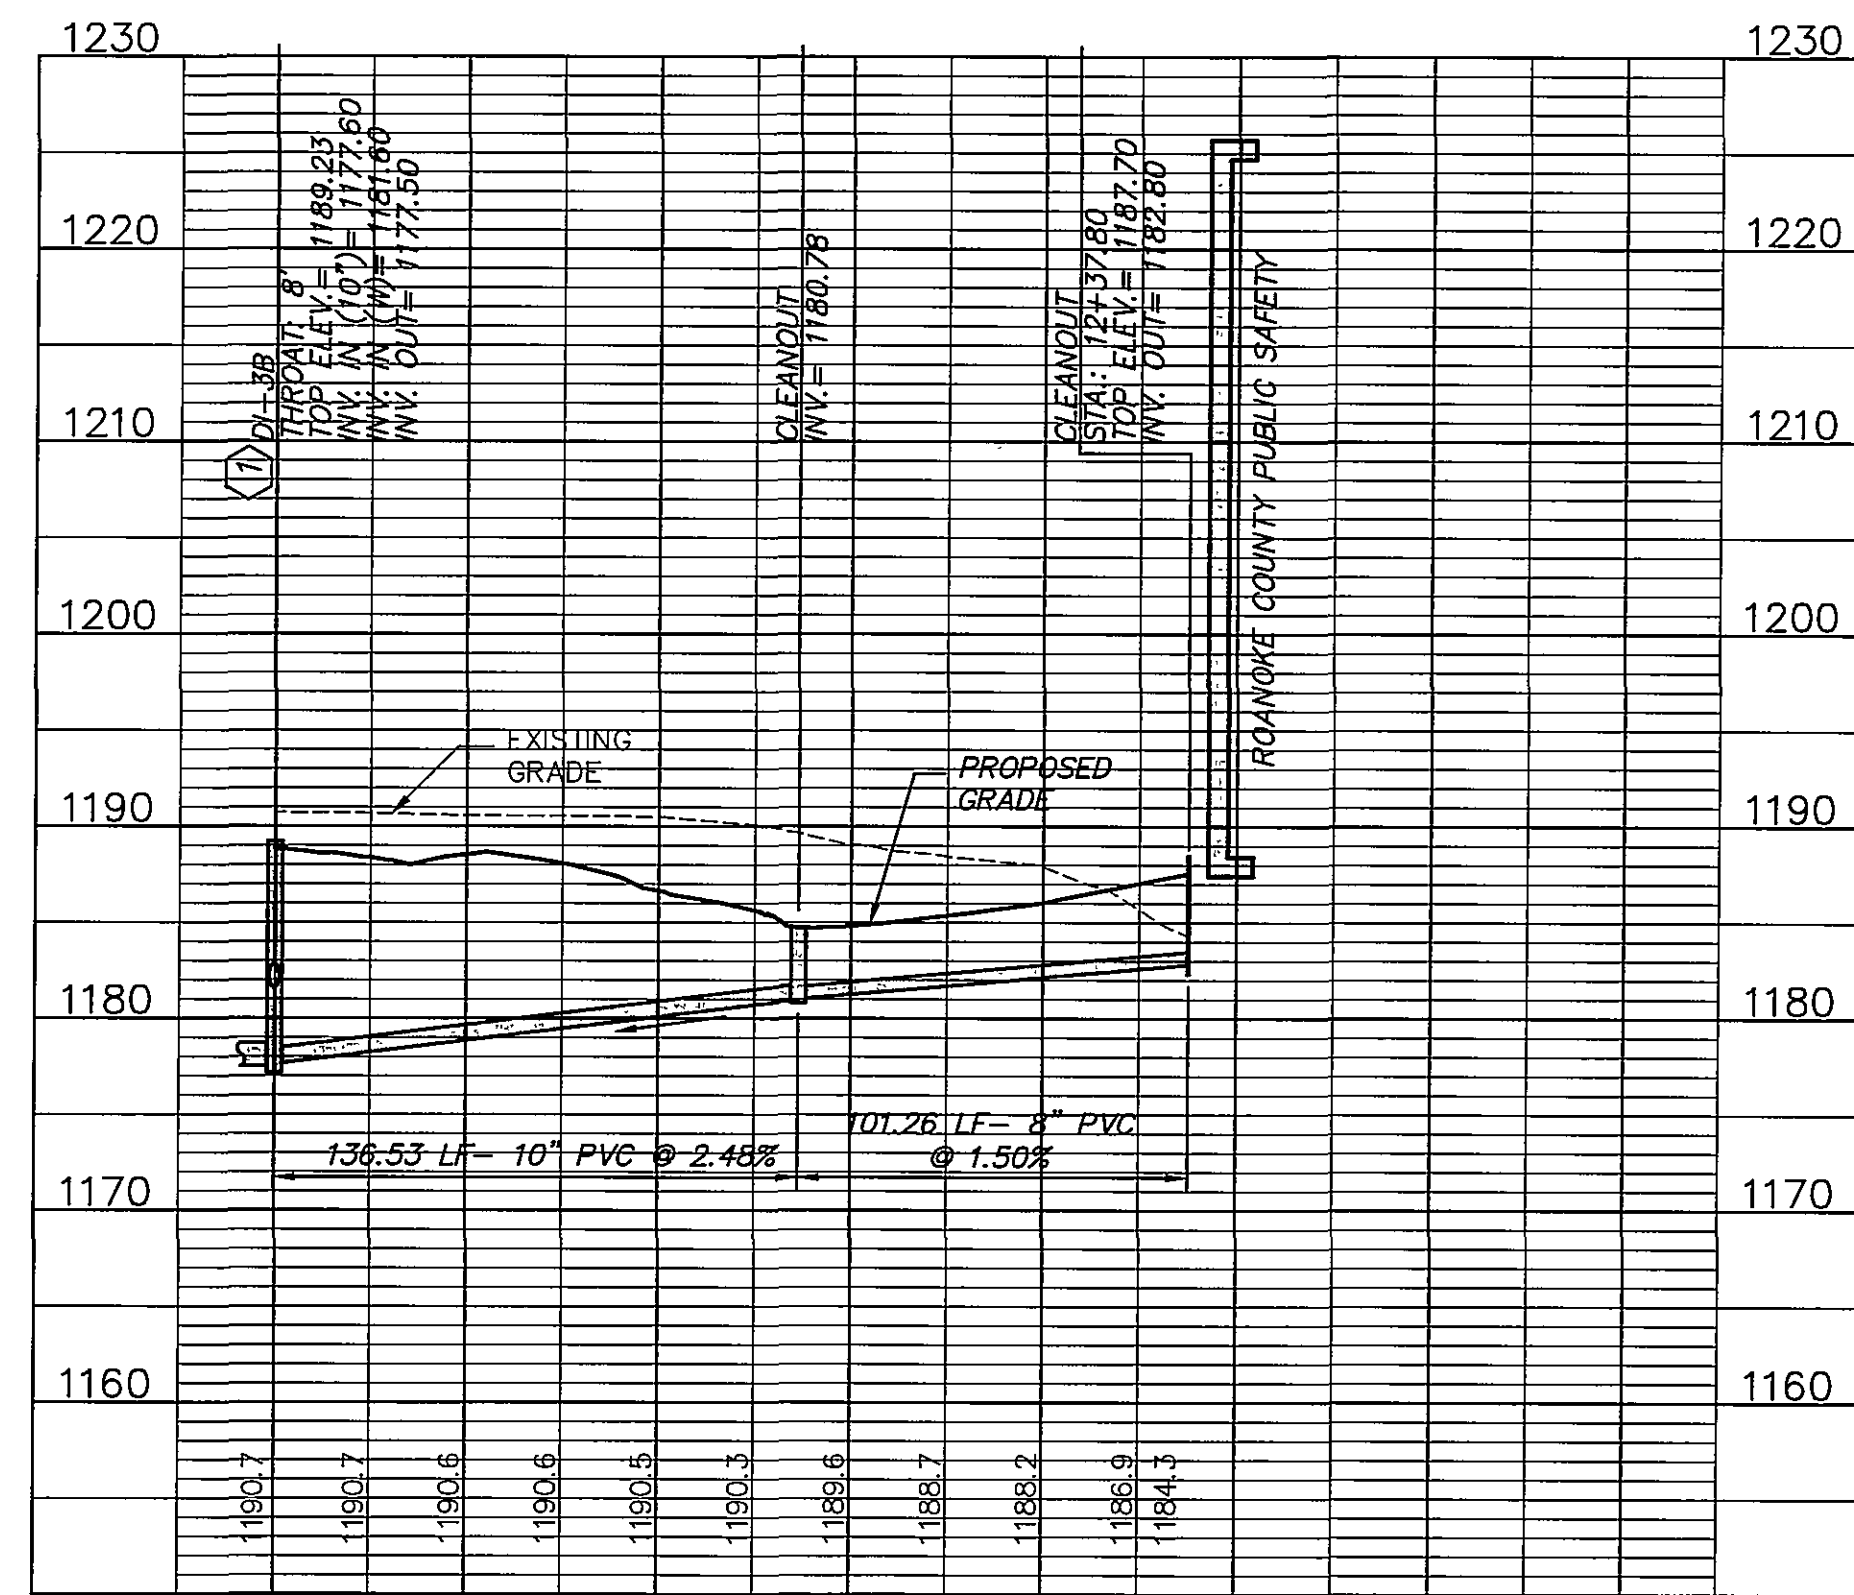

STORM WATER LINE C

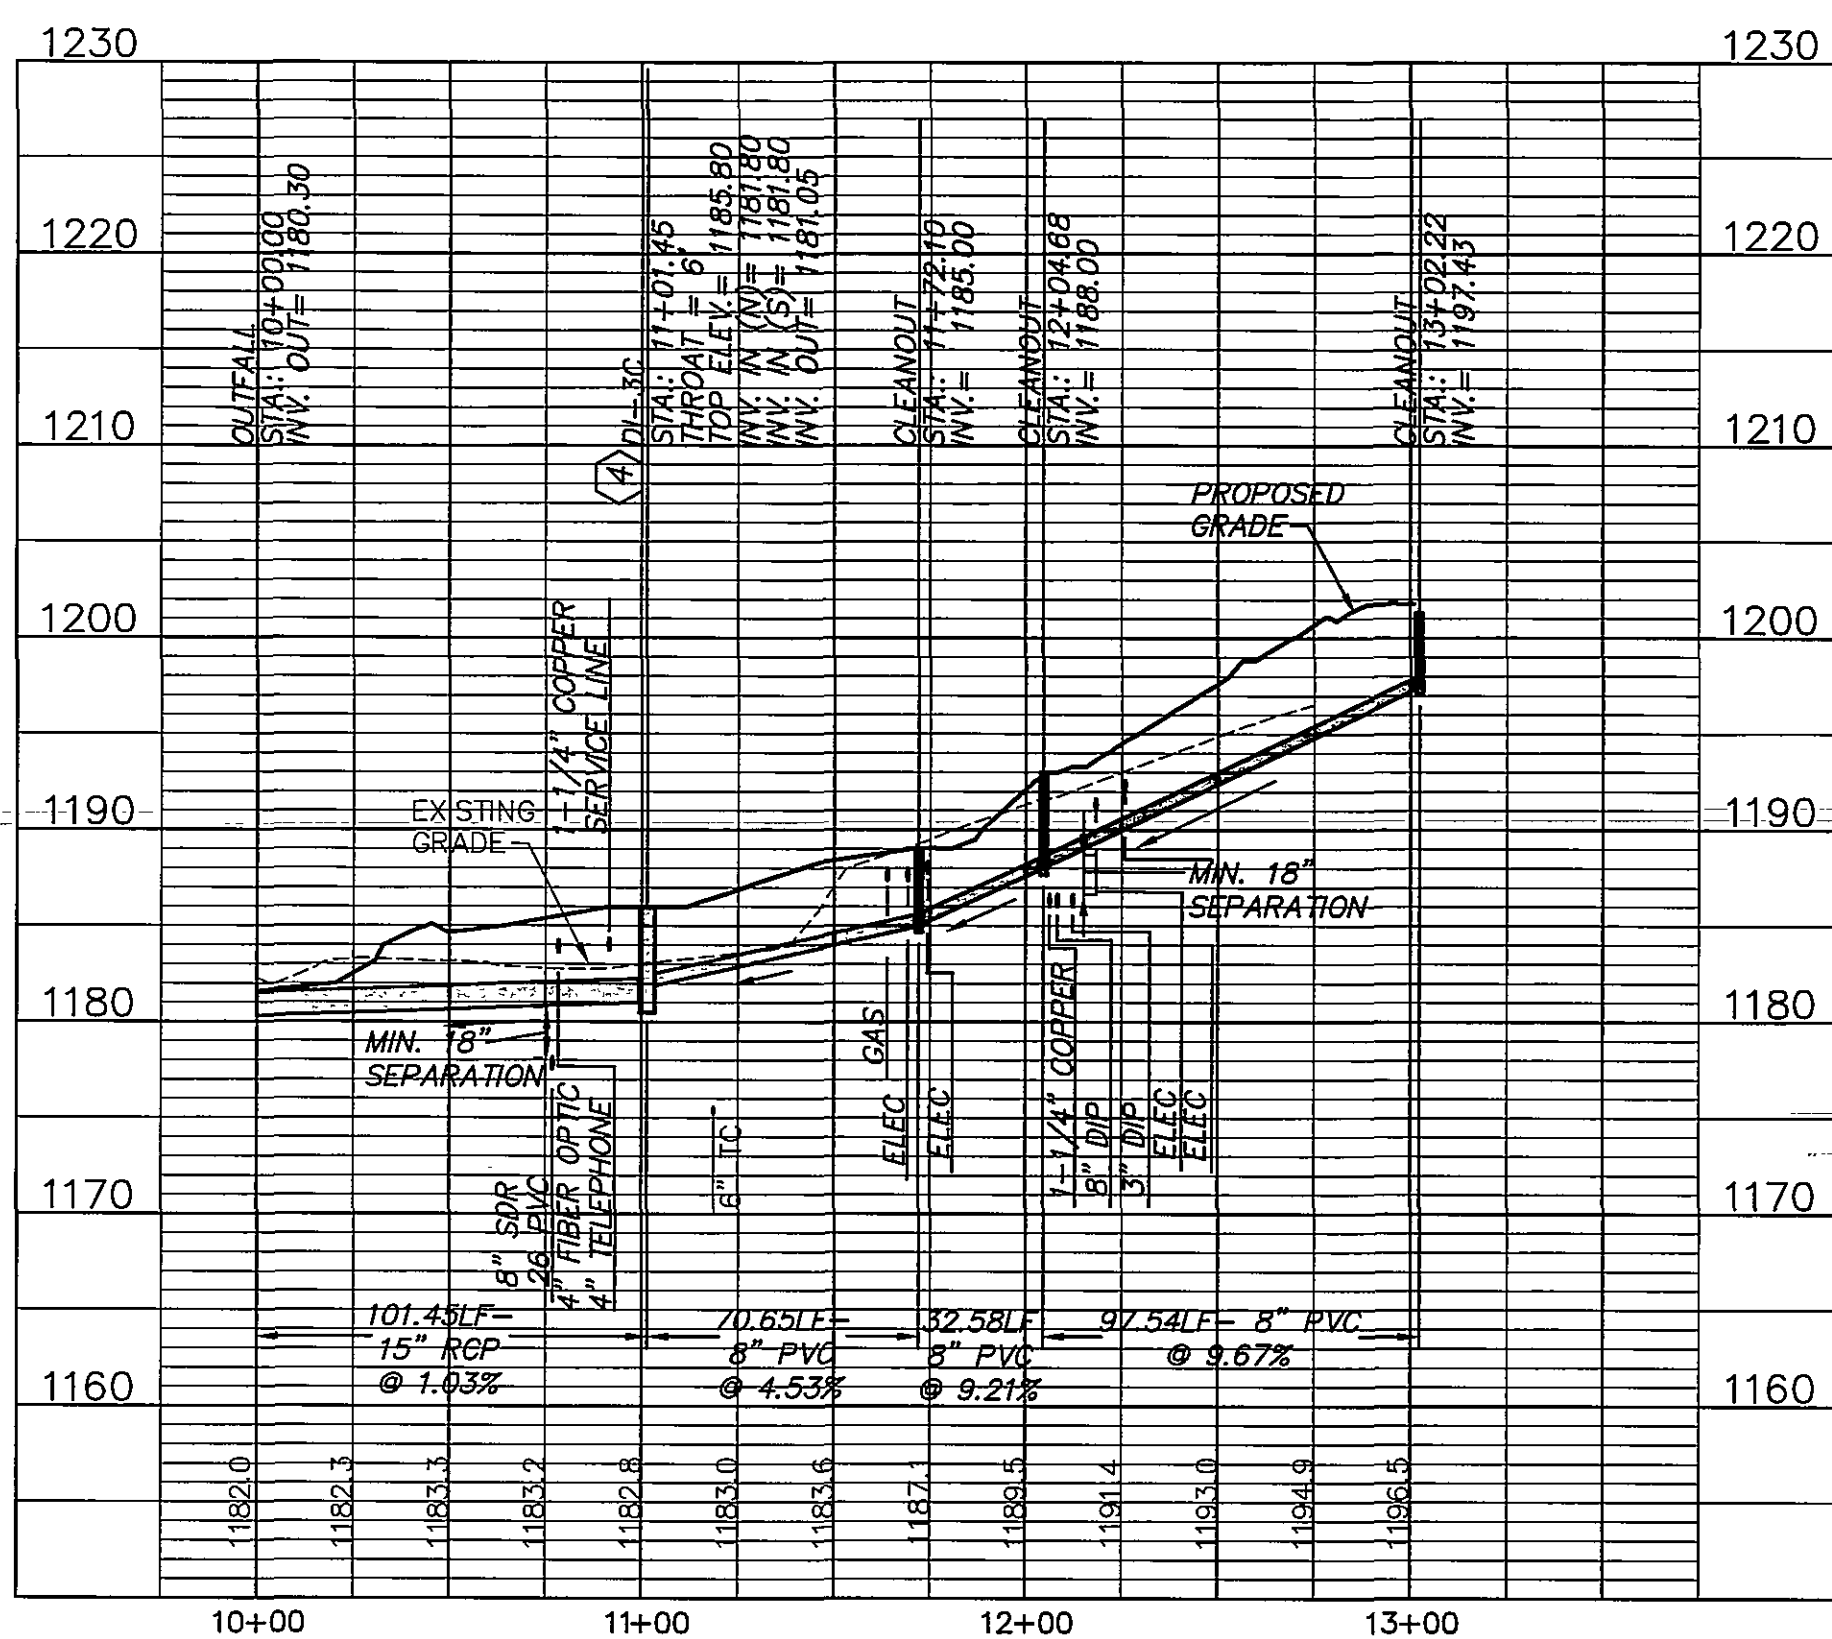


STORM WATER LINE D

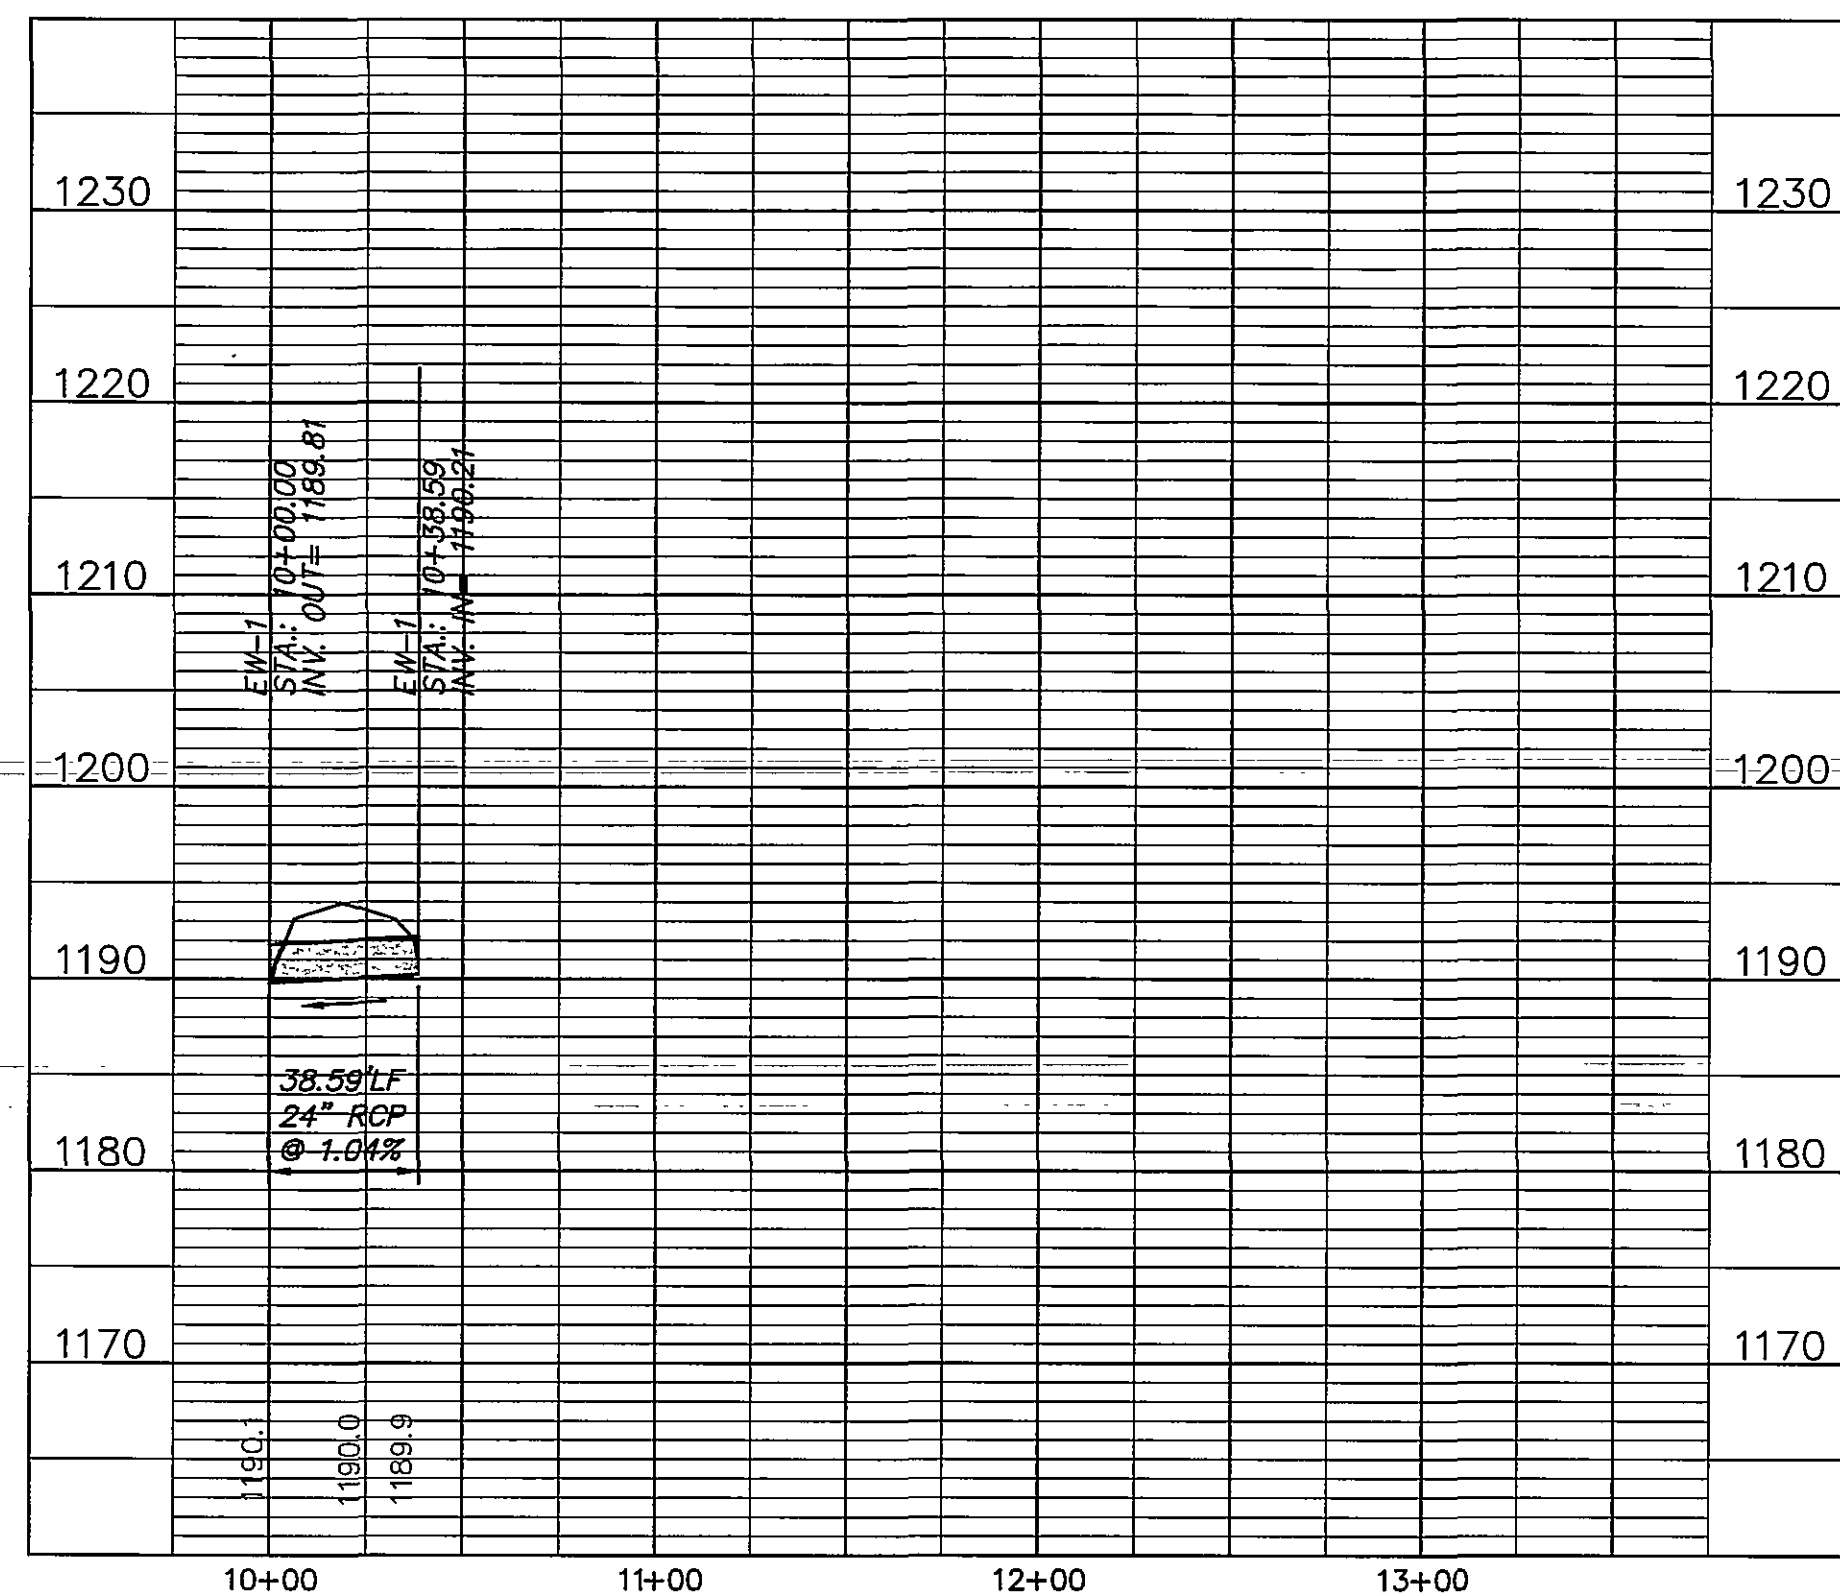

STORM WATER LINE E

THE ENGINEER AND/OR SURVEYOR TAKES NO RESPONSIBILITY FOR THE LOCATION OR ACCURACY OF THE UTILITIES AS SHOWN HEREON OR ANY UTILITIES WITHIN THE PROJECT THAT MAY NOT BE SHOWN HEREON. THE CONTRACTOR SHALL BE RESPONSIBLE FOR CONTACTING THE UTILITY COMPANIES TO SEE IF ANY UTILITIES EXIST WITHIN THE AREA OF THE PROJECT BEFORE ANY CONSTRUCTION BEGINS. ANY COST INCURRED BY DAMAGING ANY UTILITY WITHIN THE PROJECT SHALL BE AT THE EXPENSE OF THE CONTRACTOR.

48 WORKING HOURS PRIOR TO STARTING THE WORK, THE CONTRACTOR SHALL CALL MISS UTILITY AT 1-800-552-7001 AND ADVISE THE NATURE AND LOCATION OF THE WORK.

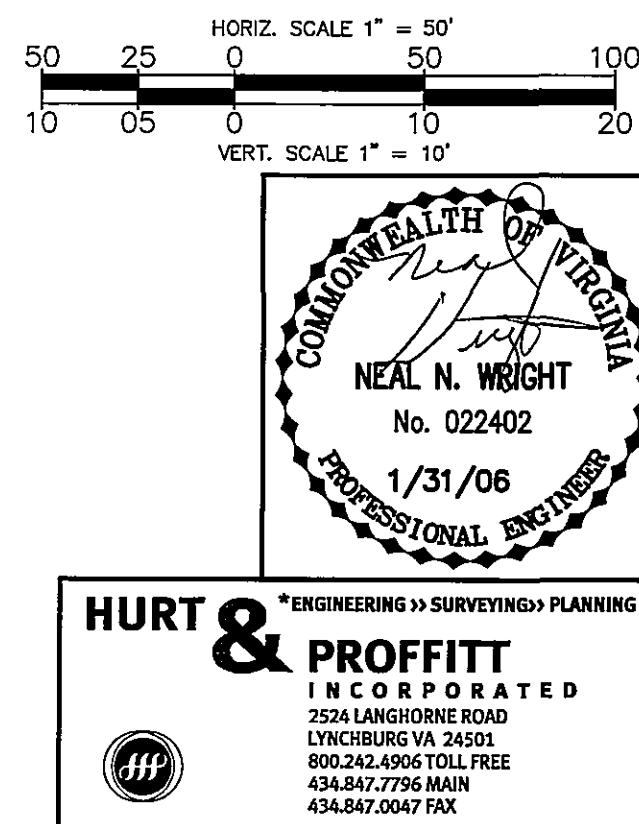

© COPYRIGHT 2004

DVA
DONNALLY, VUICIC, ASSOCIATES, L.L.C.
architecture ■ planning ■ interiors
400 Professional Drive ■ Suite 200 ■ Catonsville, Maryland 20879-3433
301-590-8900 ■ Fax 301-590-8620 ■ EMAIL: DVA@DVA-NC.COM



SITE PLAN
FOR
ROANOKE COUNTY PUBLIC SAFETY BUILDING
ROANOKE COUNTY, VIRGINIA
NORTHROP GRUMMAN
STORMWATER SEWER PLAN AND PROFILE



REVISIONS	
03/16/05 PER COUNTY COMMENTS	
03/29/05 PER COUNTY COMMENTS	
04/27/05 PER COUNTY COMMENTS	
05/11/05 PER COUNTY COMMENTS	
07/26/05 PER COUNTY COMMENTS	
11/09/05 PER COUNTY COMMENTS	
12/08/05 PER COUNTY COMMENTS	
1/16/06 PER VDOT COMMENTS	
ISSUED: HURT & PROFFITT NUMBER:	
12/08/05 20040857	
DRAWN BY:	CHECKED BY:
DVA JOB NO. A.19802X	SCALE
DRAWING	

C203
SHEET 10 OF 18