



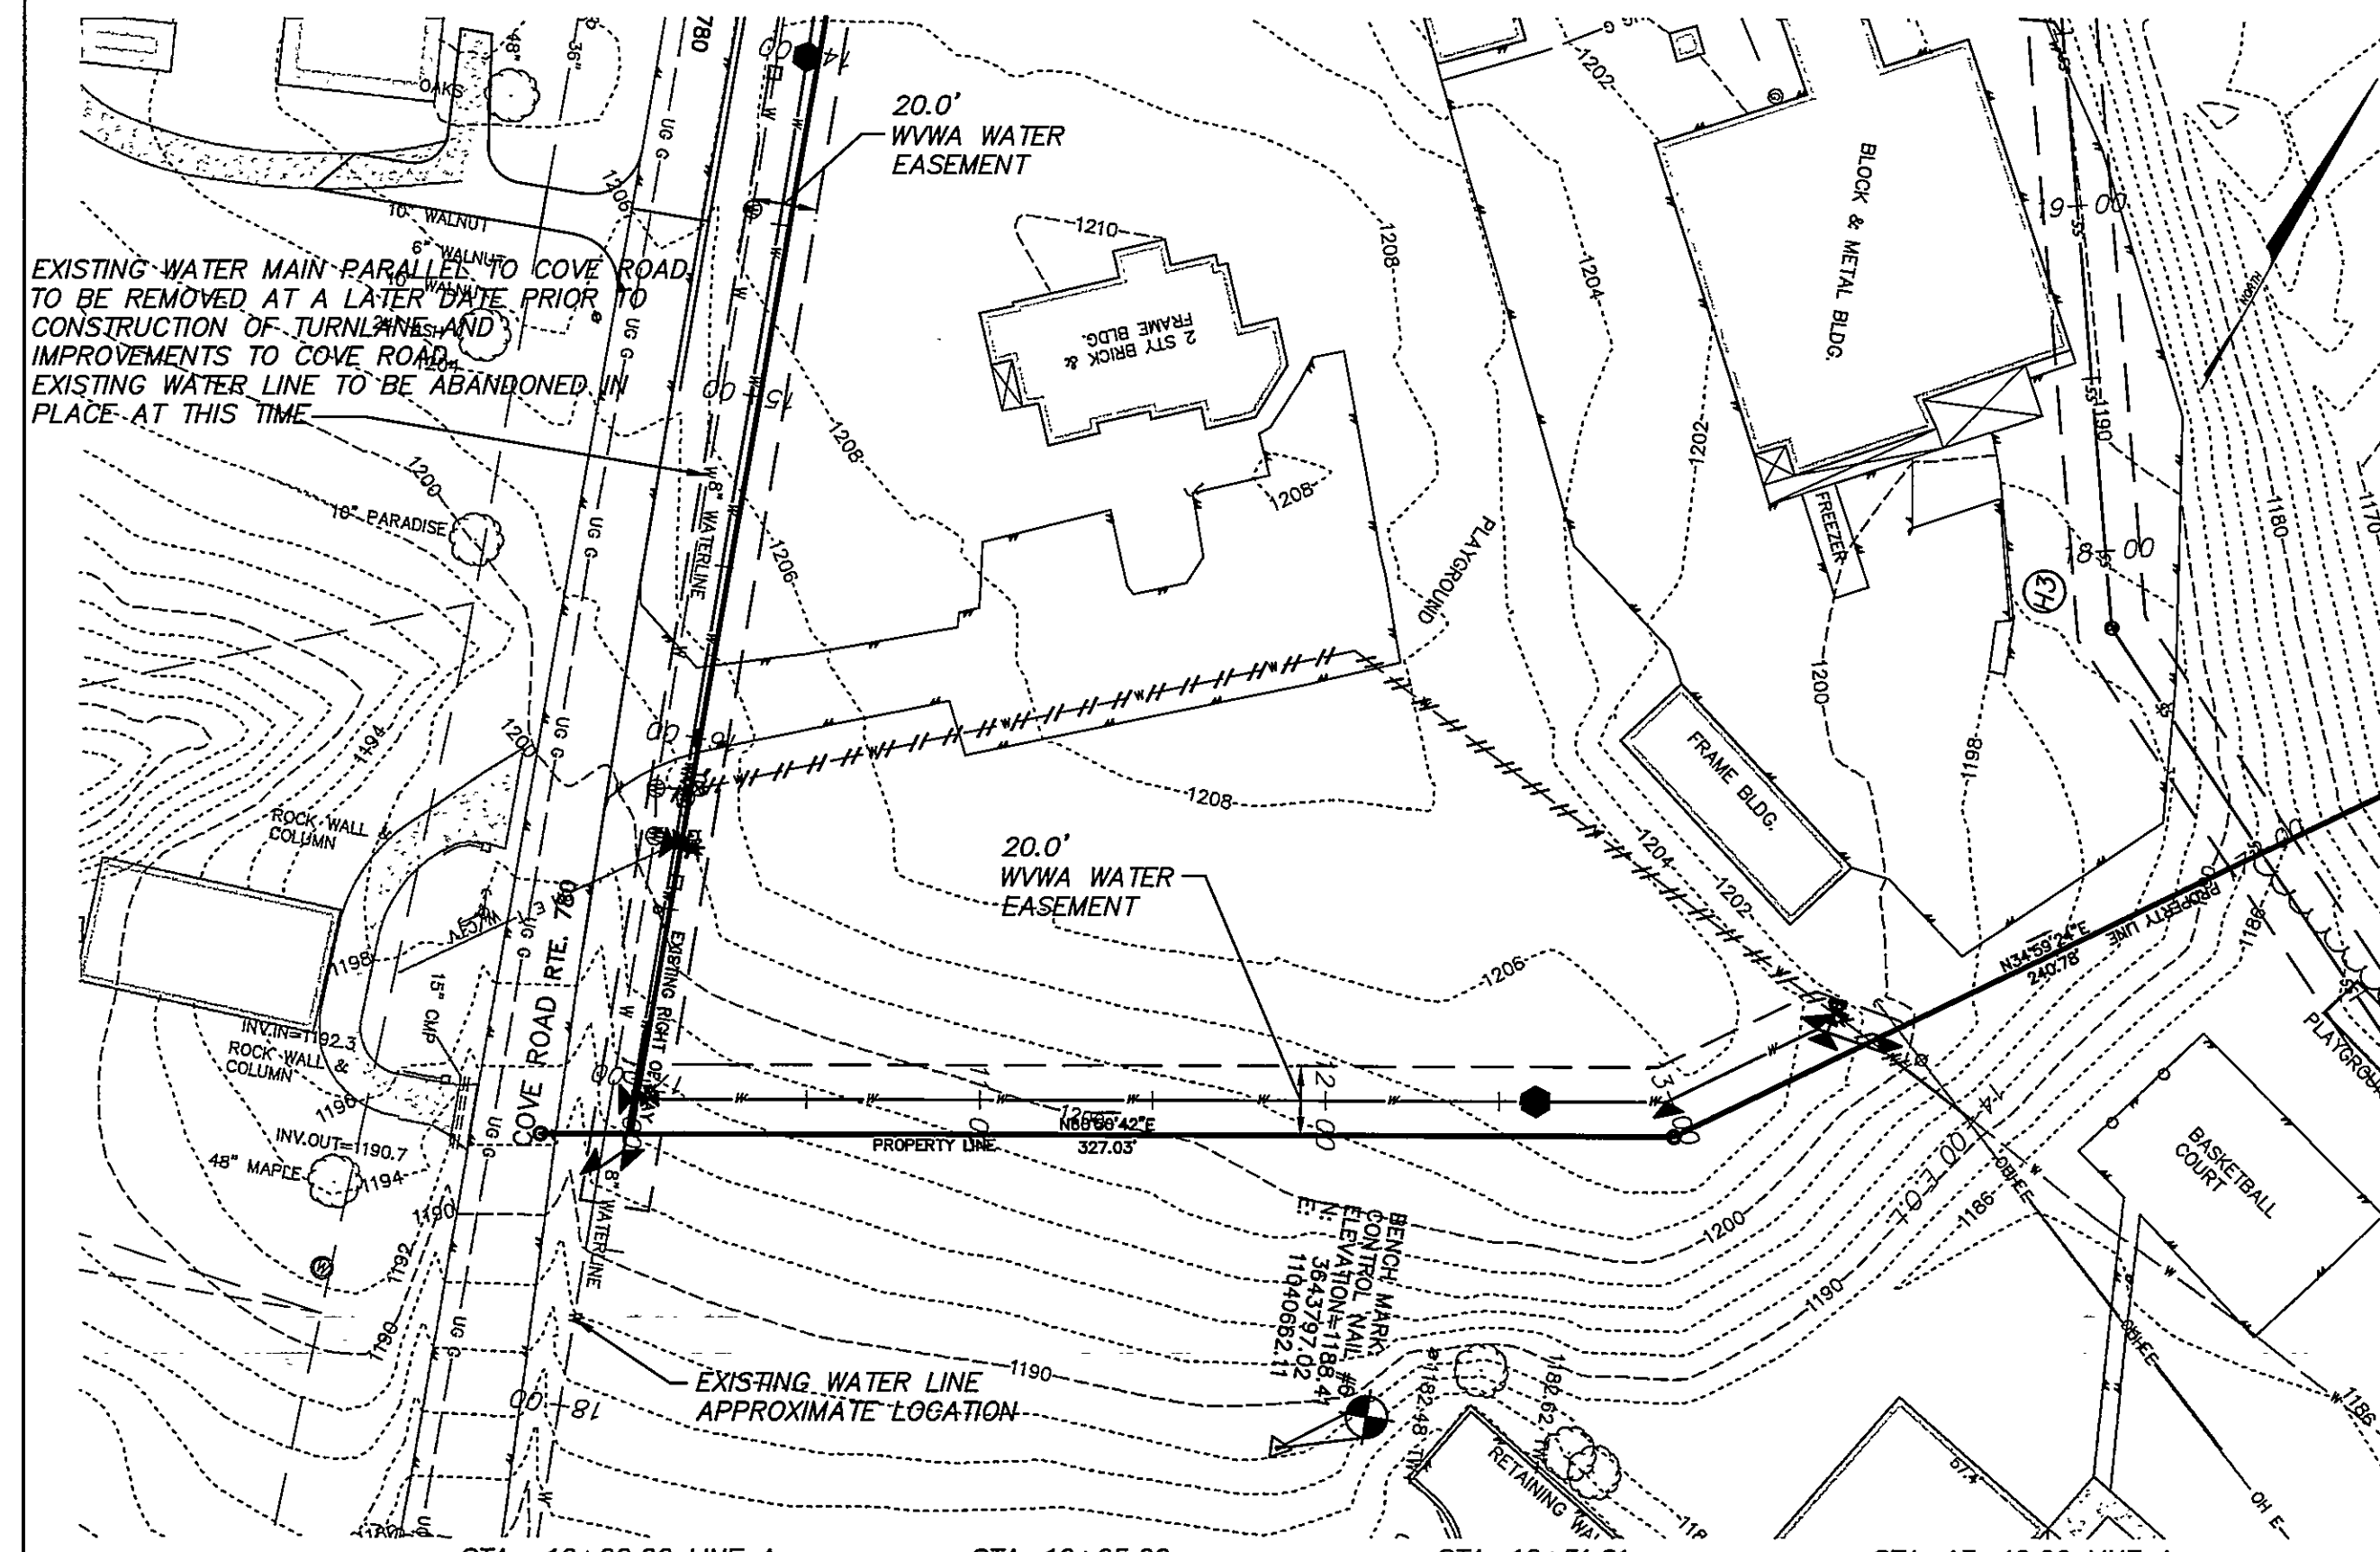


- STA: 10+00.00 LINE A=
STA: 17+03.83 LINE B
REQ'D:
1- 8" X 8" TEE
1- THRUST BLOCK
CONTRACTOR TO FIELD VERIFY
EXISTING WATER LINE DEPTH AND
SIZE BEFORE CONSTRUCTION
- STA: 10+05.00
REQ'D:
1- 8" GATE VALVE AND BOX
- STA: 12+51.81
REQ'D:
1- 8" AIR RELEASE VALVE
- STA: 13+46.99 LINE A
REQ'D:
1- 8" 45° BEND
1- THRUST BLOCK
- STA: 12+89.52
REQ'D:
1- 8" 22-1/2° BEND
1- THRUST BLOCK
- STA: 13+66.99 LINE A
REQ'D:
1- 8" 22-1/2° BEND
1- THRUST BLOCK
- STA: 14+00.00 LINE A E.O.L.
CONNECT NEW 8" DI PUSH ON CLASS 350
WATER LINE TO EXISTING 8" DIP WATER LINE
CONTRACTOR SHALL FIELD VERIFY DEPTH AND
LOCATION OF EXISTING 8" WATER LINE BEFORE
WYMA CONNECTS TO THE EXISTING 8" WATER LINE

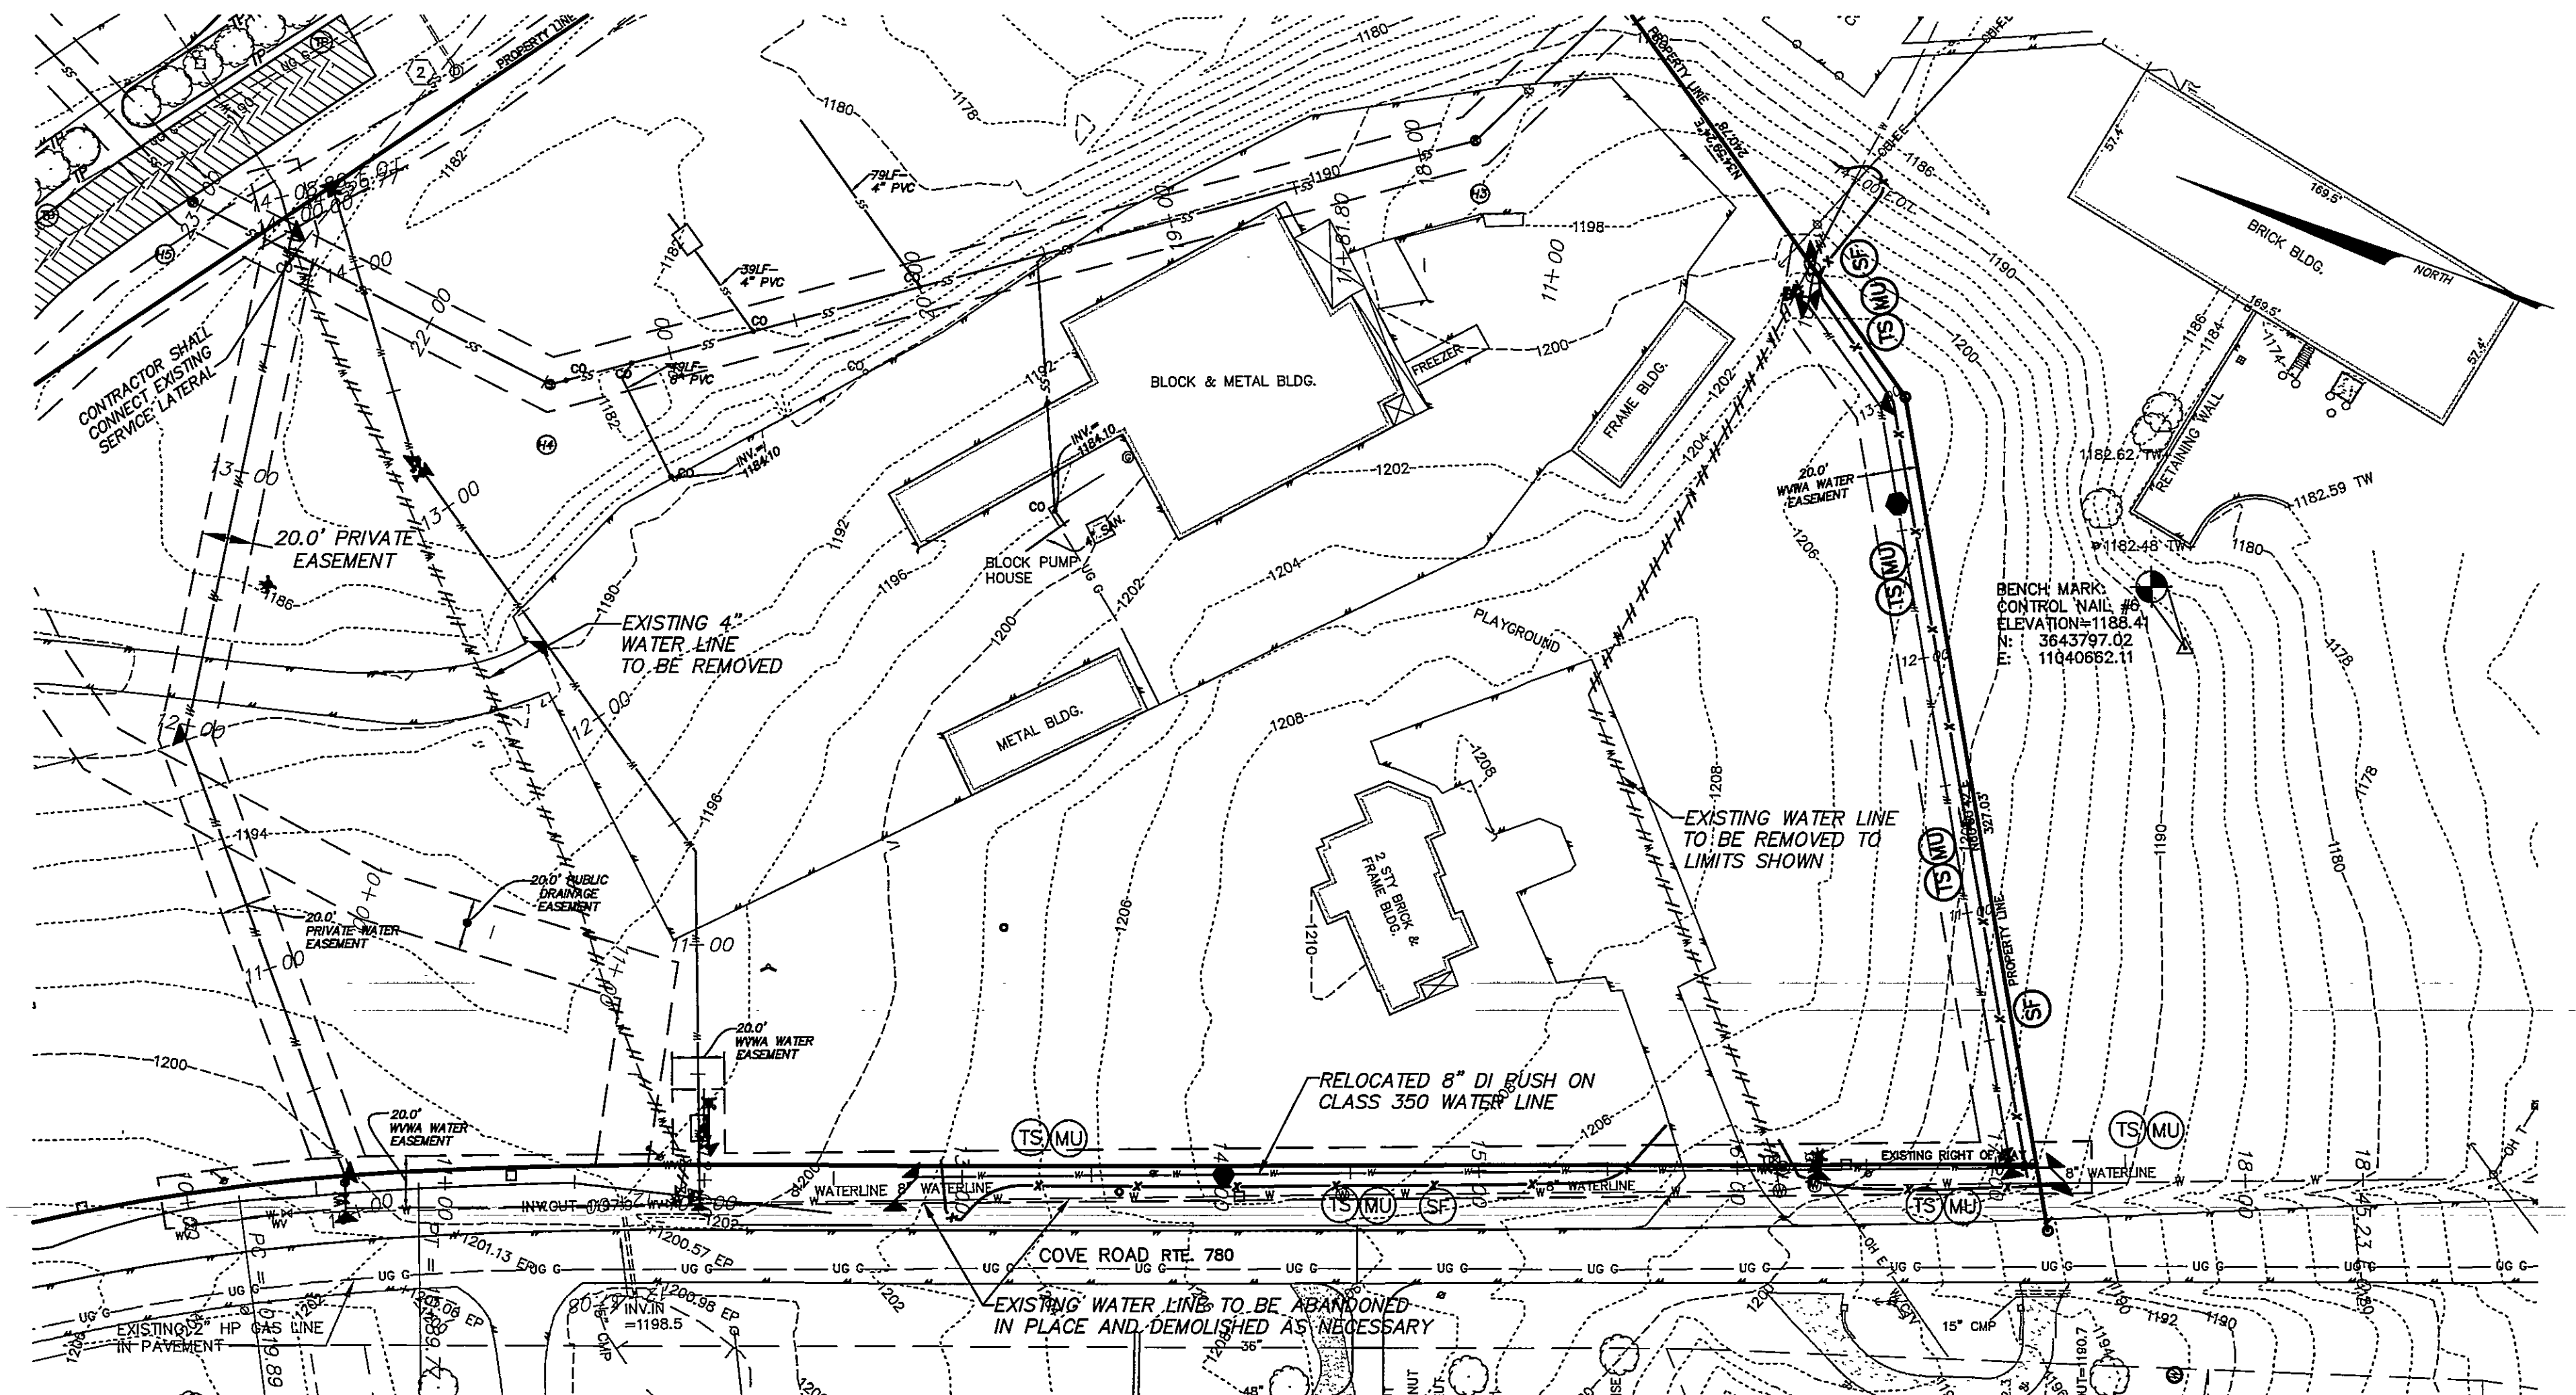


- STA: 10+65.76 LINE B=
STA: 10+00.00 LINE C
REQ'D:
1- 4" WET TAP
1- THRUST BLOCK
- STA: 11+98.08 LINE B
REQ'D:
1- 8"X6" TEE
1- CONNECT TO EXISTING 8" DIP
1- CONNECTION WILL BE PERFORMED BY WYMA
1- THRUST BLOCK
1- 8" GATE VALVE AND BOX
1- 8" PLUG
1- 8"X12" FIRE VAULT
1- 2" WATER METER
NOTE: ROD PLUG, TEE, AND VALVE
TO THRUST BLOCK
- STA: 12+73.76 LINE B
REQ'D:
1- 8" 45° BEND
1- THRUST BLOCK
- STA: 12+82.45 LINE B
REQ'D:
1- 8" 45° BEND
1- THRUST BLOCK
- STA: 14+01.00 LINE B
REQ'D:
1- AIR RELEASE VALVE
- STA: 16+31.64 LINE B
REQ'D:
1- 8"X6"X6" TEE
1- FIRE HYDRANT ASSEMBLY
1- THRUST BLOCK
- STA: 17+05.58 LINE B=
STA: 10+00.00 LINE A
REQ'D:
1- 8" X 8" TEE
1- THRUST BLOCK
- STA: 17+20.97 LINE B
REQ'D:
1- 8" 45° BEND
1- THRUST BLOCK
- STA: 17+26.93 LINE B
REQ'D:
1- 8" 45° BEND
1- THRUST BLOCK
CONTRACTOR SHALL FIELD VERIFY DEPTH AND
LOCATION OF EXISTING 8" WATER LINE BEFORE
WYMA CONNECTS TO THE EXISTING 8" WATER LINE

NOTE: CONTRACTOR SHALL SUPPLY
TAPPING SLEEVE AND VALVE IN
ACCORDANCE WITH WYMA DESIGN
AND CONSTRUCTION STANDARDS.



- GENERAL NOTE:**
1. PROPOSED TURNLANE AND PROPOSED ENTRANCES SHOWN ARE FOR REFERENCE PURPOSES ONLY.
2. PROPOSED COVE ROAD IMPROVEMENTS ARE NOT PART OF THIS SUBMITTAL.
3. EXCAVATION AND SHORING TO BE PROVIDED BY CONTRACTOR PER OSHA STANDARDS AT
LOCATIONS FOR ALL TAPS TO BE PERFORMED BY WYMA.
4. CONTRACTOR SHALL COORDINATE WATER OUTAGE, AND ALL CONNECTIONS TO EXISTING SYSTEM
WITH WYMA. PROPOSED CONNECTION AT STA: 11+45.98 MAY NOT REQUIRE A WET TAP.

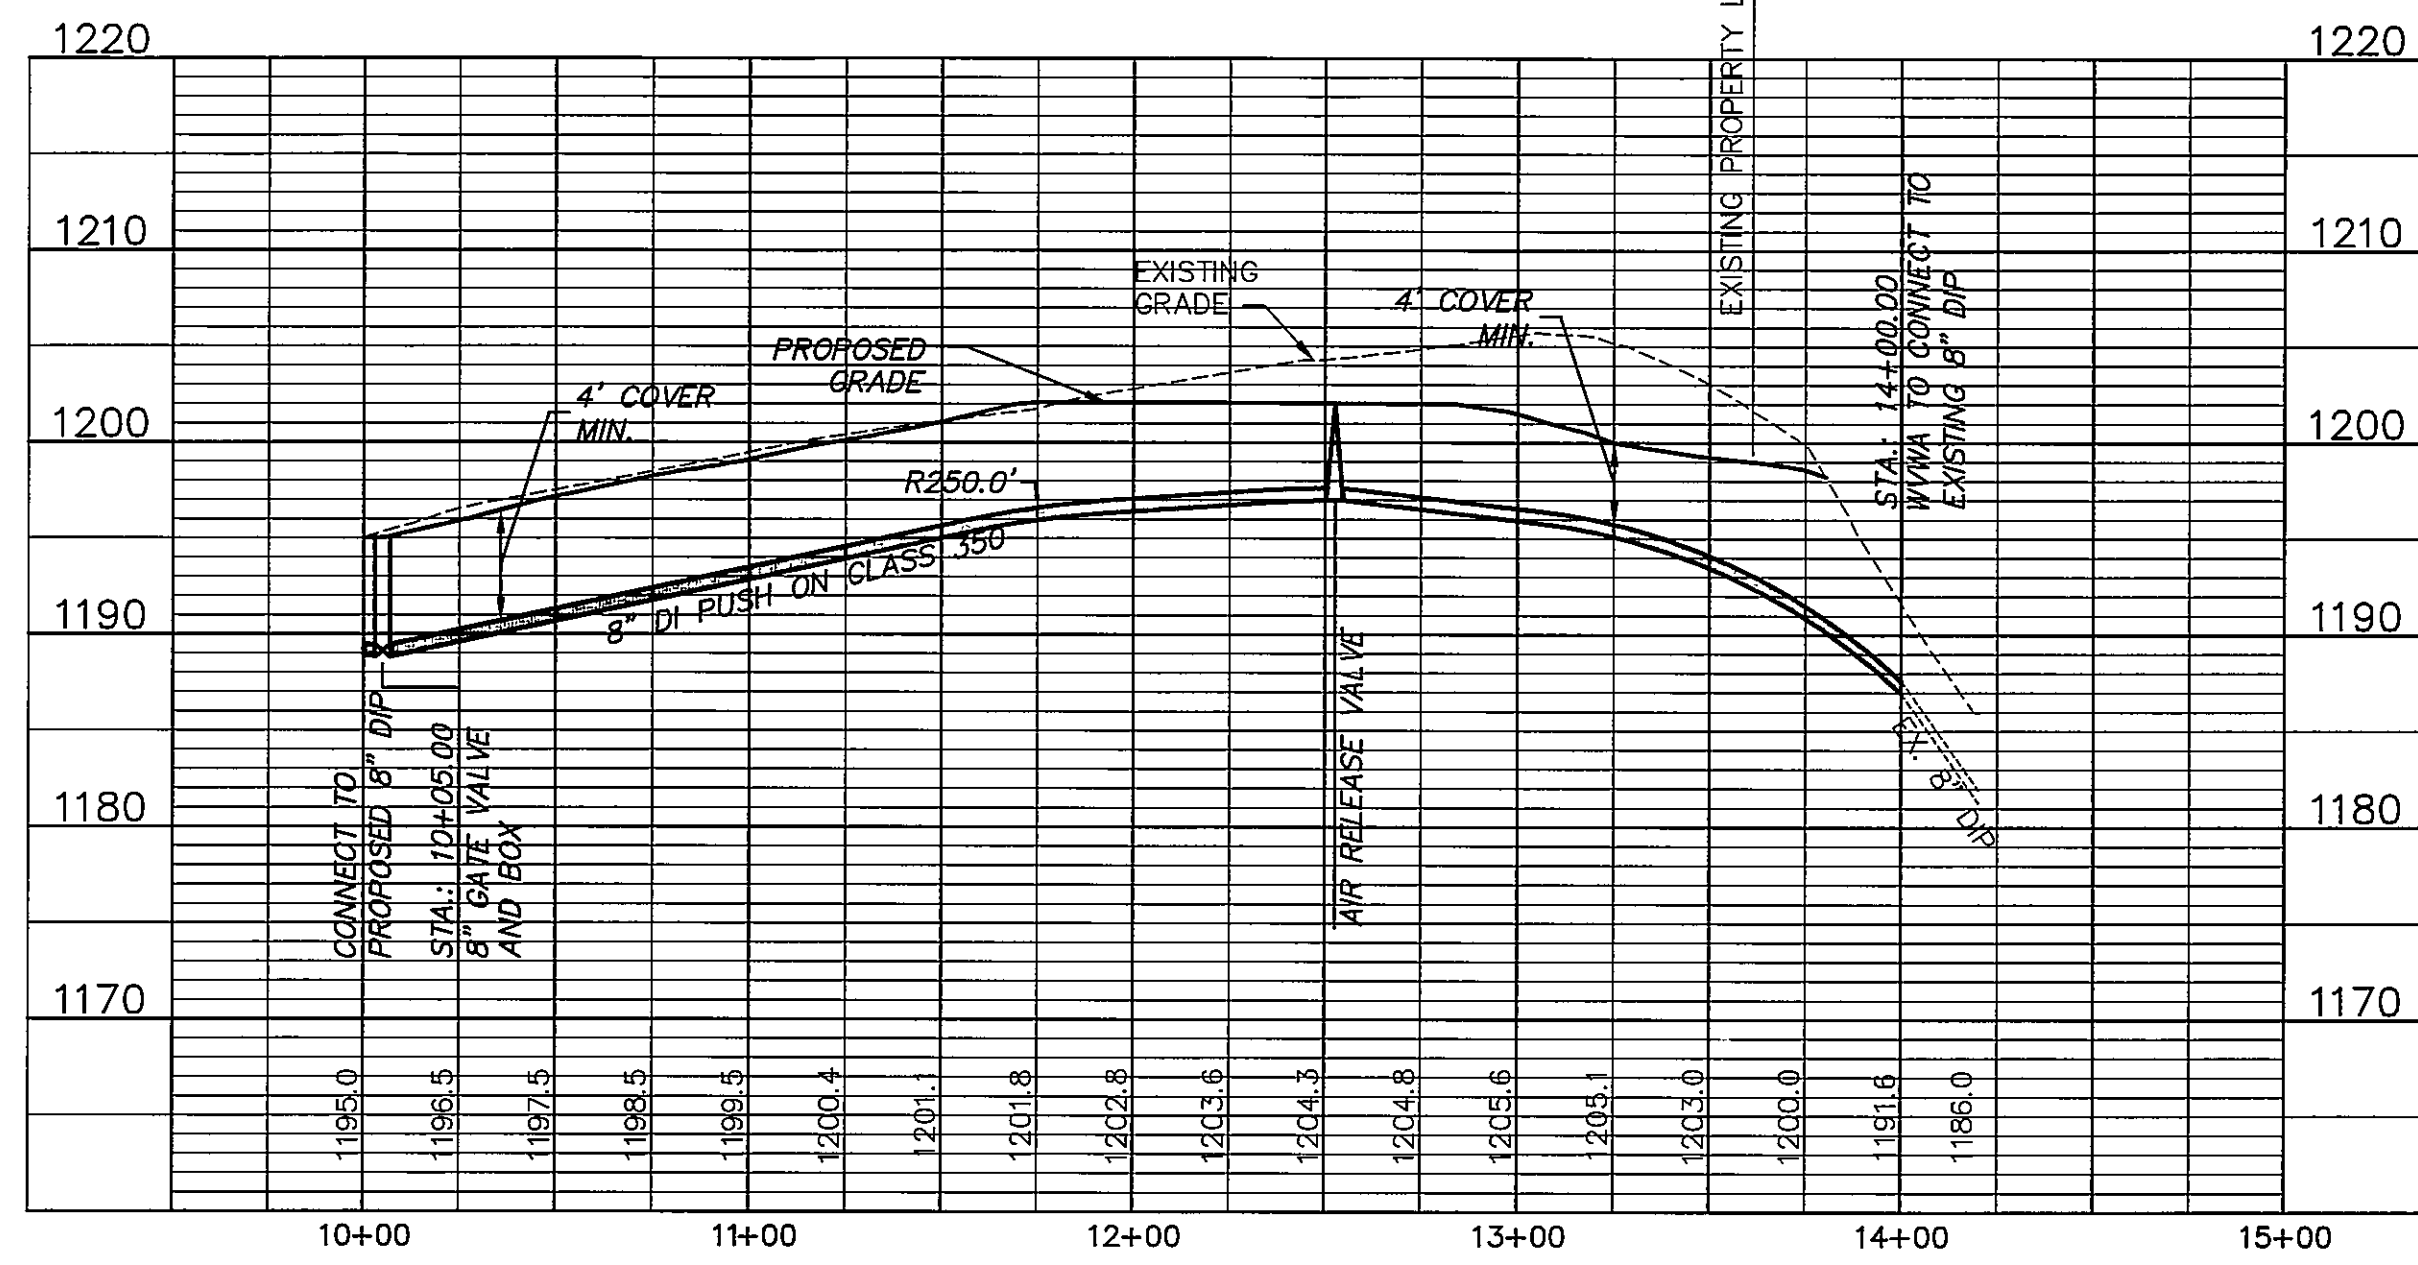

8" DI PUSH ON CLASS 350 WATER LINE A PROFILE


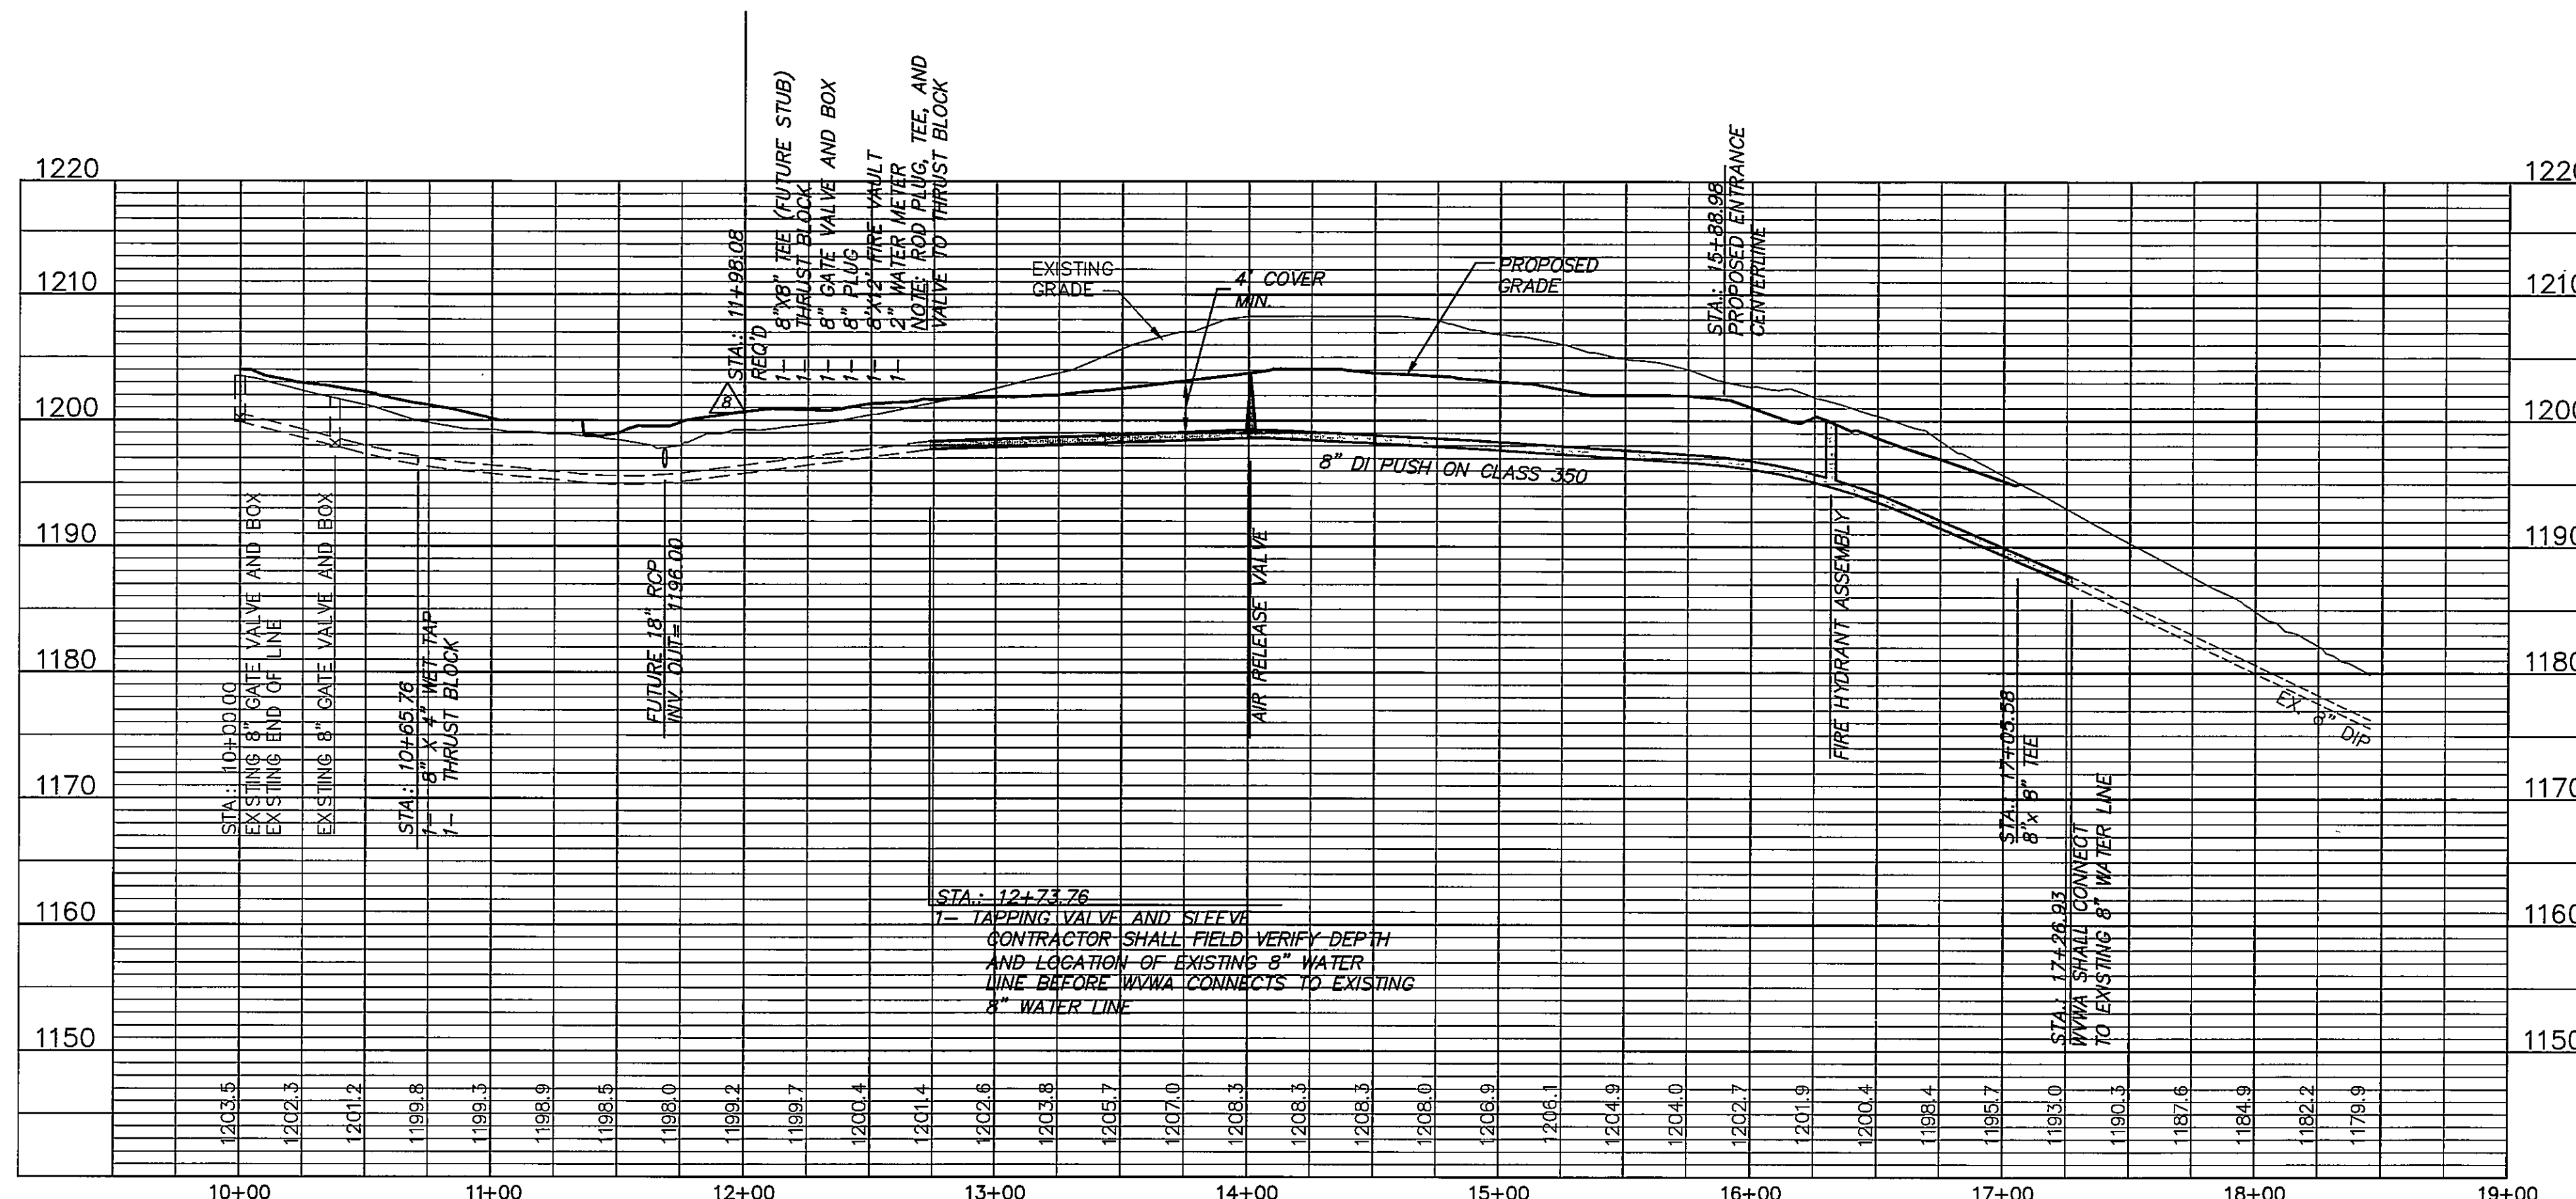


8" DI PUSH ON CLASS 350 WATER LINE B PROFILE

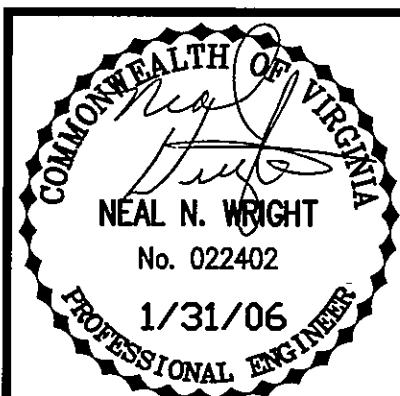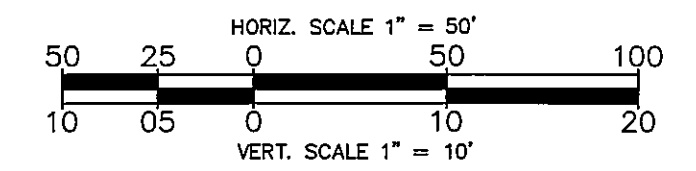

HURT & PROFFITT
INCORPORATED
2524 LANGHORNE ROAD
LYNCHBURG, VA 24501
800.242.4996 TOLL FREE
434.847.7796 FAX
434.847.0047 FAX

© COPYRIGHT 2004

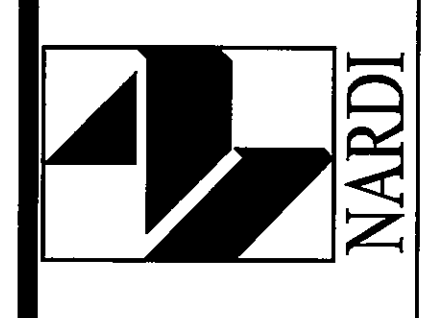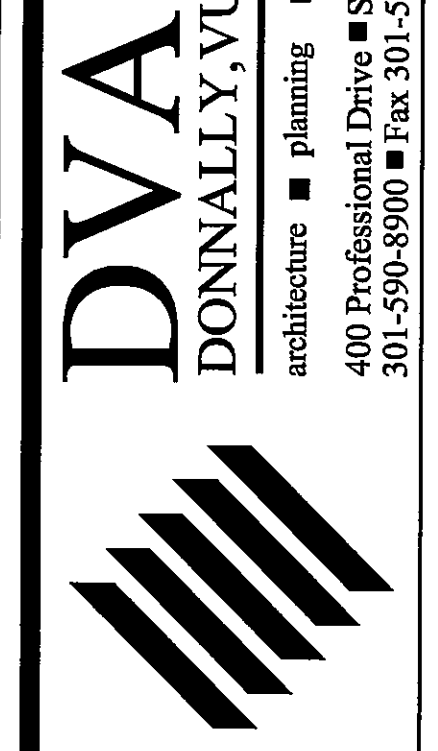

SITE PLAN FOR
ROANOKE COUNTY PUBLIC SAFETY BUILDING
ROANOKE COUNTY, VIRGINIA
NORTHROP GRUMMAN
WATER LINE RELOCATION PLAN AND PROFILE



REVISIONS	
11/08/05 PER COUNTY COMMENTS	
12/08/05 PER COUNTY COMMENTS	
12/28/05 PER COUNTY COMMENTS	
11/06/06 PER VDOT COMMENTS	

ISSUED:	HURT & PROFFITT NUMBER:
12/08/05	20040857
DRAWN:	CHECKED:
ELC	MDM
DVA JOB NO.:	SCALE:
13-0002	
DRAWING	

C204
SHEET 11 OF 18