



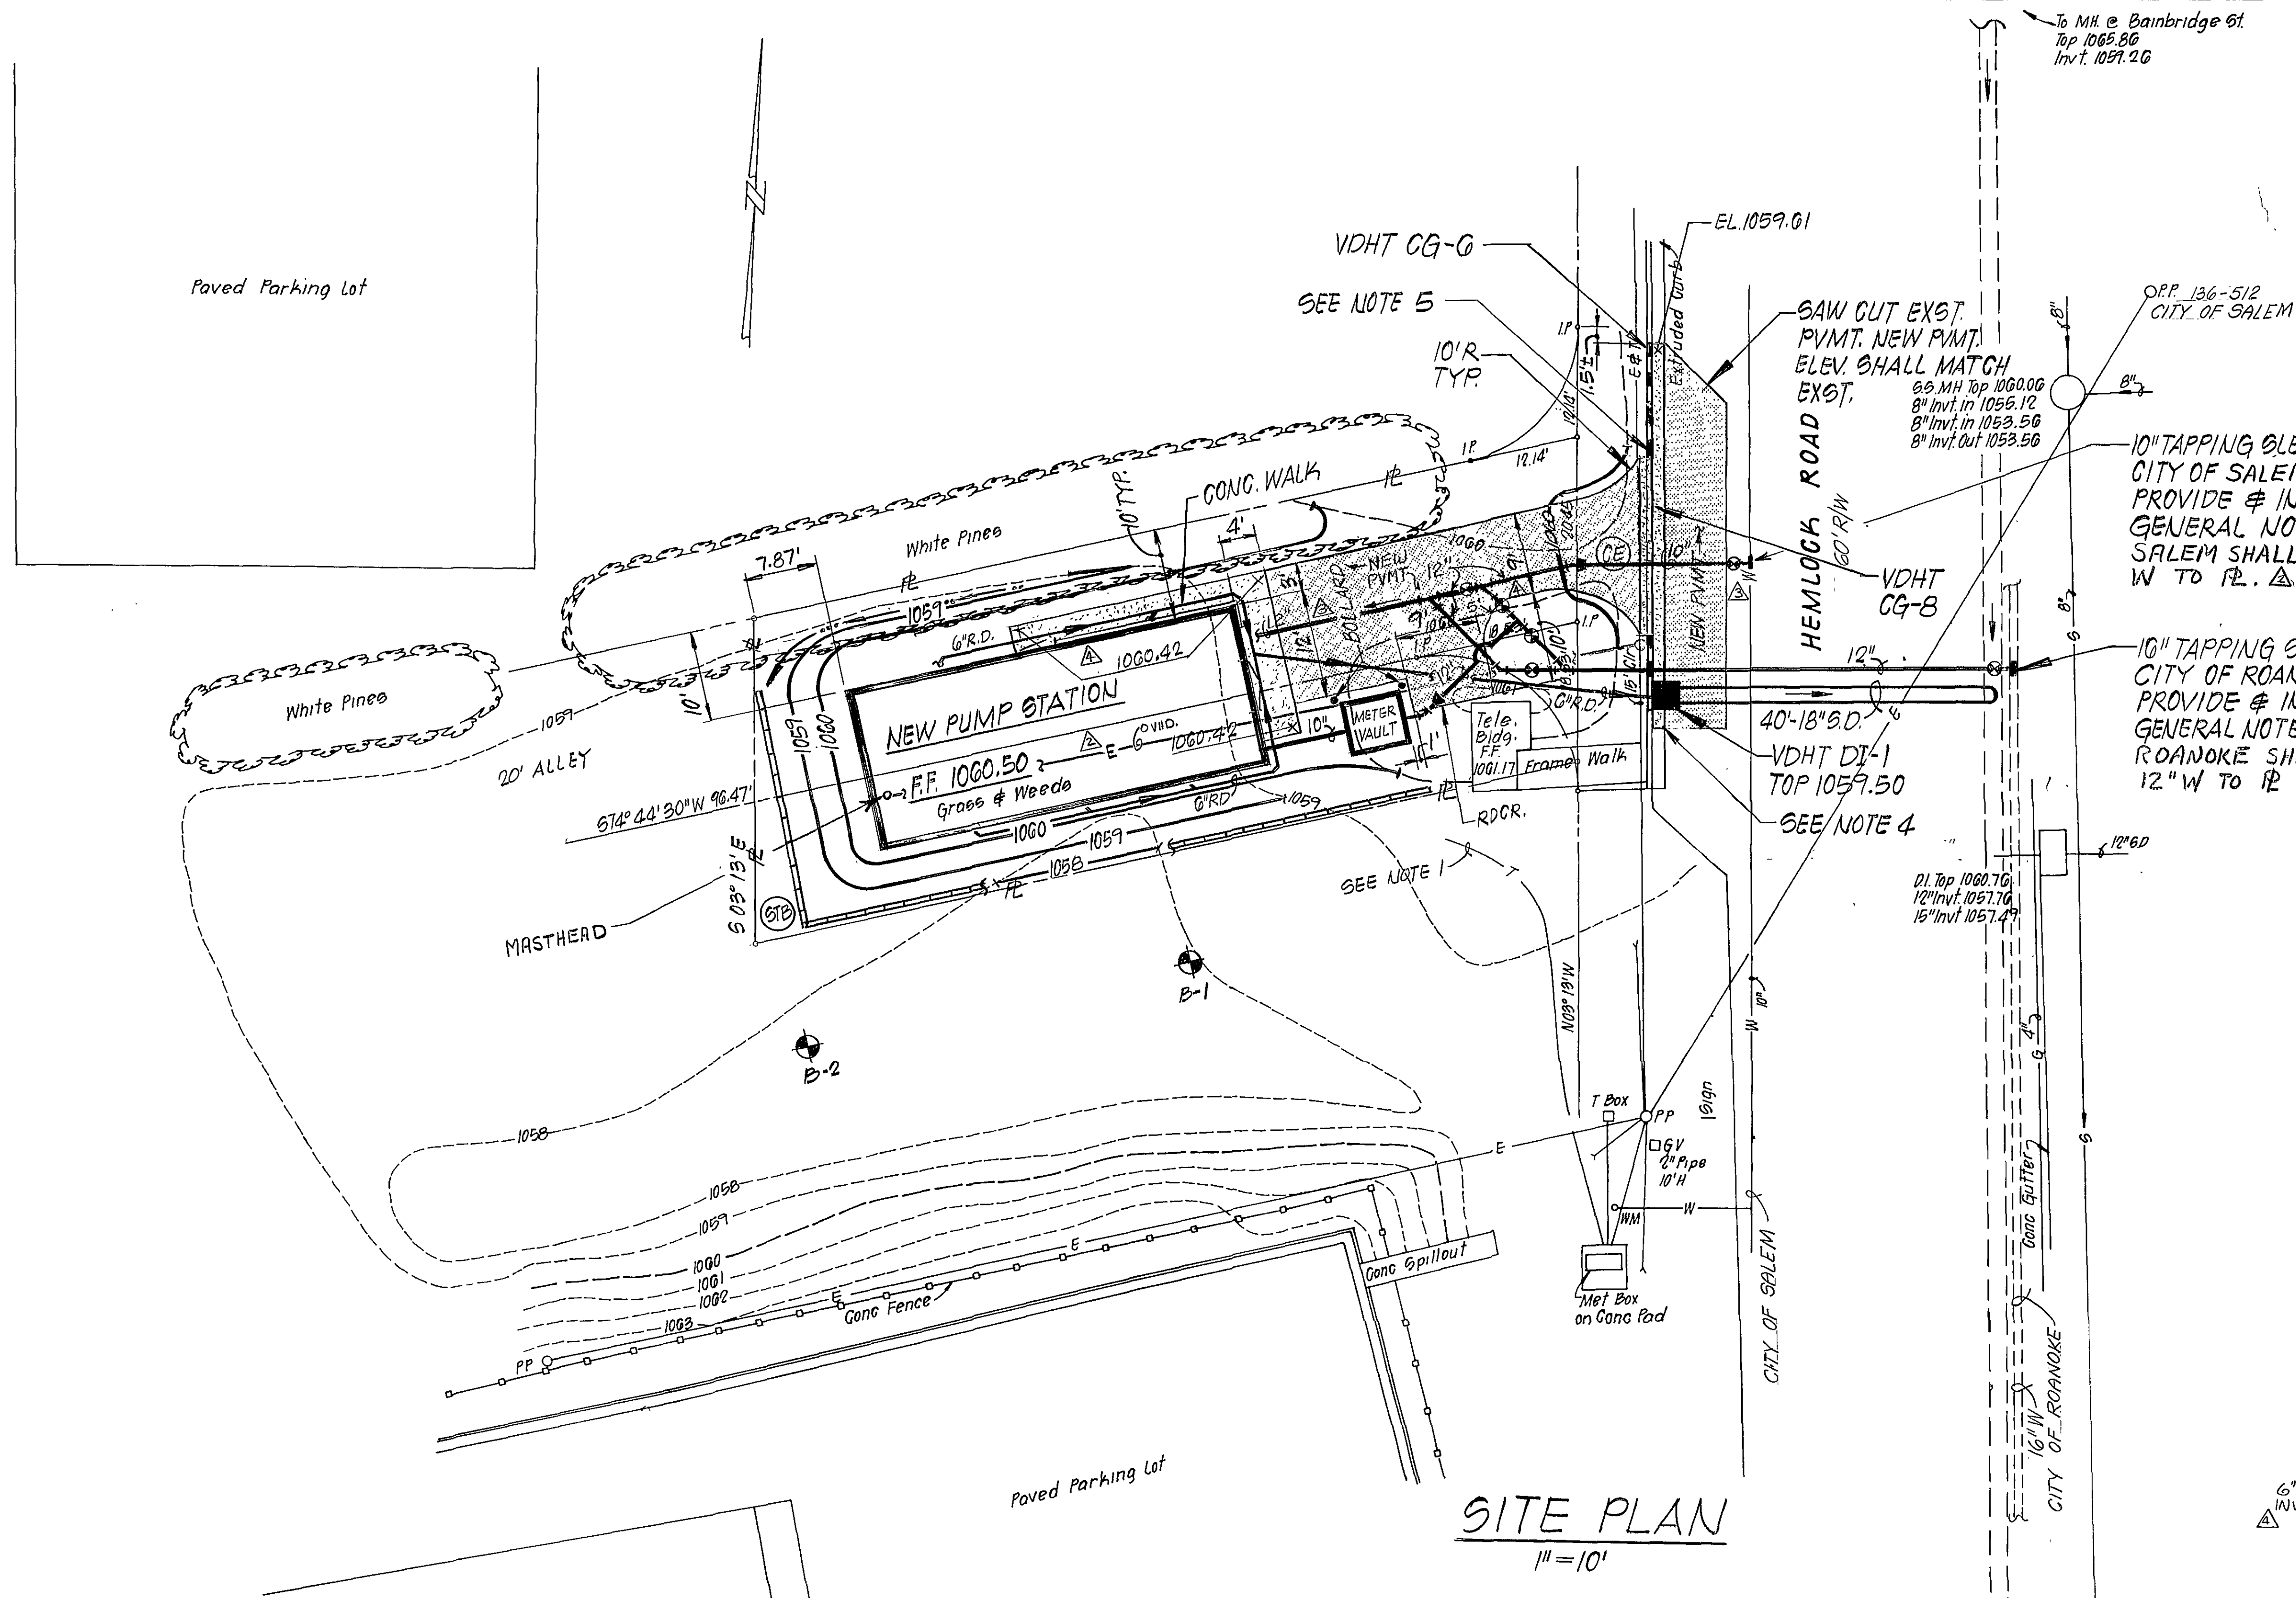


SITE PLAN
1" = 10'

- NOTES: 1 CONTRACTOR COORDINATE UTILITY RELOCATION WITH UTILITY COMPANY
2. ALL WATER LINES SHALL HAVE A MIN 3' COVER
3 SEE SH 7 FOR BOLLARD DET
4 WARP PVMT & GUTTER TO FORM A SMOOTH TRANSITION TO DRAIN.
5 CONTR SHALL REMOVE EXST CURB & GUTTER WHERE NEW CG-G & CG-B ARE TO BE INSTALLED

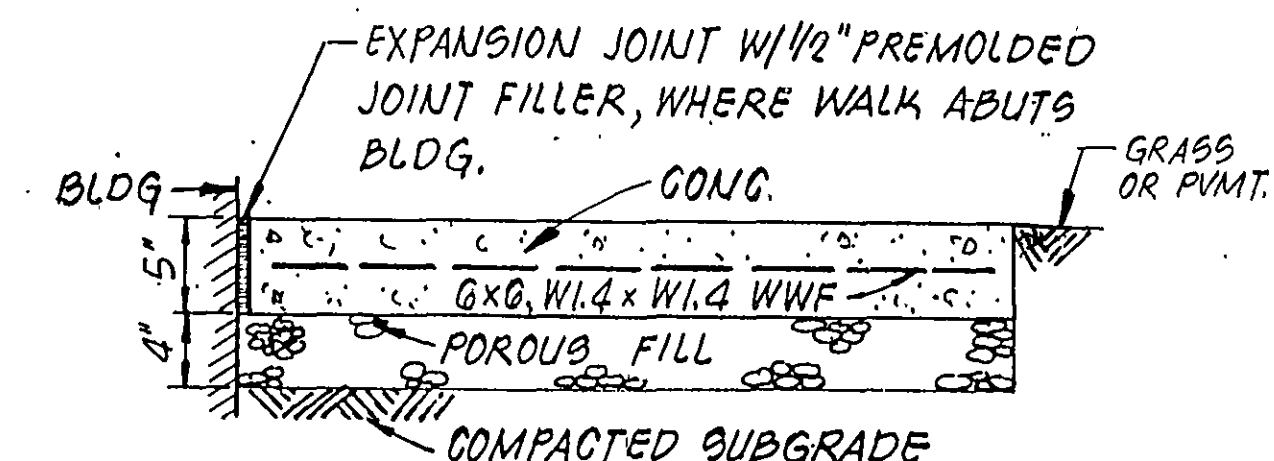


NOTE: CONTRACTION JOINT 1" DEEP SPACED 5' APART. EXPANSION JOINTS SHALL BE LOCATED EVERY 40' (MAX. 9 PA.)

TYPICAL SIDEWALK SECTION
NO SCALE

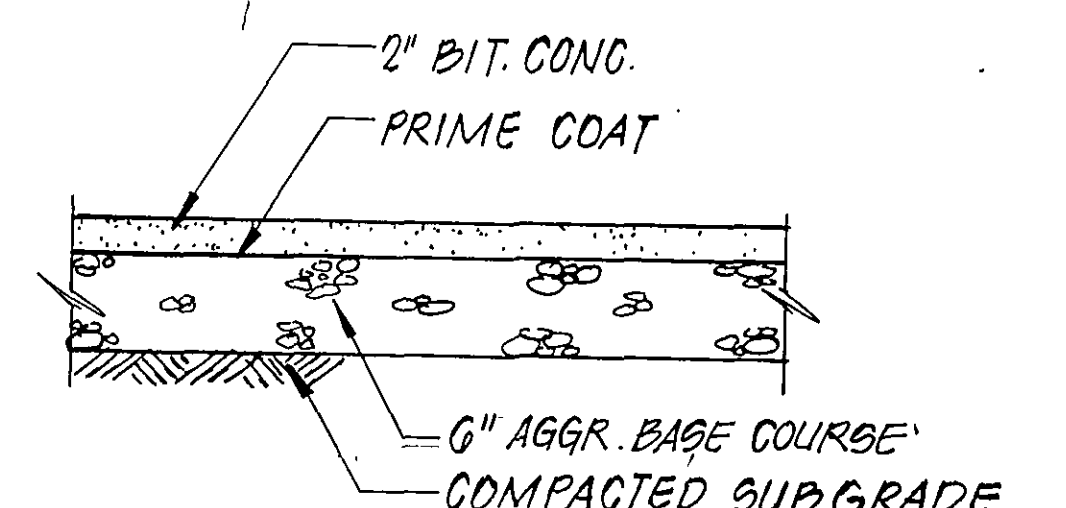

TYPICAL PVMT SECTION
NO SCALE

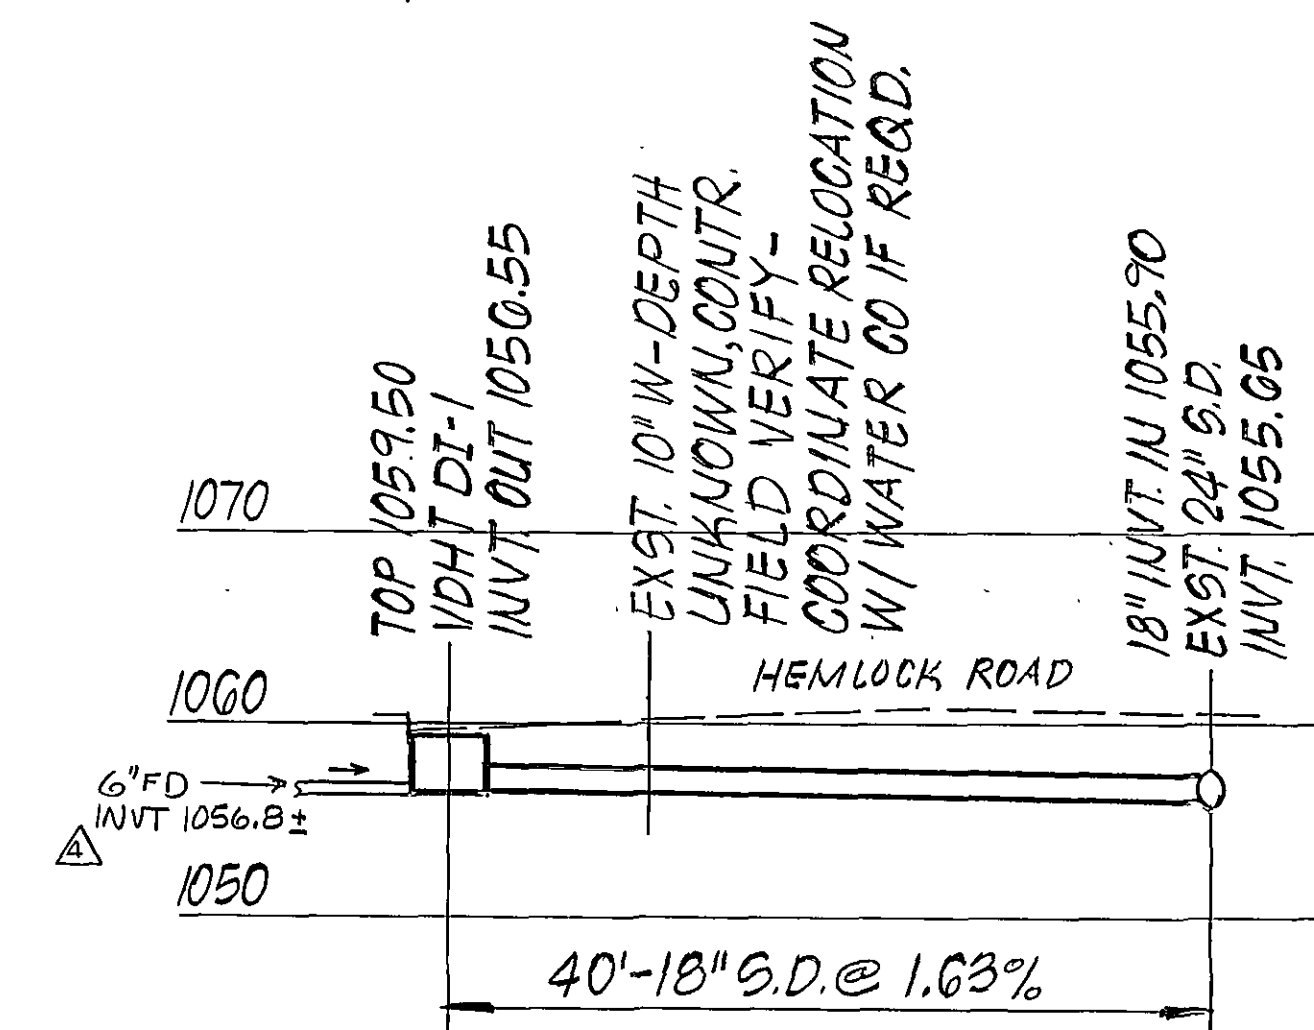

PROFILE-18" STORM DRAIN
SCALE: 1" = 10' HORIZ. & VERT.

DESIGNED	SWH	RECORD DWG	DATE	12/10/87	BY	SWH
DRAWN	RM	REV. SUCTION PIPING	DATE	3/27/87	BY	SWH
CHECKED		REV. ELEC SERVICE & WATER MAIN RESP.	DATE	3/17/87	BY	SWH
APPROVED		REV. PER OWNER COMMENTS	DATE	5/5/86	BY	RSM
SUBMITTED			DATE		BY	APP.

ROANOKE CITY-SALEM INTERCONNECT PUMPING STATION	
SITE PLAN	

SCALE: NOTED	COMM NO. 566
DATE: JUNE 86	SHEET 3

RECORD DRAWING

Mattern & Craig
CONSULTING ENGINEERS