



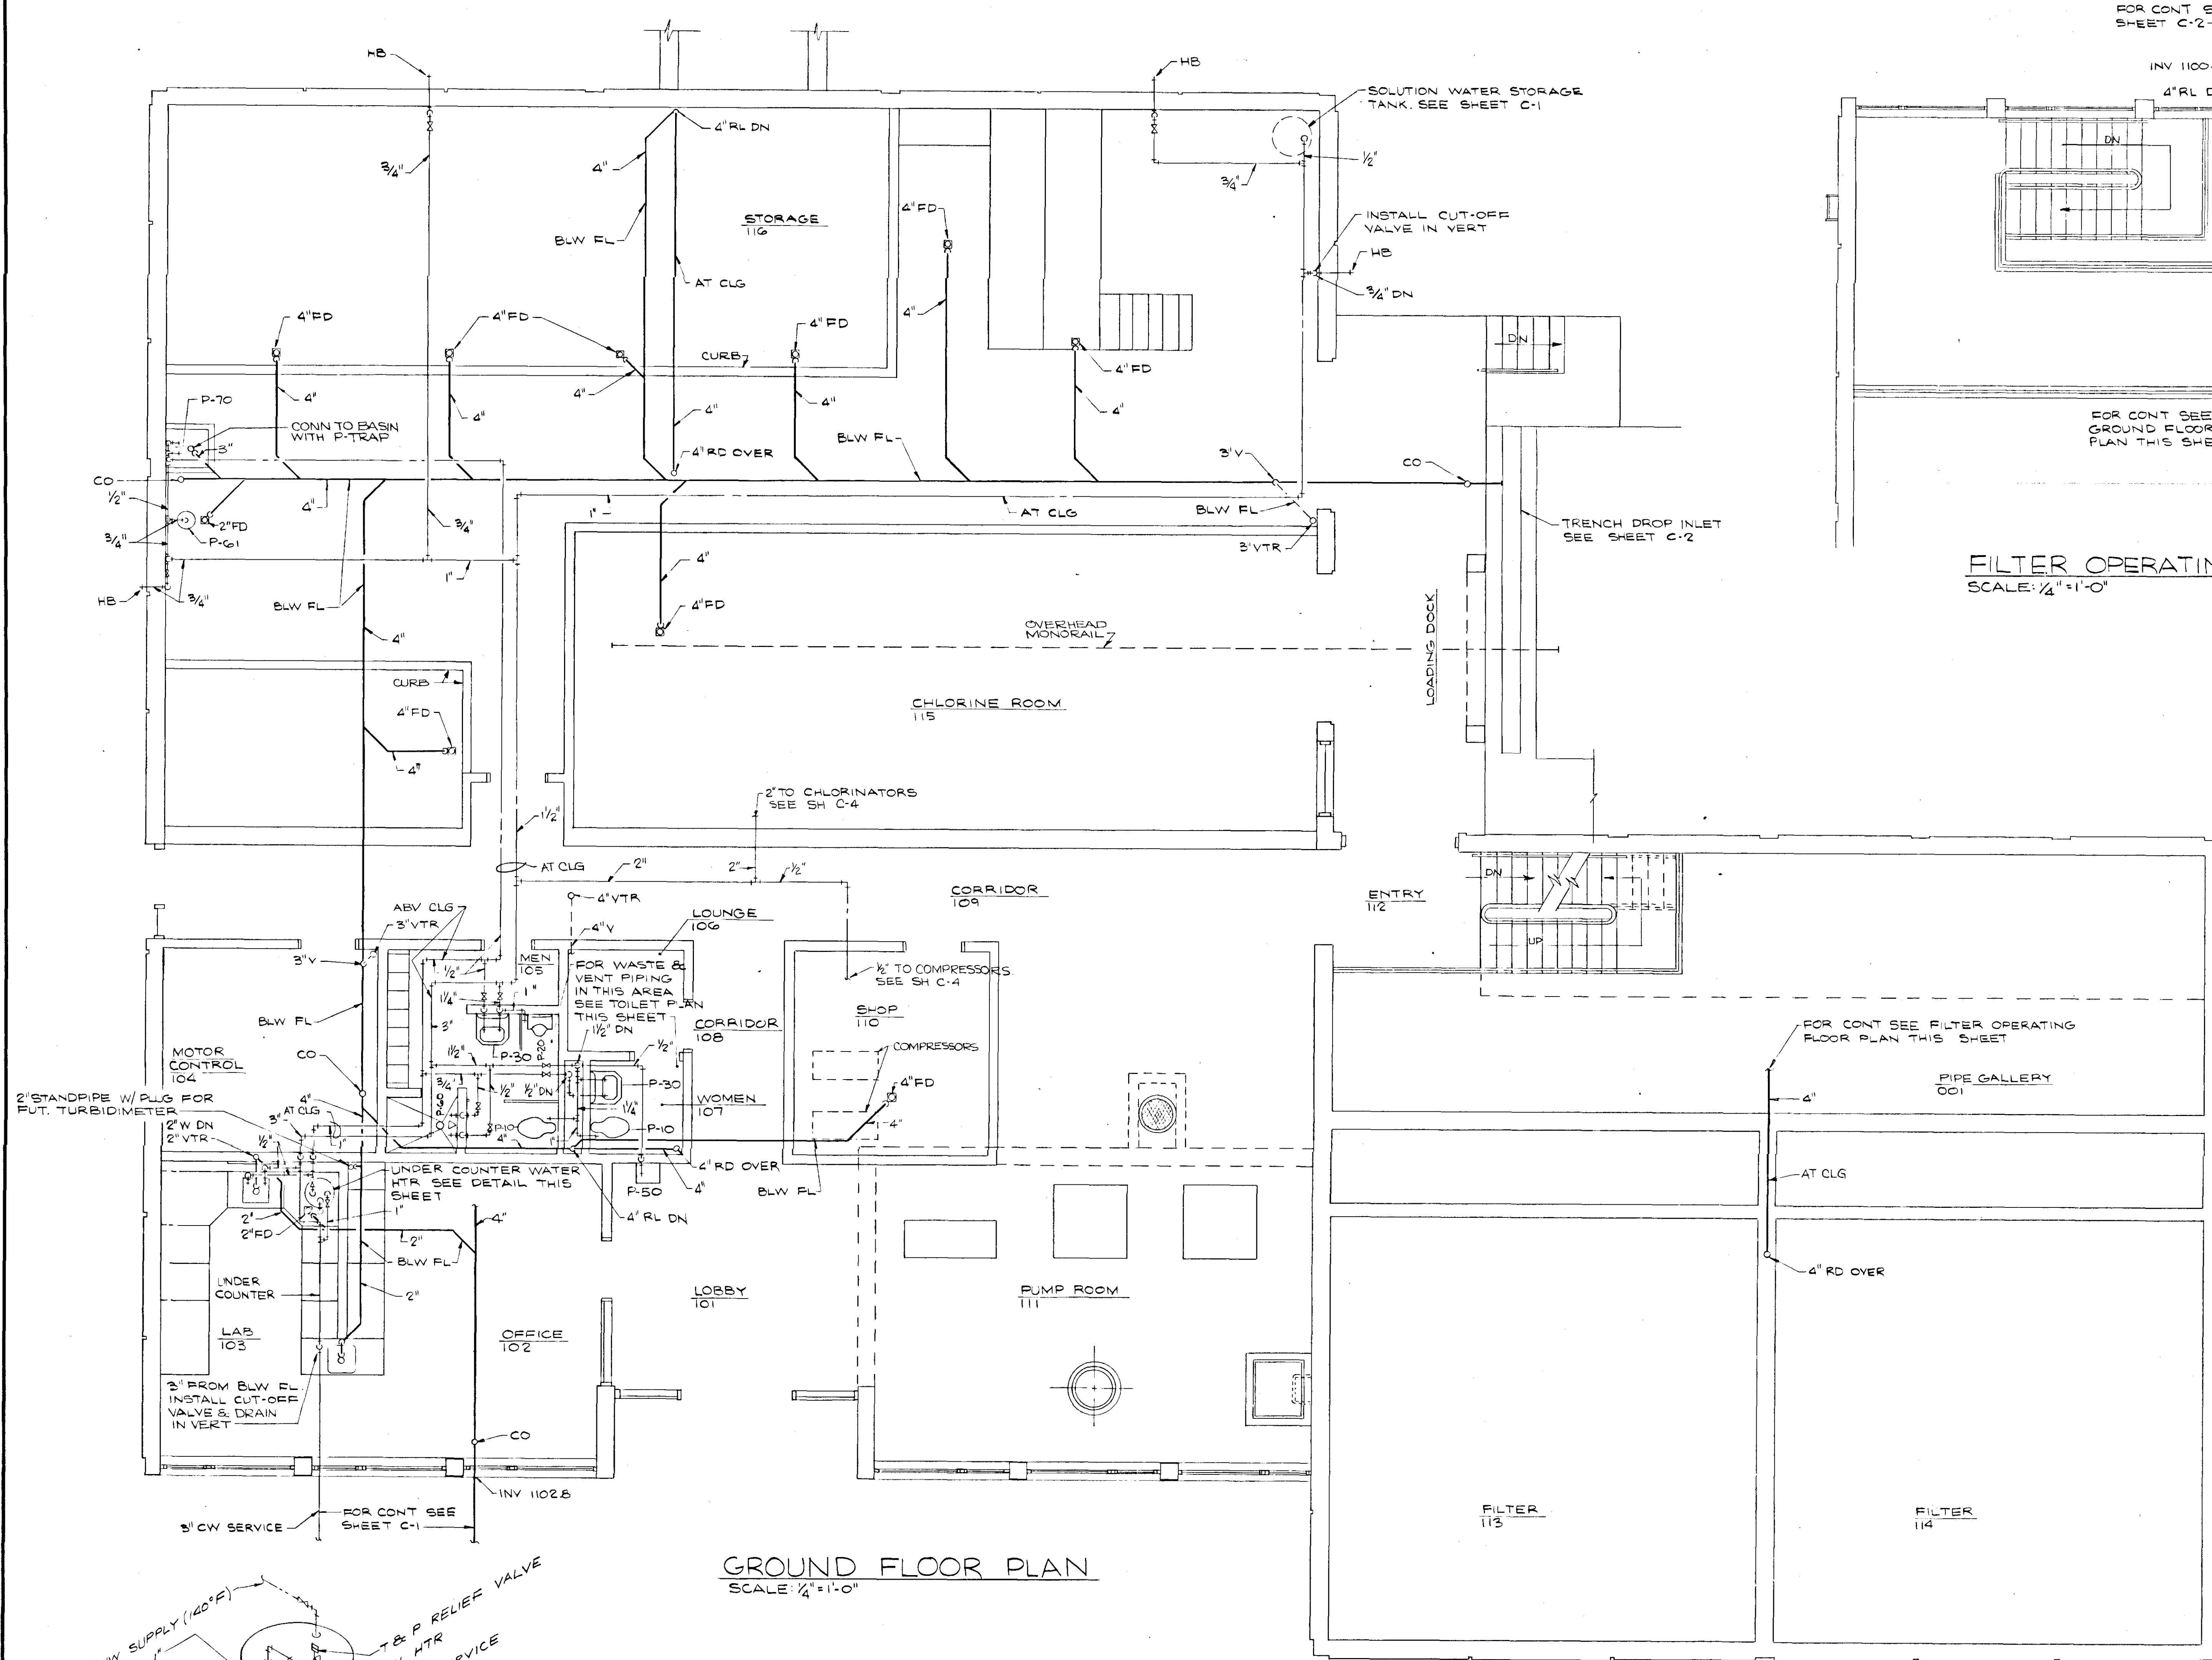


GROUND FLOOR PLAN
SCALE: 1/4" = 1'-0"

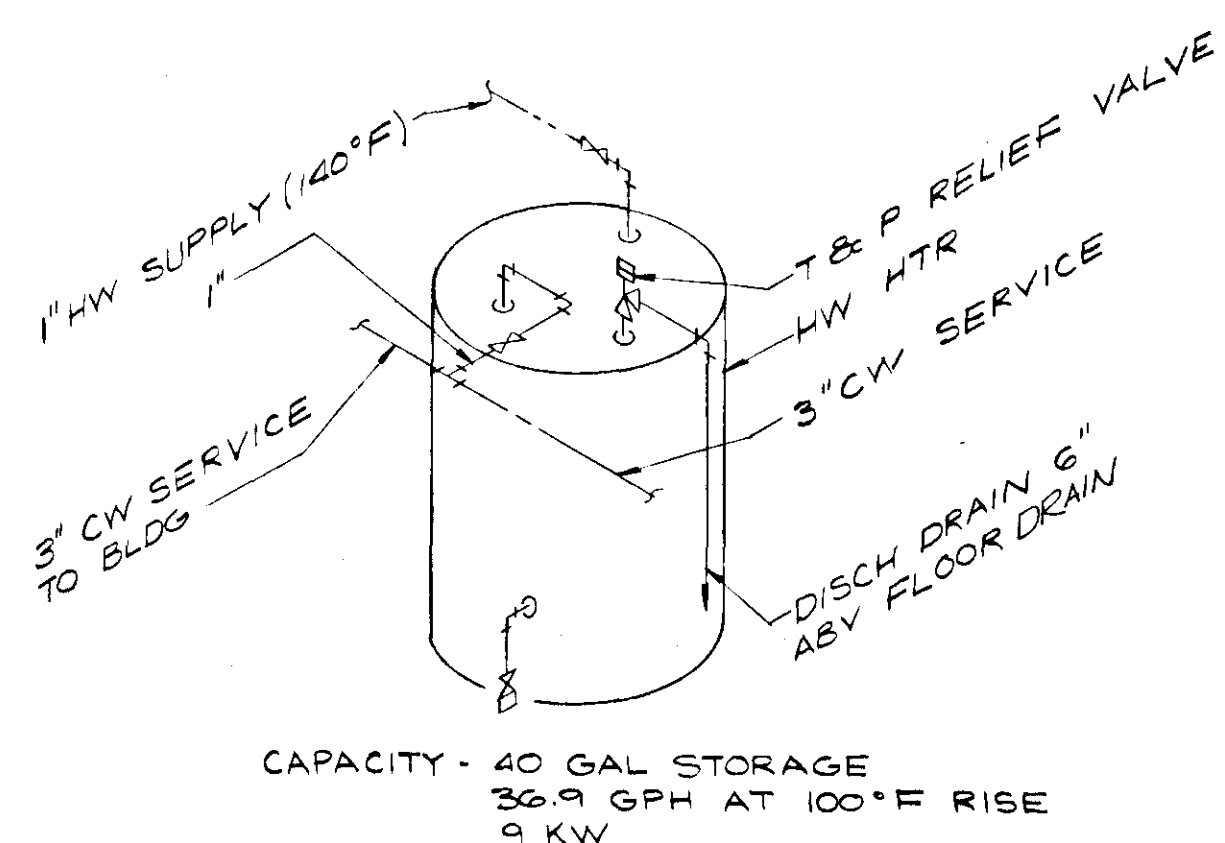


DETAIL - HW HEATER
NO SCALE

FIXTURE SCHEDULE							
FIXTURE	MARK	MTG HGT	CW	HW	TRAP	VENT	
WATER CLOSET	P-10	15"	1"	-	-	2"	
URINAL	P-20	24"	1"	-	-	1 1/2"	
LAVATORY	P-30	31"	1/2"	1/2"	1 1/4"	1 1/4"	
ELECT WATER COOLER	P-50	42"	1/2"	-	1 1/2"	1 1/4"	
SHOWER	P-60	72"	1/2"	1/2"	SEE PLAN	-	
EMERGENCY SHOWER	P-61	84"	1/2"	-	-	-	
MIXING VALVE	P-70	-	1/2"	1/2"	-	-	


FIXTURE SCHEDULE NOTES:
1. SIZES GIVEN ABOVE ARE FOR ONE FIXTURE ONLY.
ANY EXCEPTIONS ARE SHOWN ON PLANS.
2. MOUNTING HEIGHTS GIVEN ARE TO FLOOD LEVEL
RIM OF FIXTURES.

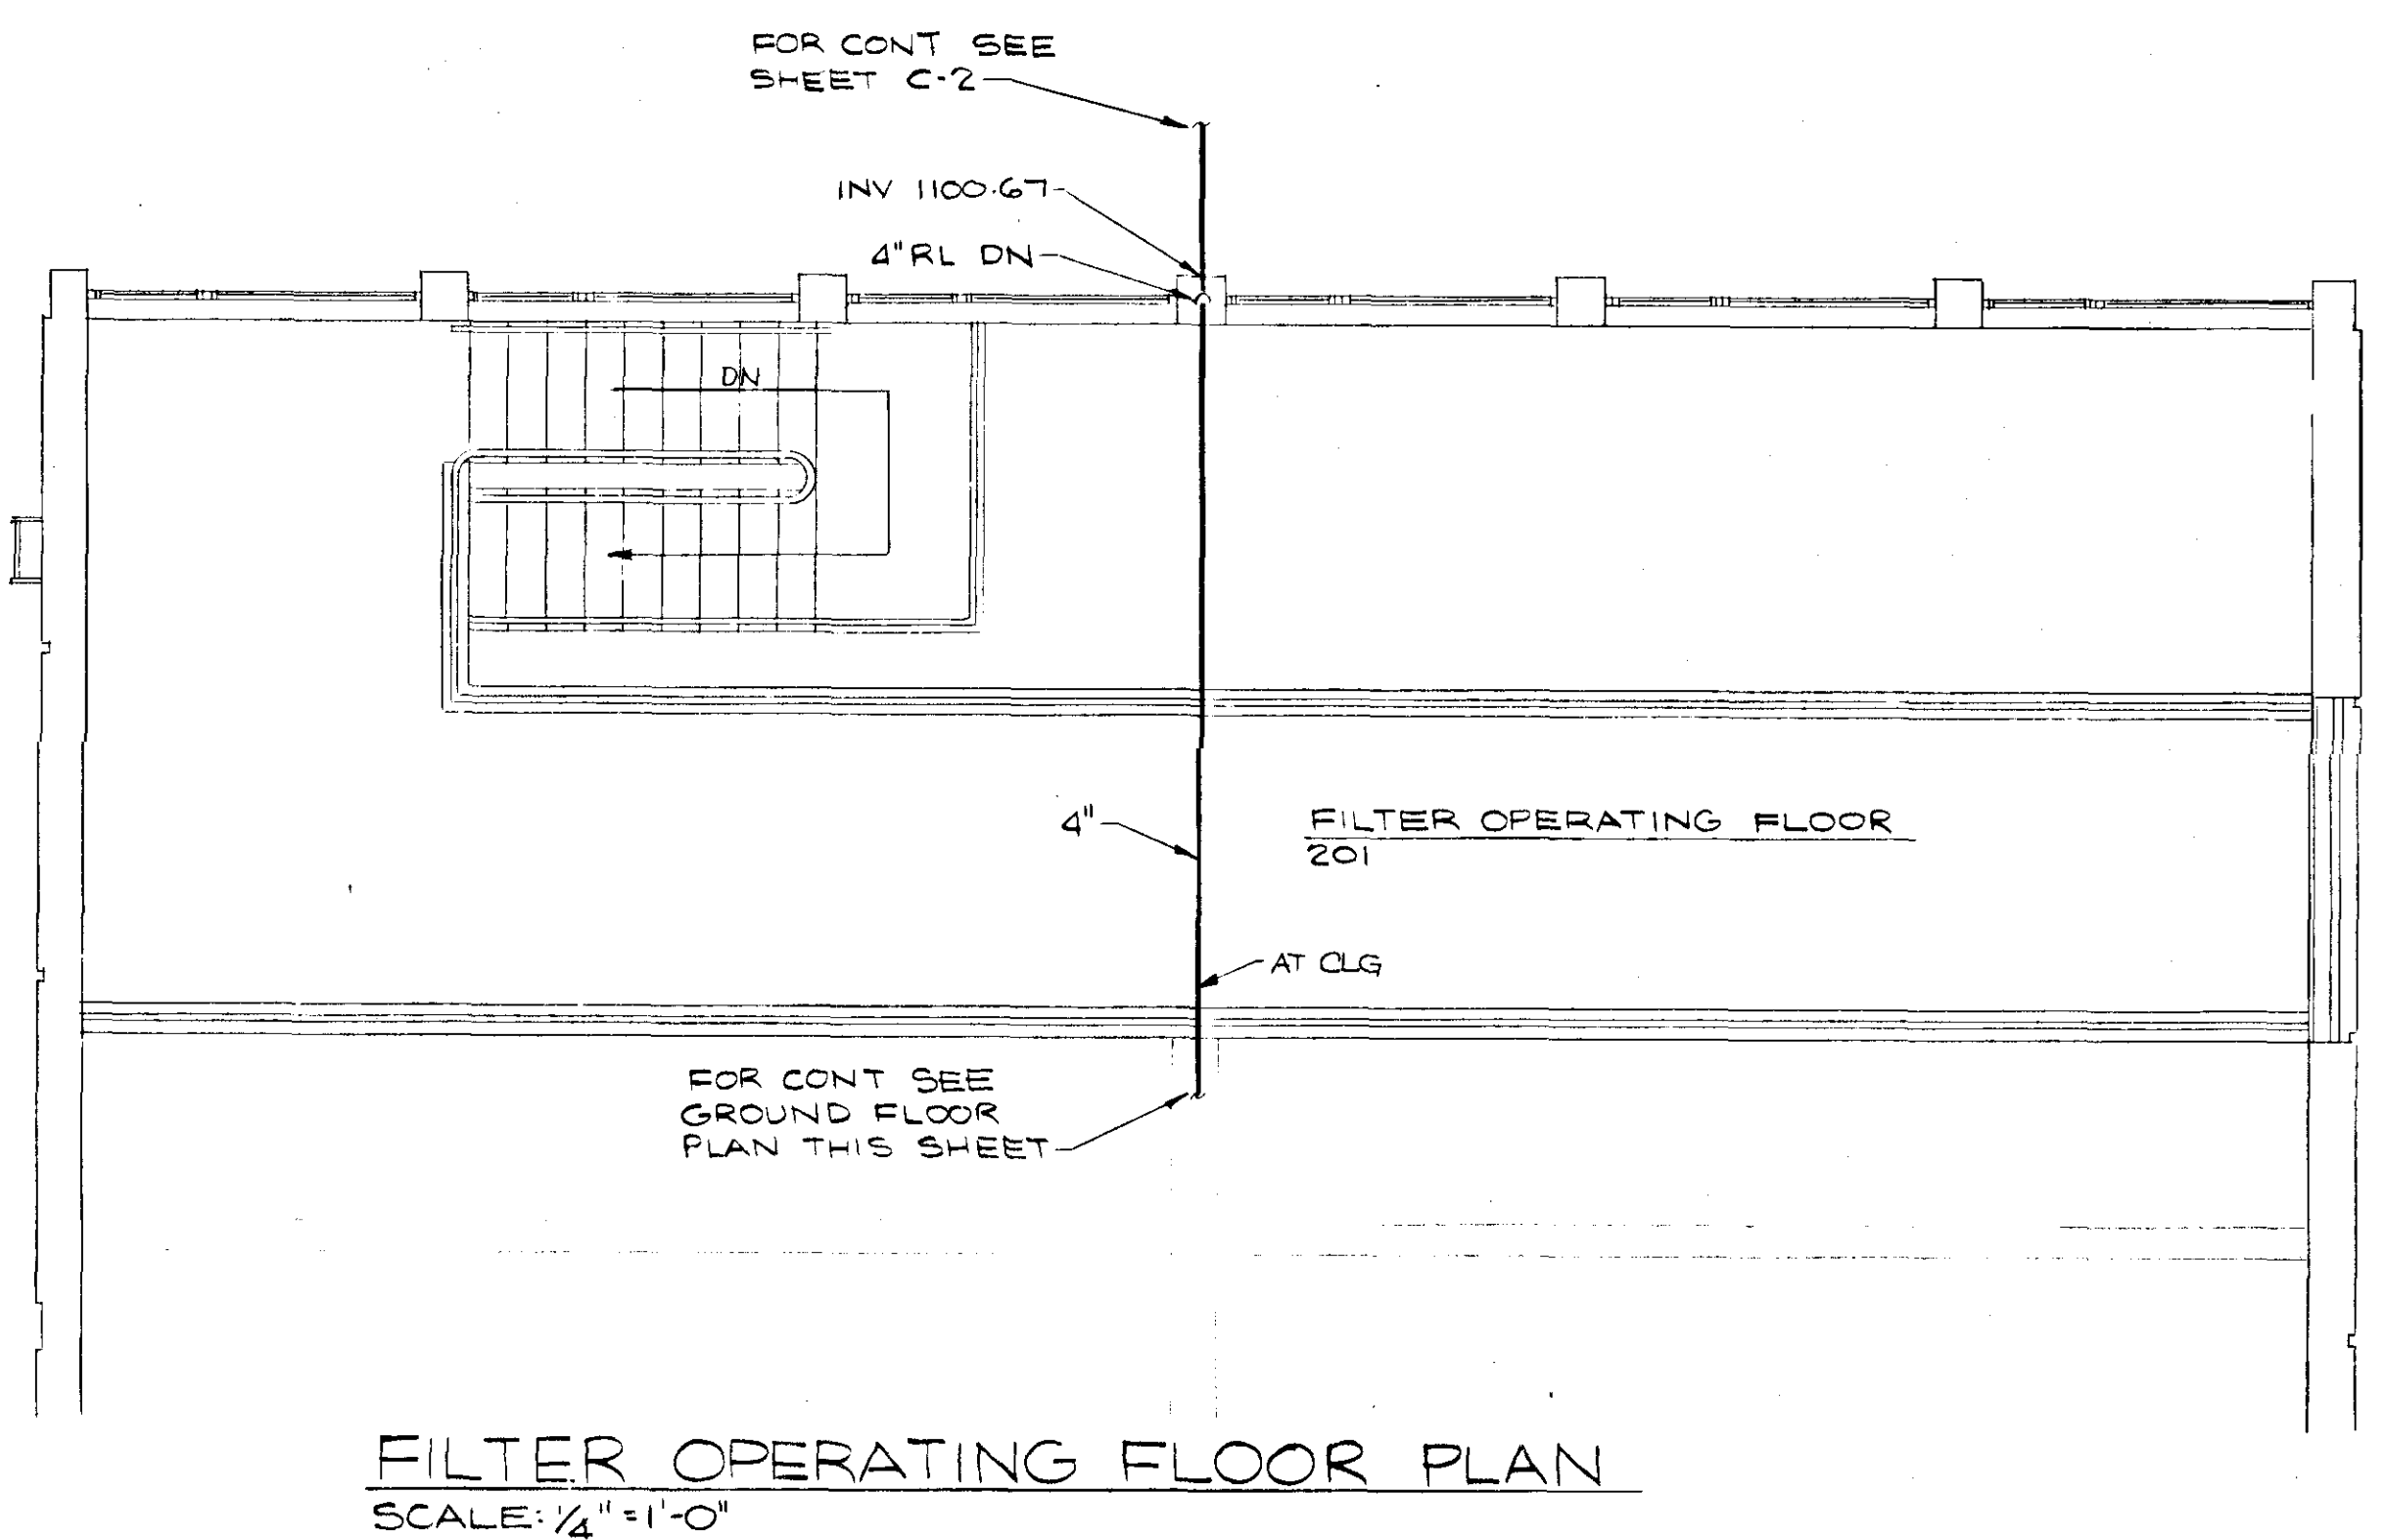

FILTER OPERATING FLOOR PLAN
SCALE: 1/4" = 1'-0"

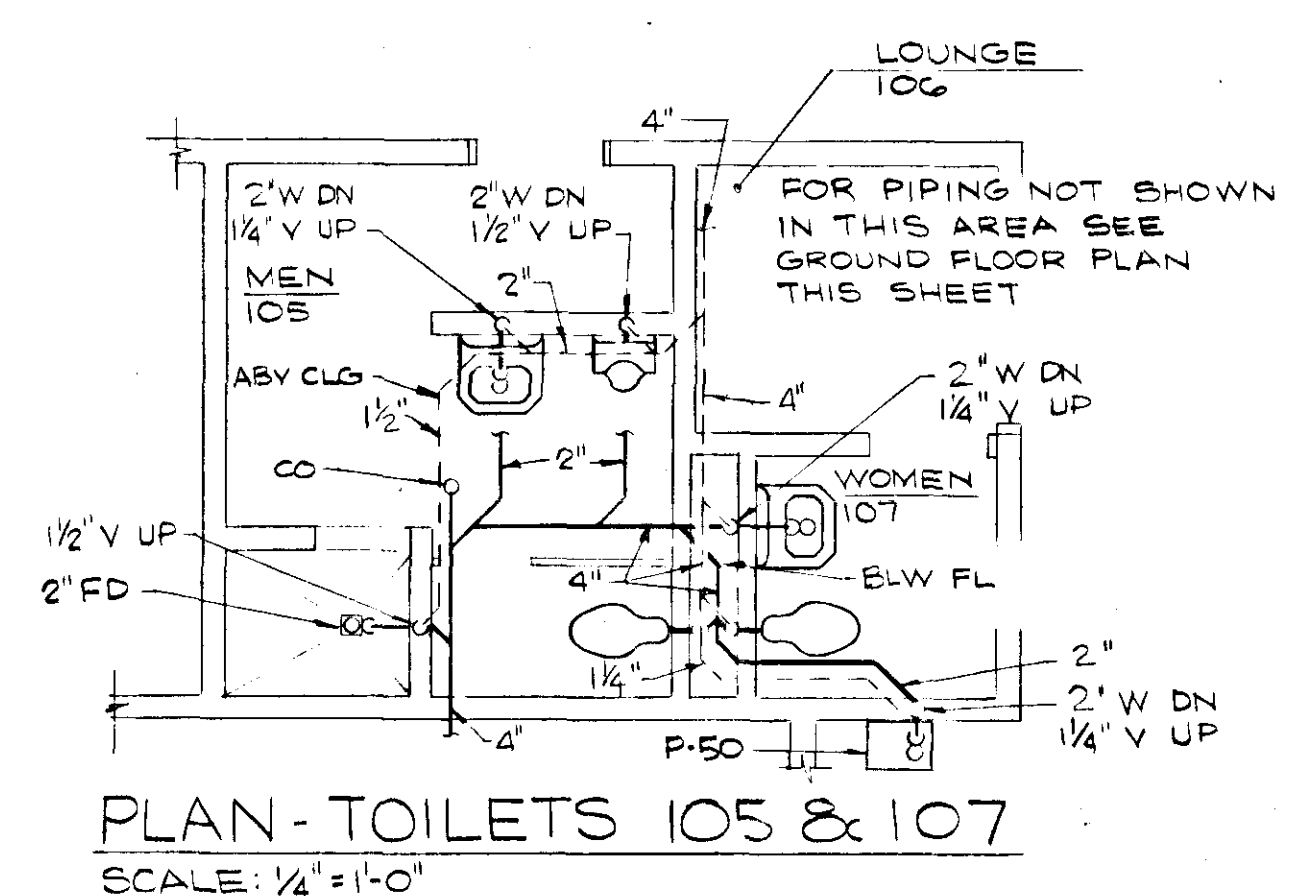

PLAN - TOILETS 105 & 107
SCALE: 1/4" = 1'-0"

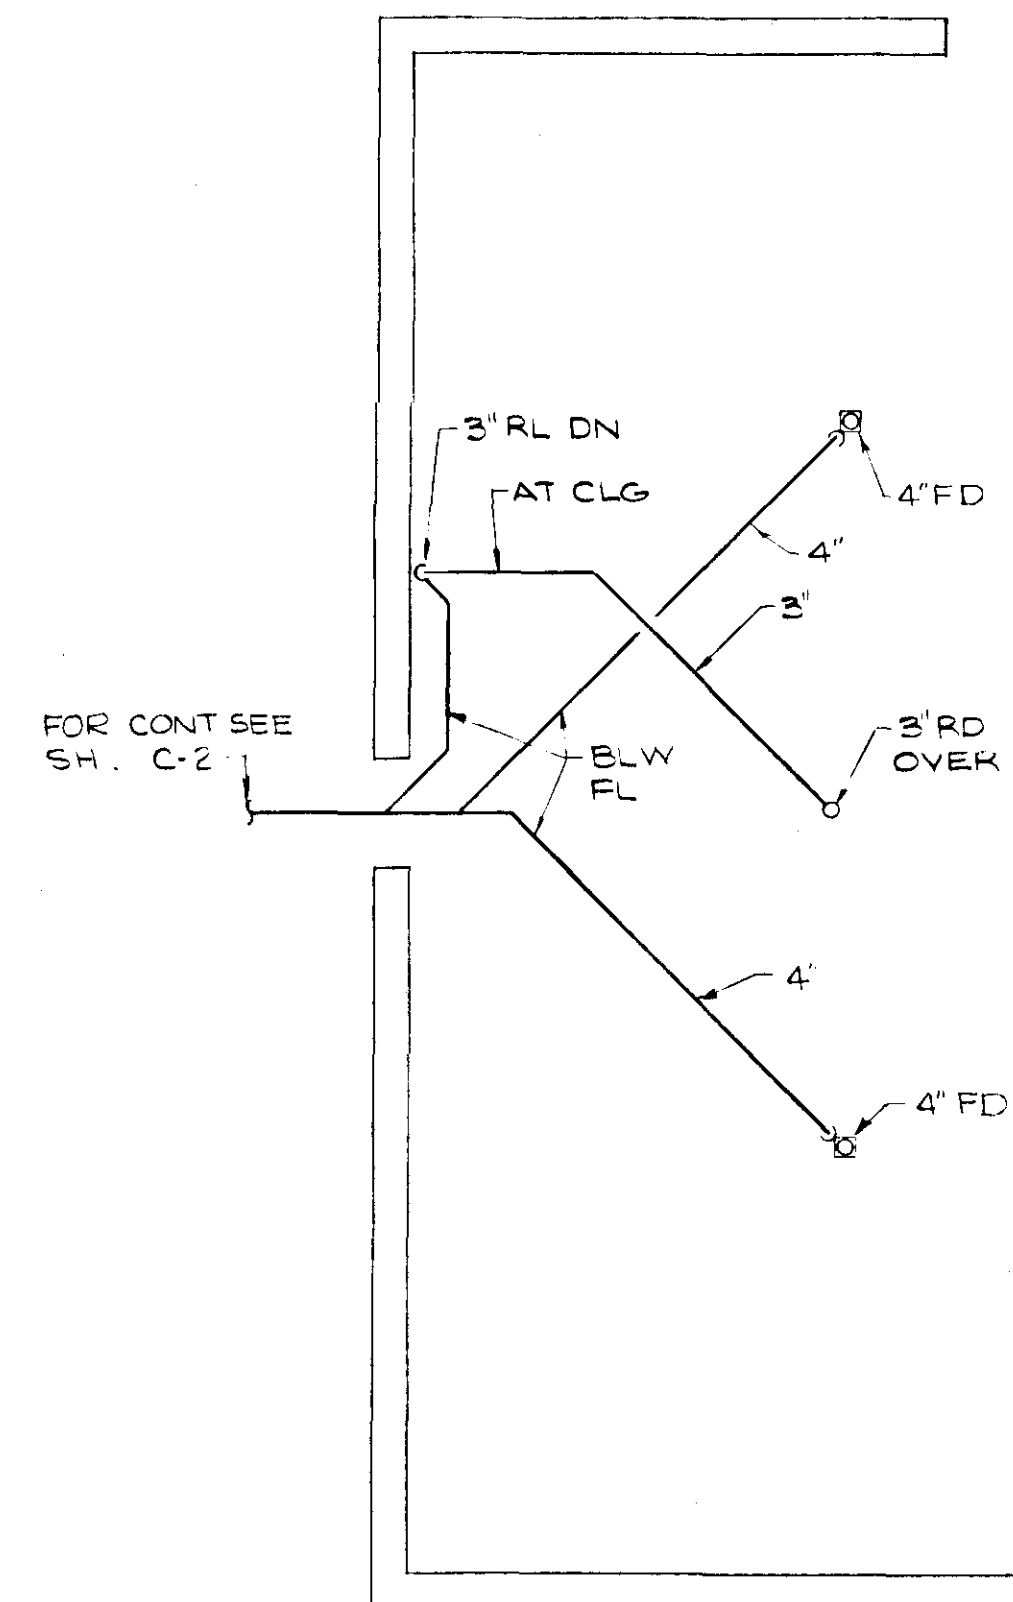

SERVICE PUMPING STATION PLAN
SCALE: 3/16" = 1'-0"

DESIGNED	DATE	DESCRIPTION	BY	APP
DRAWN		WATER FILTRATION PLANT		
CHECKED		CITY OF SALEM, VIRGINIA		
APPROVED		PLUMBING		
SUBMITTED		FLOOR PLANS		
HAYES, SEAY, MATTERN & MATTERN ARCHITECTS-ENGINEERS		SCALE AS NOTED	COMM. NO. 3627-A	
ROANOKE, VIRGINIA		DATE APRIL 1970	SHEET P-1	